


SHEET NOTES

Portland International
Jetport
1001 Westbrook Street
Portland, Maine 04102

Gensler
2024 N Street, NW
Suite 200
Washington, DC 20006
Telephone 202.221.5200
Facsimile 202.221.5207

oast ASSOCIATES, INC.
3405 Georgetown Road, Suite 100, Georgetown, MA 01037
Telephone 413.537.7700
Facsimile 413.537.7701
oast.com
engineers • architects • planners • construction managers

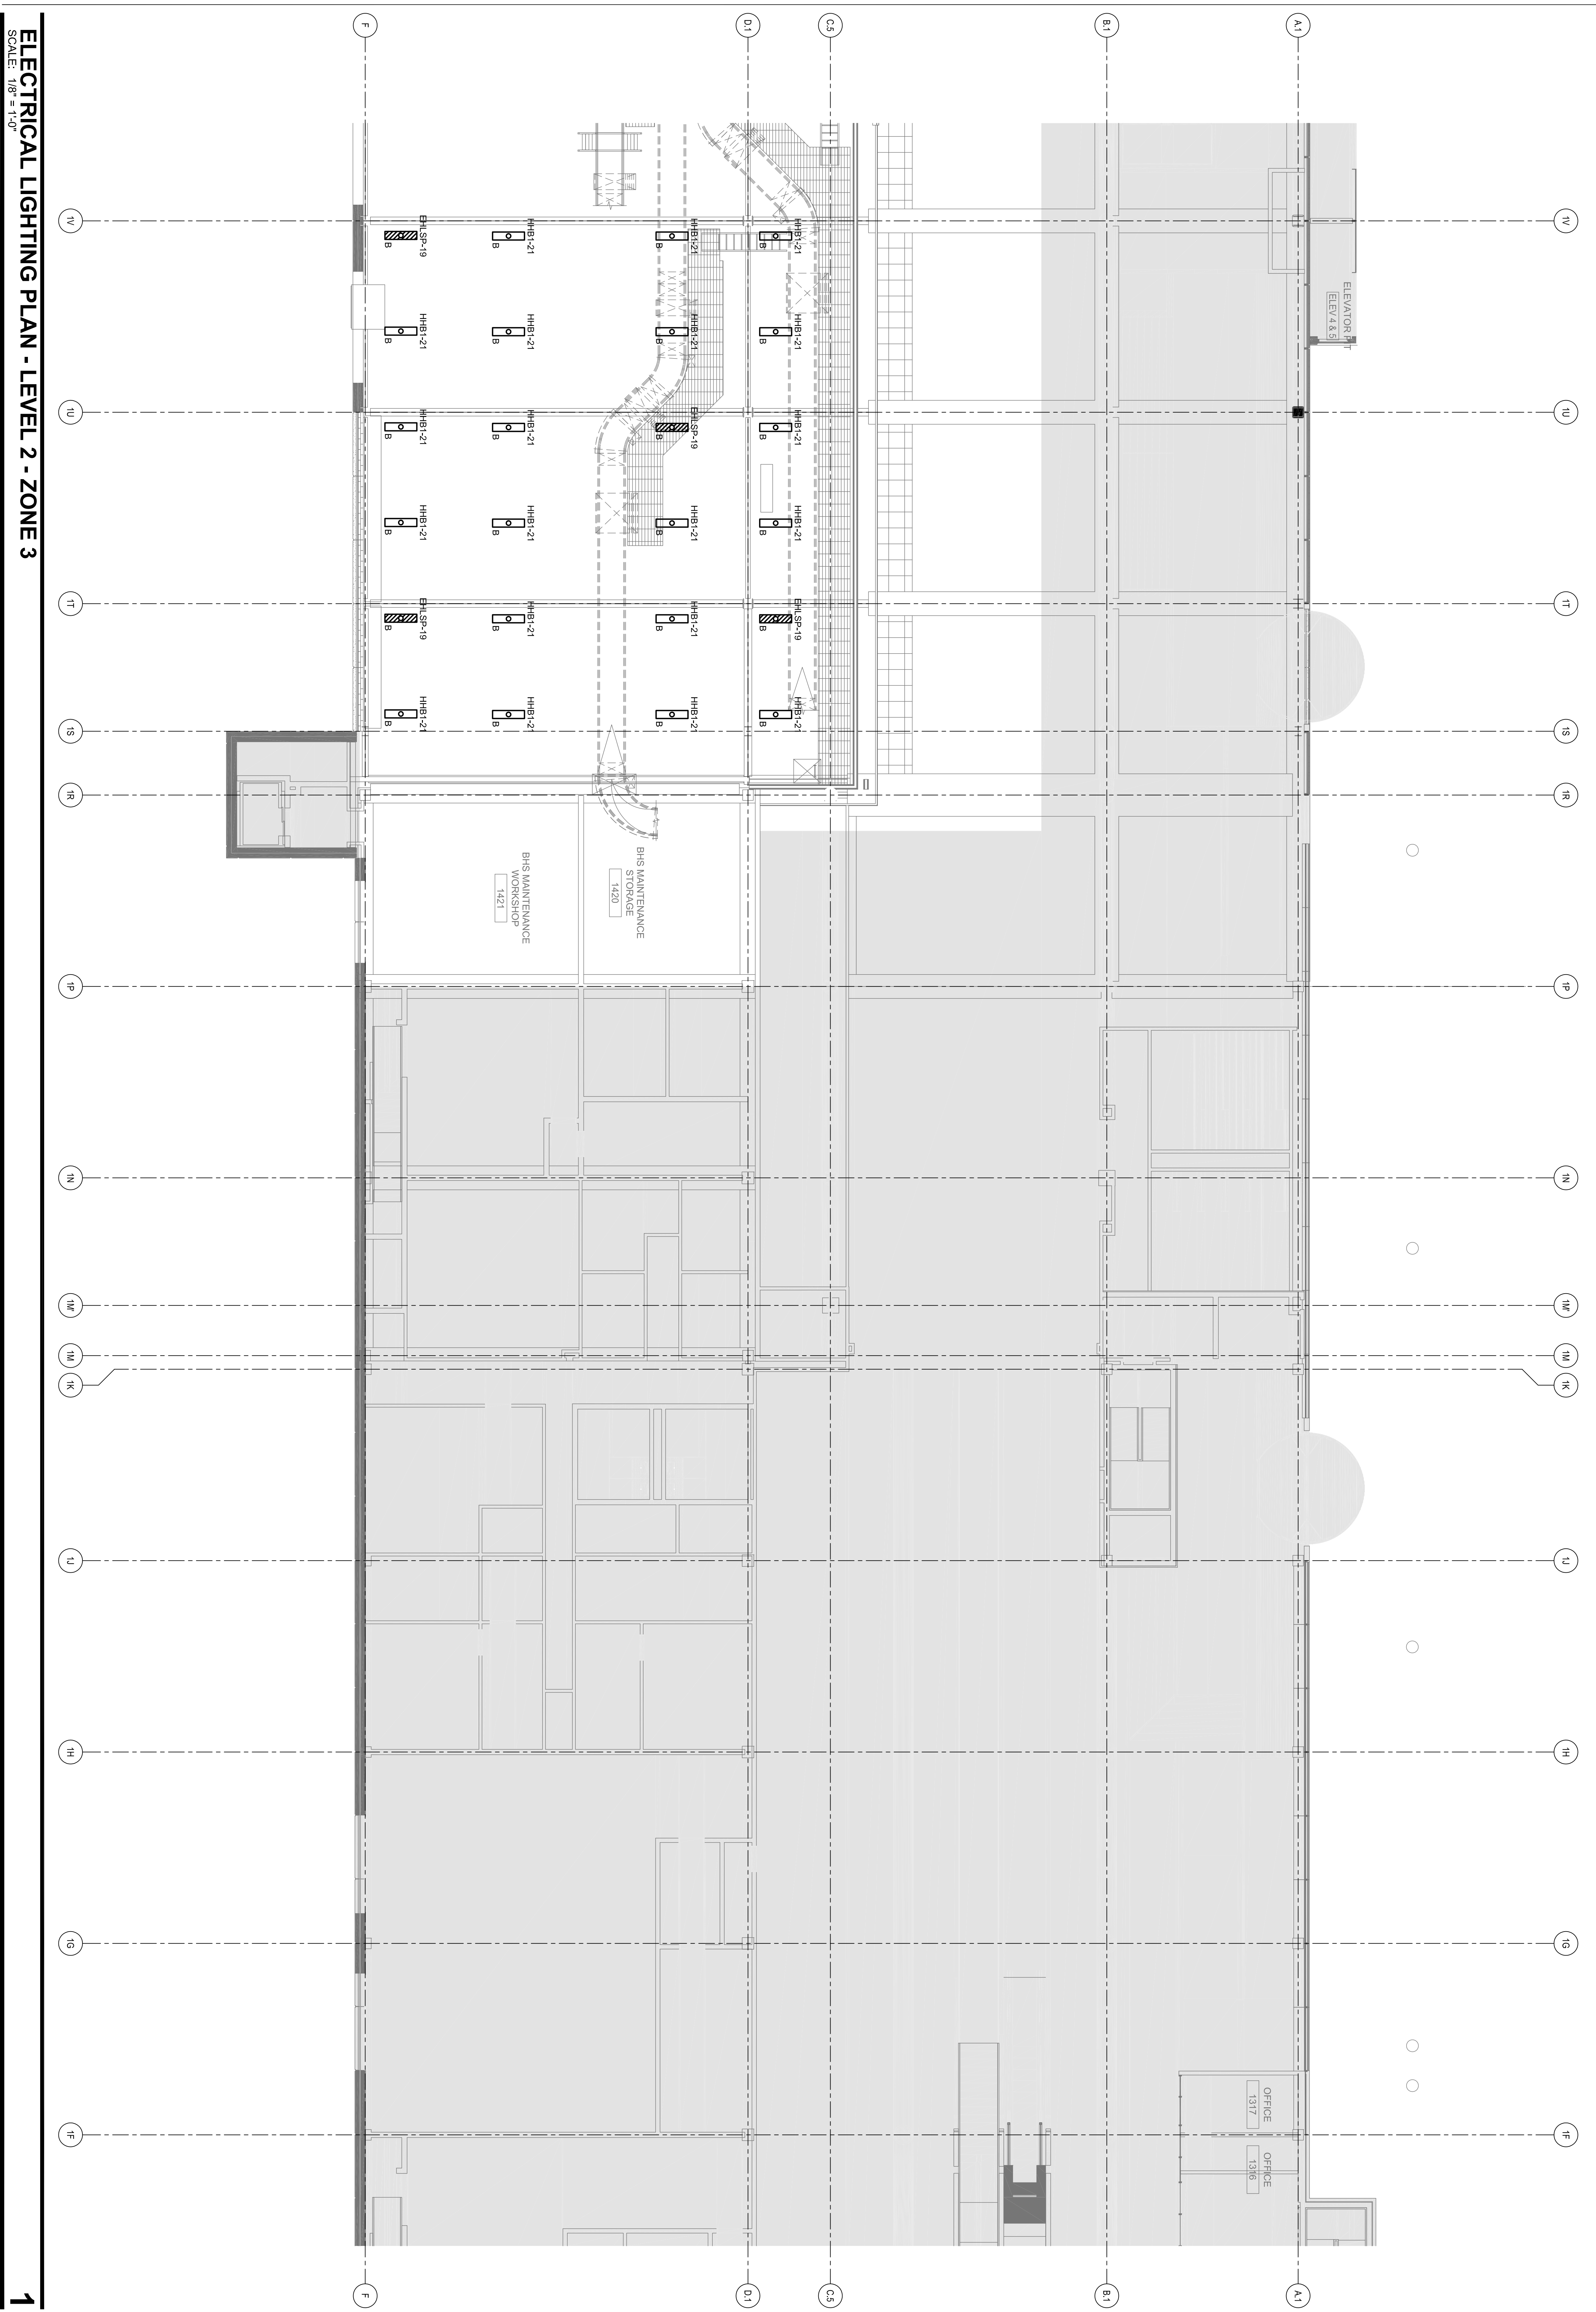


GENERAL NOTES

A SEE SHEET E00.00 FOR LEGEND AND GENERAL NOTES.

△	Issue	Date & Issue Description	By	Checked
01	09/22/03	PERMITTING/REVISION	LAM	BHG
02	12/03/03	ENGINEERING	LAM	BHG
03	07/23/09	75% CONSTRUCTION DOCUMENTS	LAM	BHG
04	10/26/09	90% CONSTRUCTION DOCUMENTS	LAM	BHG
		ISSUED FOR PERMIT	LAM	BHG

KEY PLAN

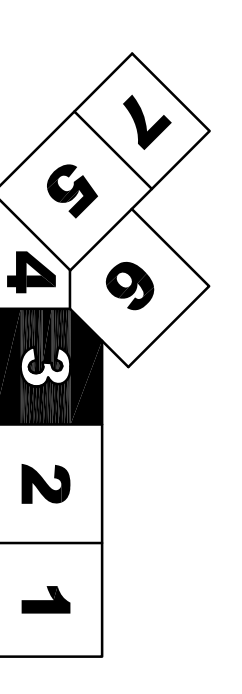

Project Name: PMA Terminal Enhancement
 Labelled Number: E04.02.03
 Date: 07/23/09
 Description: ELECTRICAL LIGHTING PLAN - LEVEL 2 - ZONE 3
 Scale: 1/8" = 1'-0"
 Ref: North
E04.02.03
 ©2009 Gensler