

SHEET NOTES

Portland International


Jetport

1001 Westbrook Street
Portland, Maine 04102

Gensler

2001 N Street, NW
Suite 200
Washington, DC 20006
Telephone 202.221.5200
Facsimile 202.972.5297

oast ASSOCIATES, INC.
360 Greenway Drive, Portland, ME 04103
Tel: 207.741.1100 Fax: 207.741.1104
engineers • architects • planners • construction managers

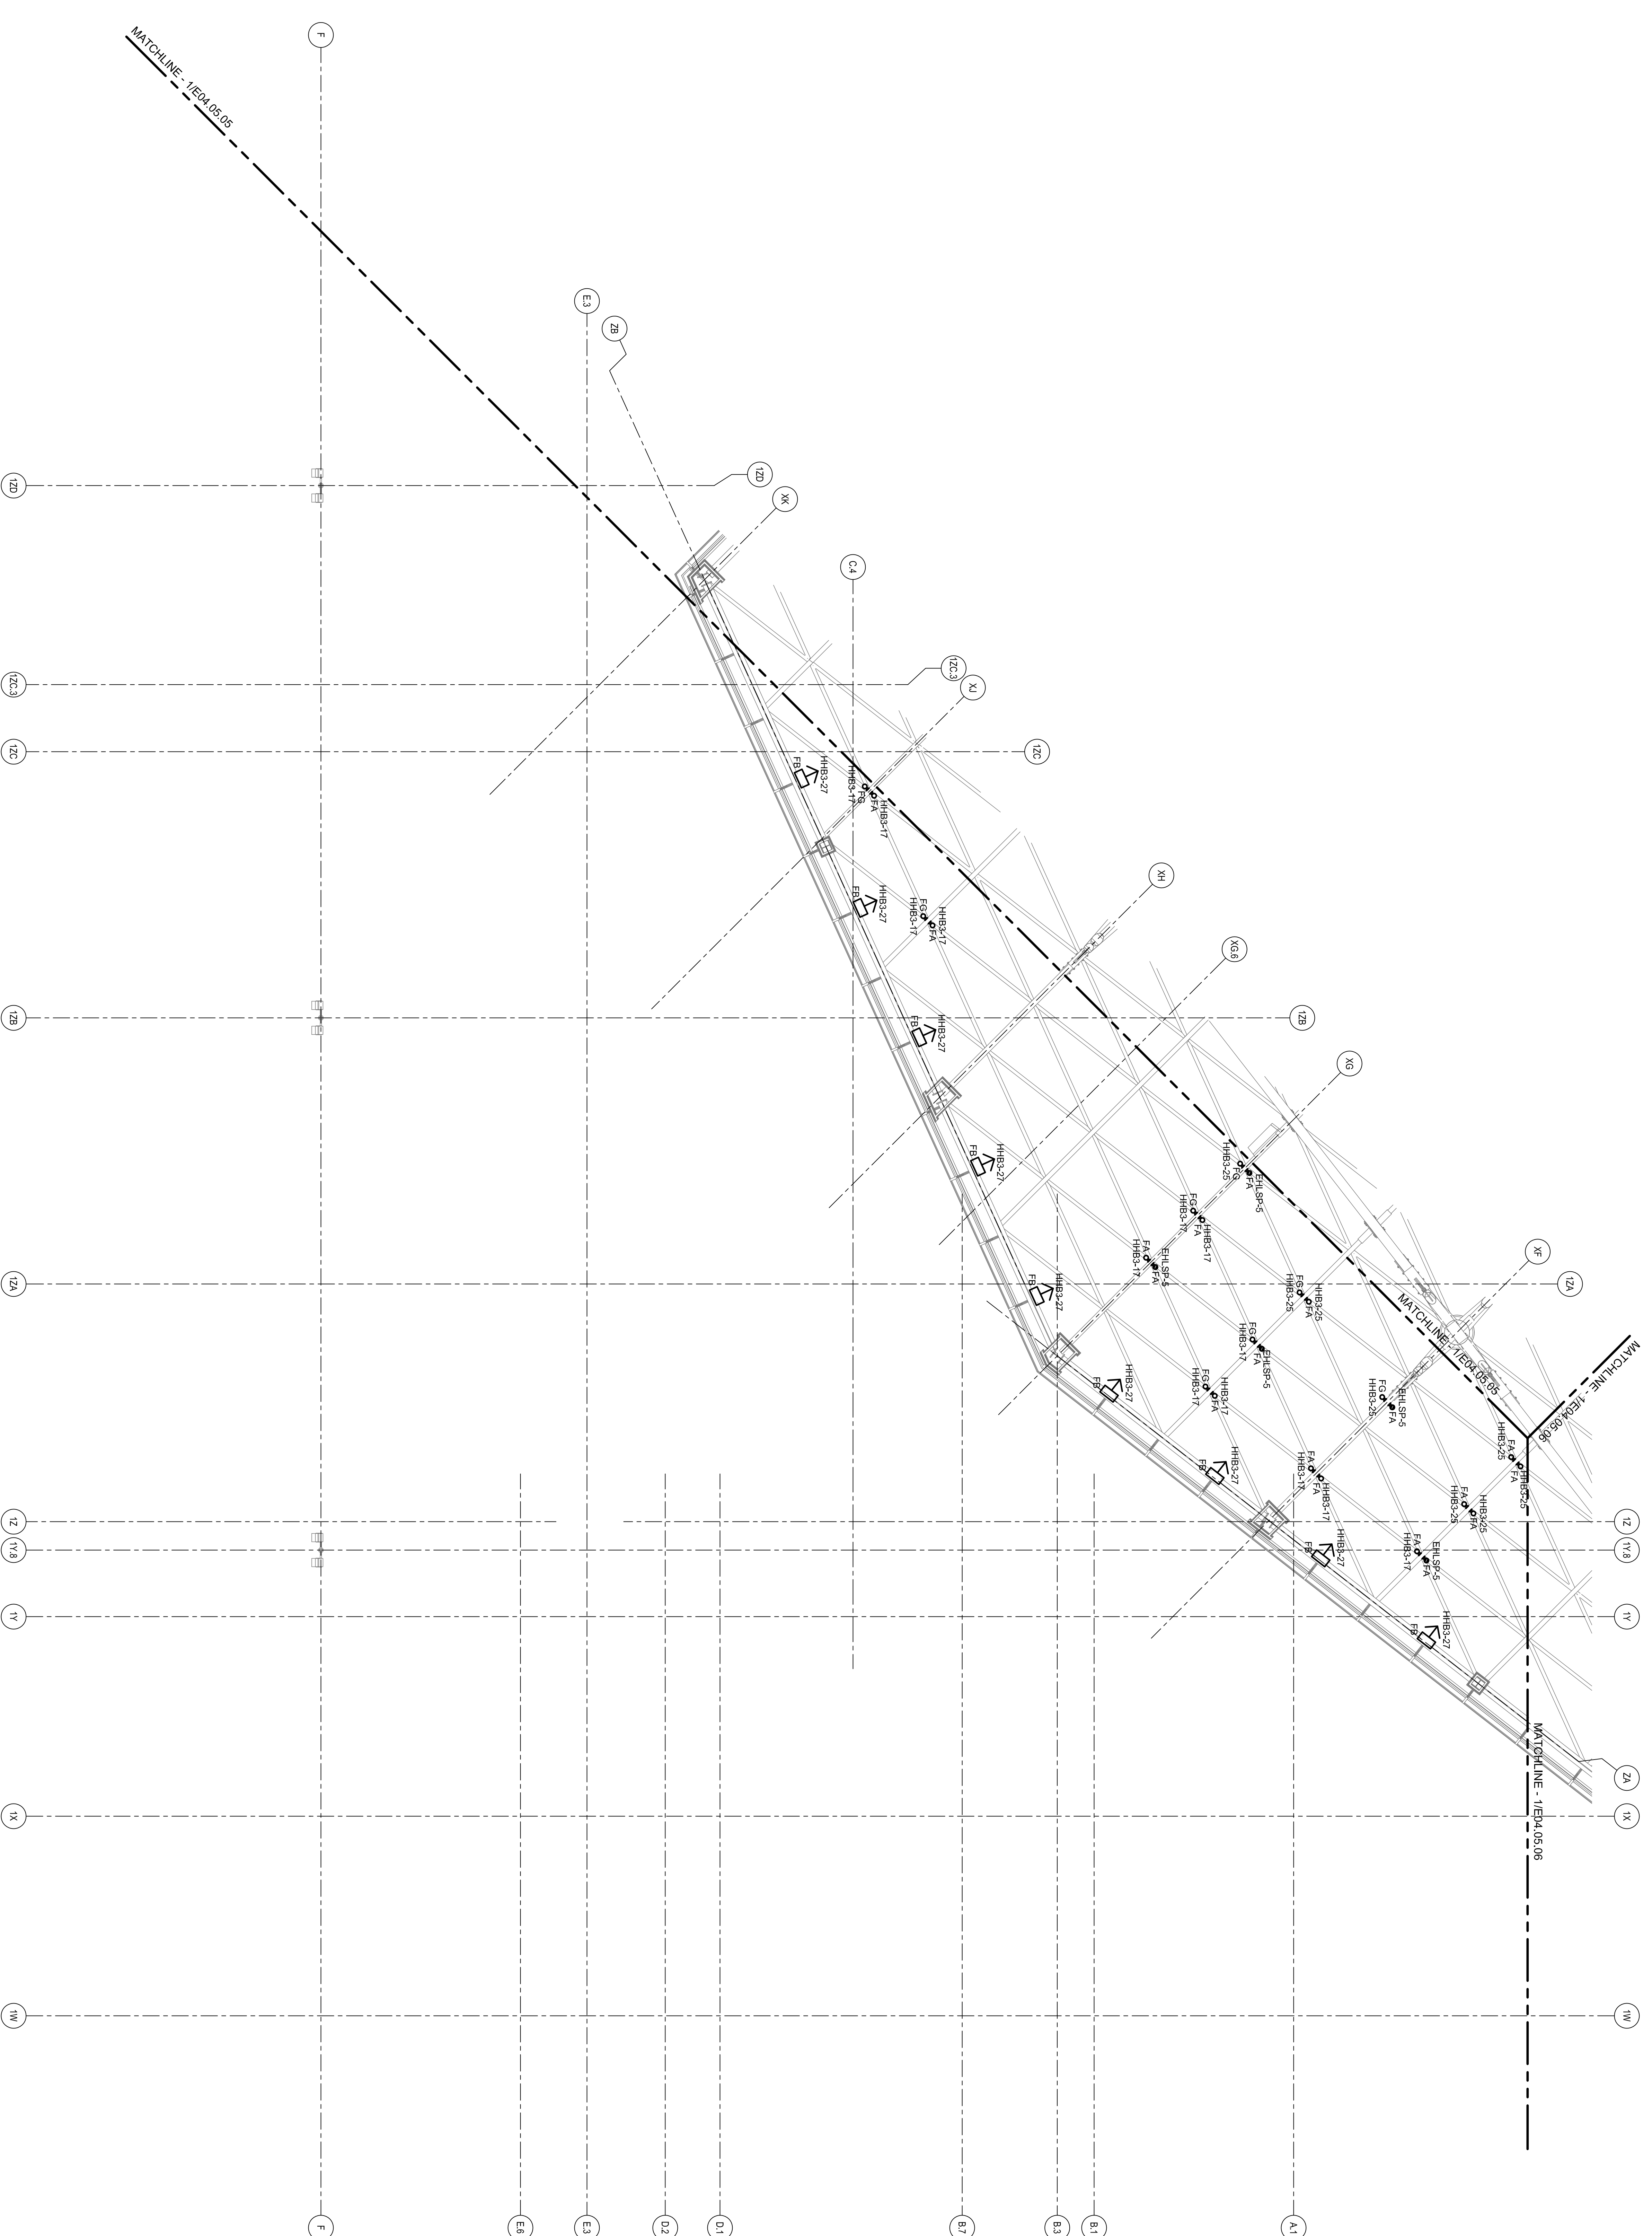


ELECTRICAL LIGHTING PLAN - LEVEL 5-ZONE 4

SCALE: 1/8" = 1'-0"

GENERAL NOTES

A SEE SHEET E04.00 FOR LEGEND AND GENERAL NOTES.

KEY PLAN

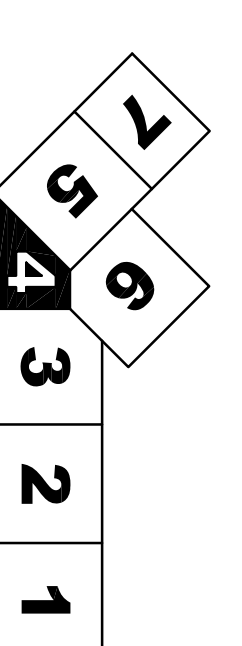

Issue	Date & Issue Description	By	Checked
01	08/22/08	LAM	BHG
02	12/03/08	LAM	BHG
03	01/23/09	LAM	BHG
04	10/26/09	LAM	BHG
	ISSUED FOR PERMIT		

Project Name: PML Terminal Enhancement
 Project Number: E04.05.04
 Date: 05/06/09
 Designer: TJS/SJO/101/Sheena.E04.05.04.dwg
 Description: ELECTRICAL LIGHTING PLAN - LEVEL 5 - ZONE 4
 Scale: 1/8" = 1'-0"
 Ref: North

E04.05.04

©2009 Gensler