


SHEET NOTES

**Portland International
Jetport**
1001 Westbrook Street
Portland, Maine 04102

Gensler
2001 K Street, NW
Suite 200
Washington, DC 20006
Telephone 202.221.5200
Facsimile 202.221.5297

oast ASSOCIATES, INC.
340 Commonwealth Street, 10th Floor, Boston, MA 02116
Engineers • Architects • Surveyors • Construction Managers

KEY PLAN

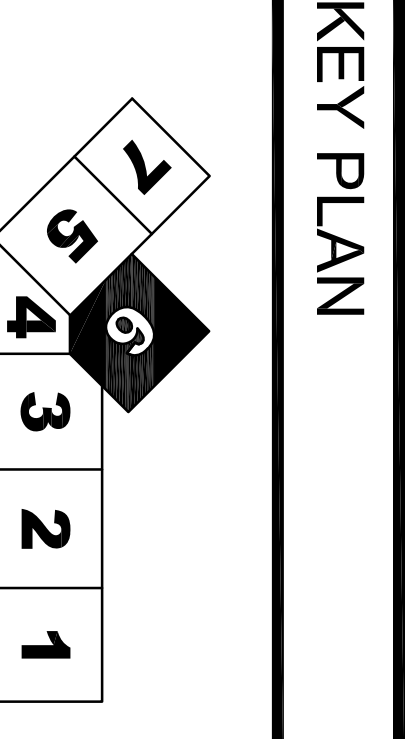


E04.05.06
1/8" = 1'-0"
Ref. North

GENERAL NOTES

- A SEE SHEET E00.00 FOR LEGEND AND GENERAL NOTES.

Rev	Date & Issue Description	By	Check
01	09/22/03	LAM	BHG
02	12/03/03	LAM	BHG
03	07/23/05	LAM	BHG
04	10/26/05	LAM	BHG

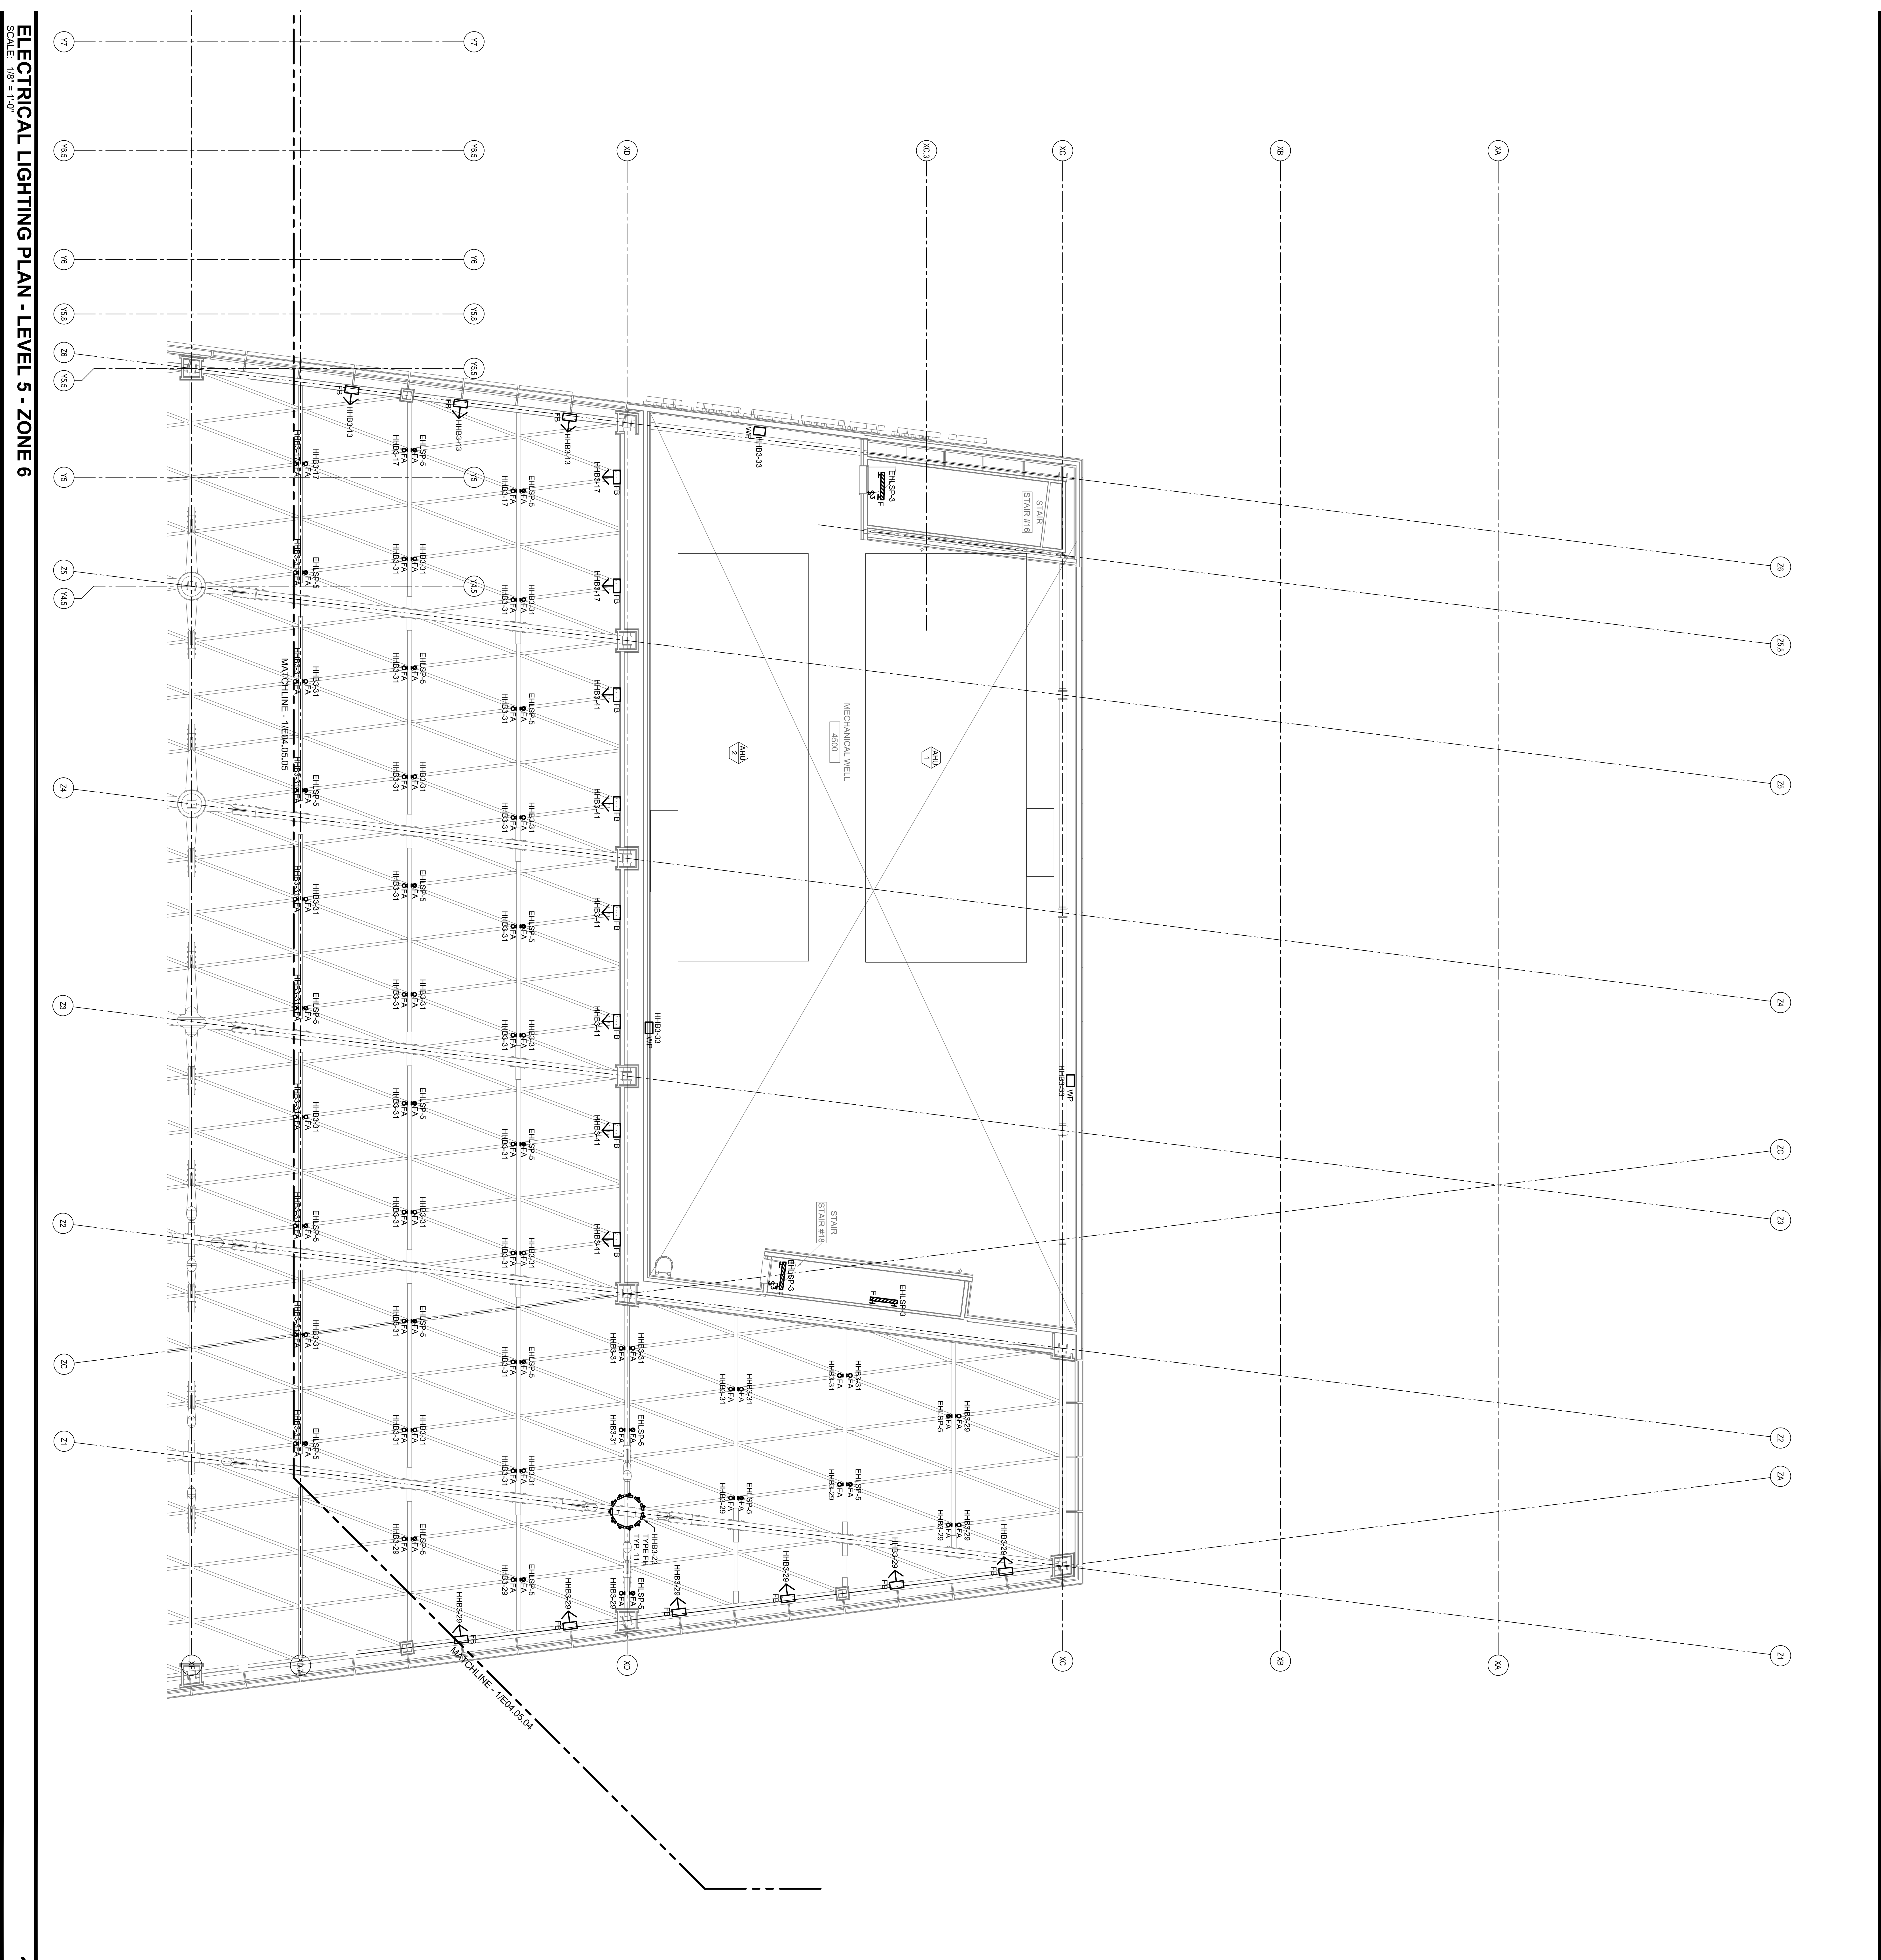

ELECTRICAL LIGHTING PLAN - LEVEL 5 - ZONE 6
SCALE: 1/8" = 1'-0"