

**SHEET NOTES**

**Portland International Jetport**  
 1001 Westbrook Street  
 Portland, Maine 04102

**Gensler**  
 2020 K Street, NW  
 Suite 200  
 Washington, DC 20006  
 Telephone 202.721.5200  
 Facsimile 202.872.8587

**oest ASSOCIATES, INC.**  
 343 Gorton Road South Portland, ME 04106  
 Phone 207.465.9100  
 Fax 207.465.9101  
 www.oest.com  
 engineers • architects • surveyors • construction managers



**FIRE RISK MANAGEMENT, INC.**  
 1 First Street  
 South Portland, ME 04106  
 Phone 207.462.7200  
 www.fire-risk.com

**GENERAL NOTES**

A SEE SHEET FP00.01 FOR LEGEND, SCHEDULES & GENERAL NOTES.

Issue	Date & Issue Description	By	Check
01	07/11/08	SKD	RHB
02	09/22/08	SKD	WMC
03	12/03/08	SKD	WMC
04	01/23/09	MHY	JLD
05	10/26/09	JLD	SKD

**KEY PLAN**

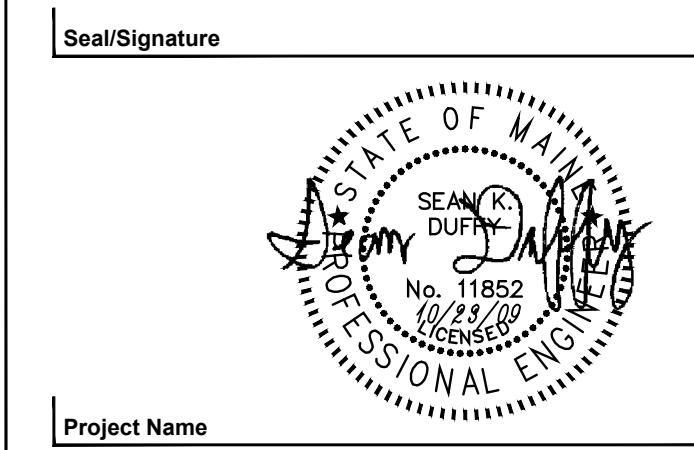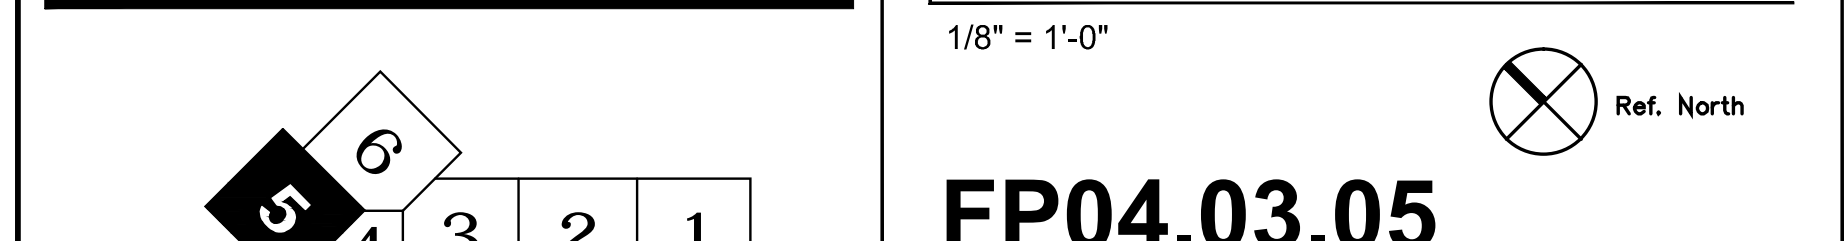

Project Name  
 PVM Terminal Expansion

Project Number  
 08.0395.000  
 CAD File Name  
 FP04.03.05.dwg  
 Description  
 FIRE PROTECTION PLAN - LEVEL 3 - ZONE 5

Scale  
 1/8" = 1'-0"

**FP04.03.05**