

SHEET NOTES


Portland International Jetport

1001 Westbrook Street
Portland, Maine 04102

Gensler
2020 K Street, NW
Suite 200
Washington, DC 20006
Telephone 202.721.5200
Facsimile 202.872.8587

oest ASSOCIATES, INC.
345 Gophers Road South Portland, ME 04106 P (207) 761-1770 F (207) 774-1242 www.oest.com
engineers • architects • surveyors • construction managers


FIRE RISK MANAGEMENT, INC.
1 Front Street
South Portland, ME 04106 P (207) 442-7200
www.fire-risk.com

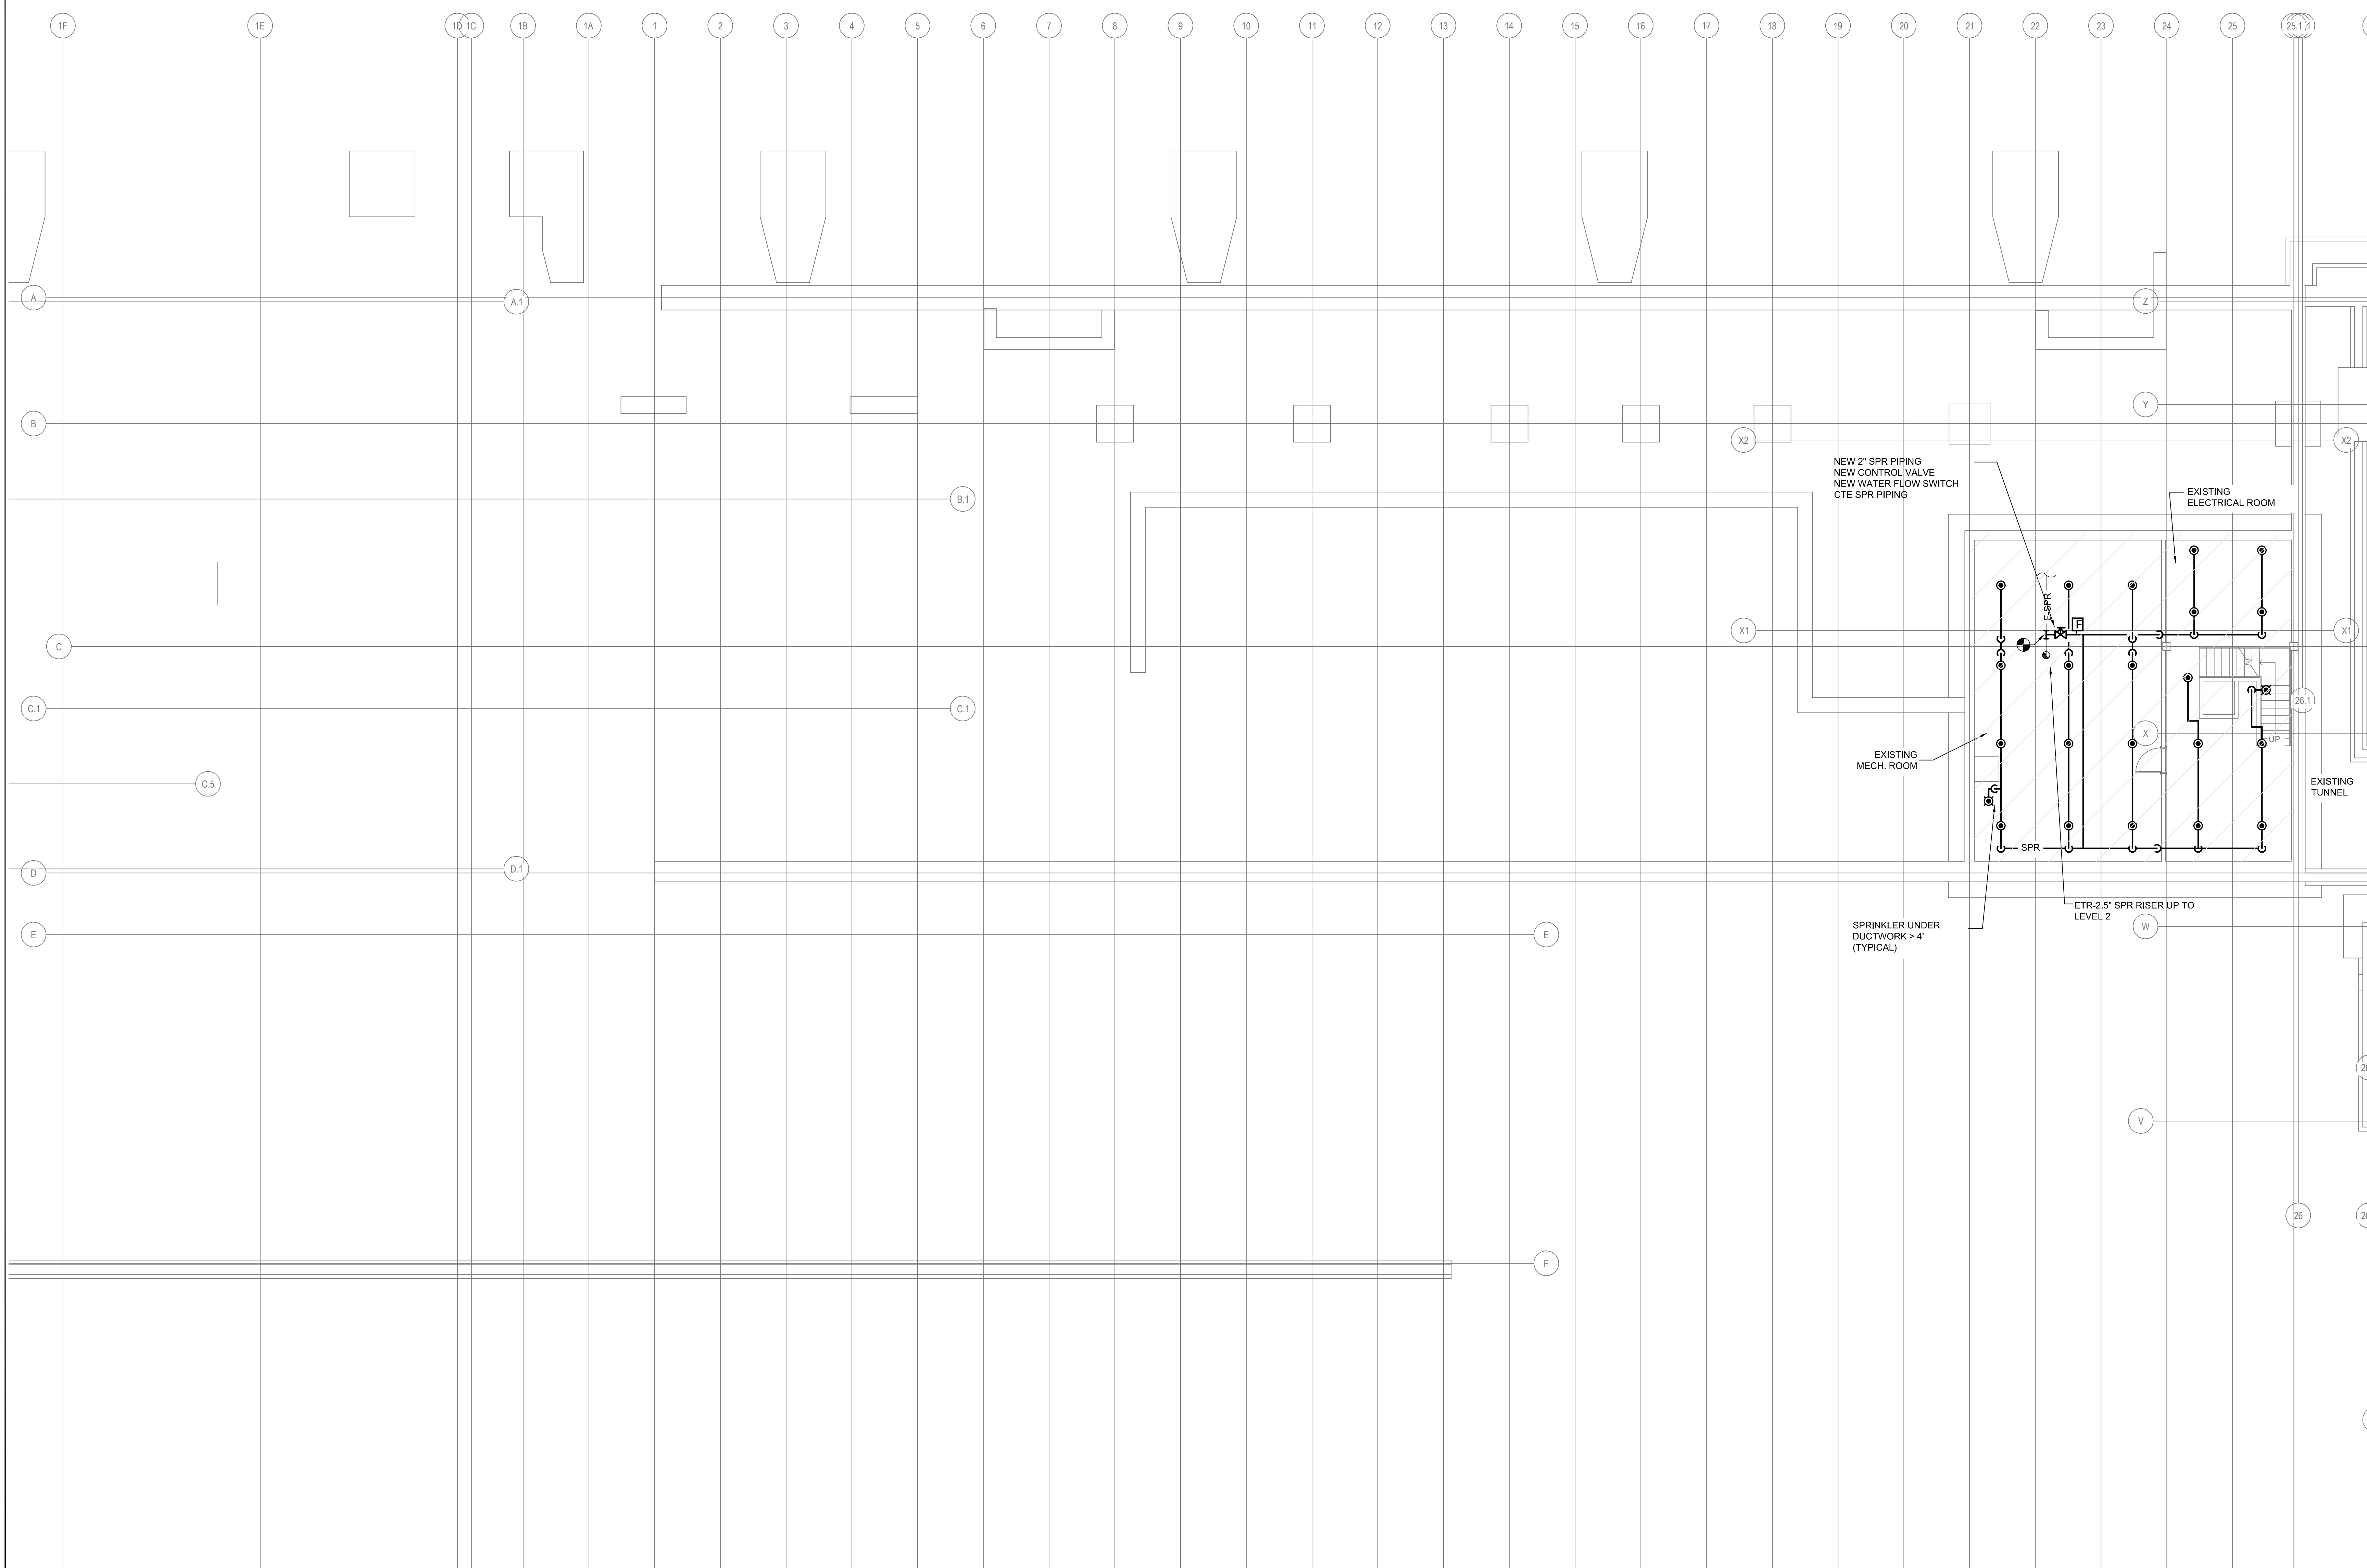

GENERAL NOTES

A SEE SHEET FP.00.01 FOR LEGEND, SCHEDULES & GENERAL NOTES.

Issue	Date & Issue Description	By	Check
01	01/23/09	MHY	JLD
95% CONSTRUCTION DOCUMENTS			
02	10/26/09	JLD	SKD
ISSUED FOR PERMIT			

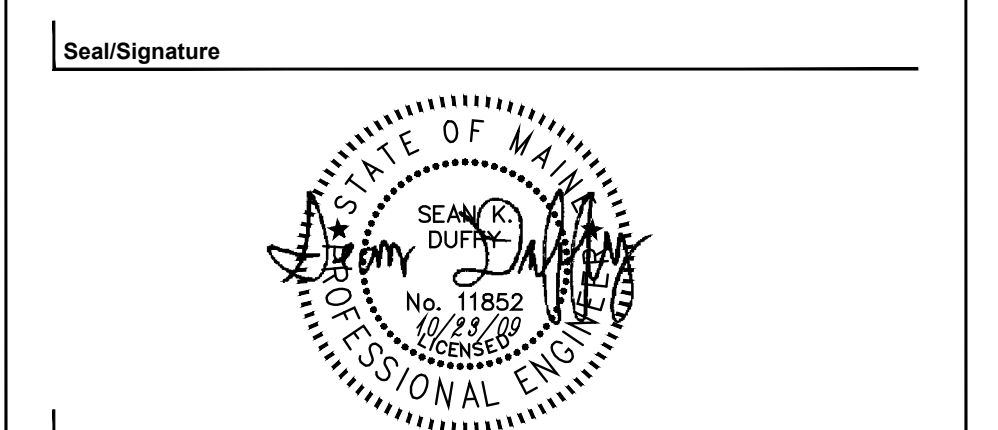

Project Name
PJM Terminal Expansion

Project Number
08.0395.000

CAD File Name
FP04.B1.02.dwg


Description
FIRE PROTECTION PLAN - LEVEL B1 - ZONE 2

Scale
1/8" = 1'-0"

FP04.B1.02

©2009 Gensler

KEY PLAN

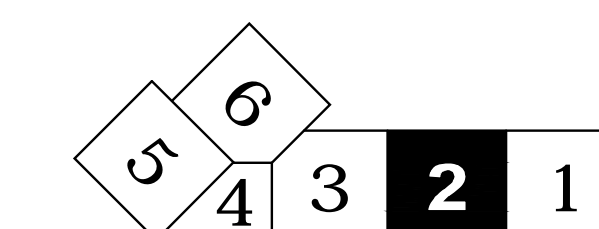

FIRE PROTECTION PLAN - LEVEL B1 - ZONE 2

SCALE: 1/8"=1'-0"