


**SHEET NOTES**

**Portland International  
Jetport**  
1001 Westbrook Street  
Portland, Maine 04102

**Gensler**  
2020 K Street, NW  
Suite 200  
Washington, DC 20006  
Telephone 202.721.5200  
Facsimile 202.872.8587

**oest ASSOCIATES, INC.**  
363 Goshen Road, South Portland, ME 04106 P: (207) 741-1770 F: (207) 774-2461 www.oest.com  
engineers • architects • surveyors • construction managers

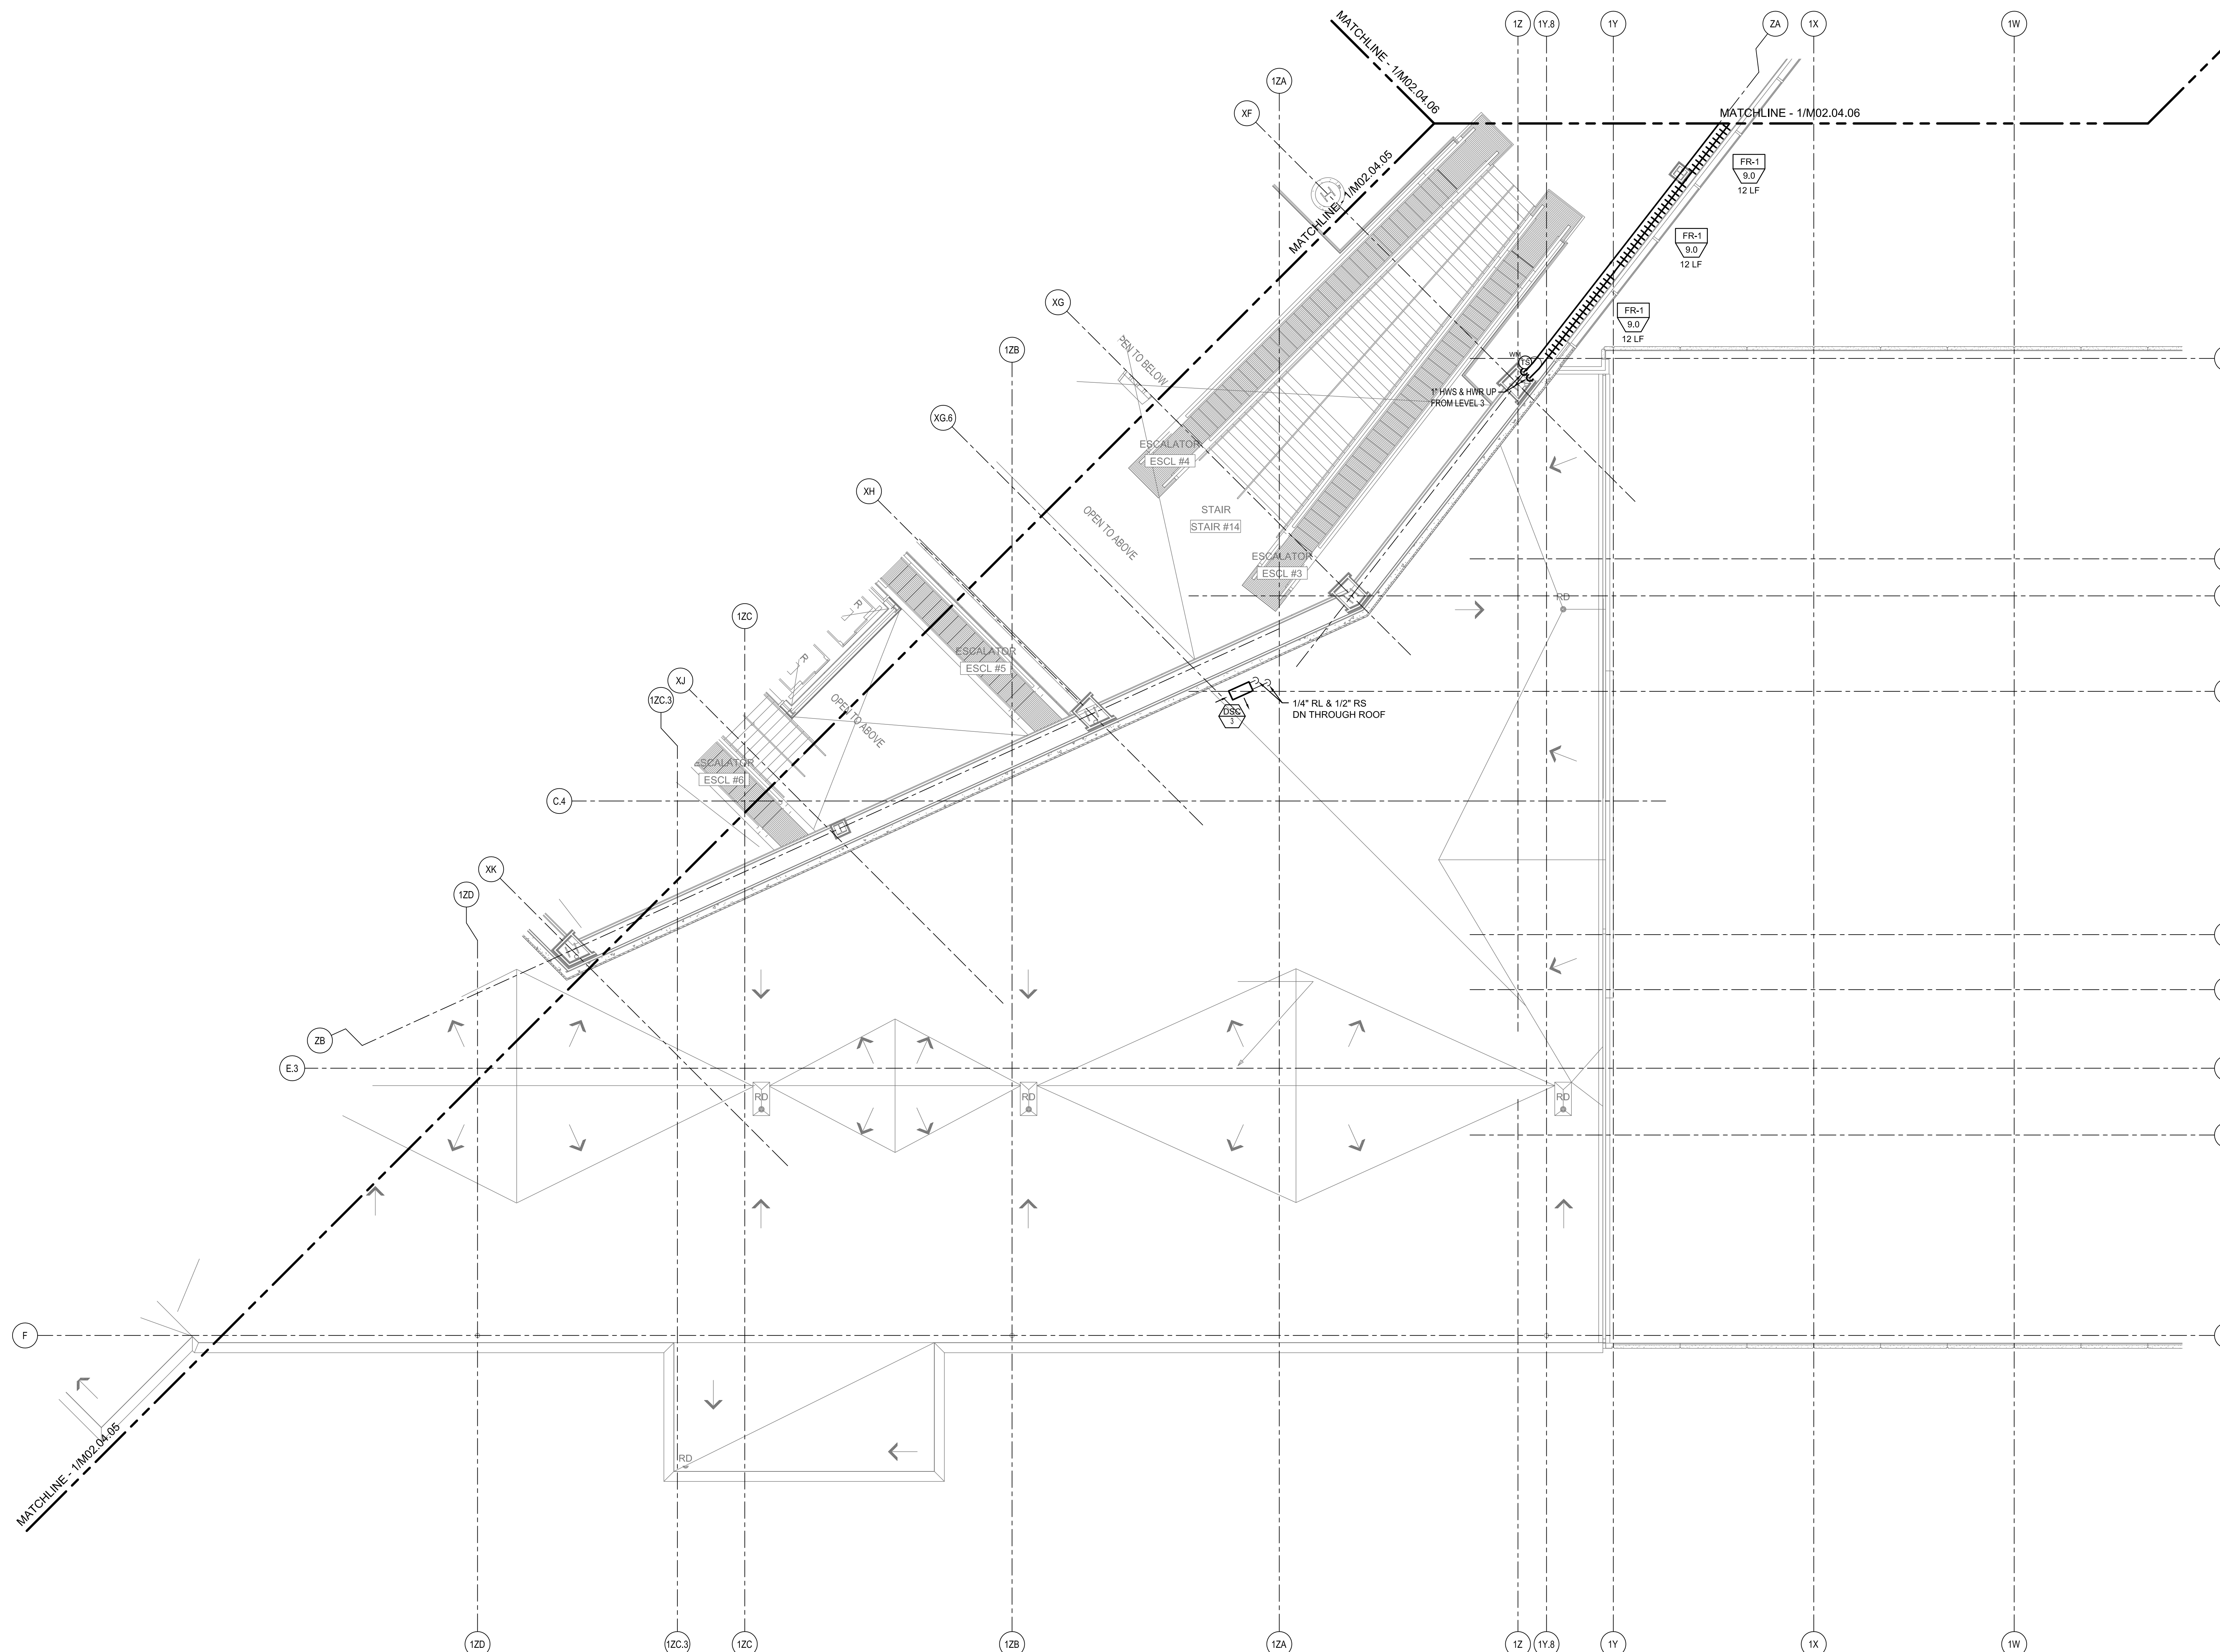

**GENERAL NOTES**


- A SEE SHEET M00.00 FOR LEGEND AND GENERAL NOTES.
- B MAINTAIN 18" MIN CLEARANCE FROM RADIANT TUBING TO FLOOR DRAINS, COLUMN WRAPS, PLUMBING FIXTURES, EQUIPMENT SUPPORTS, AND PIPING AT FLOORS.

Issue	Date & Issue Description	By	Check
01	07/11/08	PWZ	RHB
02	09/22/08	PWZ	RHB
03	12/03/08	PWZ	RHB
04	01/23/09	PWZ	RHB
05	10/26/09	PWZ	RHB

Project Name: PWM Terminal Enhancement  
 Project Number: 09-6395-000  
 CAD File Name: T:\6330\01\Sheets\M02.04.04.dwg  
 Description: MECHANICAL PIPING PLAN - LEVEL 4 - ZONE 4

Scale: 1/8" = 1'-0"

**KEY PLAN**

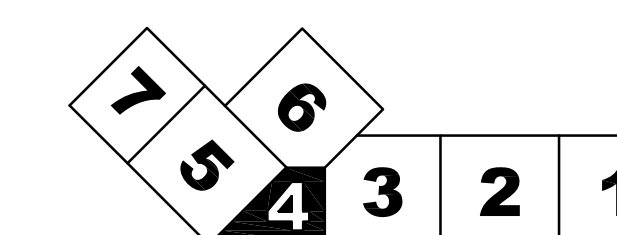

**M02.04.04**