


**MECHANICAL ROOM SANITARY RISER DIAGRAM**  
SCALE: NOT TO SCALE

**2**

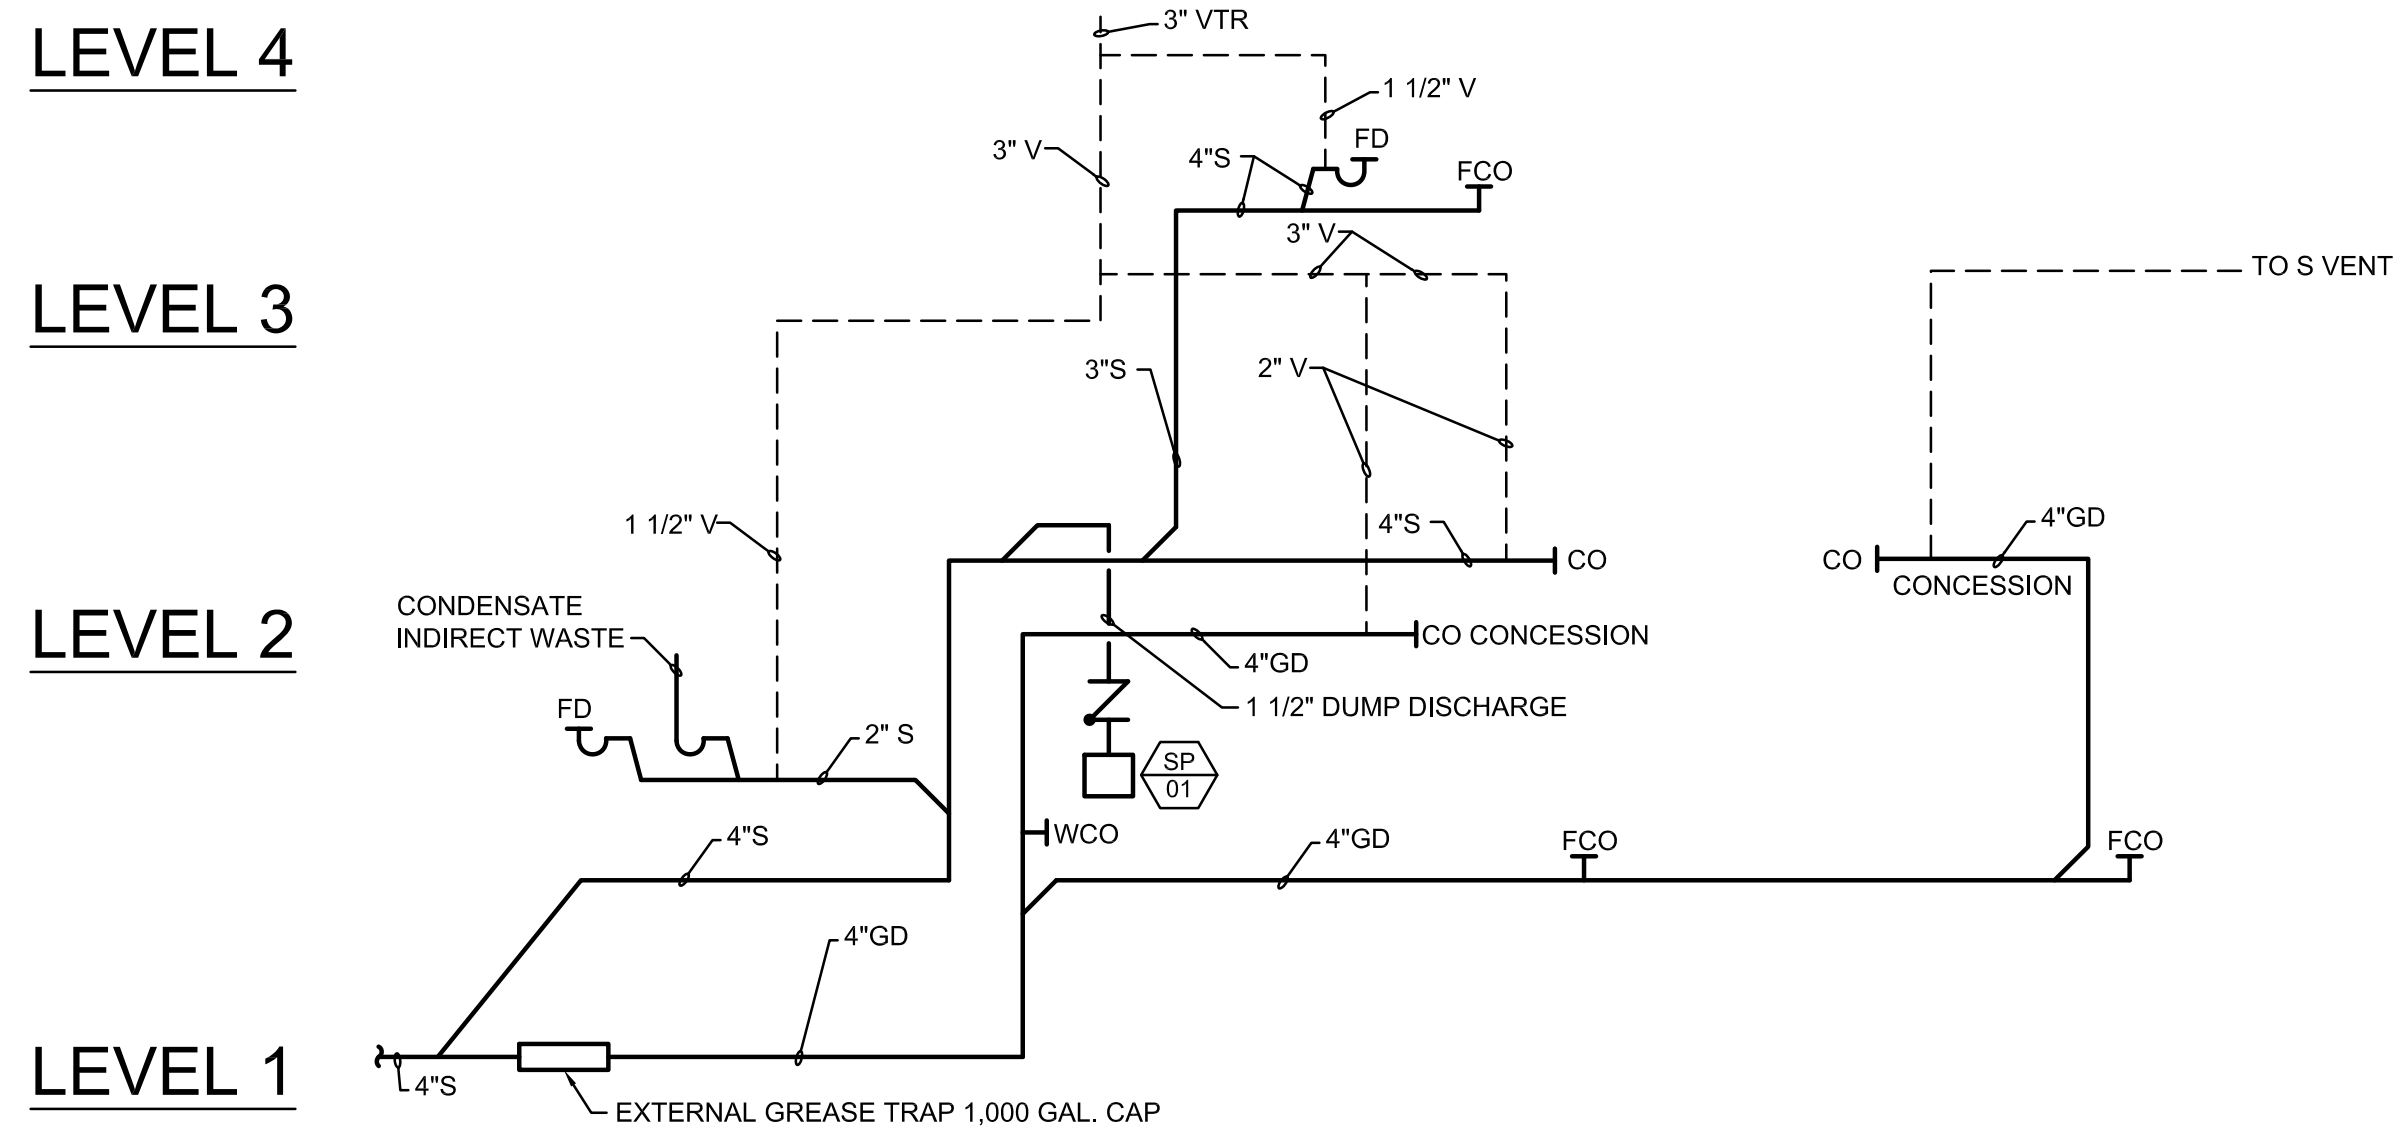

**WEST SANITARY & GREASE DRAIN**  
SCALE: NOT TO SCALE

**SHEET NOTES**


01 2" AIR CONDITIONER CONDENSATE INDIRECT WASTE.

**Portland International Jetport**  
1001 Westbrook Street  
Portland, Maine 04102

**Gensler**

2020 K Street, NW  
Suite 200  
Washington, DC 20006  
Telephone 202.721.5200  
Facsimile 202.872.8587

**oest ASSOCIATES, INC.**  
360 Goshen Road, South Portland, ME 04106 P (207) 741-1770 F (207) 774-2461 www.oest.com  
engineers • architects • surveyors • construction managers

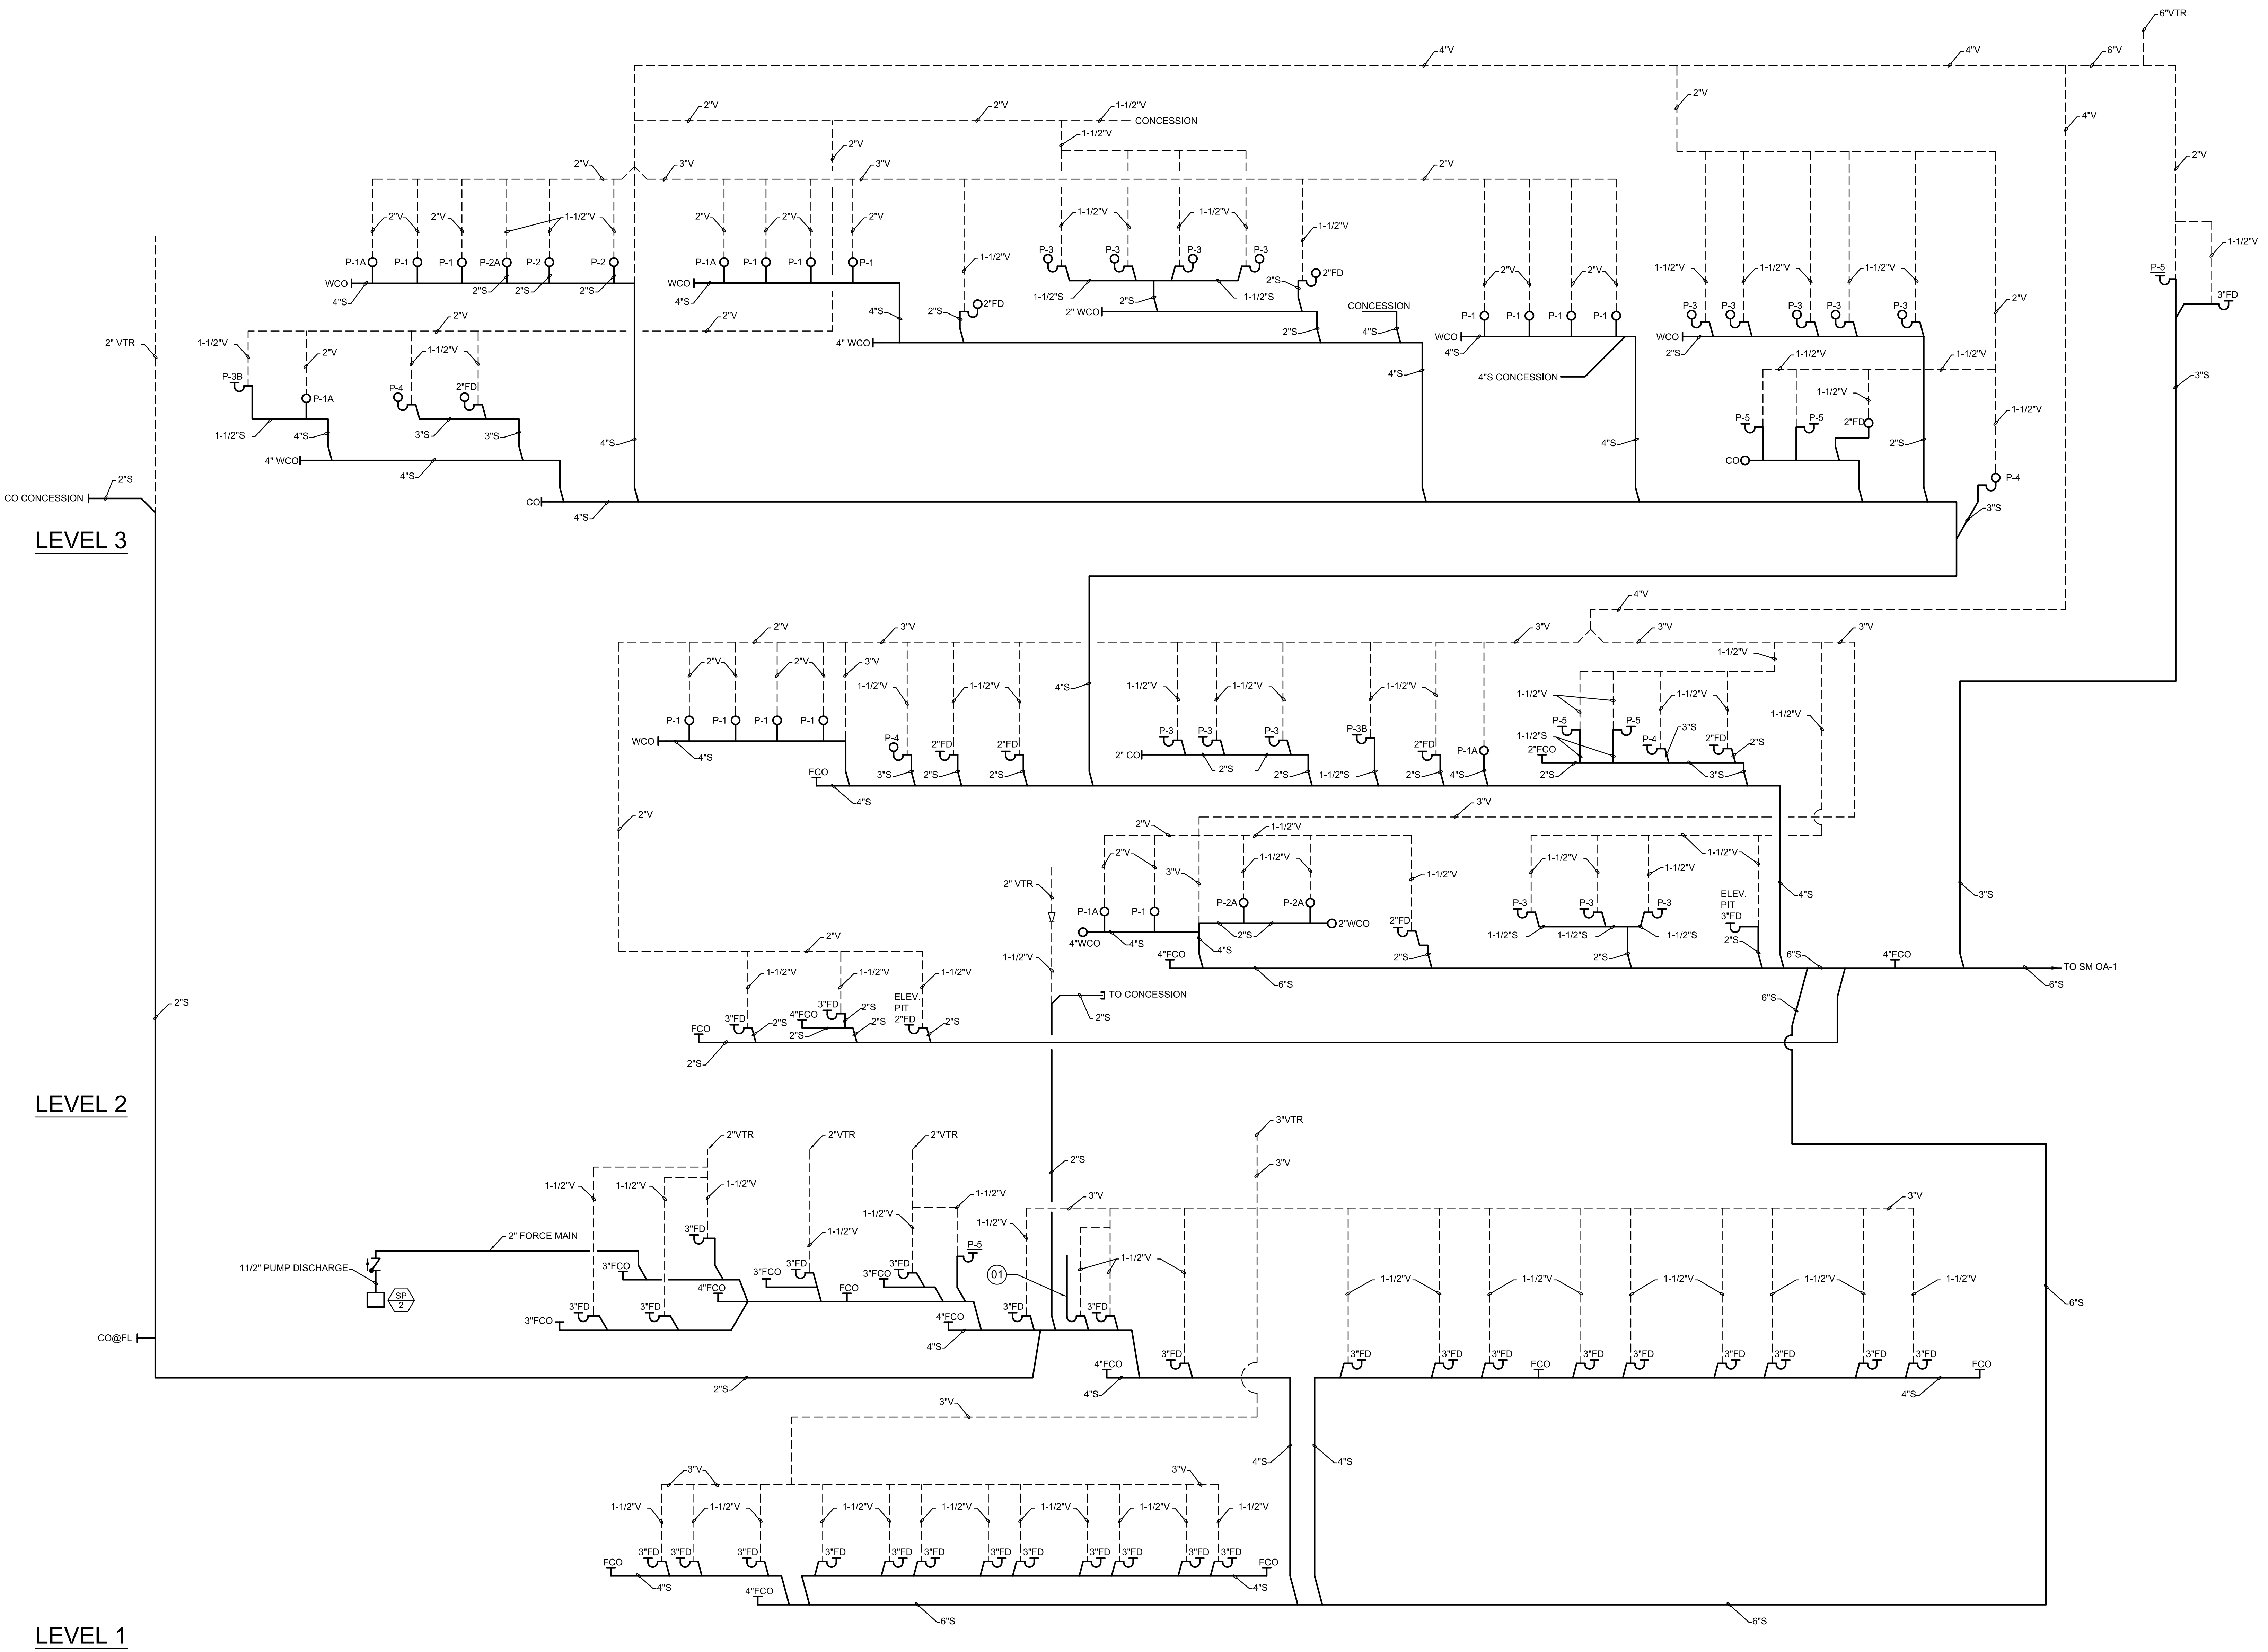


**SANITARY RISER DIAGRAM**  
SCALE: NOT TO SCALE

**1**

**GENERAL NOTES**

A SEE SHEET P00.00 FOR LEGEND AND GENERAL NOTES.

Issue	Date & Issue Description	By	Check
01	12/03/08	KLM	JS
02	01/23/09	CM	JS
02	10/26/09	PWZ	JS

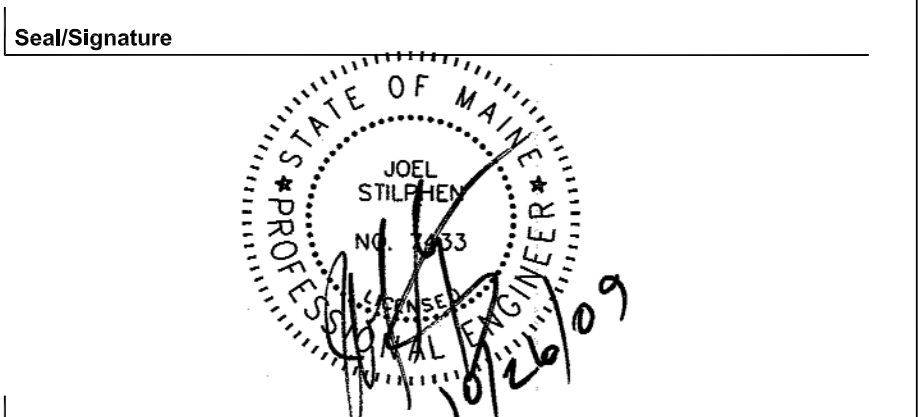

Project Name  
PJM Terminal Enhancement

Project Number  
09.6395.000

CAD File Name  
T:\5330\01\Sheets\P12.01.dwg

Description  
SANITARY RISER DIAGRAM

Scale  
NOT TO SCALE

**P12.01**

©2009 Gensler