



CANOPY HEAT TRACE LAYOUT
SCALE: NOT TO SCALE

5

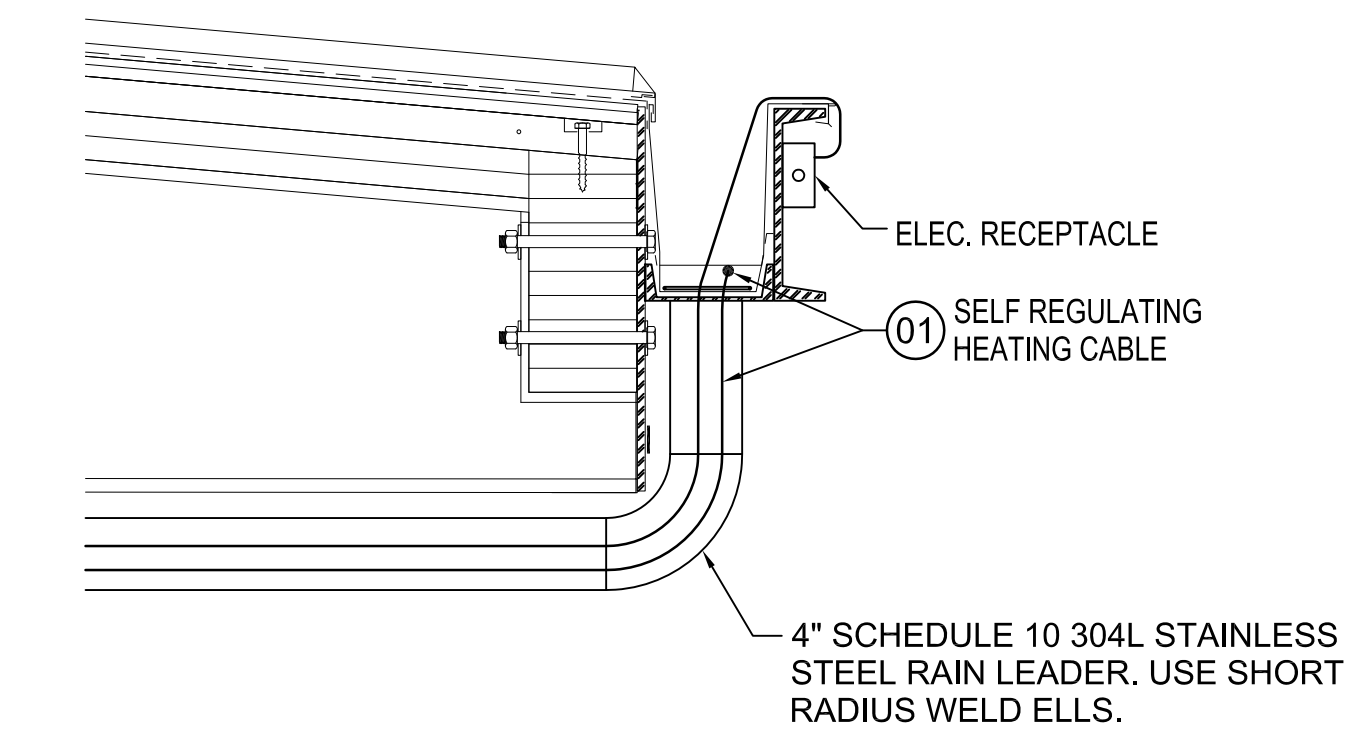


HEAT TRACE DETAIL @ GUTTER
SCALE: NOT TO SCALE

1

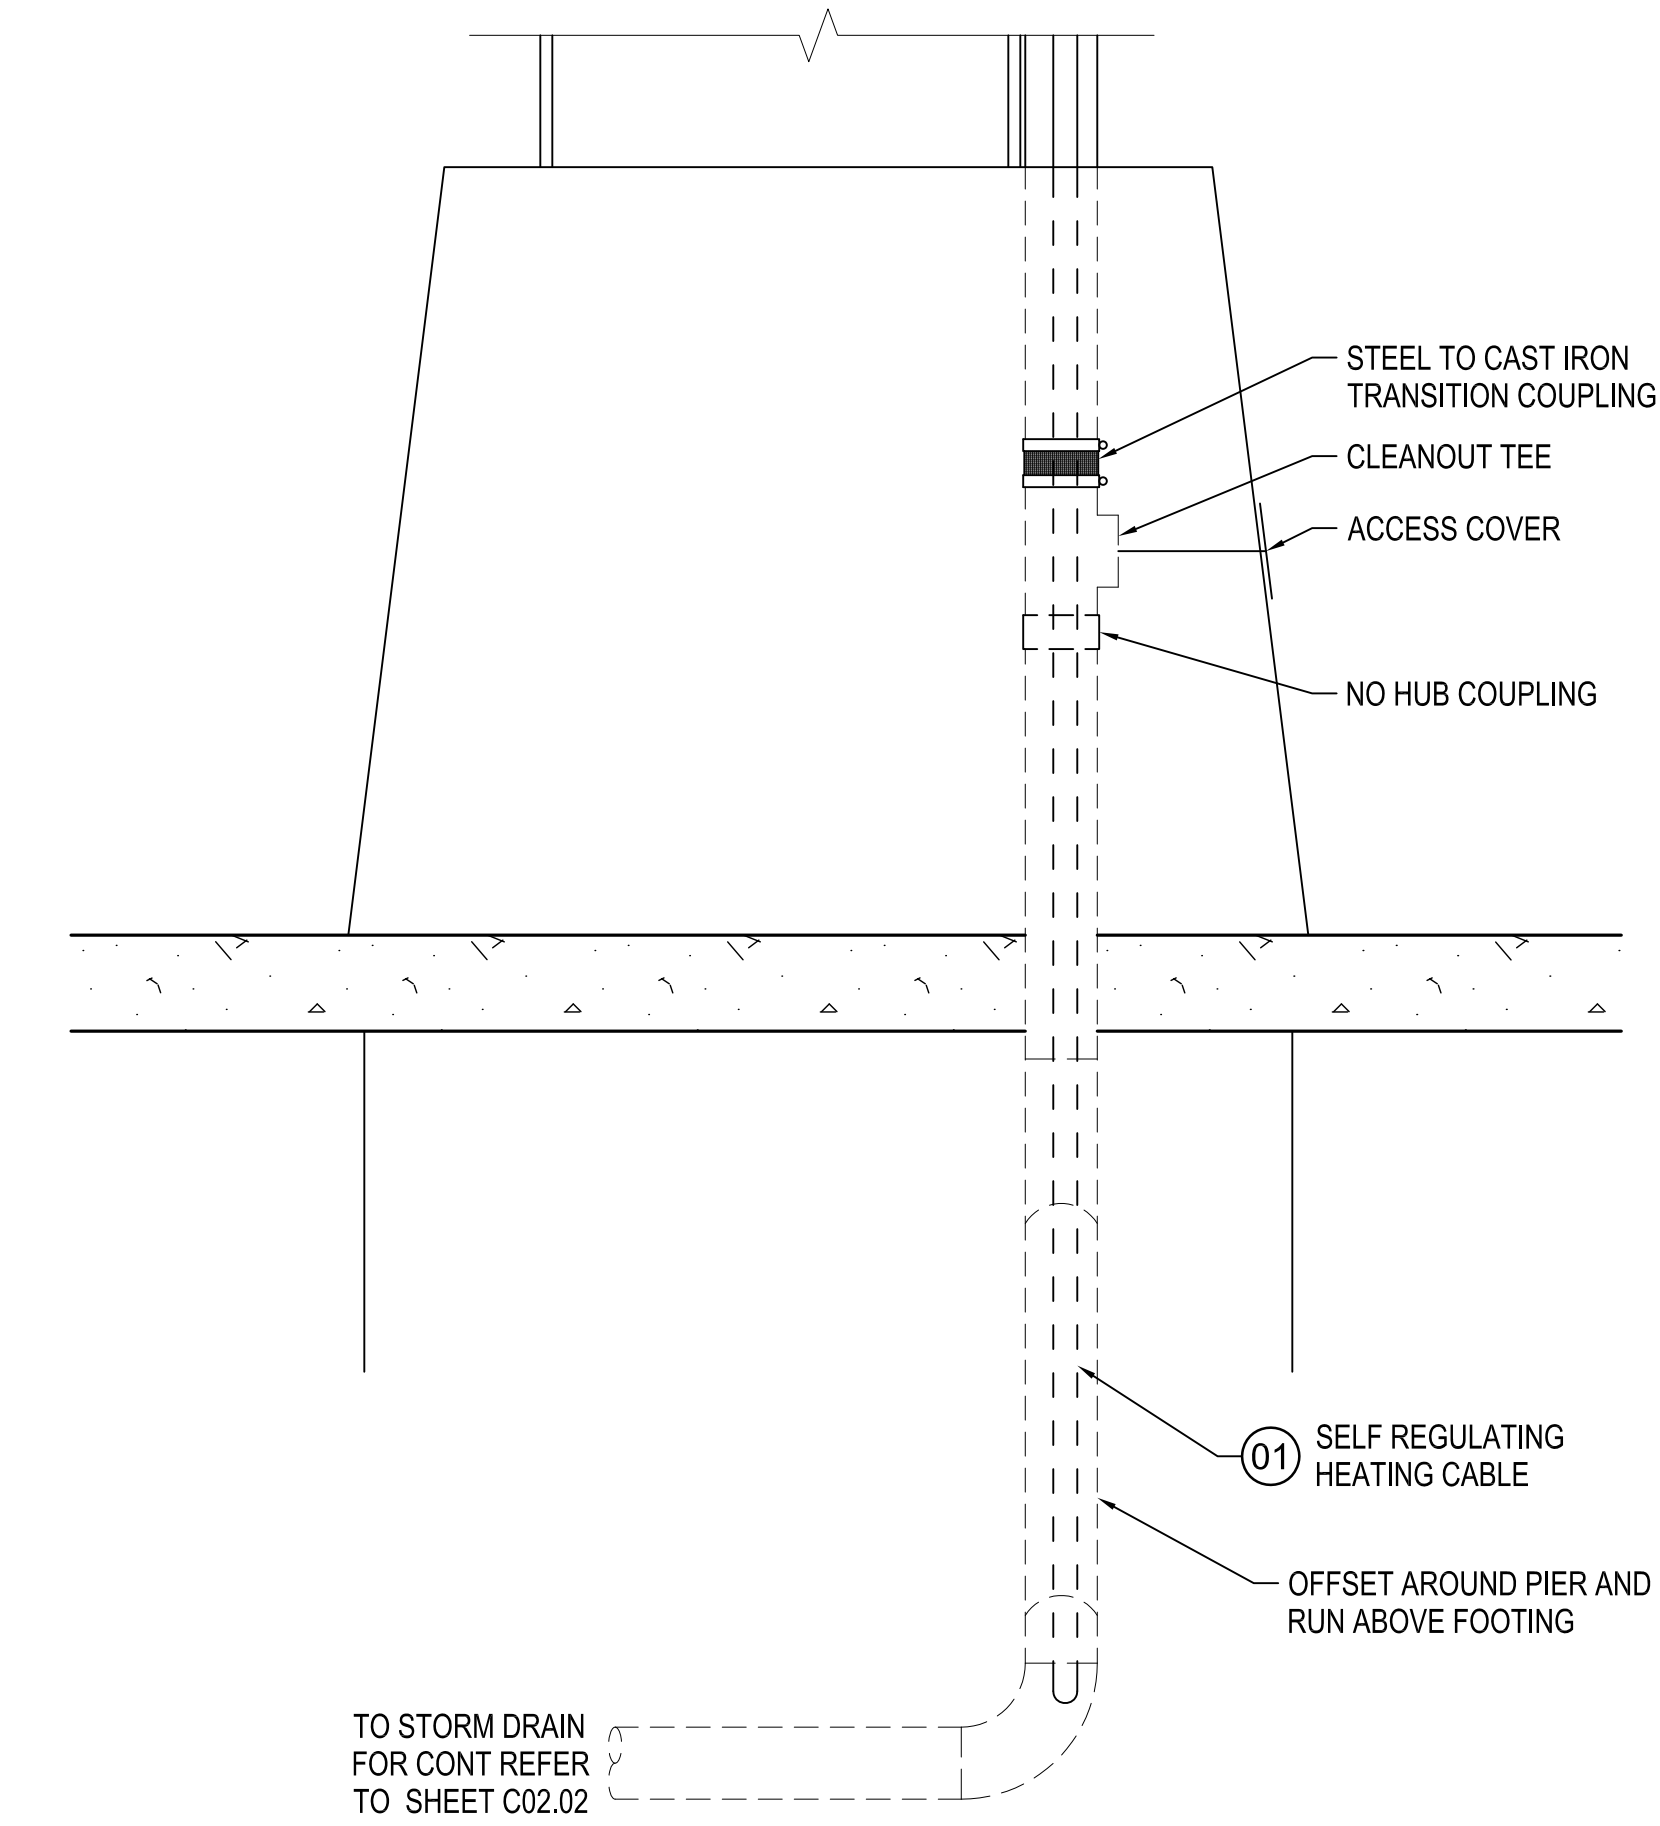


HEAT TRACE DETAIL @ BASE
SCALE: NOT TO SCALE

2

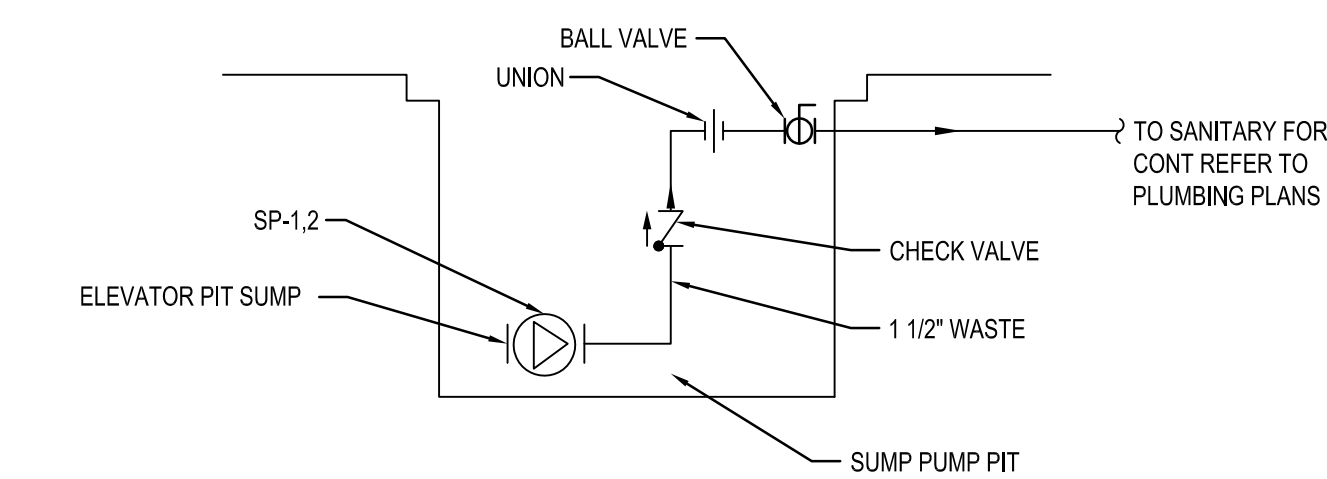

ELEVATOR PIT SUMP PUMP DETAIL
SCALE: NOT TO SCALE

3

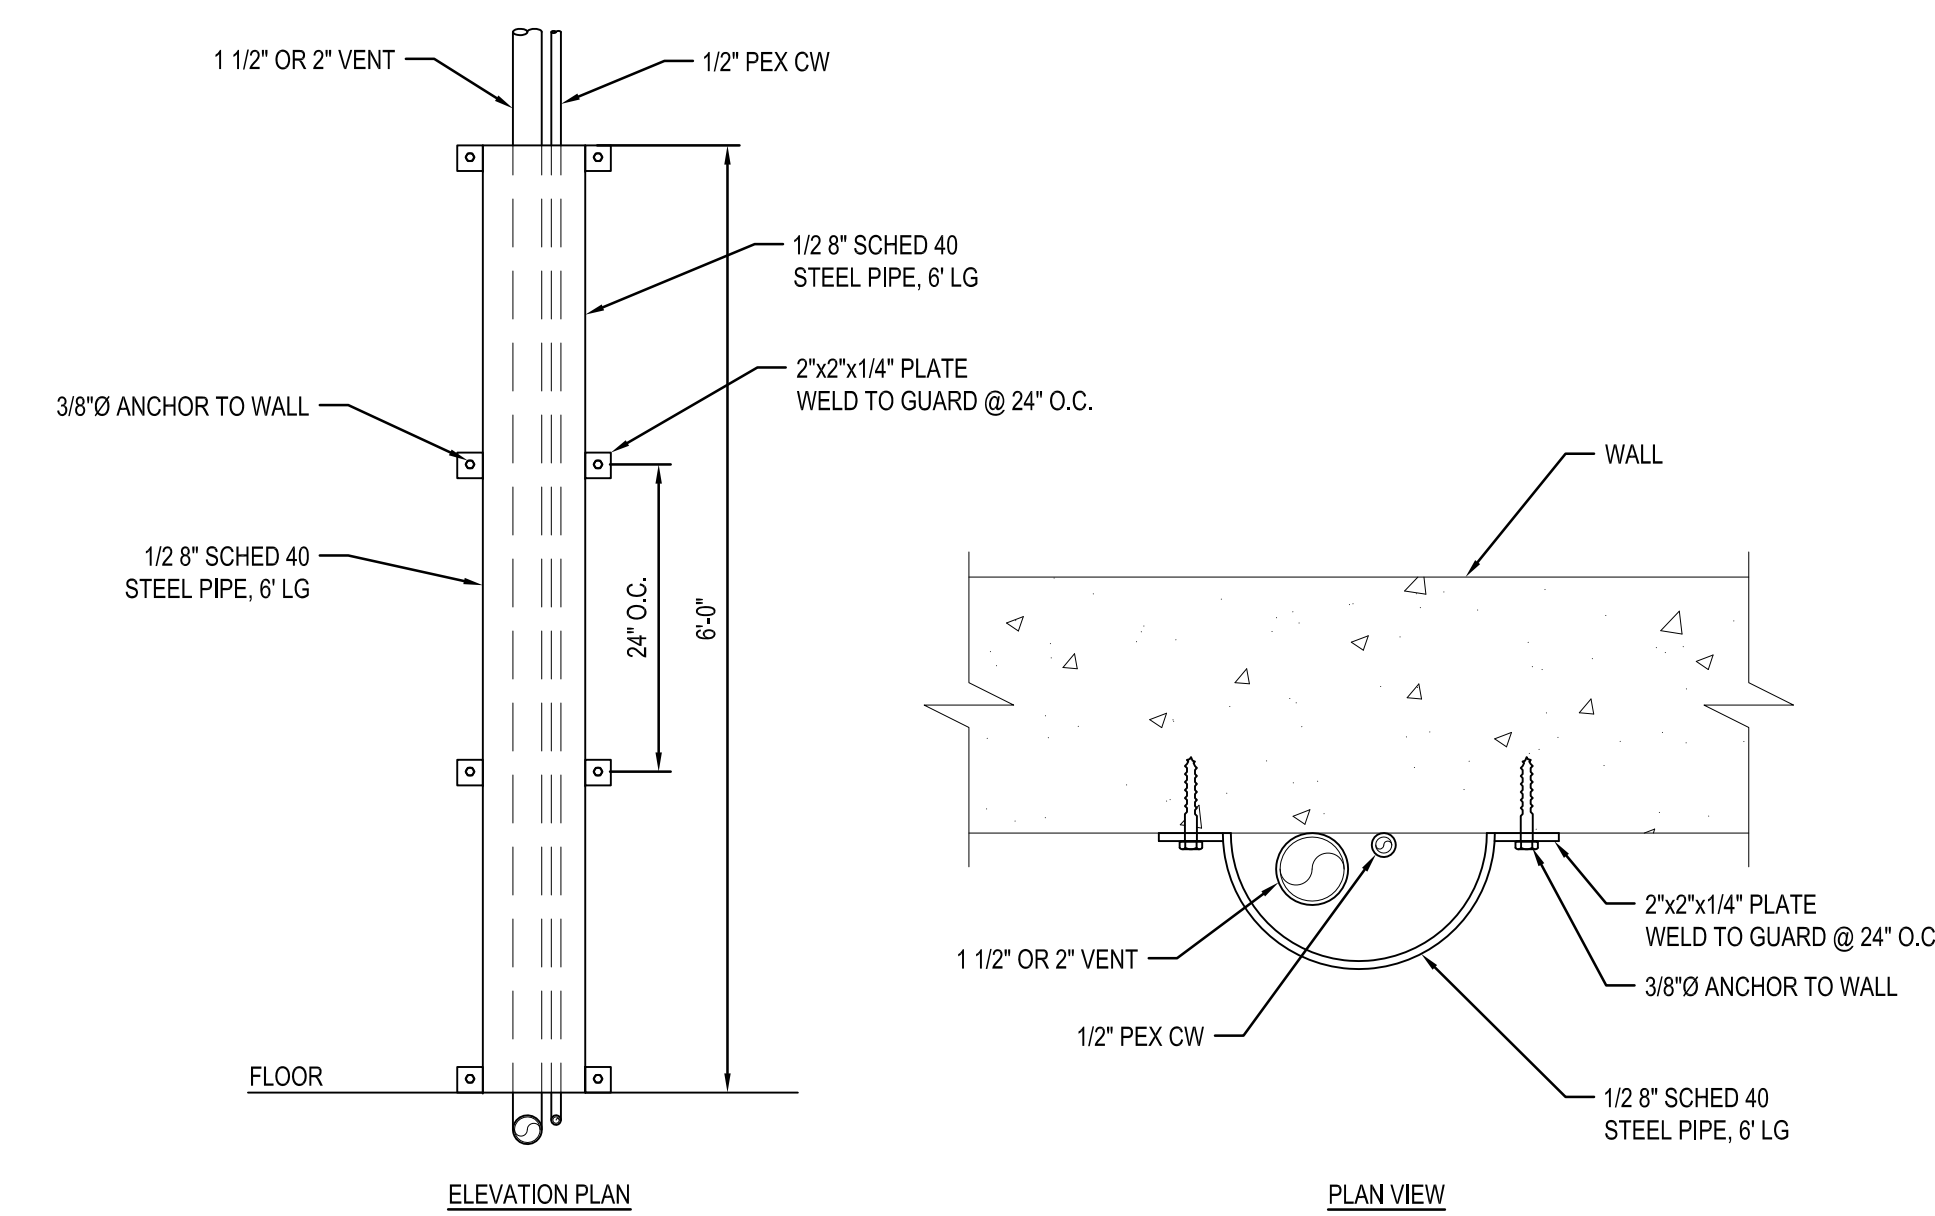

BAGGAGE MAKEUP PIPE GUARD DETAIL
SCALE: NOT TO SCALE

4

SHEET NOTES

01 SR TRACE EASY HEAT SELF REGULATING HEATING CABLE, CATALOG NO. SR22J, NOMINAL 2W/FT., 277V, 1 PHASE. RUN IN BASE OF RAIN GUTTER AND LOOP DOWN RAIN LEADER TO 4" BELOW GRADE.

Portland International Jetport

1001 Westbrook Street
Portland, Maine 04102

Gensler

2020 K Street, NW
Suite 200
Washington, DC 20006
Telephone 202.721.5200
Facsimile 202.872.8587


nest ASSOCIATES, INC.
360 Goshen Road, South Portland, ME 04106 P: (207) 741-1770 F: (207) 774-2461 www.nest.com
engineers • architects • surveyors • construction managers

GENERAL NOTES

A SEE SHEET P00.00 FOR LEGEND AND GENERAL NOTES.

Issue	Date & Issue Description	By	Check
01	12/03/08	KLM	JS
02	01/23/09	CM	JS
02	10/26/09	PWZ	JS

Seal/Signature

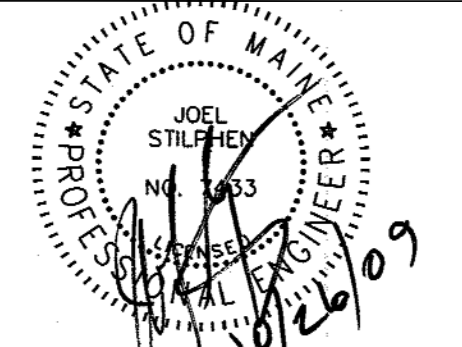

Project Name
PJM Terminal Enhancement

Project Number
09-6395-000
CAD File Name
T:\6330\101\Sheets\P12.23.dwg
Description
PLUMBING DETAILS

Scale
NOT TO SCALE

P12.23

©2009 Gensler