


Portland International  
Jetport


1001 Westbrook Street  
Portland, Maine 04102

**Gensler**  
2020 K Street, Northwest  
Suite 200  
Washington, DC 20006  
Telephone 202.721.5200  
Facsimile 202.872.8587

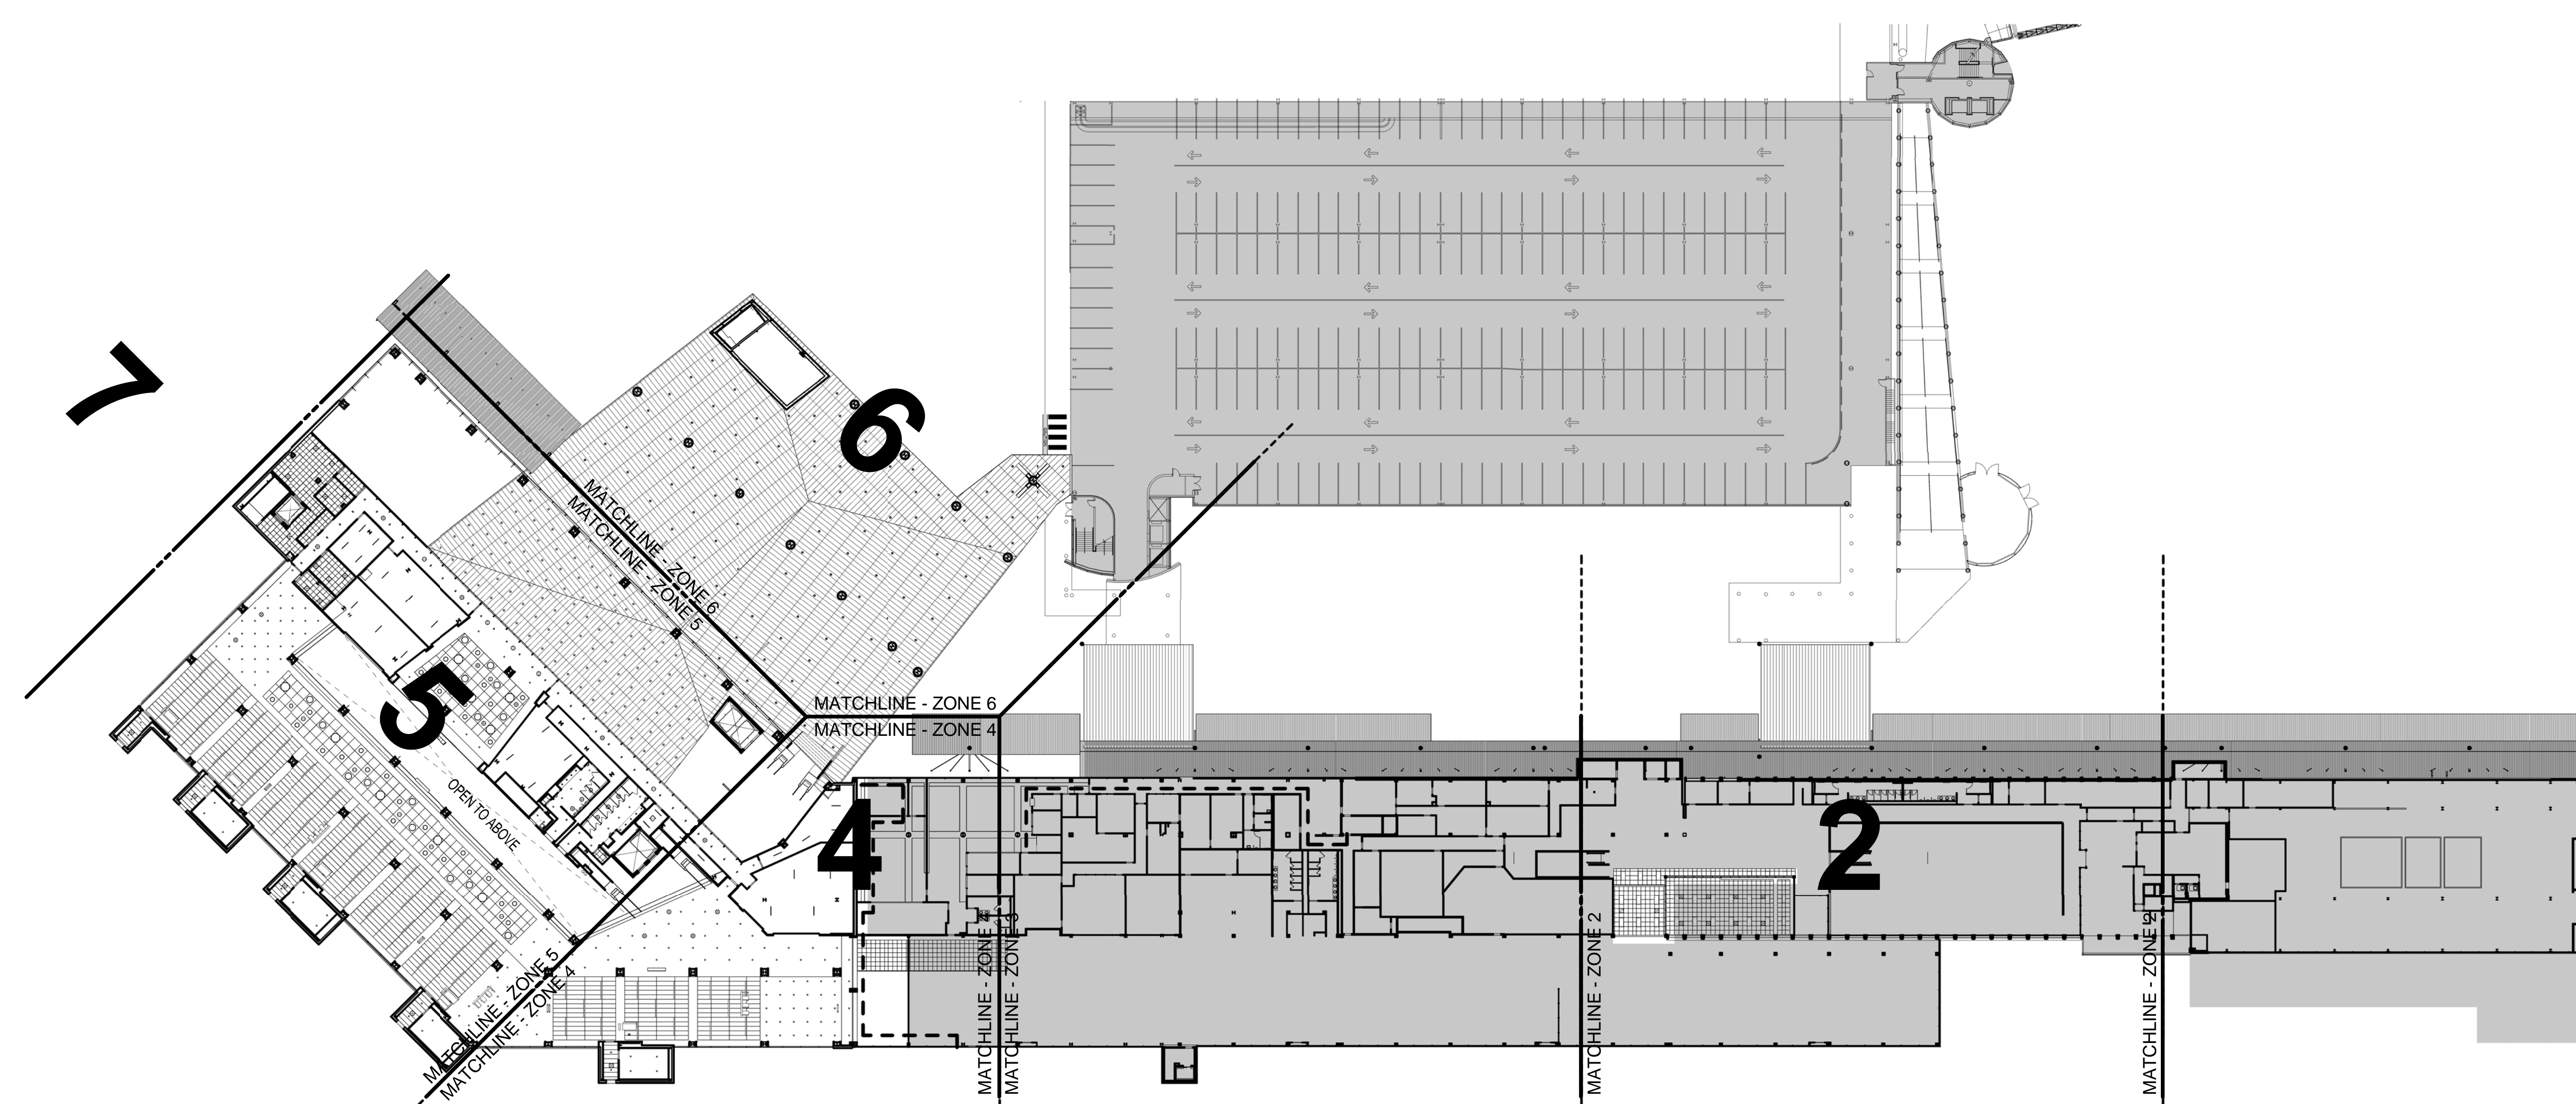

Date	Description
07/11/08	SCHEMATIC DESIGN
09/22/08	DESIGN DEVELOPMENT
12/03/08	75% CONSTRUCTION DOCUMENTS
01/23/09	95% CONSTRUCTION DOCUMENTS
10/26/09	ISSUED FOR PERMIT
145 09/01/11	ISSUED FOR CONSTRUCTION

Seal/Signature

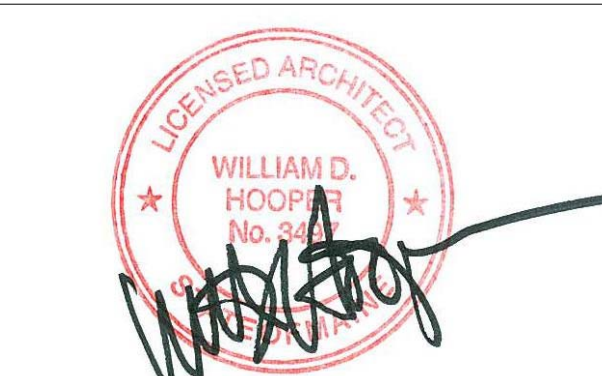


Project Name  
PWM Terminal Enhancement

Project Number  
09.6395.000

Description  
REFLECTED CEILING PLAN - LEVEL 3 - ZONING DIAGRAM

 Scale  
1" = 40'-0"



**A04.03.00**

© 2009 Gensler