

SHEET NOTES

**Portland International
Jetport**

1001 Westbrook Street
Portland, Maine 04102

Gensler

2020 K Street, NW
Suite 200
Washington, DC 20006
Telephone 202.771.5200
Facsimile 202.872.8587

oest ASSOCIATES, INC.
343 Gorham Road, South Portland, ME 04106 P: (207) 761-1770 F: (207) 774-1246 www.oest.com
engineers - architects - surveyors - construction managers

amec
343 Gorham Road, South Portland ME 04106
P: (207) 761-1770 F: (207) 774-1246 www.amec.com


THESE DRAWINGS ARE ISSUED FOR CONSTRUCTION AND REFLECT ALL AMEC ISSUED BULLETINS AND SKETCHES.

Issue	Date & Issue Description	By	Check
01	12/03/08	LAM	BHG
75% CONSTRUCTION DOCUMENTS			
02	01/23/09	LAM	BHG
95% CONSTRUCTION DOCUMENTS			
03	10/26/09	LAM	BHG
ISSUED FOR PERMIT			
04	11/02/09	LAM	BHG
ADDENDUM #1			
02	05 11/13/09	LAM	BHG
ADDENDUM #2			
03	06 11/20/09	LAM	BHG
ADDENDUM #3			
16	07 09/01/11	LAM	BHG
ISSUED FOR CONSTRUCTION			

GENERAL NOTES

- A SEE SHEET E00.00 FOR LEGEND AND GENERAL NOTES.
- B CONTRACTOR SHALL COORDINATE MOUNTING HEIGHTS OF EXIT SIGNS OF THIS LEVEL WITH ARCHITECTURAL.
- C "B" TYPE FIXTURES IN BAG OUTBOUND AND BAG SCREENING SHALL BE MOUNTED SO BOTTOM OF FIXTURE IS FLUSH WITH BOTTOM OF STEEL BEAMS.

KEY PLAN

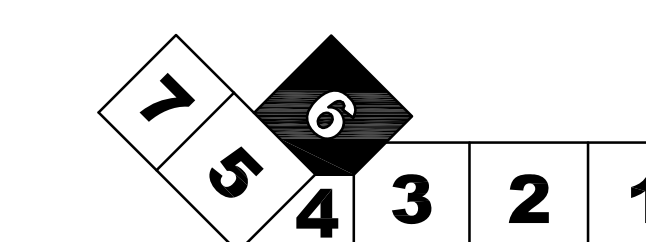


Scale
1/8" = 1'-0"

Ref. North

E04.02.06

©2009 Gensler

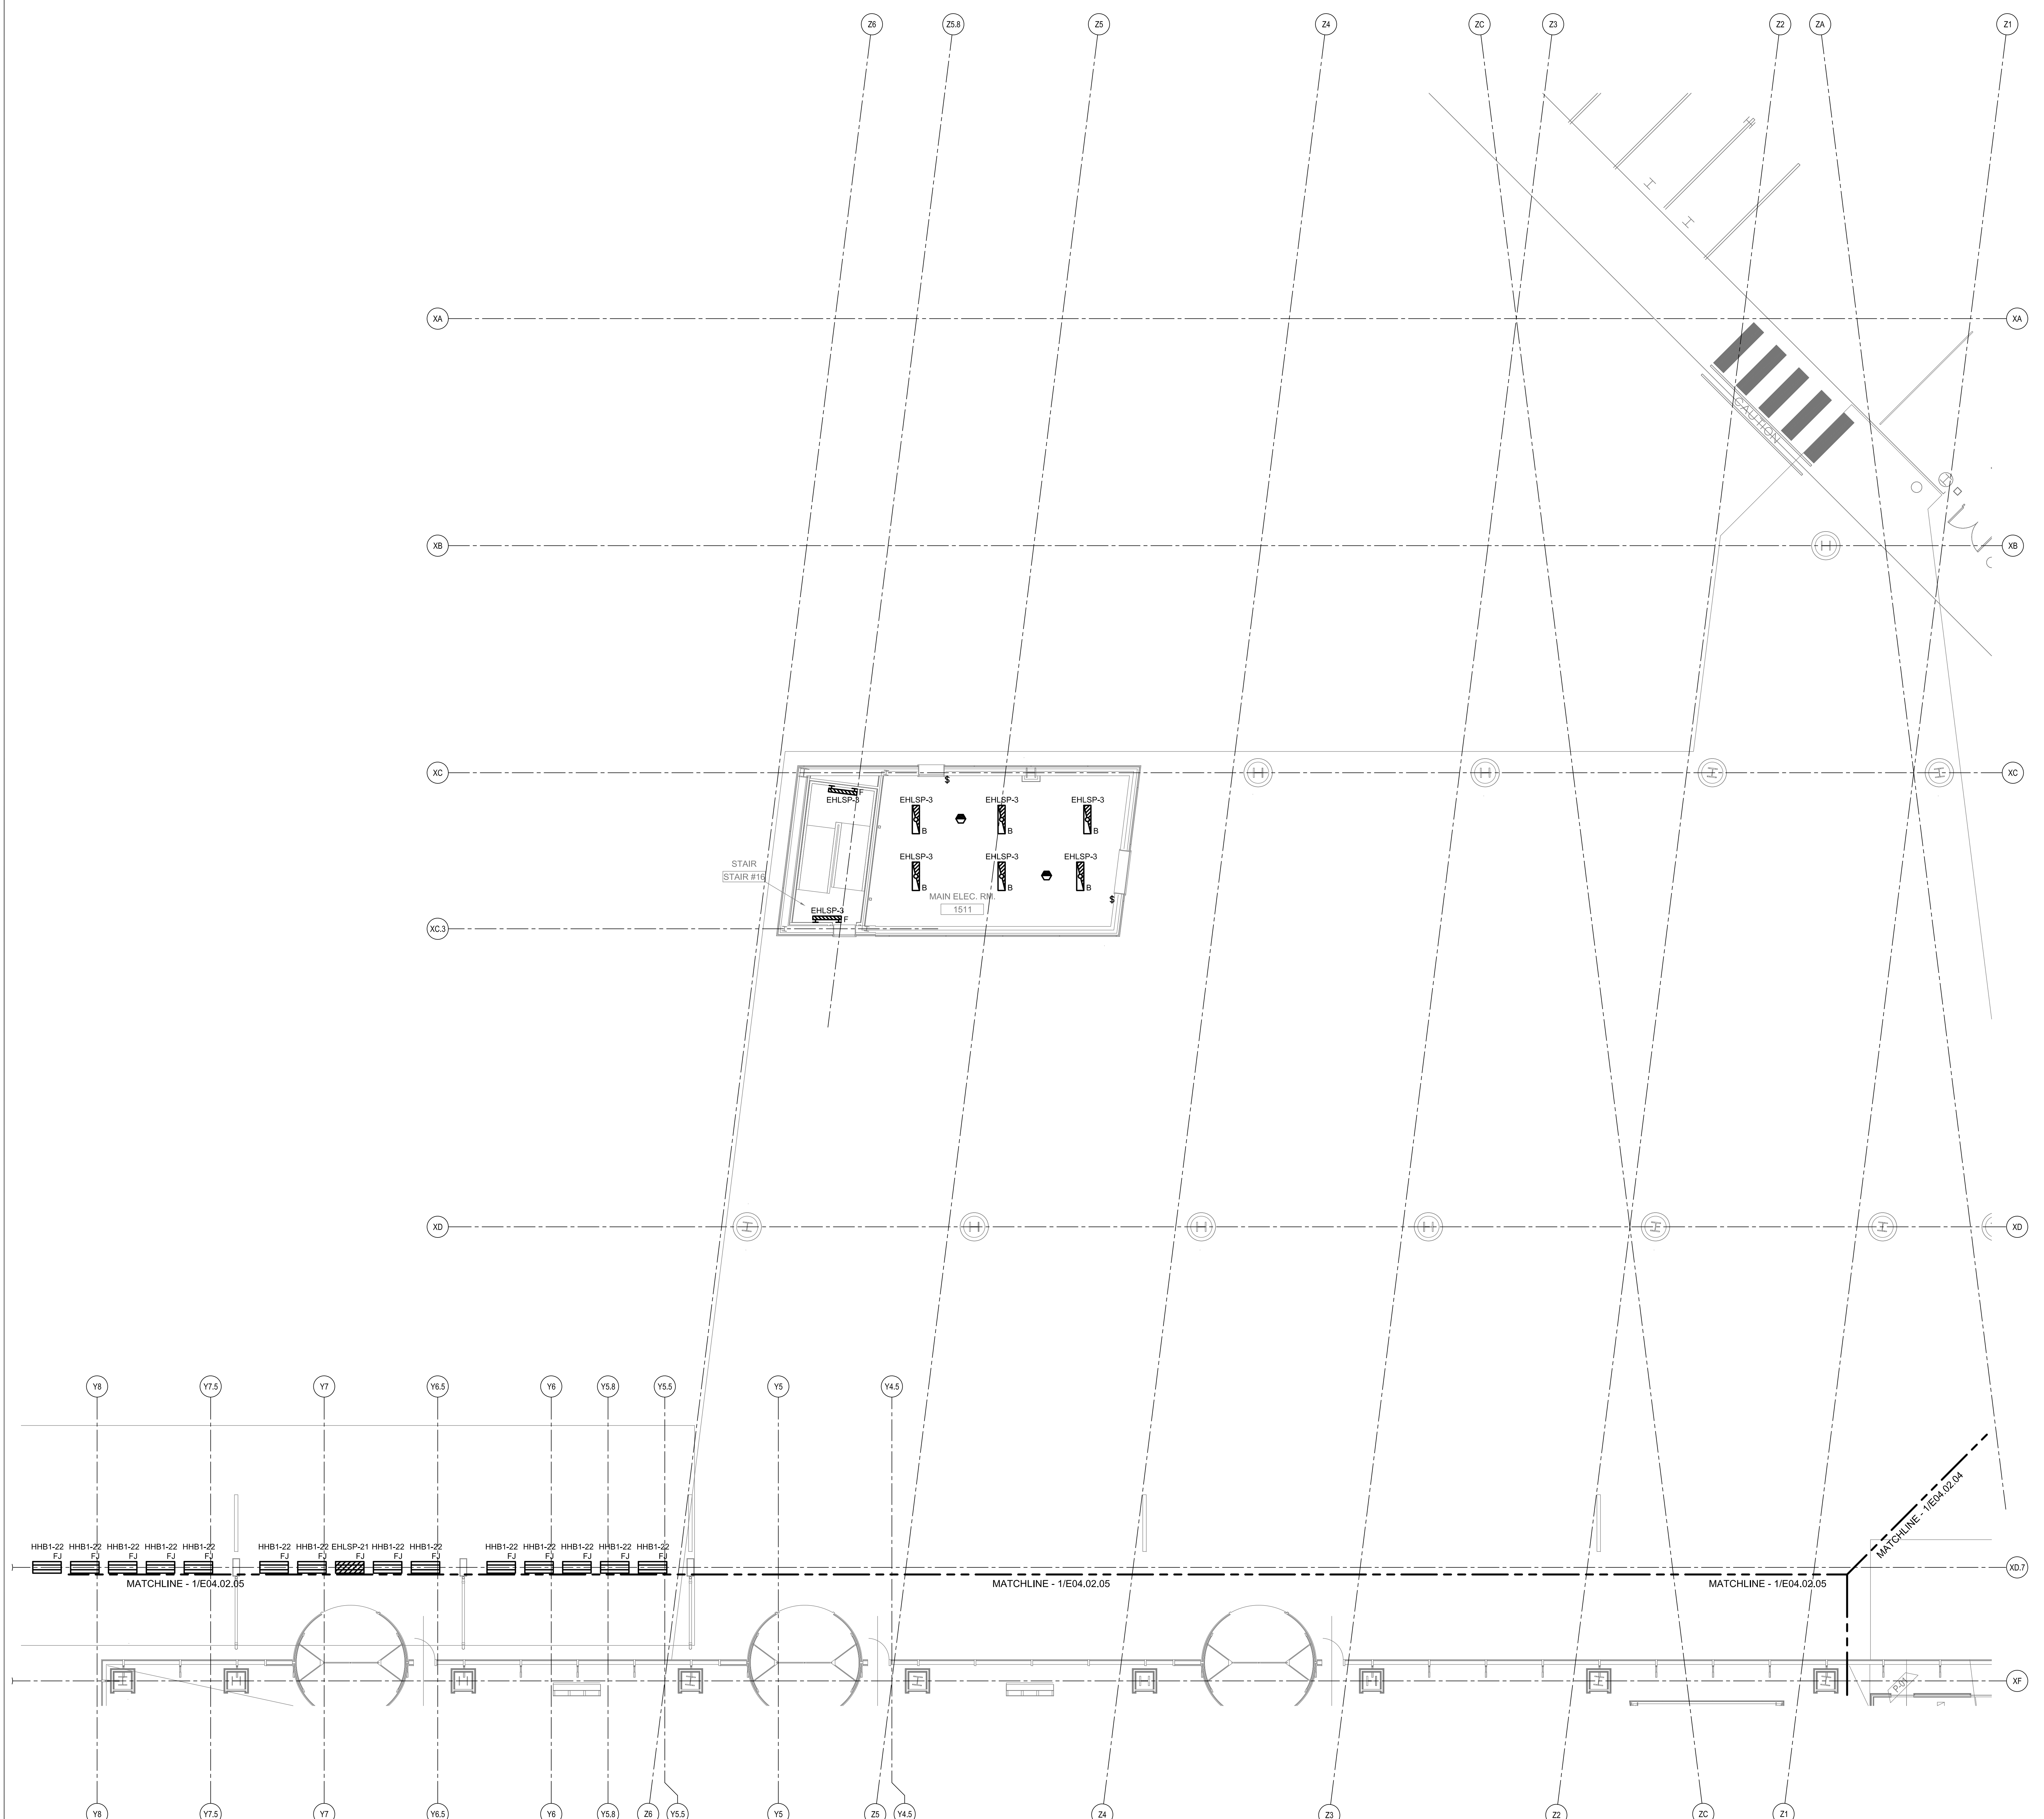

ELECTRICAL LIGHTING PLAN - LEVEL 2 - ZONE 6
SCALE: 1/8" = 1'-0"