

SHEET NOTES

Portland International
Jetport
1001 Westbrook Street
Portland, Maine 04102

Gensler
2020 K Street, NW
Suite 200
Washington, DC 20006
Telephone 202.721.5200
Facsimile 202.872.8587

nest ASSOCIATES, INC.
343 Gorham Road, South Portland, ME 04106
P: (207) 761-1770 F: (207) 774-1246 www.nest.com
engineers • architects • surveyors • construction managers

amec
343 Gorham Road, South Portland ME 04106
P: (207) 761-1770 F: (207) 774-1246 www.amec.com

FIRE RISK MANAGEMENT, INC.
1 First Street
Portland, ME 04106
(207) 445-2208
www.firemg.com

THESE DRAWINGS ARE ISSUED FOR
CONSTRUCTION AND REFLECT ALL FRM
ISSUED BULLETINS AND SKETCHES.


Issue	Date & Issue Description	By	Check
01	07/11/08	PWZ	RHB
02	09/22/08	SKD	WMC
03	12/03/08	SKD	WMC
04	01/23/09	MHY	JLD
05	10/26/09	JLD	SKD
02	06 11/12/09	JLD	SKD
145	07 09/01/11	SKD	

ISSUED FOR CONSTRUCTION

GENERAL NOTES

A SEE SHEET FP00.01 FOR LEGEND,
SCHEDULES & GENERAL NOTES.


KEY PLAN

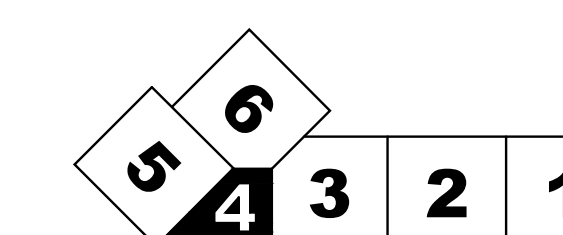

Scale
1/8" = 1'-0"

FP04.04.04

©2009 Gensler

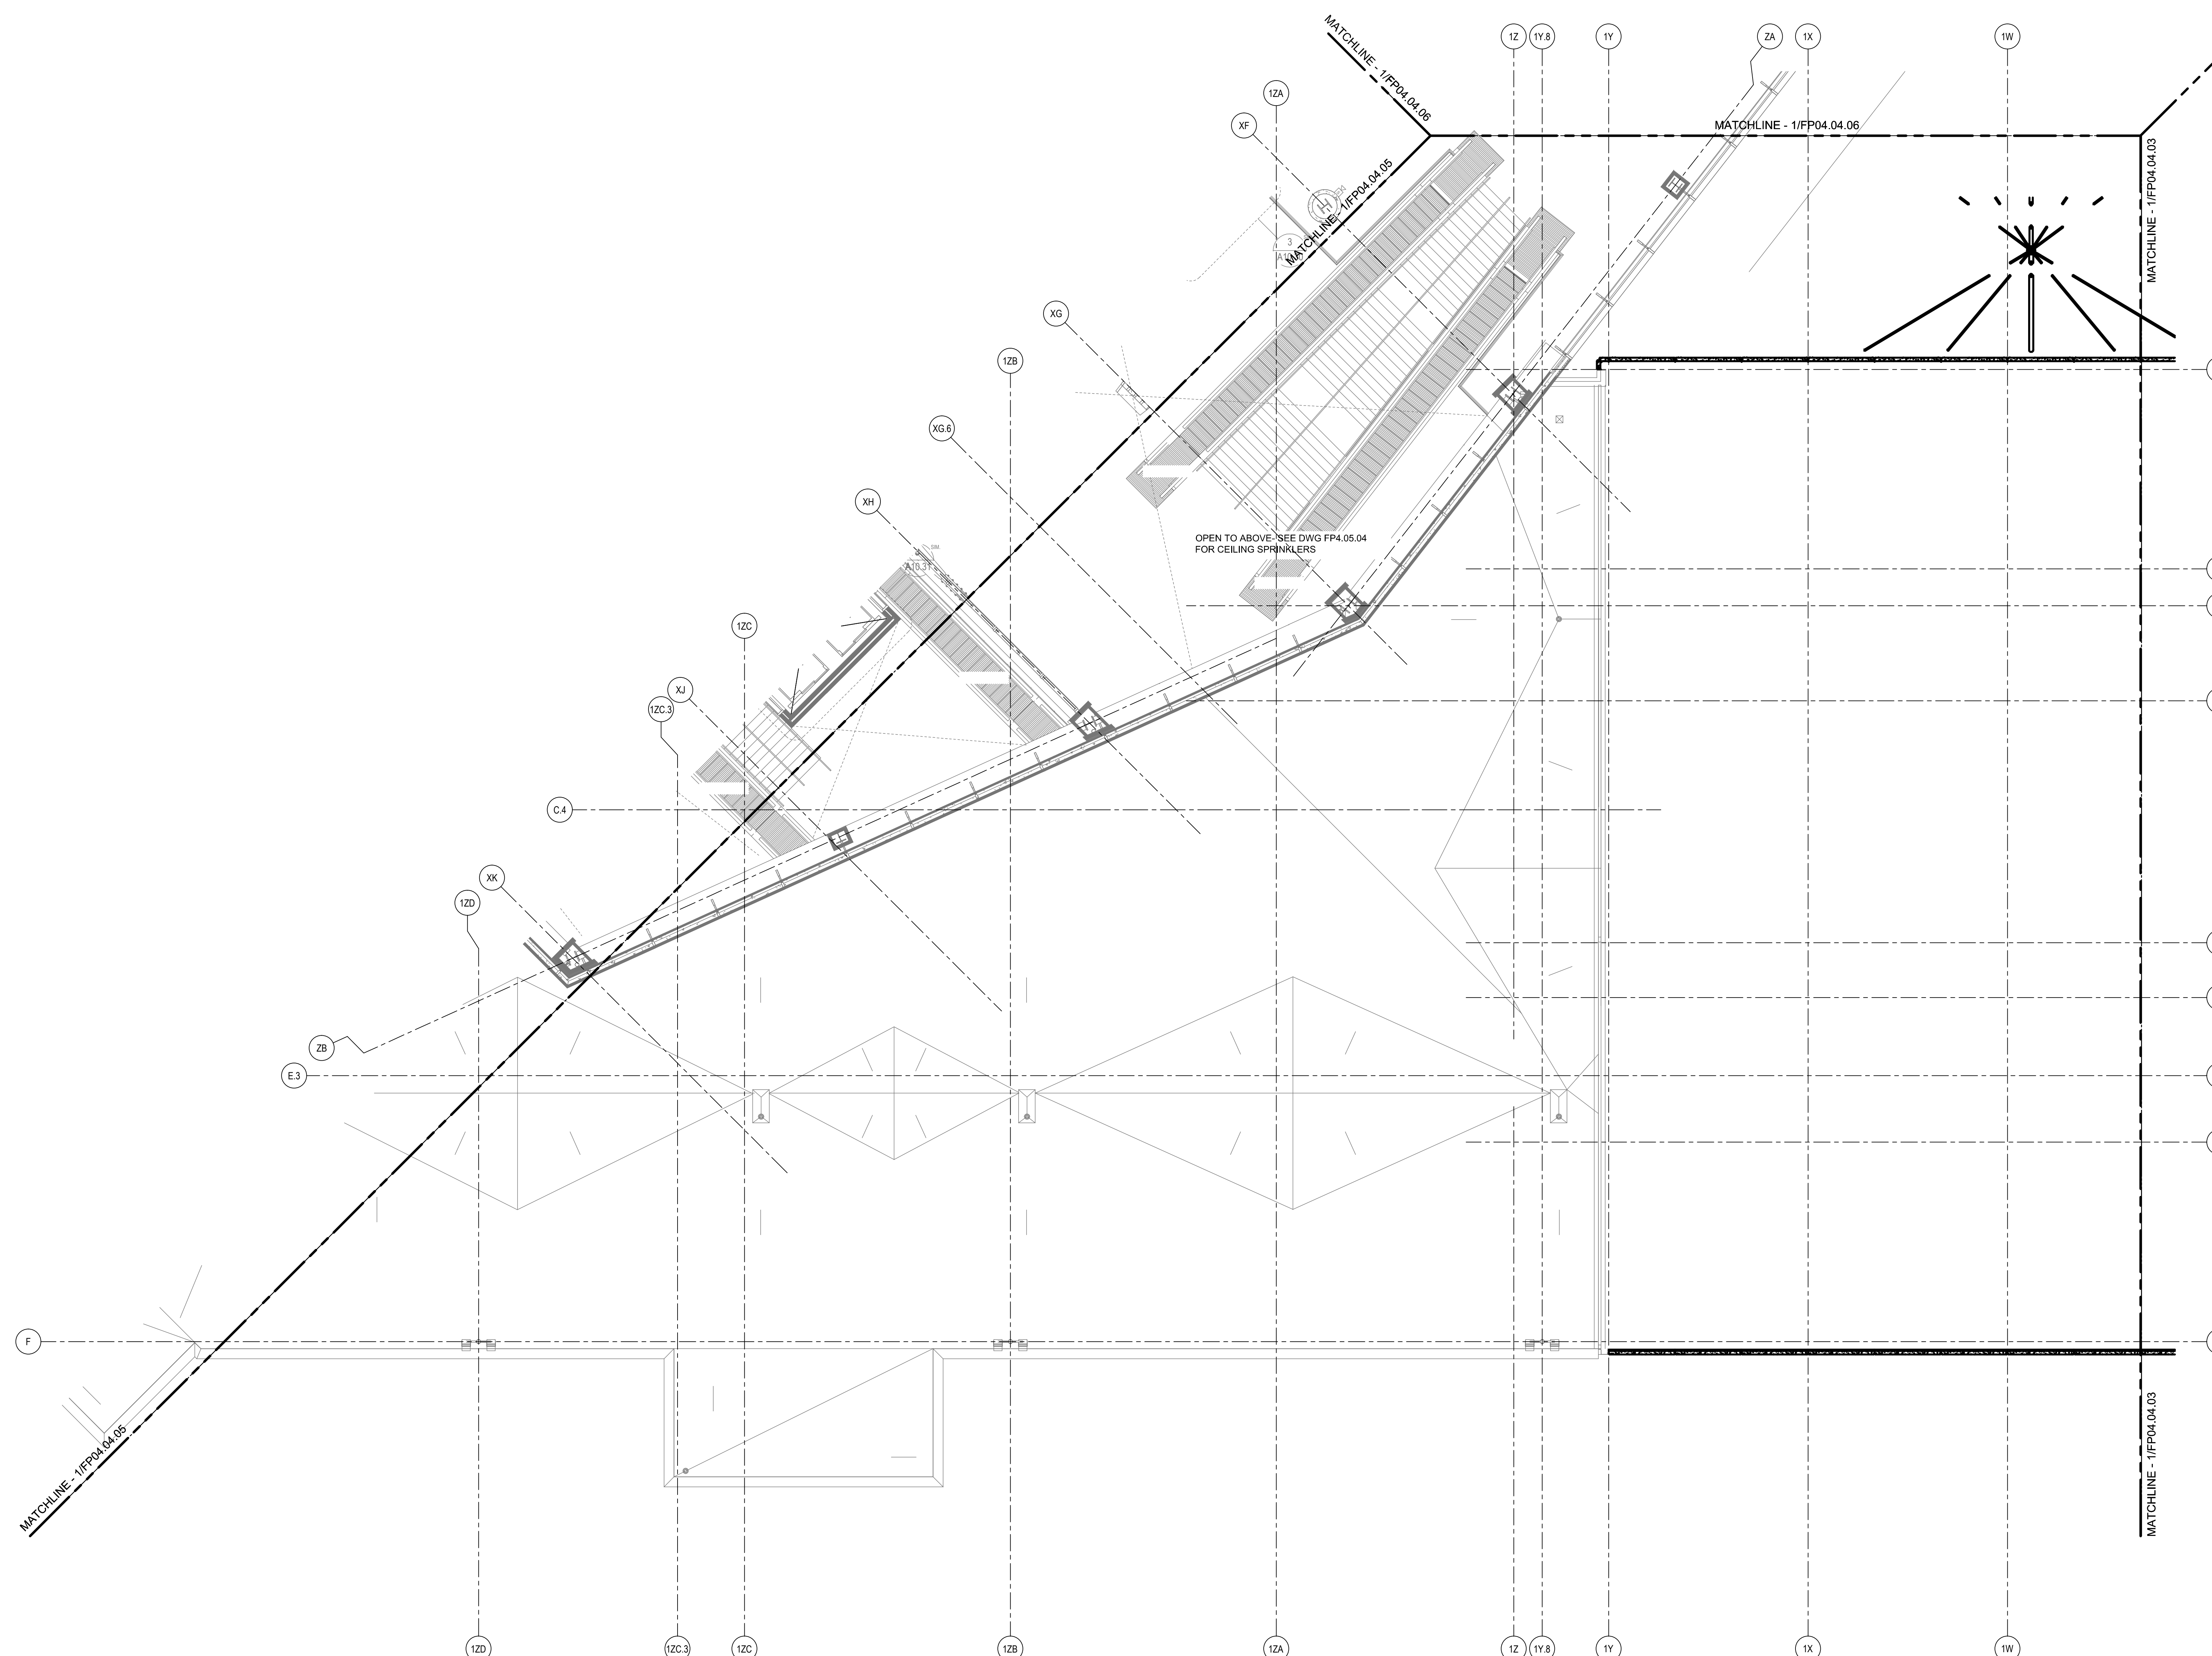

FIRE PROTECTION PLAN - LEVEL 4 - ZONE 4

SCALE: 1/8"=1'-0"