


DEMO KEY NOTES

1. ERECT POLYETHYLENE FACED PARTITION AT PROJECT START
2. REMOVE CURTAINWALL FOR NEW DOOR
3. MODIFY RADIATOR, RE: MECH
4. SALVAGE LIGHTING FIXTURE, RE: ELEC.
5. EXISTING CEILING TO REMAIN/BE RECONFIGURED.
6. PROTECT CEILING ASSEMBLIES TO REMAIN FROM DAMAGE DUE TO CONSTRUCTION ACTIVITY.



GENERAL NOTES

1. SEE SHEET 1.G-001 FOR GENERAL PROJECT NOTES, LEGENDS, AND ABBREVIATIONS.
2. SEE FINISH SCHEDULE FOR CEILING AND CEILING GRID TYPES.
3. EXCEPT WHERE INDICATED, CENTER CEILING GRIDS IN ROOMS. USE HALF TILES OR GREATER AT PERIMETERS WHEN POSSIBLE.
4. ALIGN CEILING ITEMS AS SHOWN, WITH COMMON CENTERLINES TYPICALLY. CENTER ITEMS IN CEILING, OR IN AREAS UNLESS INDICATED OTHERWISE.
5. WHERE TEGULAR OR BEVELED TILE IS USED, PAINT ALL CUT EDGES TO MATCH.
6. WHERE ARCHITECTURAL DRAWINGS DEPICT MECHANICAL OR ELECTRICAL ITEMS OR EQUIPMENT (LIGHTS, DIFFUSERS, ETC.) INSTALLATION OF SUCH ITEMS SHALL BE COORDINATED WITH EACH RESPECTIVE TRADE SUB-CONTRACTORS.
7. SEE MECHANICAL, AND ELECTRICAL DRAWINGS FOR ADDITIONAL INFORMATION.

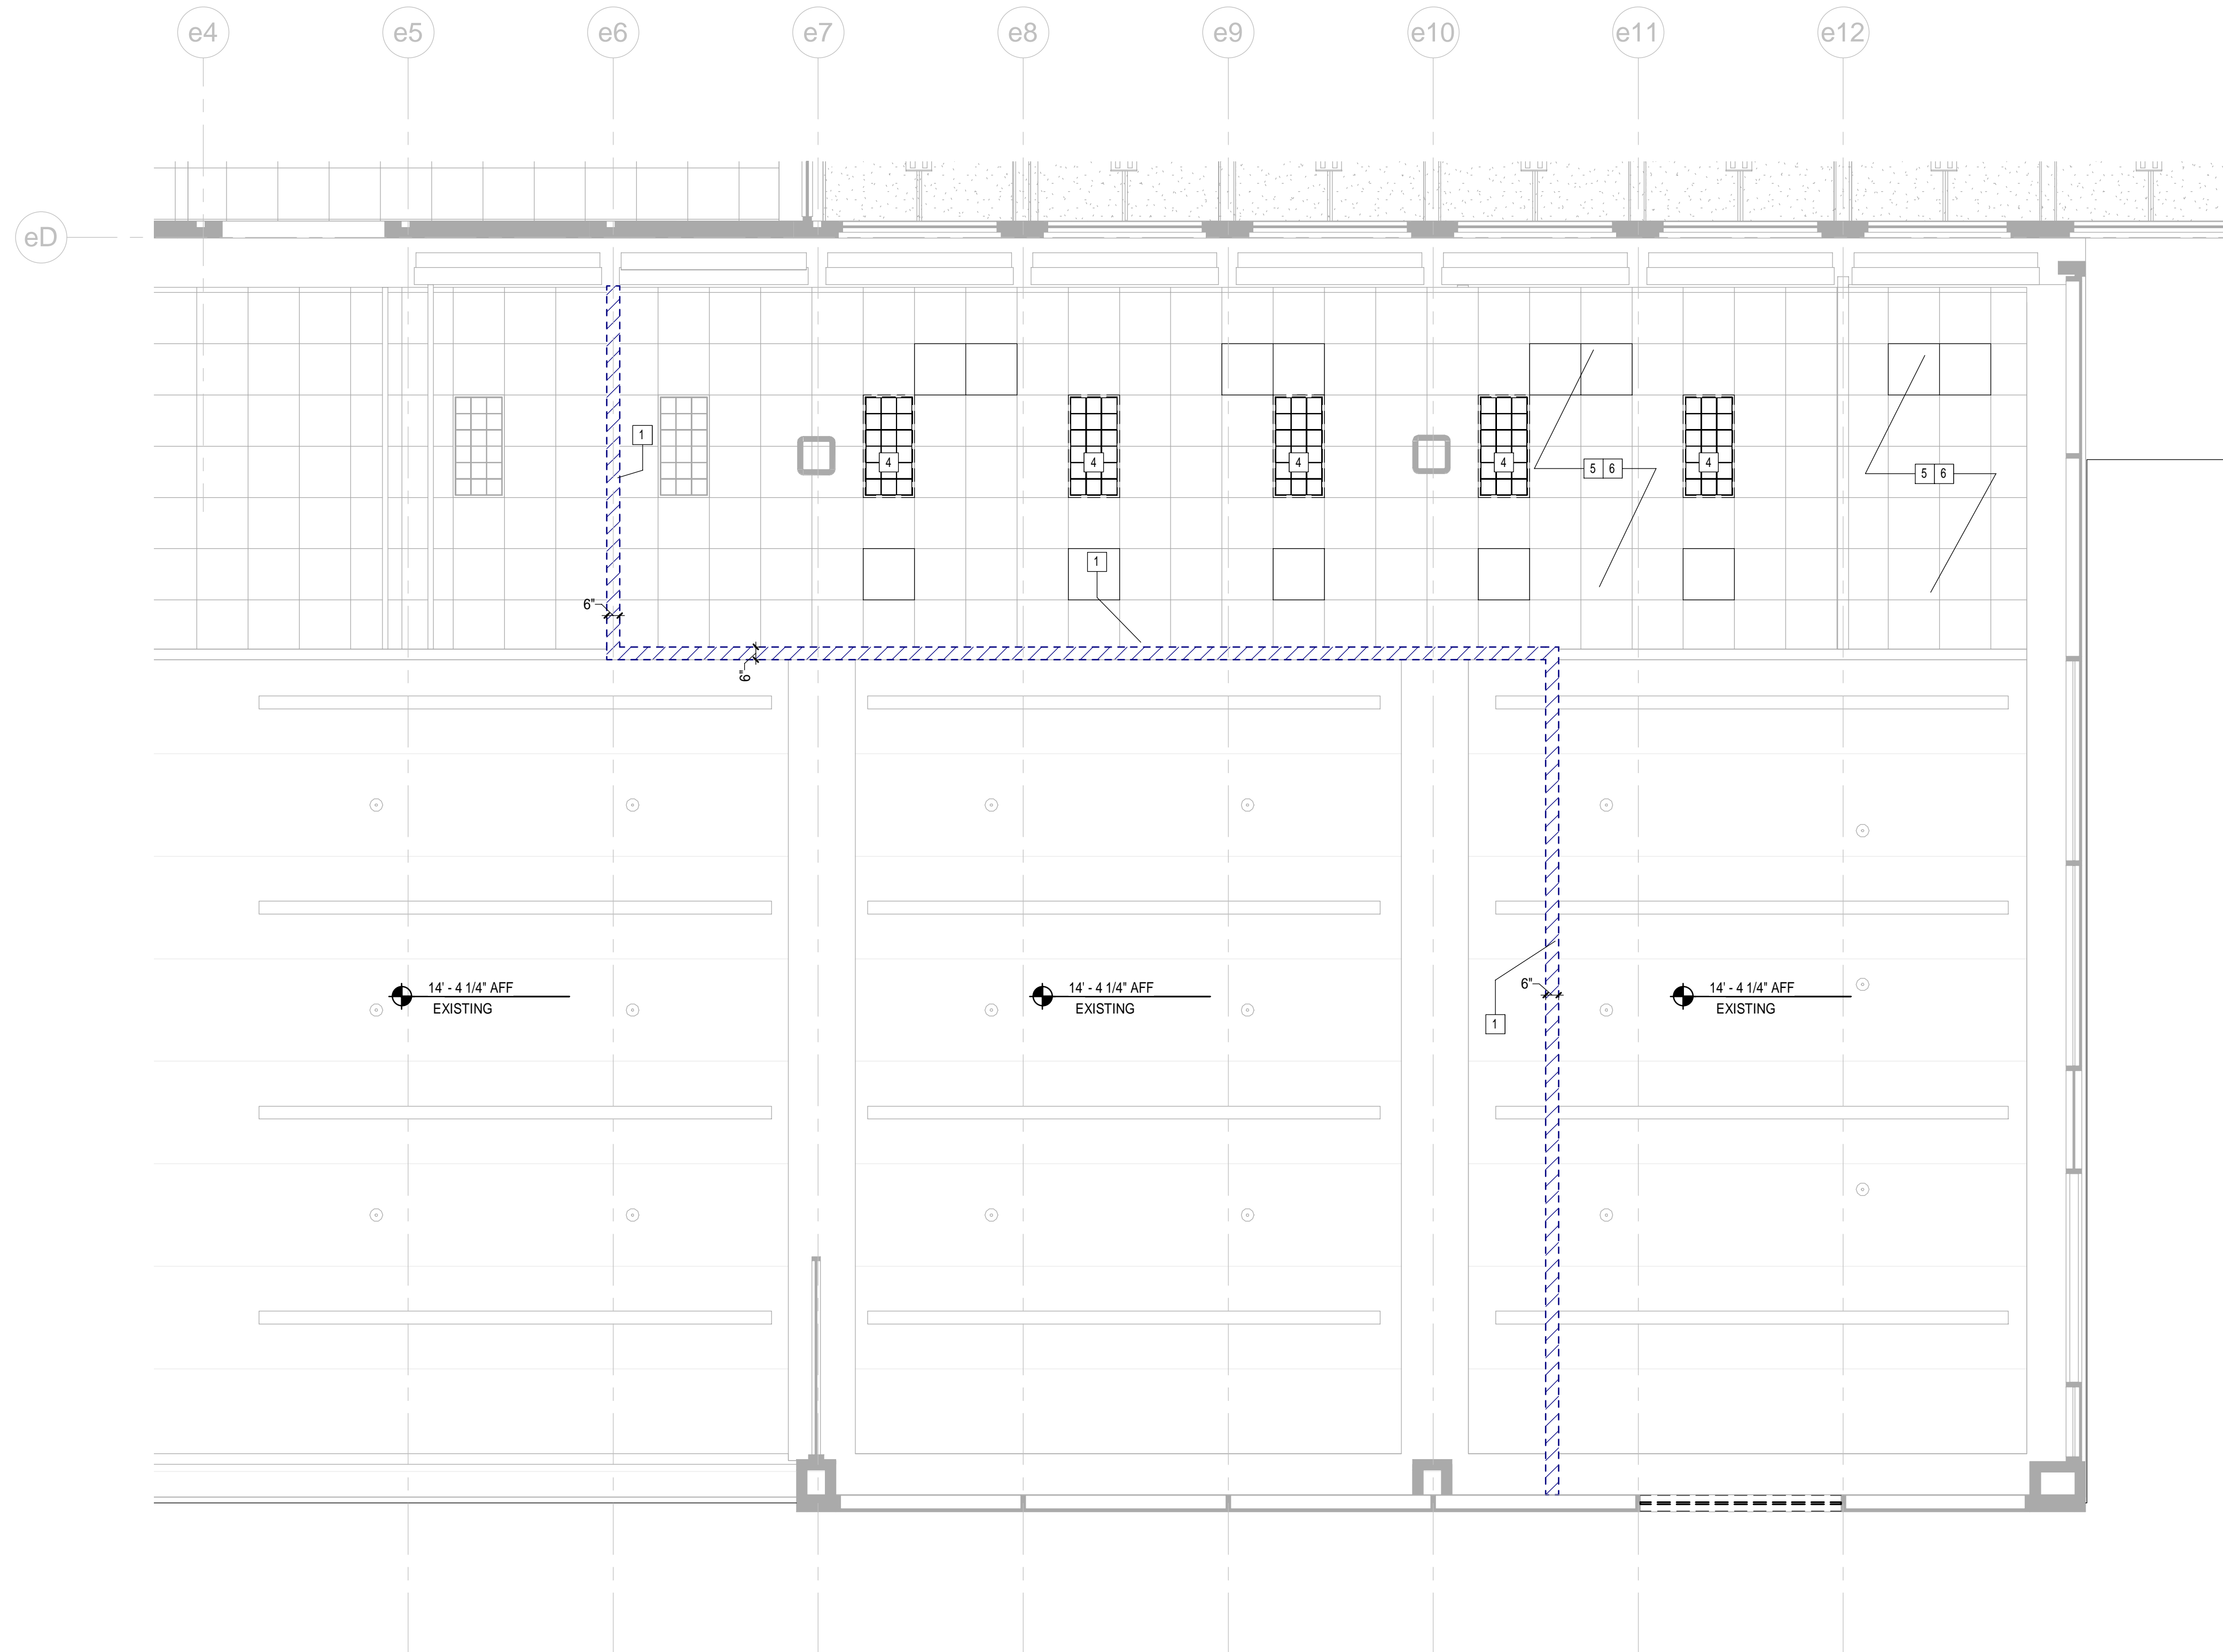


CEILING LEGEND:

- 2x2 CEILING TILE AND GRID
- 2x4 CEILING TILE AND GRID
- GWB CEILING
- DOWN LIGHT
- 2x2 LIGHT FIXTURE
- 2x4 LIGHT FIXTURE
- 1x4 LIGHT FIXTURE
- SUPPLY DIFFUSER
- RETURN DIFFUSER
- EXHAUST DIFFUSER
- LINEAR DIFFUSER

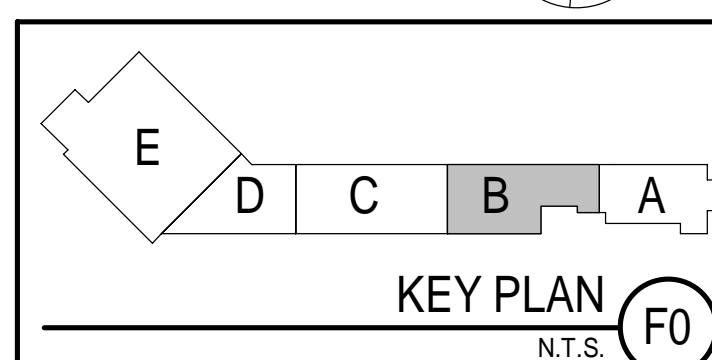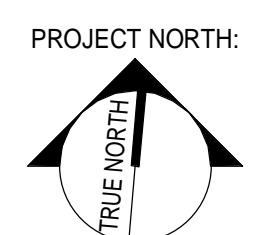

1 2ND FLOOR - 1 DEMO REFLECTED CEILING PLAN
1/4" = 1'-0"

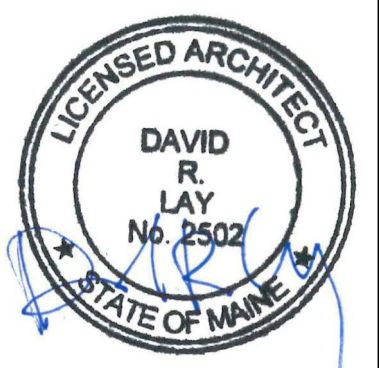

ARCHITECTURE 144 Fore Street P.O. Box 618
Portland, Maine 04104
Tel: (207) 775-3846
Fax: (207) 775-1070
www.smlinc.com

SMART ENERGY INTERIORS

SMRT PROJECT NO. 17033

PROJECT MGR	JCDRAWIN	A/E OF RECORD
Author		Checker
DR		

ISSUED FOR CONSTRUCTION	DATE:	12/21/17
STATUS:	BY:	
REV:	0	

THIS PLAN SHALL NOT BE MODIFIED WITHOUT WRITTEN PERMISSION FROM SEBAGO TECHNICALS, INC. ALL CHANGES SHALL BE AT THE USER'S RISK AND WITHOUT LIABILITY TO SEBAGO TECHNICALS, INC.

SEBAGO TECHNICALS

WWW.SEBAGOTECHNICALS.COM
75 John Roberts Rd., Suite 1A
South Portland, ME 04086
Tel: (207) 783-5660
Fax: (207) 783-5660

PROJECT NO.	DESIGN	CHKD	DRAWN
-------------	--------	------	-------

2ND FLOOR - DEMO REFLECTED CEILING PLAN
OF:
PORTLAND INTERNATIONAL JETPORT GATE UPGRADES
1001 WESTBROOK STREET
PORTLAND, MAINE 04102

DATE	SCALE
12/21/17	As indicated

1.AD122