

**SHEET NOTES**

01 PROVIDE CONVENIENCE LIGHT WITH SWITCH IN THE ESCALATOR UPPER LEVEL MACHINE SPACE. COORDINATE LOCATION AND INSTALLATION WITH THE ESCALATOR CONTRACTOR.

**Portland International Jetport**

1001 Westbrook Street  
Portland, Maine 04102

**Gensler**  
2020 K Street, NW  
Suite 200  
Washington, DC 20006  
Telephone 202.771.5200  
Facsimile 202.872.8587

**oest ASSOCIATES, INC.**  
343 Gorham Road, South Portland, ME 04106  
P: (207) 761-1770 F: (207) 774-1246 www.oest.com  
engineers - architects - surveyors - construction managers

**amec**  
343 Gorham Road, South Portland ME 04106  
P: (207) 761-1770 F: (207) 774-1246 www.amec.com


THESE DRAWINGS ARE ISSUED FOR CONSTRUCTION AND REFLECT ALL AMEC ISSUED BULLETINS AND SKETCHES.

Issue	Date & Issue Description	By	Check	
01	09/22/08	LAM	BHG	
02	12/03/08	LAM	BHG	
03	01/23/09	LAM	BHG	
04	10/26/09	LAM	BHG	
05	11/02/09	LAM	BHG	
02	06	11/12/09	LAM	BHG
03	07	11/20/09	LAM	BHG
04	08	09/01/11	LAM	BHG


**GENERAL NOTES**

A SEE SHEET E00.00 FOR LEGEND AND GENERAL NOTES.

**KEY PLAN**

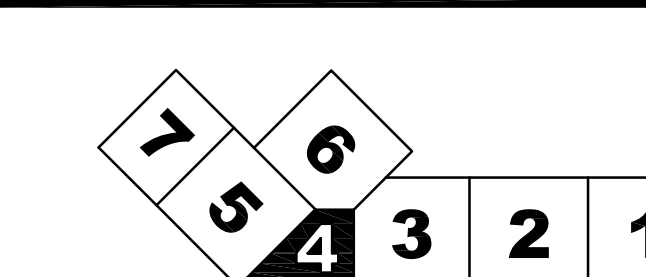

Scale: 1/8" = 1'-0"  
Ref. North  
**E04.03.04**  
©2009 Gensler

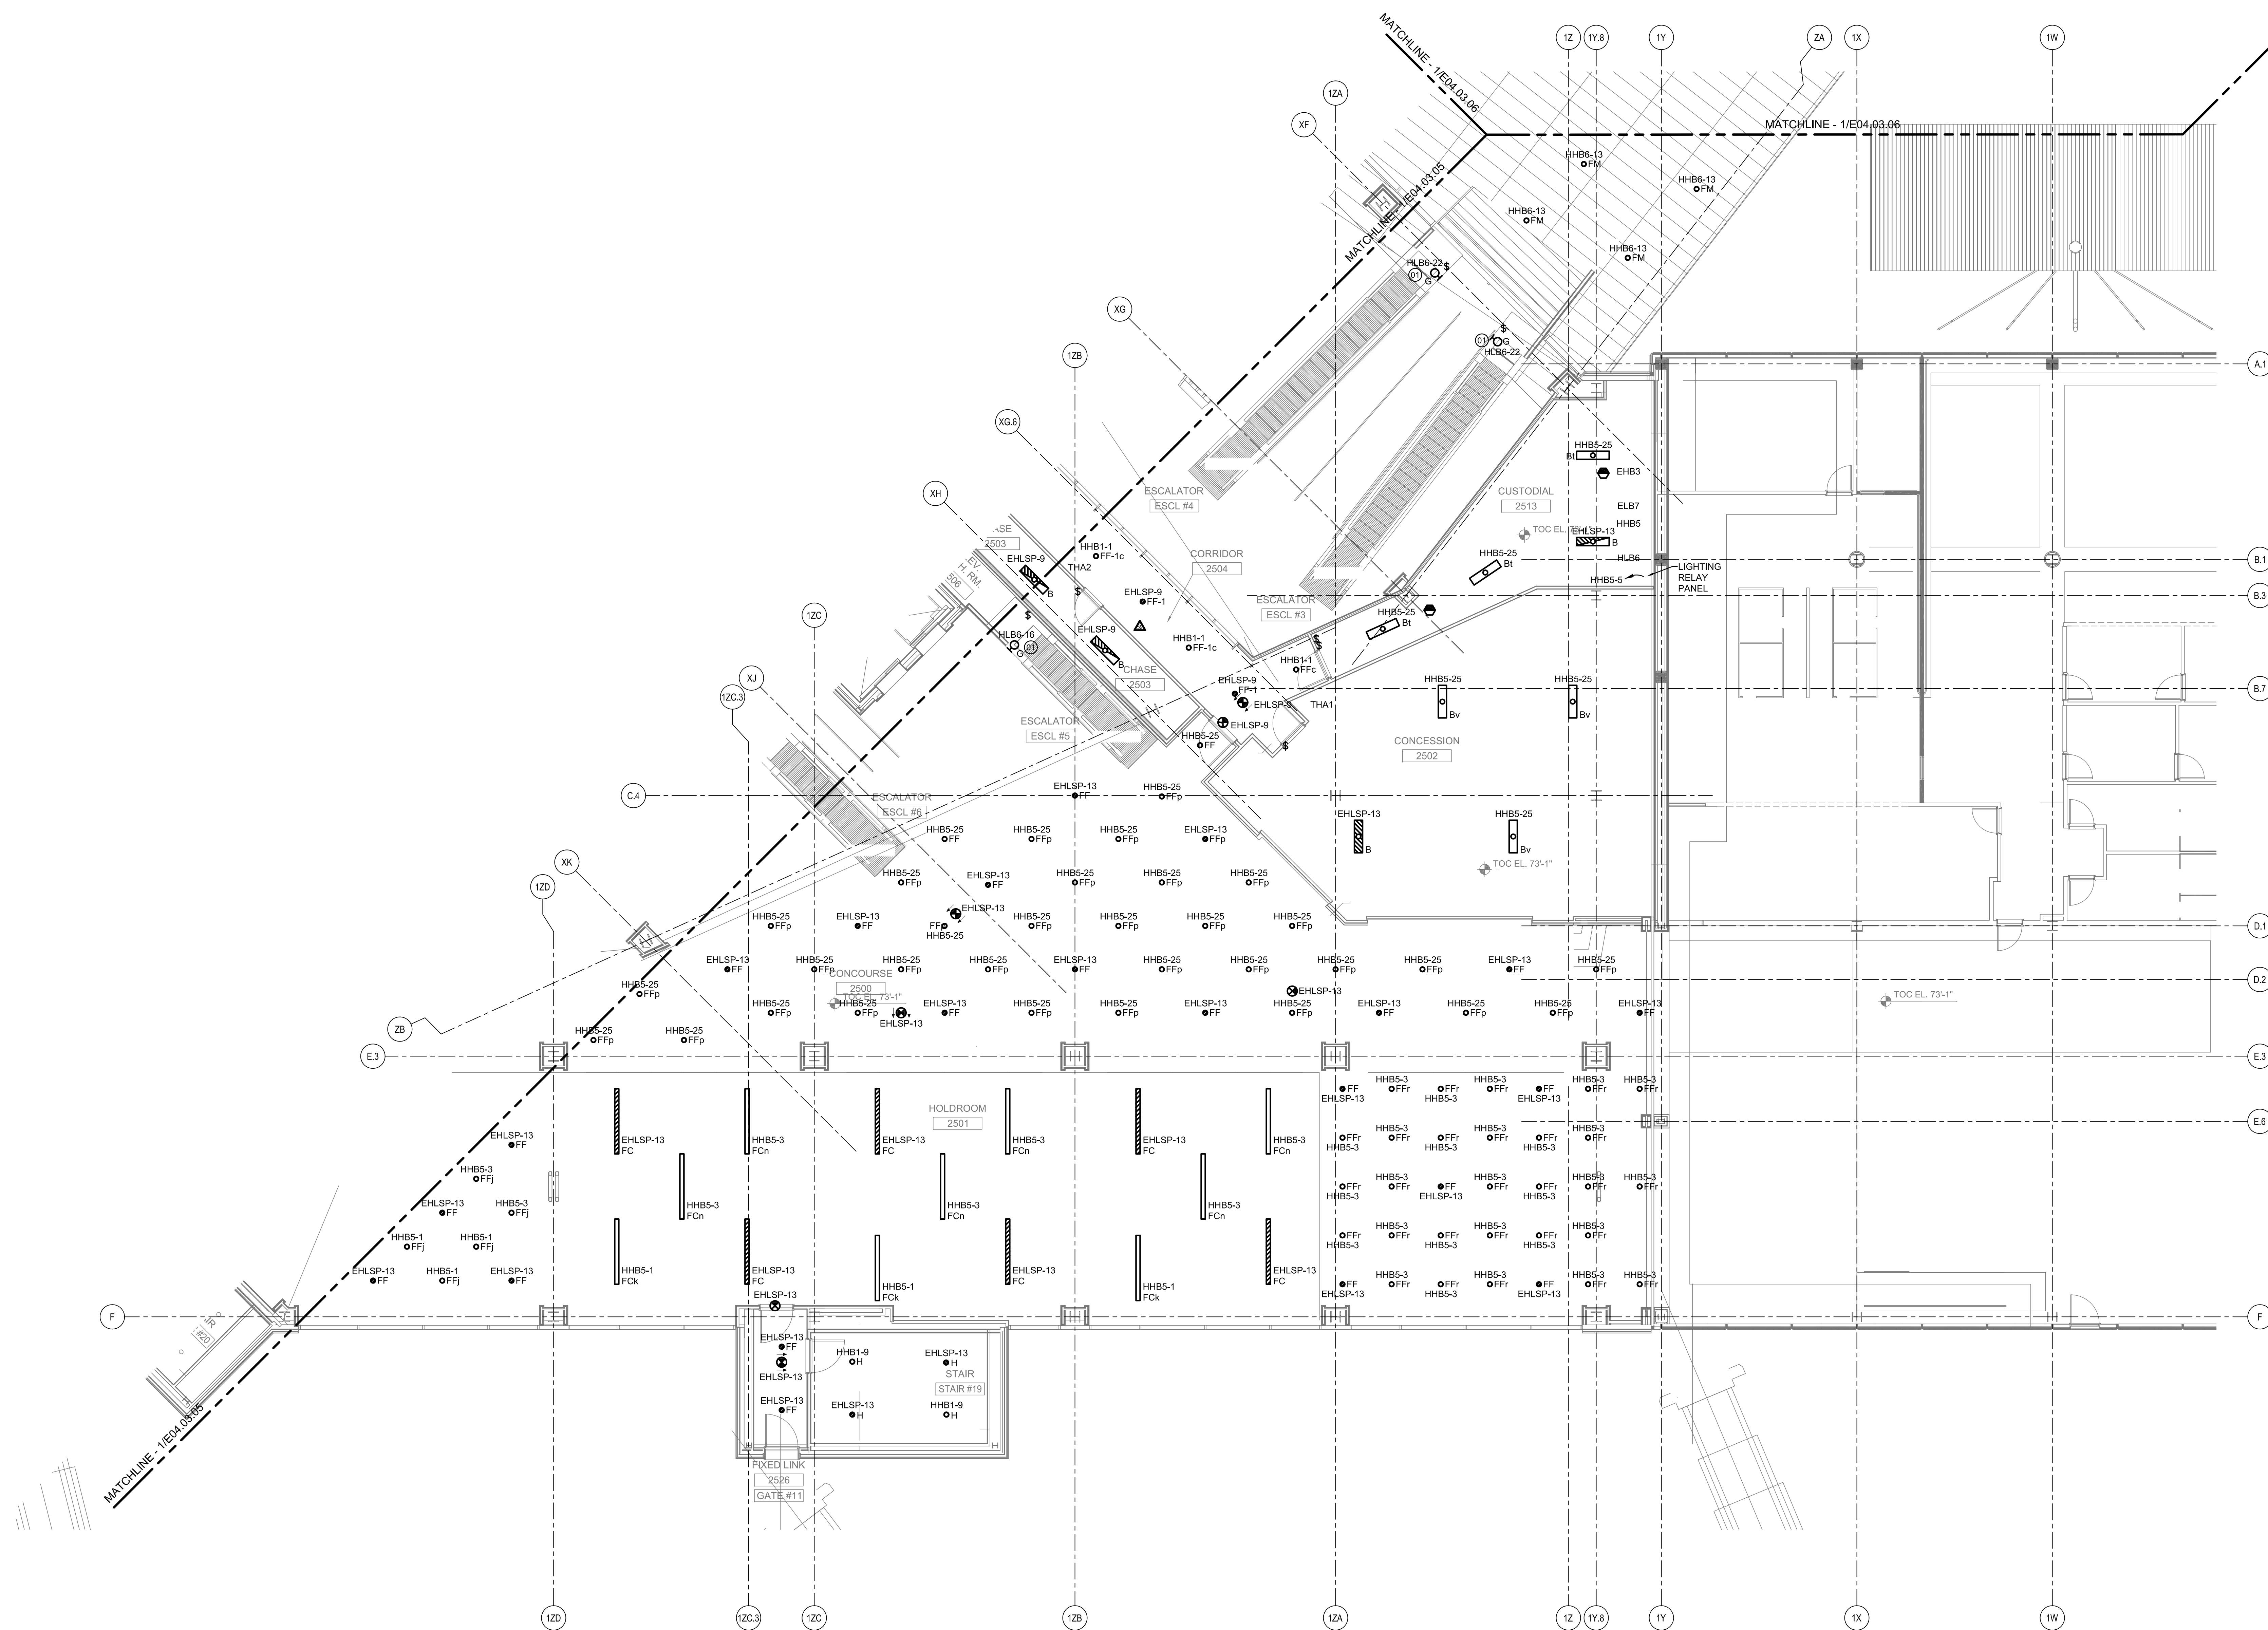

**ELECTRICAL LIGHTING PLAN - LEVEL 3 - ZONE 4**  
SCALE: 1/8" = 1'-0"