

SHEET NOTES

**Portland International
Jetport**
1001 Westbrook Street
Portland, Maine 04102

Gensler
2020 K Street, NW
Suite 200
Washington, DC 20006
Telephone 202.771.5200
Facsimile 202.872.8587

oest ASSOCIATES, INC.
363 Gopher Road, South Portland, ME 04106 P: (207) 764-1770 F: (207) 774-1246 www.oest.com
engineers - architects - surveyors - construction managers

amec
343 Gorham Road, South Portland ME 04106
P: (207) 761-1770 F: (207) 774-1246 www.amec.com


THESE DRAWINGS ARE ISSUED FOR CONSTRUCTION AND REFLECT ALL AMEC ISSUED BULLETINS AND SKETCHES.

Issue	Date & Issue Description	By	Check
01	12/03/08 LAM	BHG	
02	01/23/09 75% CONSTRUCTION DOCUMENTS	LAM	BHG
	95% CONSTRUCTION DOCUMENTS		
03	10/26/09 ISSUED FOR PERMIT	LAM	BHG
04	11/02/09 ADDENDUM #1	LAM	BHG
02	05 11/13/09 ADDENDUM #2	LAM	BHG
03	06 11/20/09 ADDENDUM #3	LAM	BHG
15	07 09/01/11 ISSUED FOR CONSTRUCTION	LAM	BHG

GENERAL NOTES

A SEE SHEET E00.00 FOR LEGEND AND GENERAL NOTES.


KEY PLAN

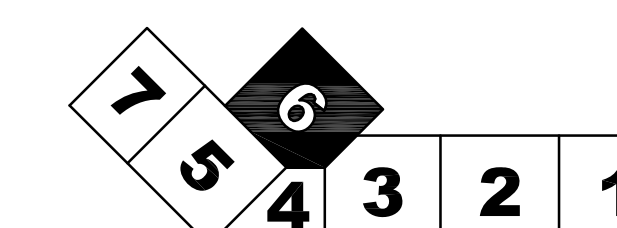

Scale
1/8" = 1'-0"

E04.03.06

©2009 Gensler

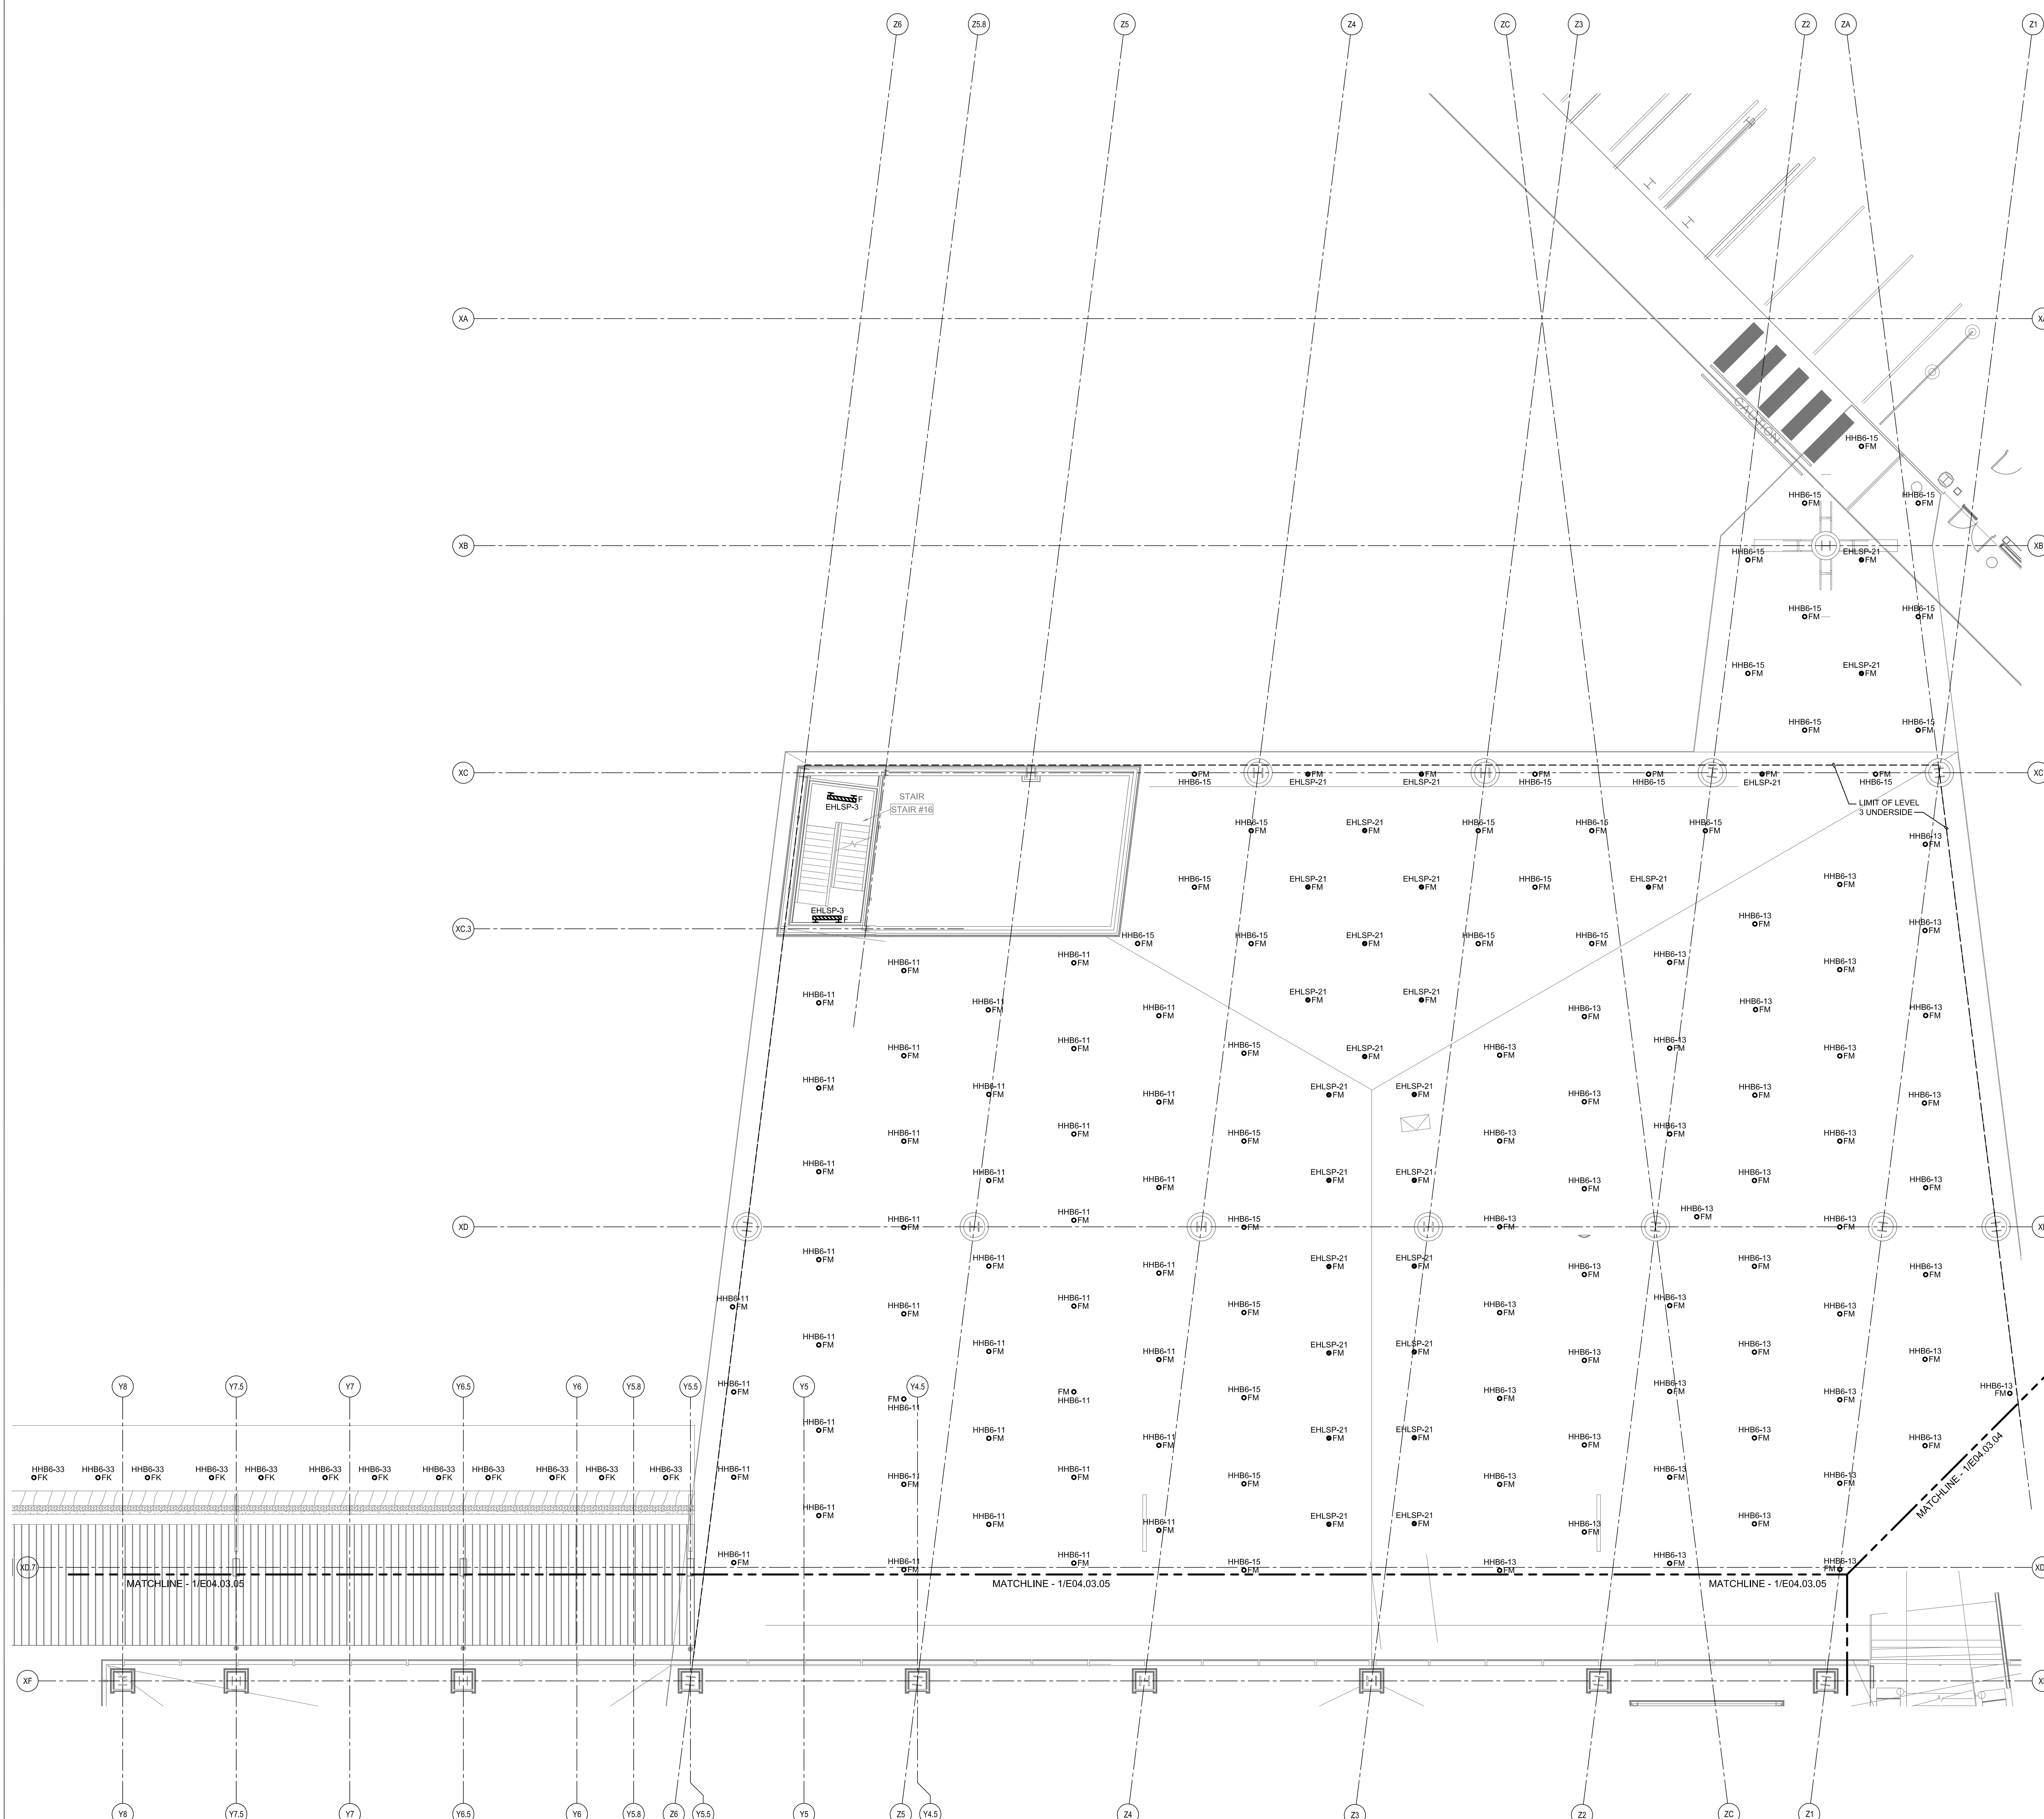

ELECTRICAL LIGHTING PLAN - LEVEL 3 - ZONE 6

SCALE: 1/8" = 1'-0"