

SHEET NOTES

Portland International  
Jetport  
1001 Westbrook Street  
Portland, Maine 04102

**Gensler**  
2020 K Street, NW  
Suite 200  
Washington, DC 20006  
Telephone 202.721.5200  
Facsimile 202.872.8587

**oest ASSOCIATES, INC.**  
363 Gopher Road, South Portland, ME 04106 P: (207) 764-1770 F: (207) 774-5246 www.oest.com  
engineers - architects - surveyors - construction managers

**amec**  
343 Gorham Road, South Portland ME 04106  
P: (207) 761-1770 F: (207) 774-1246 www.amec.com


THESE DRAWINGS ARE ISSUED FOR CONSTRUCTION AND REFLECT ALL AMEC ISSUED BULLETINS AND SKETCHES.

Issue	Date & Issue Description	By	Check
01	09/22/08	LAM	BHG
02	12/03/08	LAM	BHG
03	01/23/09	LAM	BHG
04	10/26/09	LAM	BHG
05	11/02/09	LAM	BHG
02	06/11/12/09	LAM	BHG
03	07/11/20/09	LAM	BHG
06	09/01/11	LAM	BHG

GENERAL NOTES

A SEE SHEET E00.00 FOR LEGEND AND GENERAL NOTES.

Seed/Signature

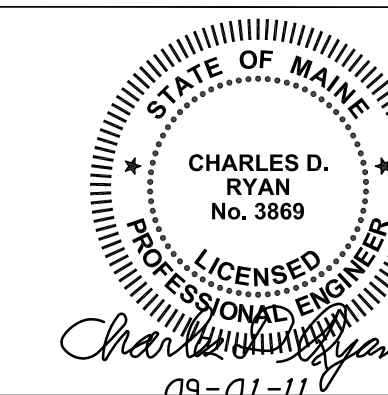

Project Name  
PJM Terminal Enhancement 03-01-11

Project Number  
03-0395-000  
CAD File Name  
C:\AMEC\5330101\E04.05.04.dwg  
Description  
ELECTRICAL LIGHTING PLAN - LEVEL 5 - ZONE 4



Scale  
1/8" = 1'-0"



E04.05.04

©2009 Gensler

KEY PLAN

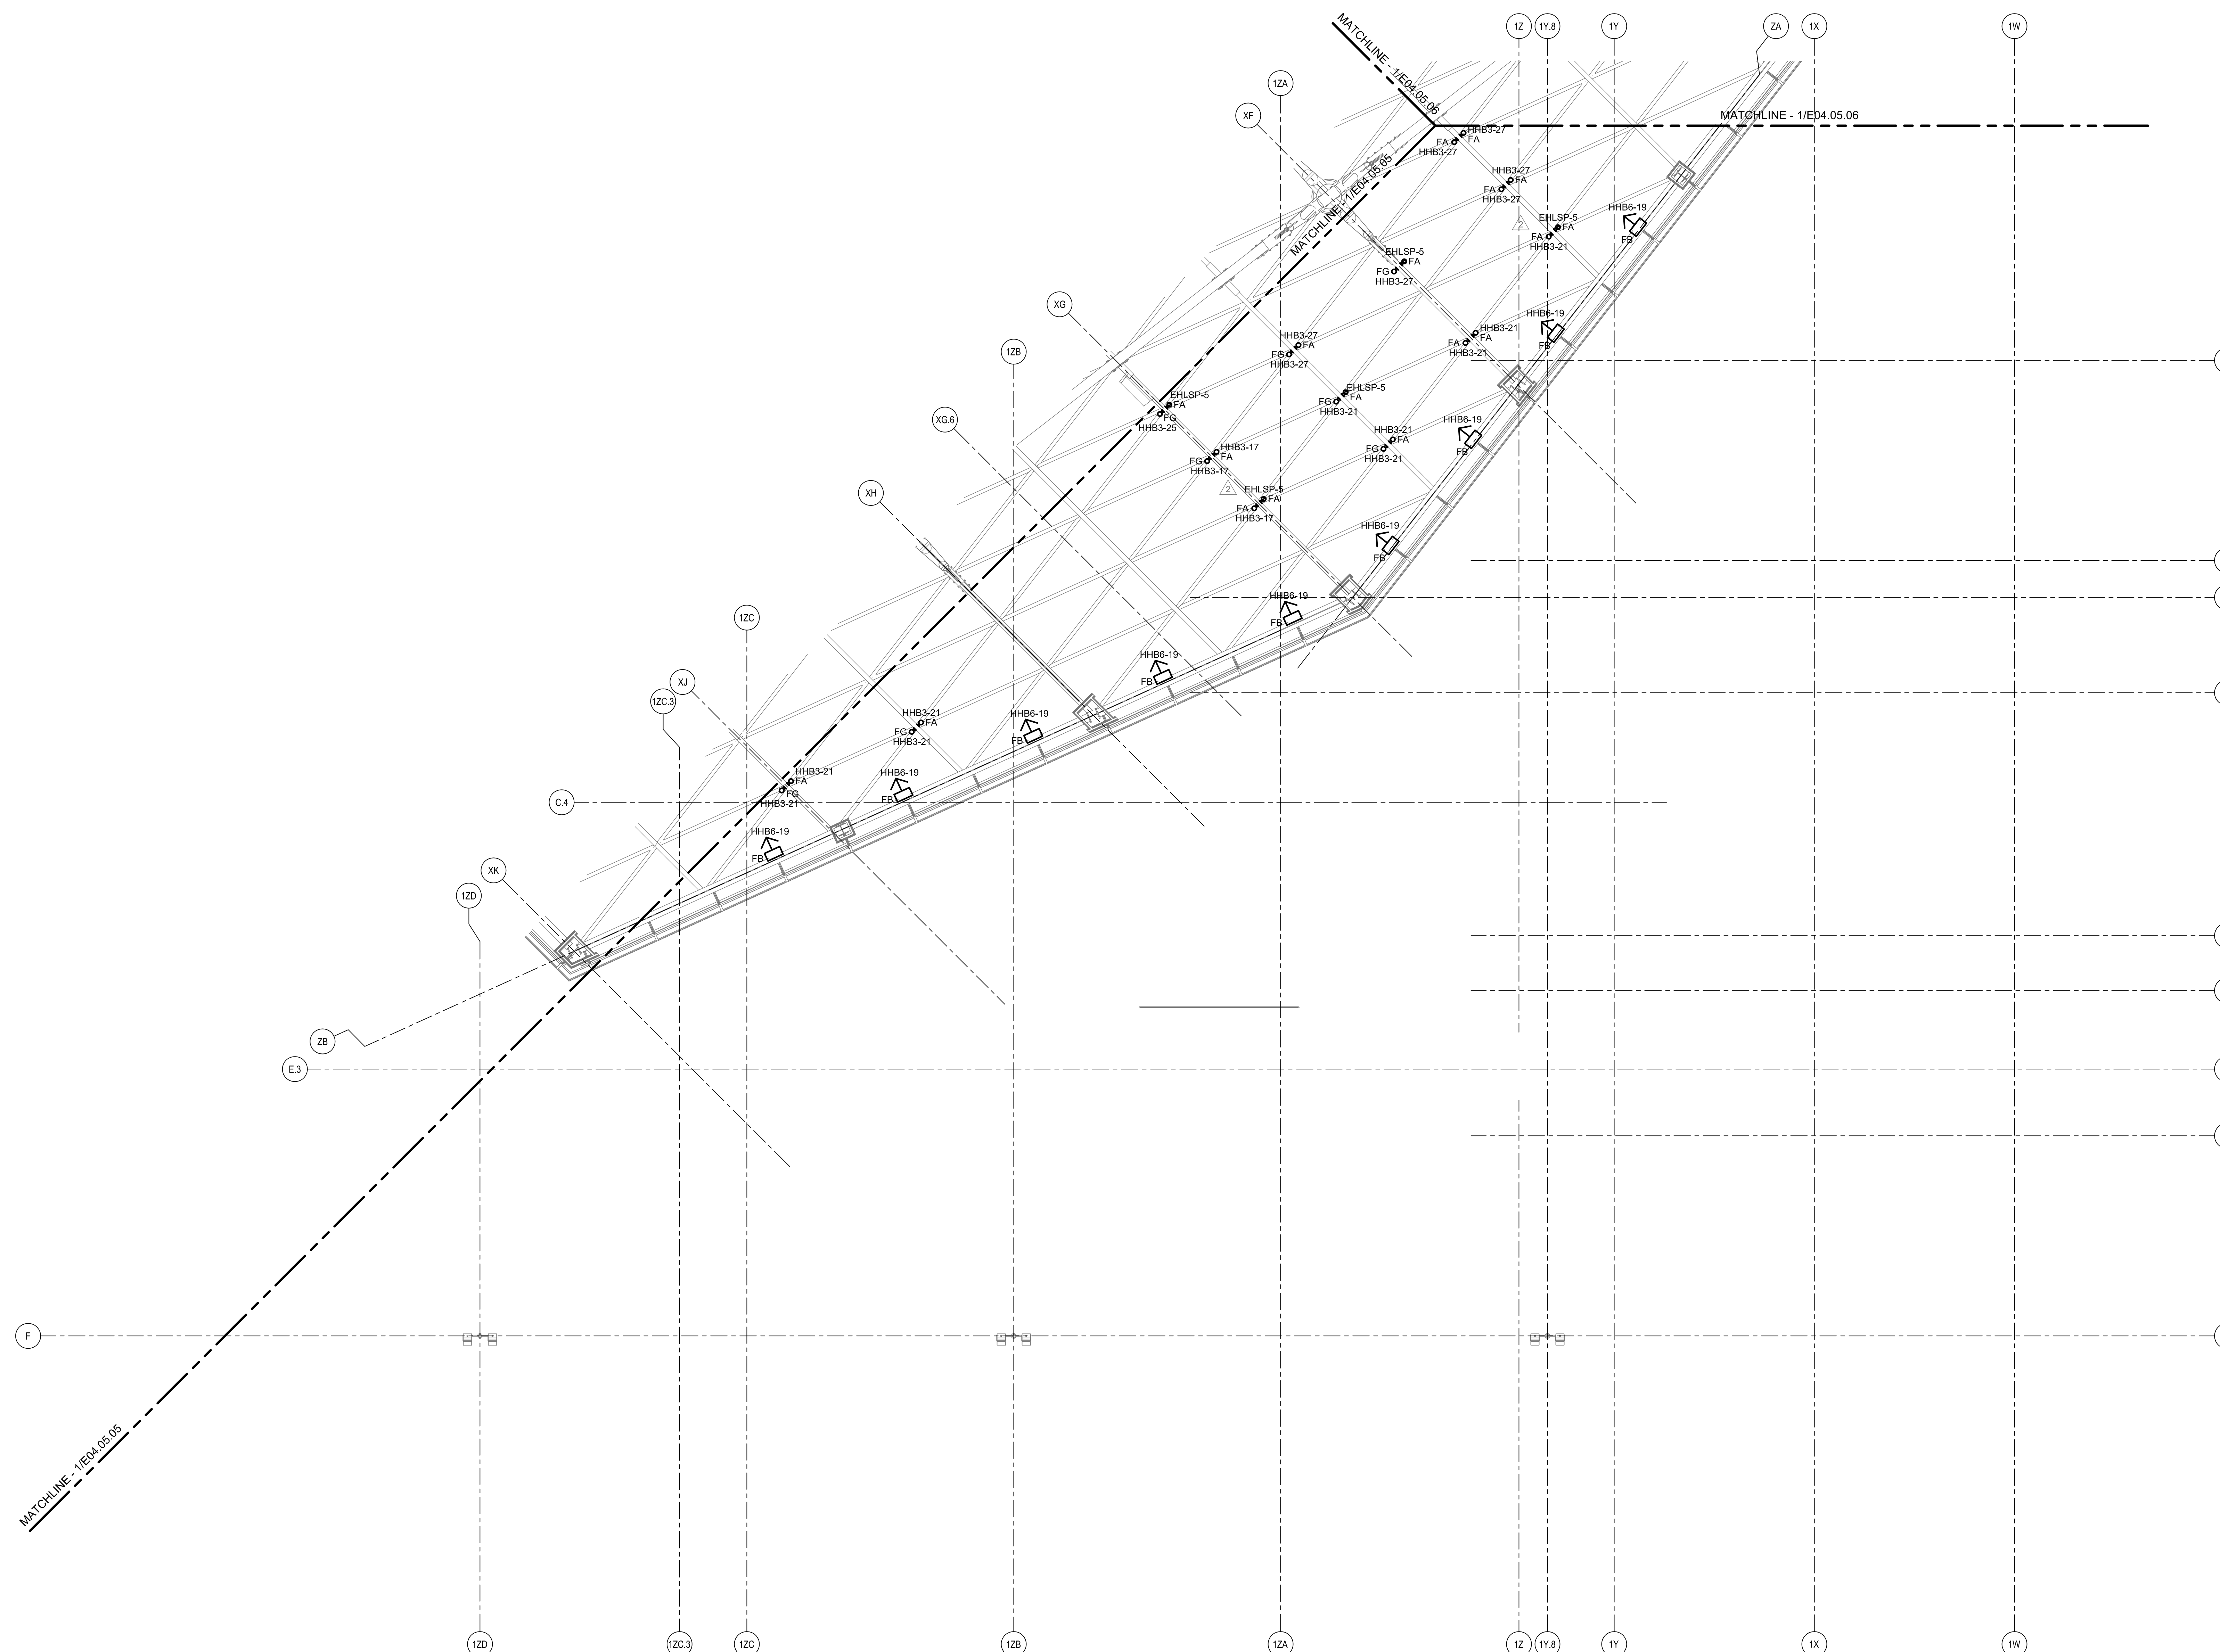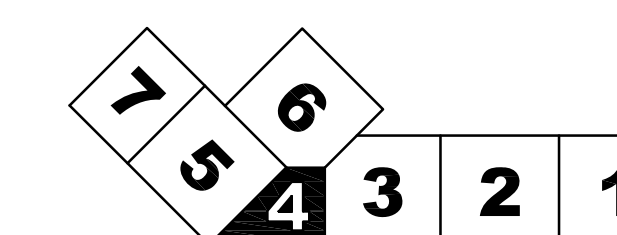

ELECTRICAL LIGHTING PLAN - LEVEL 5 - ZONE 4

SCALE: 1/8" = 1'-0"