

Portland International Jetport
1001 Westbrook Street
Portland, Maine 04102

2020 K Street, NW
Suite 200
Washington, DC 20006
Telephone 202.721.5200
Facsimile 202.872.8587

Gensler

oest ASSOCIATES, INC.
343 Gorham Road, South Portland, ME 04106 P: (207) 761-1770 F: (207) 774-1246 www.oest.com
engineers • architects • surveyors • construction managers

amec
343 Gorham Road, South Portland ME 04106
P: (207) 761-1770 F: (207) 774-1246 www.amec.com

FIRE RISK MANAGEMENT, INC.
1 First Street
Portland, ME 04101
(207) 445-7208
www.firemg.com

SHEET NOTES

01 ALL SPRINKLERS IN EXISTING HOLDROOM AREA MUST BE STANDARD RESPONSE TYPE TO MATCH RESPONSE TYPE OF NEW EXTENDED COVERAGE SPRINKLERS LISTED FOR AN ORDINARY HAZARD OCCUPANCY. REPLACE EXISTING SPRINKLERS.

02 NO SPRINKLER WORK PLANNED IN EXISTING OFFICE/ CONFERENCE AREA NOTED. AREA IS PROVIDED WITH AN EXISTING SPRINKLERS AND PIPING NOT SHOWN BUT TO REMAIN. (EXCEPT AS NOTED ON DRAWINGS)

THESE DRAWINGS ARE ISSUED FOR CONSTRUCTION AND REFLECT ALL FRM ISSUED BULLETINS AND SKETCHES.


Issue	Date & Issue Description	By	Check
01	07/11/08	FWZ	RHB
02	09/22/08	SKD	WMC
03	12/03/08	SKD	WMC
04	01/23/09	MHY	JLD
05	10/26/09	JLD	SKD
02	06/11/12/09	RDV	SKD
145	07/09/01/11	SKD	

ISSUED FOR CONSTRUCTION

GENERAL NOTES

A SEE SHEET FP00.01 FOR LEGEND, SCHEDULES & GENERAL NOTES.

Seal/Signature




Project Name
PJM Terminal Enhancement

Project Number
08.0395.000
CAD File Name
FP04.03.04.dwg
Description
FIRE PROTECTION PLAN - LEVEL 3 - ZONE 4

Scale
1/8" = 1'-0"


Ref. North

KEY PLAN

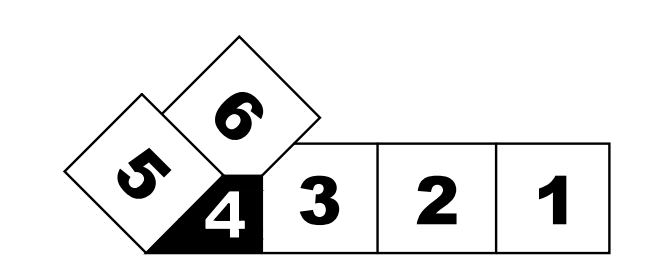

FP04.03.04

©2009 Gensler

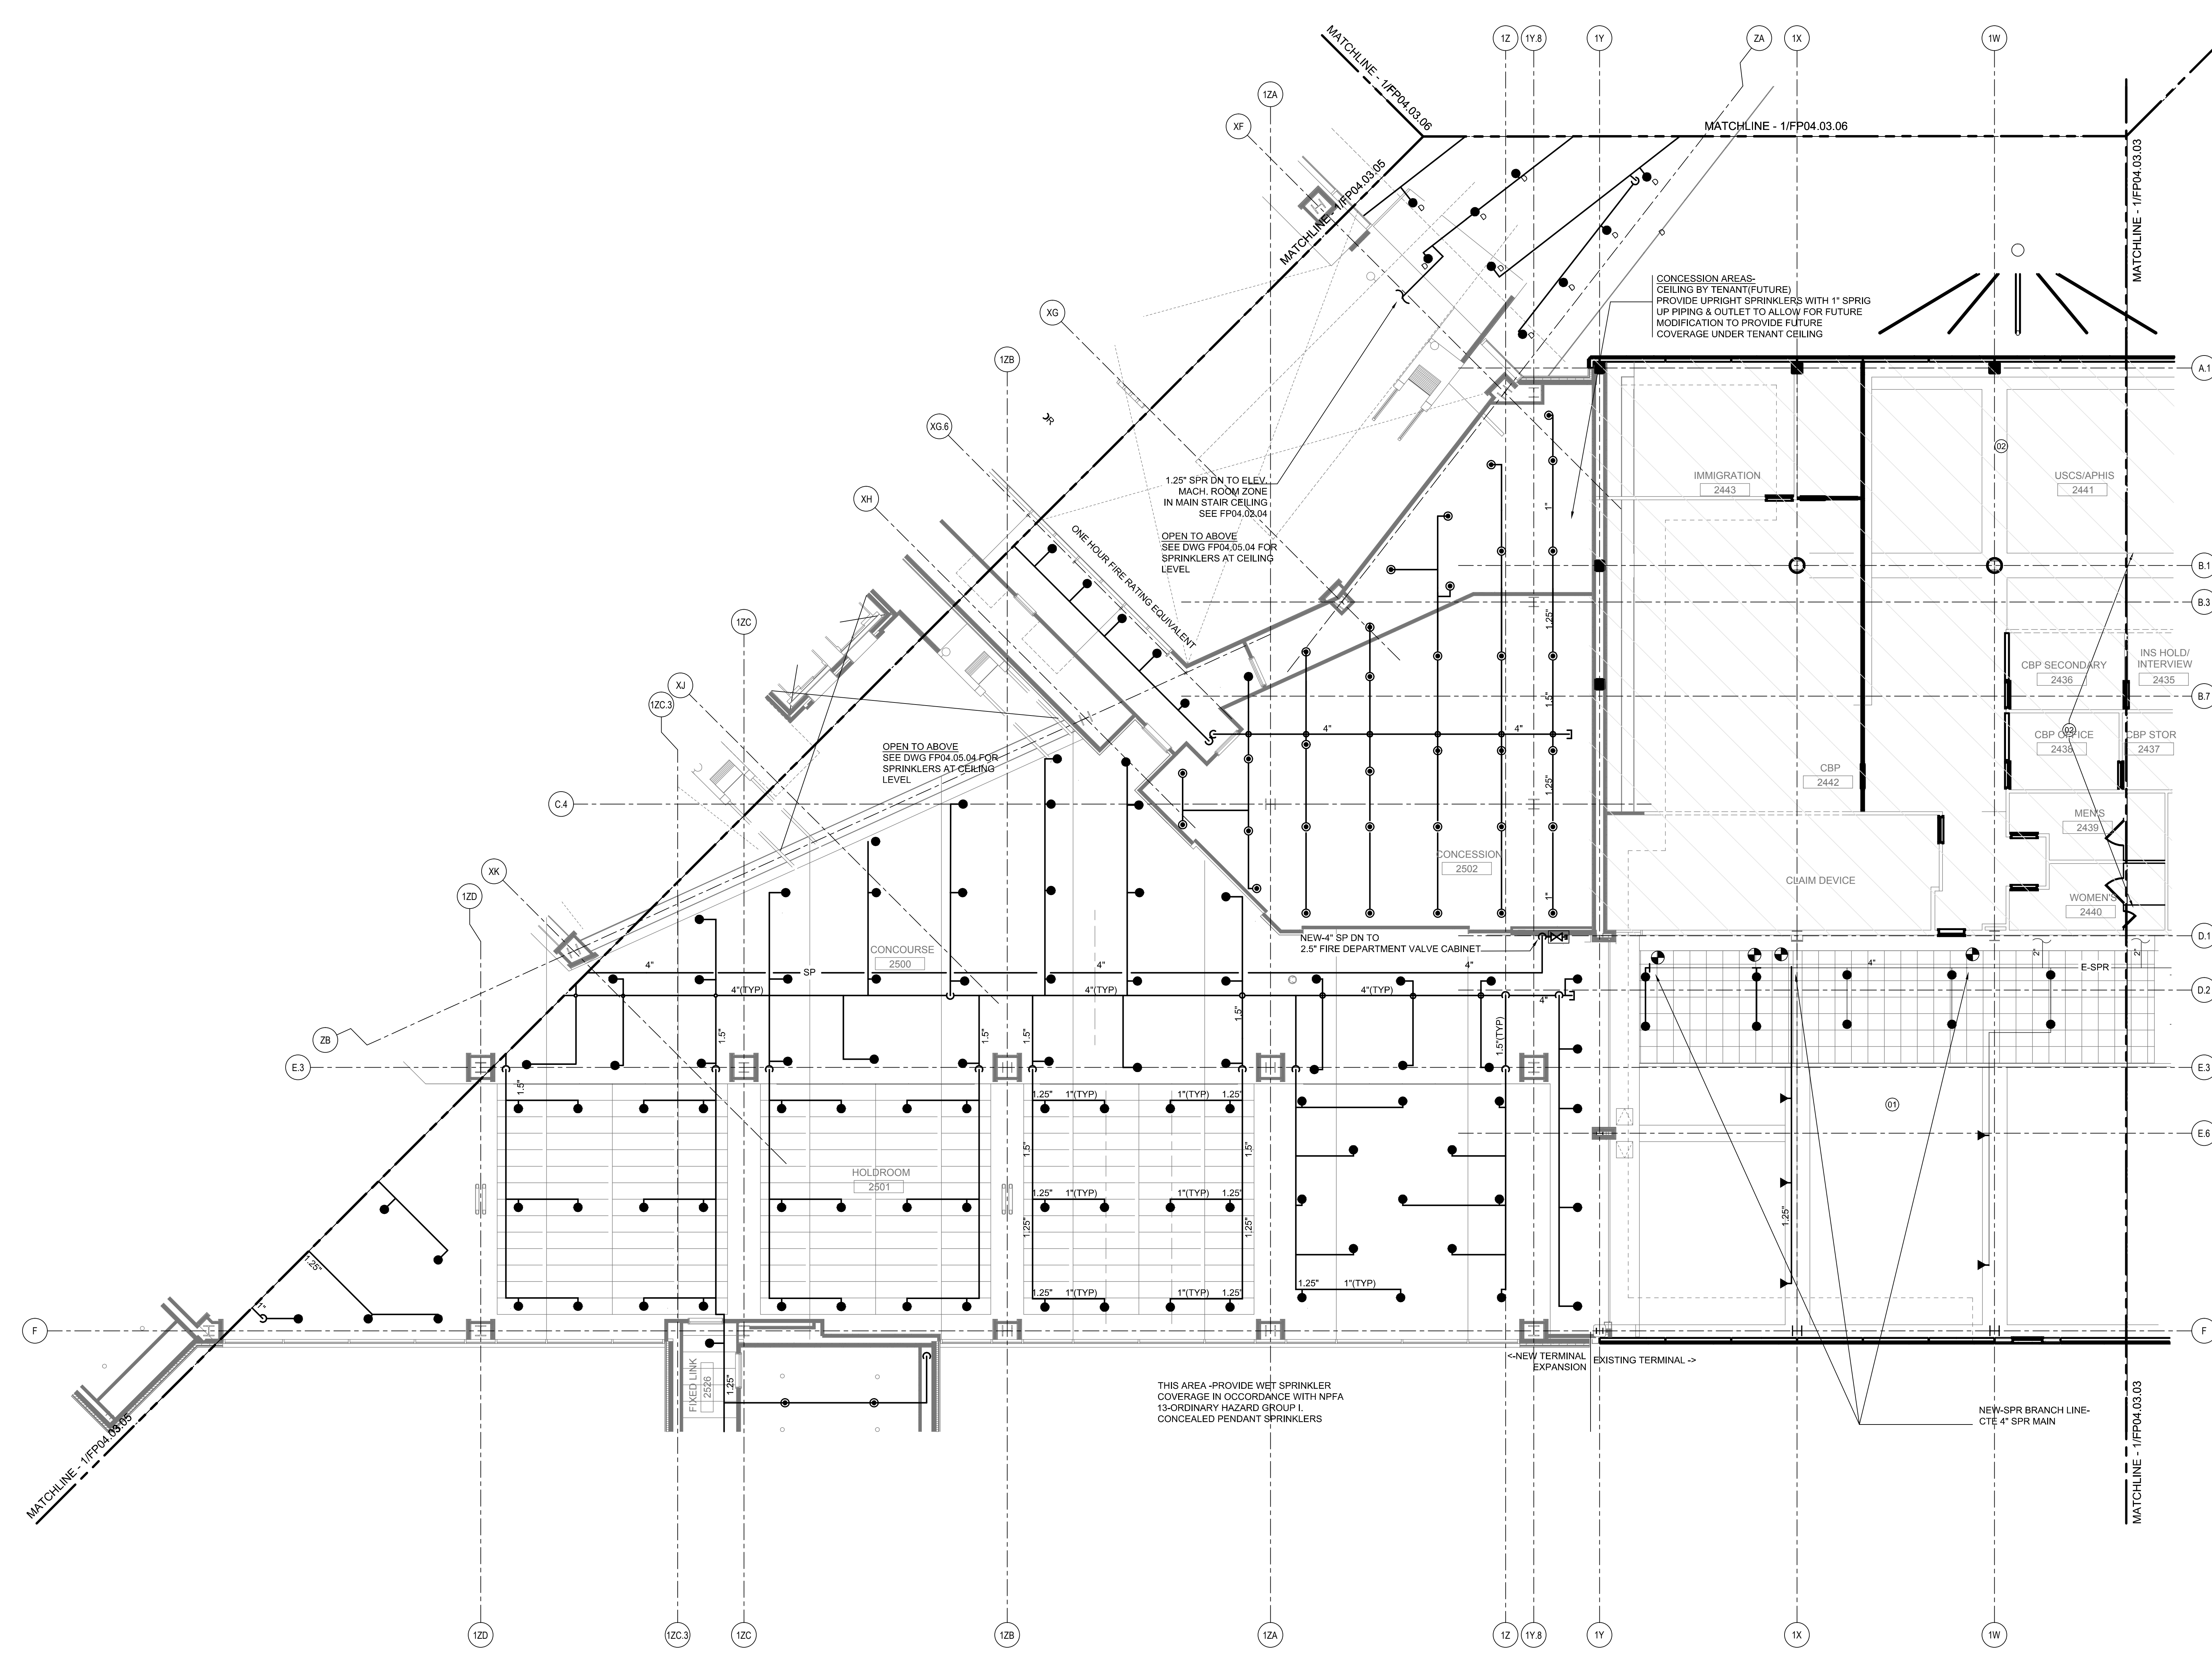

FIRE PROTECTION PLAN - LEVEL 3 - ZONE 4
SCALE: 1/8"=1'-0"