



**DETAIL- MAIN RISER MANIFOLD (MECHANICAL ROOM 3501)**  
SCALE: NTS

1

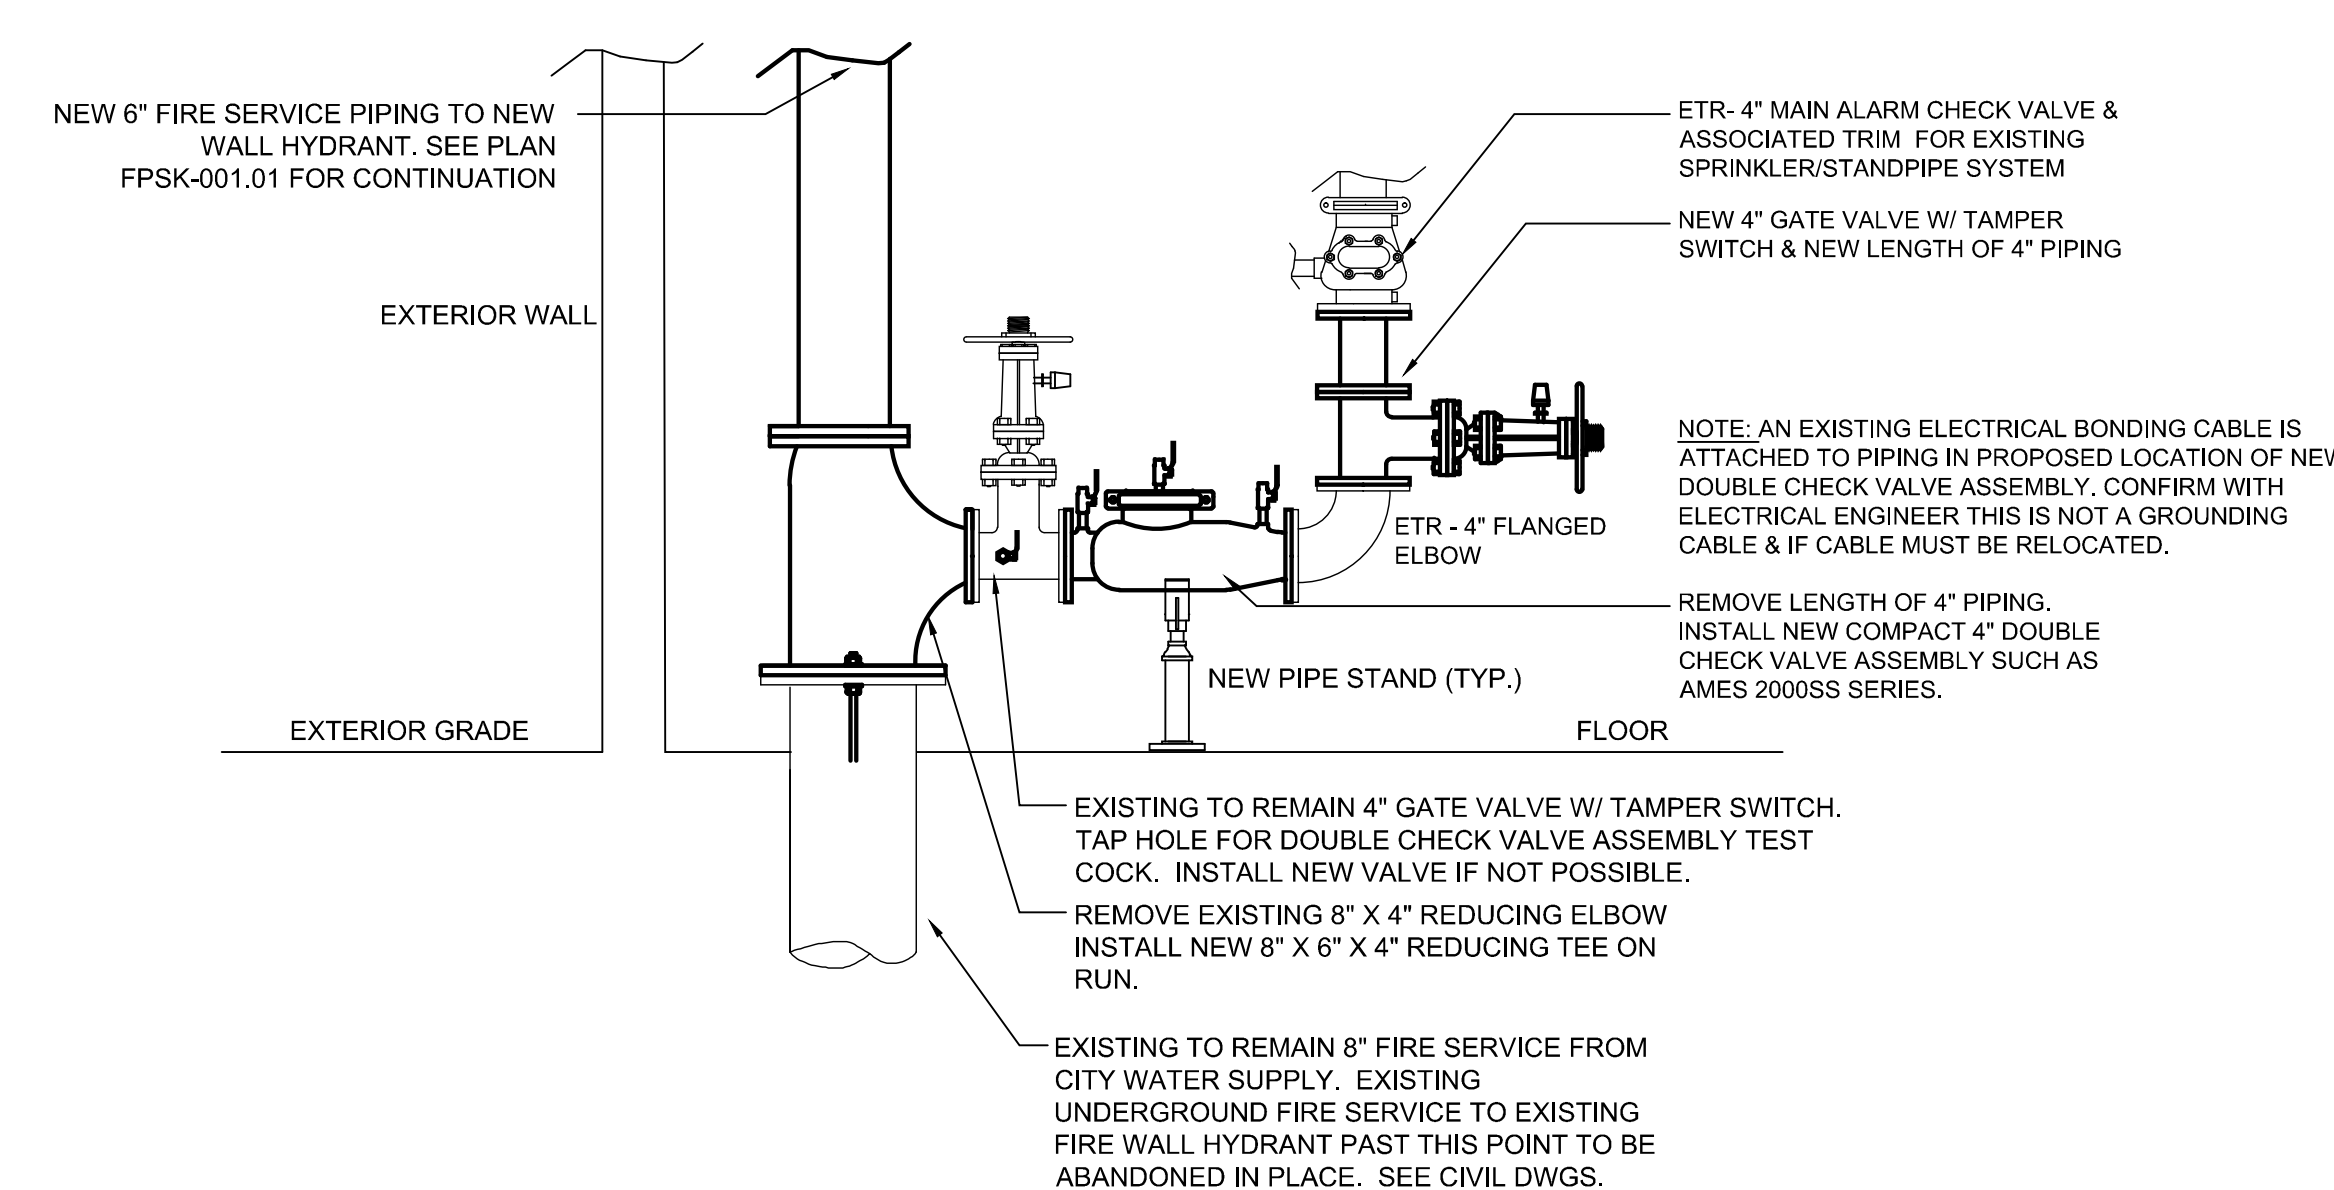

**DETAIL- EXISTING TERMINAL WESTERLY SPRINKLER VALVE ROOM- NEW WORK**  
SCALE: NTS

2

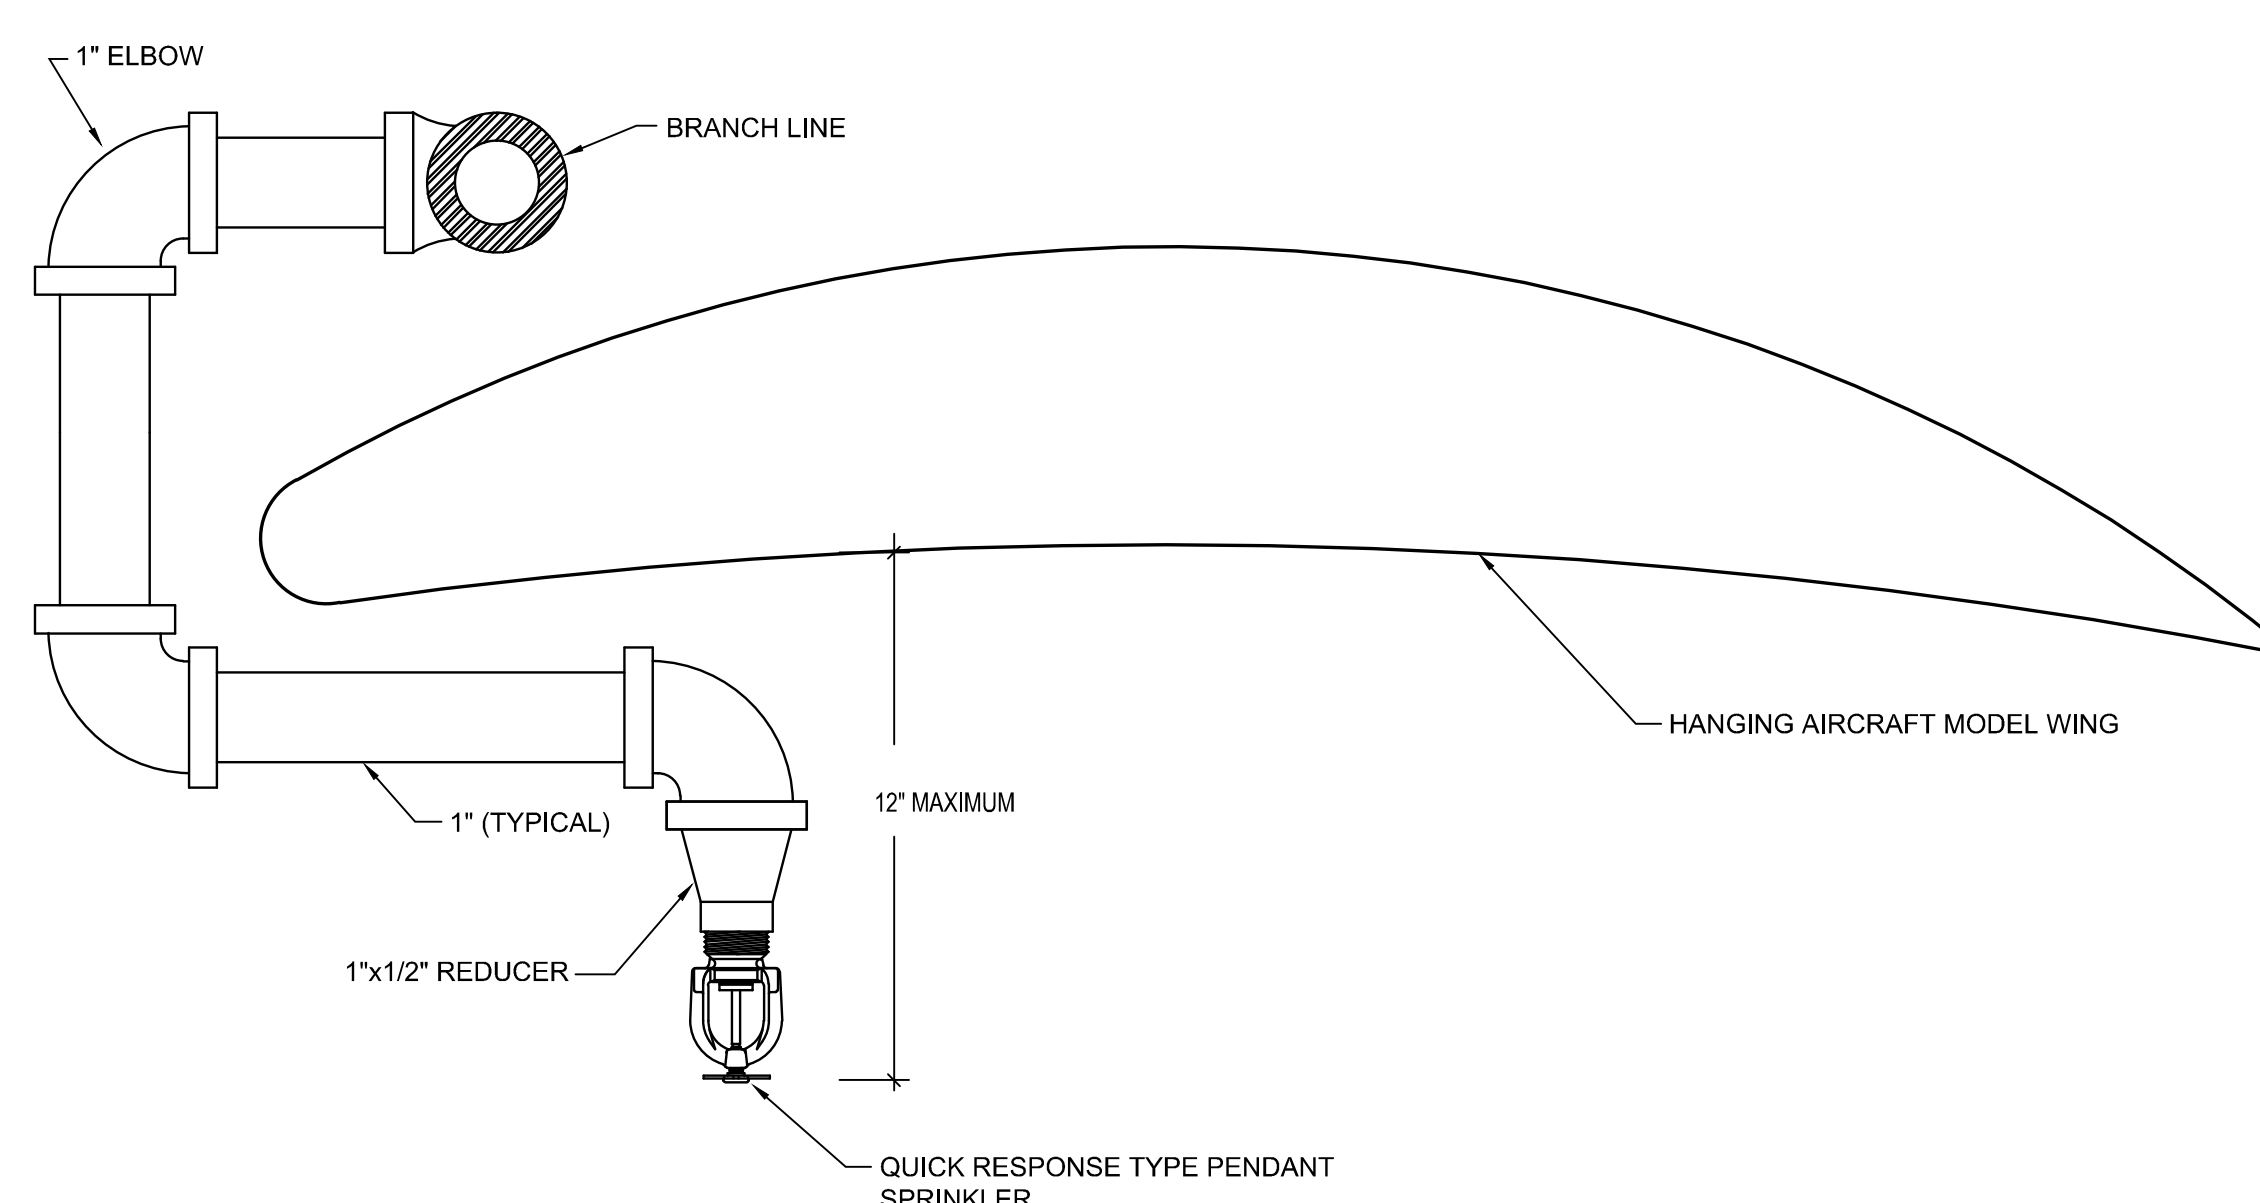

**DETAIL- SPRINKLER "ARM UNDER" CROSS SECTION OF AIRCRAFT WING**  
SCALE: NTS

REFERENCE FROM FP04.05.06

3


**GENERAL NOTES**

A SEE SHEET FP00.01 FOR LEGEND, SCHEDULES & GENERAL NOTES.

THESE DRAWINGS ARE ISSUED FOR CONSTRUCTION AND REFLECT ALL FRM ISSUED BULLETINS AND SKETCHES.

Issue	Date & Issue Description	By	Check
01	12/03/08	SKD	WMC
02	11/23/09	SKD	JLD
03	10/26/09	RDV	SKD
02	04	11/12/09	RDV SKD
18	05	05/03/10	JLD SKD
145	06	09/01/11	SKD

\_\_\_\_\_  
Seal/Signature

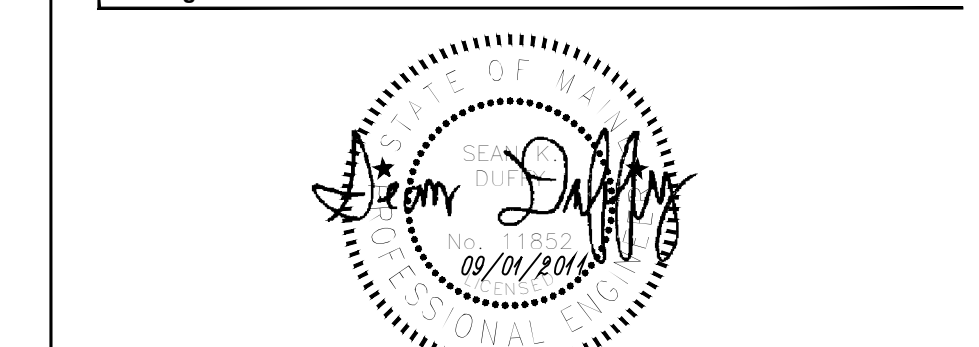

Project Name  
PJM Terminal Enhancement

Project Number  
08.0395.000  
CAD File Name  
FP12.03.dwg  
Description  
FIRE PROTECTION DETAILS & DIAGRAMS

Scale  
AS NOTED

**FP12.03**