

# Portland International Jetport

1001 Westbrook Street  
Portland, Maine 04102

**Gensler**

2020 K Street, NW  
Suite 200  
Washington, DC 20006  
Telephone 202.721.5200  
Facsimile 202.872.8587

**oest ASSOCIATES, INC.**  
343 Gorham Road, South Portland, ME 04106  
P: (207) 761-1770 F: (207) 774-1246 www.oest.com  
engineers • architects • surveyors • construction managers

**amec**  
343 Gorham Road, South Portland ME 04106  
P: (207) 761-1770 F: (207) 774-1246 www.amec.com

## SHEET NOTES

- 01 REMOVE EXISTING RADIANT FLOOR MANIFOLD, PIPE AND CONTROLS.
- 02 REMOVE EXISTING RADIANT FLOOR TUBING FOR ENTIRE FLOOR.
- 03 REMOVE PIPE FROM BRANCH TO RISER AND STOP DEMOLITION AT ELBOW AT BOTTOM OF RISER. PIPE RISERS TO REMAIN.
- 04 REMOVE CABINET UNIT HEATERS AND PIPING.
- 05 REMOVE VAV BOX AND ASSOCIATED DUCTWORK, FITTINGS, HANGERS AND DIFFUSERS.
- 06 REMOVE SWITCH AND CONTROLS.
- 07 CAREFULLY REMOVE EXISTING DDC CONTROL PANEL AND ELECTRICAL BOXES, RELOCATE AS INDICATED ON NEW WORK DRAWINGS.  
NOTE: DDC CONTROLS MUST BE KEPT OPERATIONAL.
- 08 REMOVE MAKEUP AIR UNIT, INCLUDING MAU, DUCTWORK, FITTINGS, HANGERS AND DIFFUSERS. DEMOLISH AND REMOVE WALL LOUVER.
- 09 REMOVE EXHAUST FAN, INCLUDING DUCTWORK, FITTINGS, AND HANGERS. DEMOLISH AND REMOVE WALL LOUVER.
- 10 REMOVE EXIST HWS & HWR UP TO DEMOLISHED FIN TUBE RADIATION ON LEVEL 3.


THESE DRAWINGS ARE ISSUED FOR CONSTRUCTION AND REFLECT ALL AMEC ISSUED BULLETINS AND SKETCHES.

Issue	Date & Issue Description	By	Check
01	01/23/09	PWZ	RHB
02	10/26/09	PWZ	RHB
03	09/01/11	PWZ	RHB

## GENERAL NOTES

- A SEE SHEET M00.00 FOR LEGEND AND GENERAL NOTES.
- B CONTRACTOR SHALL FIELD VERIFY EXISTING DUCTWORK & PIPING PRIOR TO DEMOLITION.

## KEY PLAN

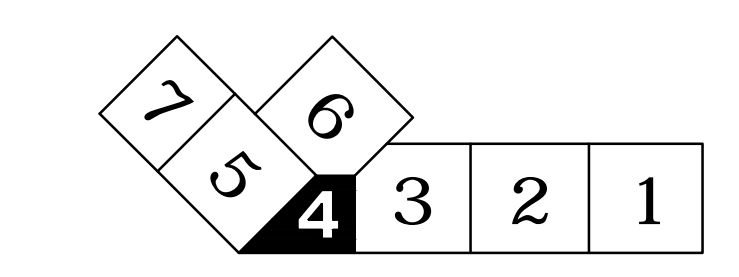


Seal/Signature  
  
 Project Name: PWM Terminal Enhancement  
 Date: 09/01/11

Project Number: 08.0395.000  
 CAD File Name: T:\5330101\Sheets\M01.02.04.dwg  
 Description: MECHANICAL DEMOLITION PLAN - LEVEL 2 - ZONE 4

Scale: 1/8" = 1'-0"  
 Ref. North

**M01.02.04**

©2009 Gensler

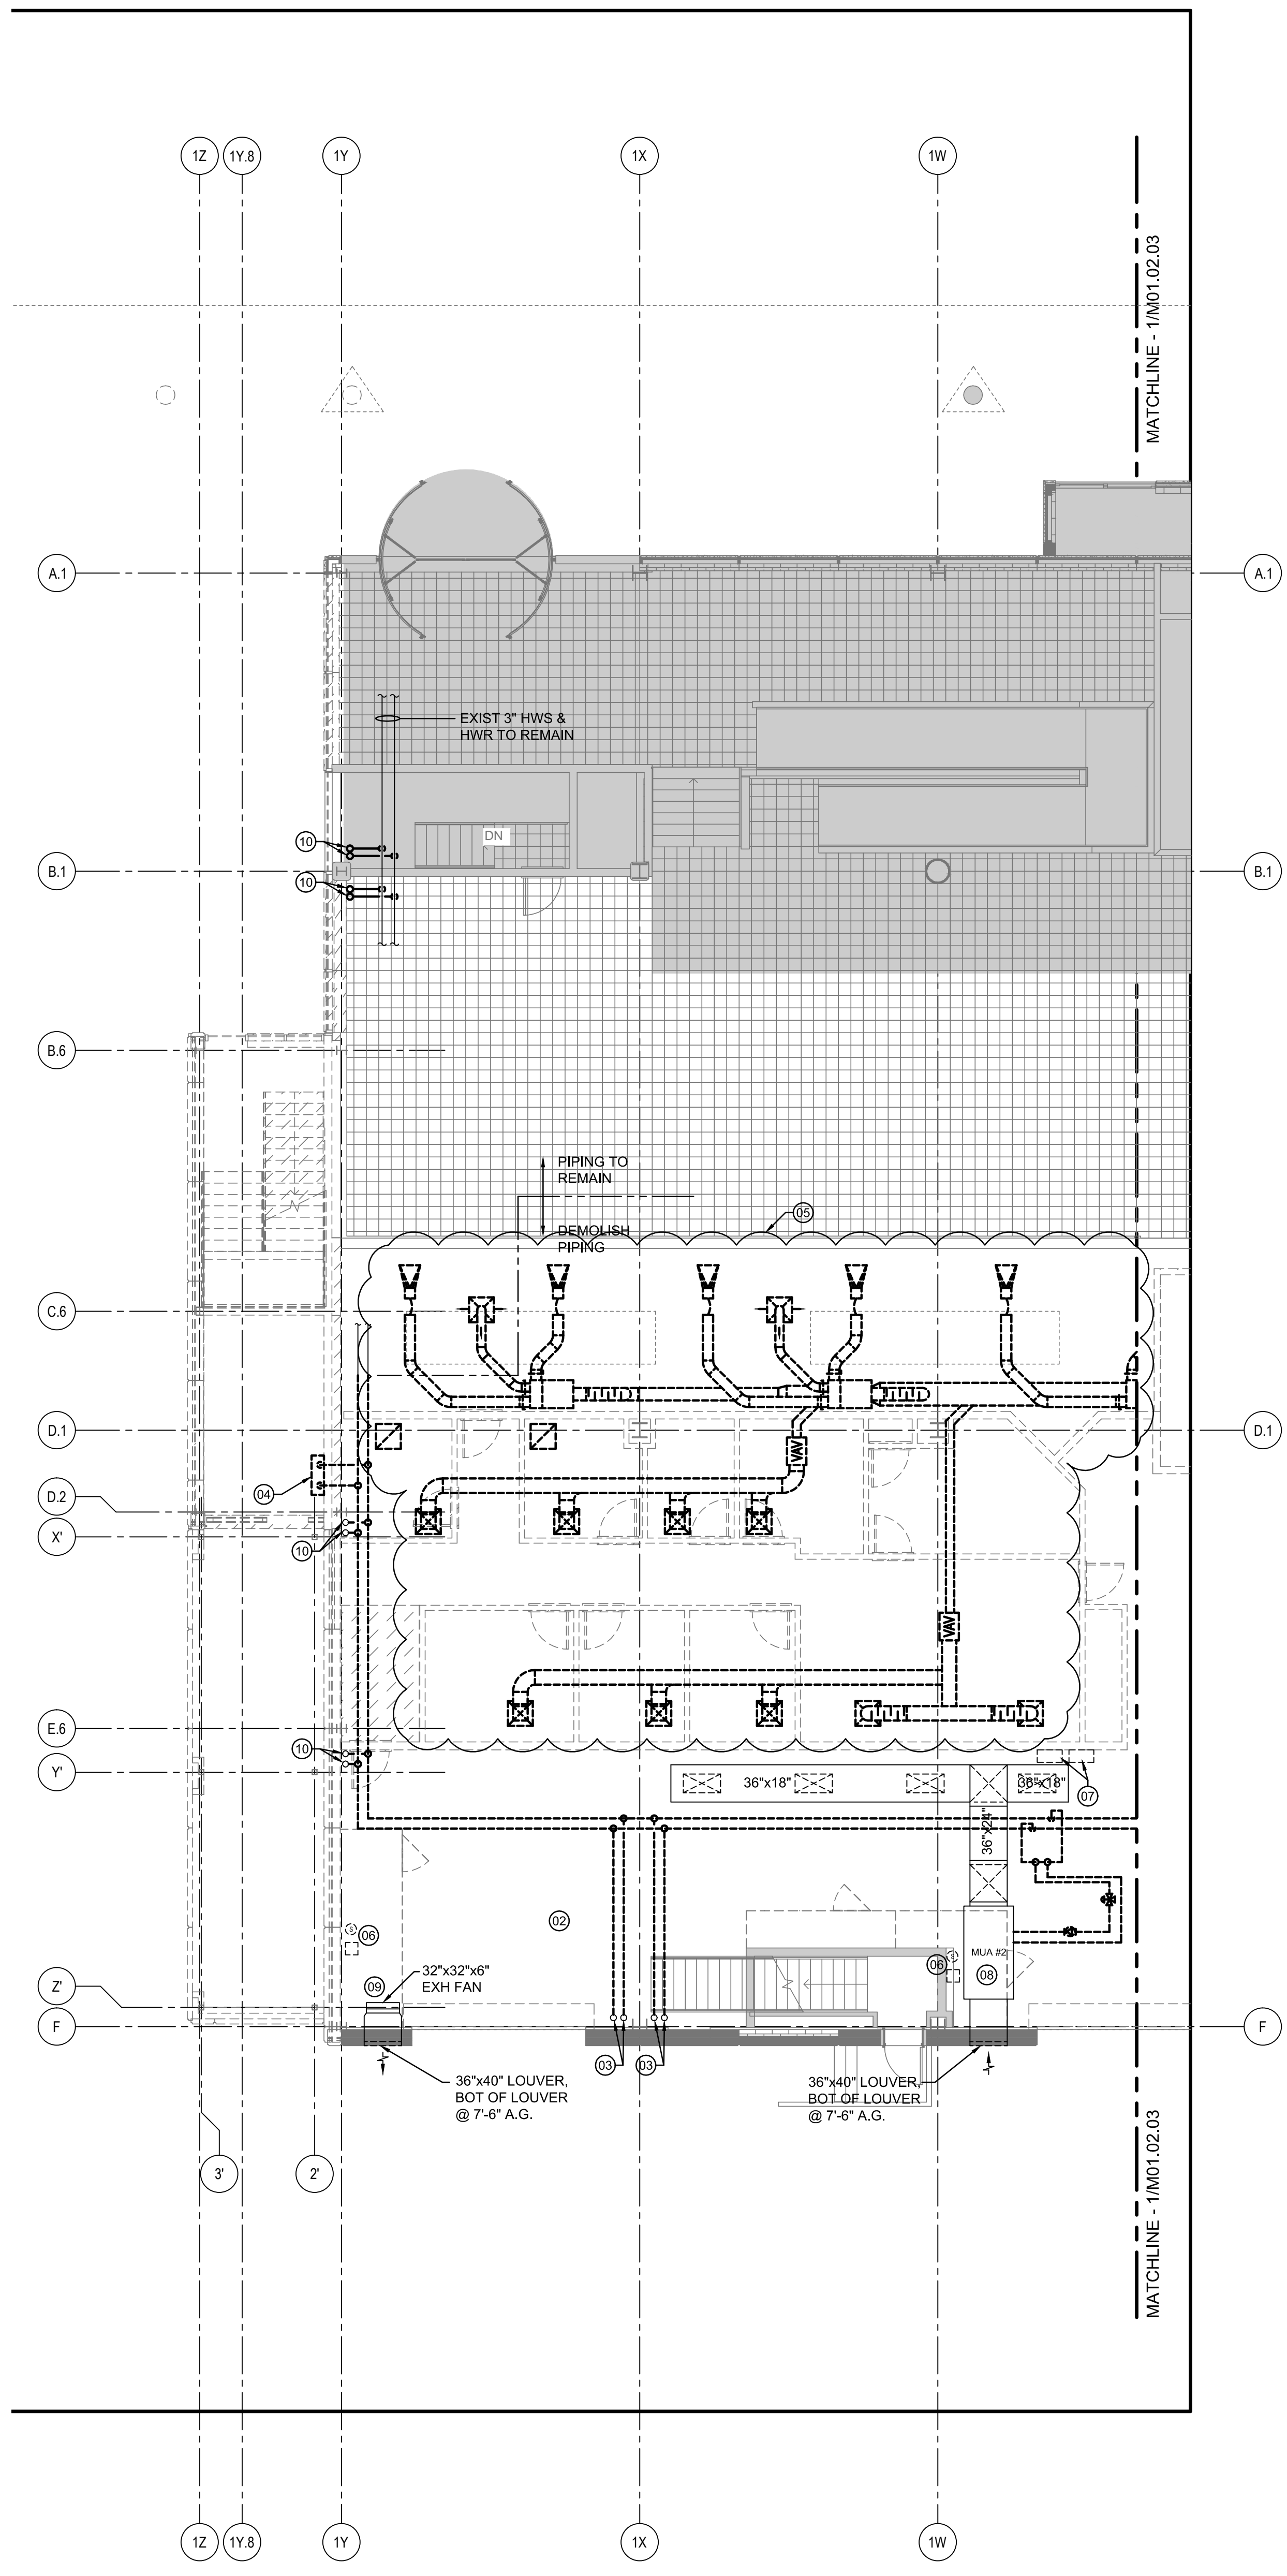

## MECHANICAL DEMOLITION PLAN - LEVEL 2 - ZONE 4

SCALE: 1/8" = 1'-0"