


**MULTISTACK LTHW BYPASS**  
SCALE: NOT TO SCALE **2**

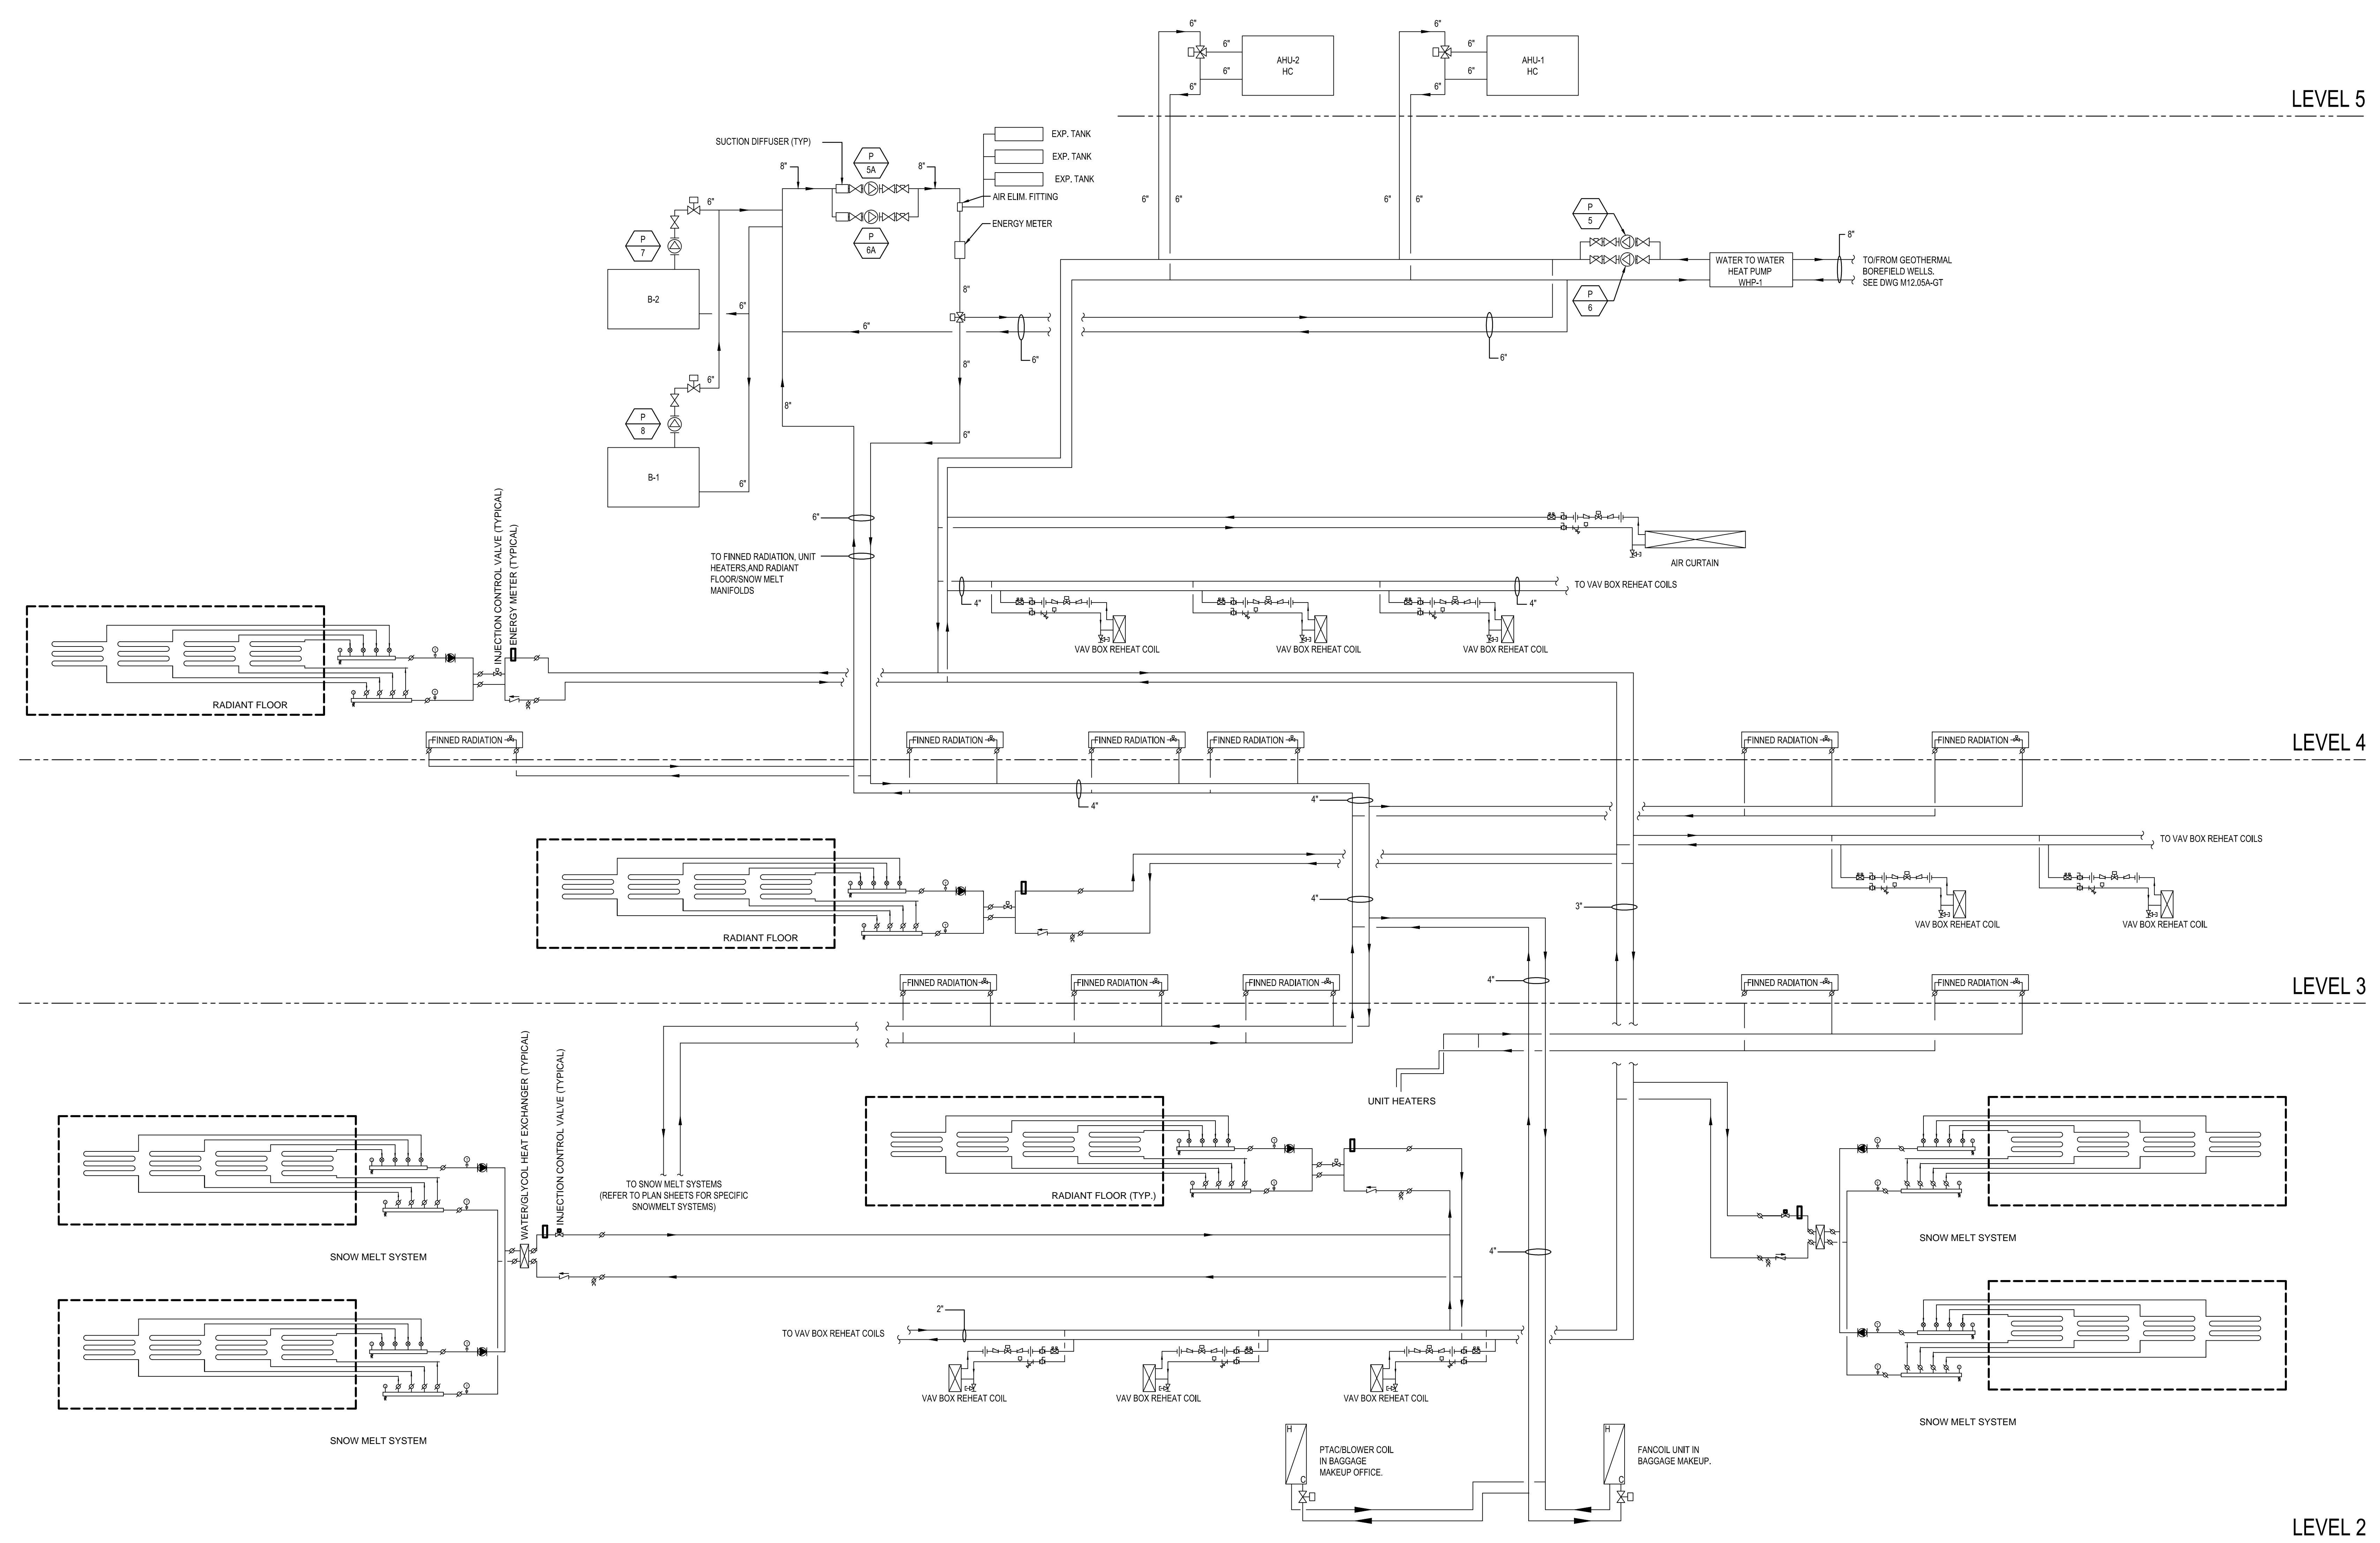

**MECHANICAL PIPING SYSTEM SCHEMATIC**  
SCALE: NOT TO SCALE **1**

**GENERAL NOTES**

- A SEE SHEET M00.00 FOR LEGEND AND GENERAL NOTES.
- B THIS SCHEMATIC IS GENERIC AND DOES NOT INDICATE ALL THE DETAILS OF THE INSTALLED PIPING SYSTEM. SEE PIPING PLANS FOR DETAILED ROUTING.
- C PIPE MAIN SIZES ONLY INDICATED. SEE PIPING PLANS AND SCHEDULES FOR BRANCH SIZES.

THESE DRAWINGS ARE ISSUED FOR CONSTRUCTION AND REFLECT ALL AMEC ISSUED BULLETINS AND SKETCHES.

Issue	Date & Issue Description	By	Check
01	12/03/08	PWZ	RHB
02	01/23/09	PWZ	RHB
03	10/26/09	PWZ	RHB
04	11/12/09	PWZ	RHB
05	05/21/10	PWZ	RHB
06	09/01/11	PWZ	RHB


Project Name  
PJM Terminal Enhancement

Project Number  
08.0395.000

CAD File Name  
T:\SS30101\Sheets\M12.03.dwg

Description  
MECHANICAL PIPING SYSTEM SCHEMATIC

Scale  
NOT TO SCALE

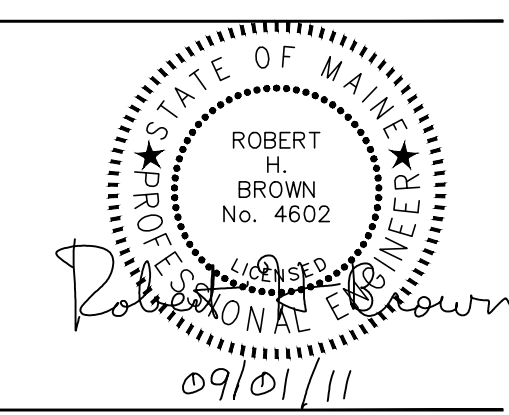

**M12.03**

C2009 Gensler