

**SHEET NOTES**

01 PRC PASSES THROUGH 24" BEAM AT CENTERLINE OF WEB.

**Portland International Jetport**

1001 Westbrook Street  
Portland, Maine 04102

**Gensler**  
2020 K Street, NW  
Suite 200  
Washington, DC 20006  
Telephone 202.771.5200  
Facsimile 202.872.8587

**nest ASSOCIATES, INC.**  
343 Gorham Road, South Portland, ME 04106  
P: (207) 761-1770 F: (207) 774-1246 www.nest.com  
engineers • architects • surveyors • construction managers

**amec**  
343 Gorham Road, South Portland ME 04106  
P: (207) 761-1770 F: (207) 774-1246 www.amec.com


THESE DRAWINGS ARE ISSUED FOR CONSTRUCTION AND REFLECT ALL AMEC ISSUED BULLETINS AND SKETCHES.

Issue	Date & Issue Description	By	Check
01	07/11/08	PWZ	JS
02	09/22/08	PWZ	JS
03	12/03/08	KLM	JS
04	01/23/09	CM	JS
05	10/26/09	PWZ	JS
06	09/01/11	PWZ	JS

**GENERAL NOTES**

- A SEE SHEET P00.00 FOR LEGEND AND GENERAL NOTES.
- B DO NOT RUN WATER OR DRAIN PIPING OVER ELECTRICAL PANELS OR SWITCH GEAR.
- C COORDINATE PLUMBING FLOOR PENETRATIONS WITH IN-FLOOR RADIANT HEAT.


**KEY PLAN**

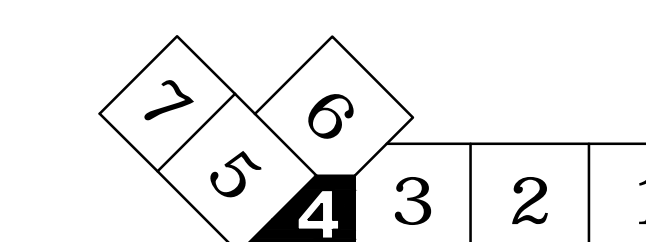

Scale: 1/8" = 1'-0"

**P02.03.04**

©2009 Gensler

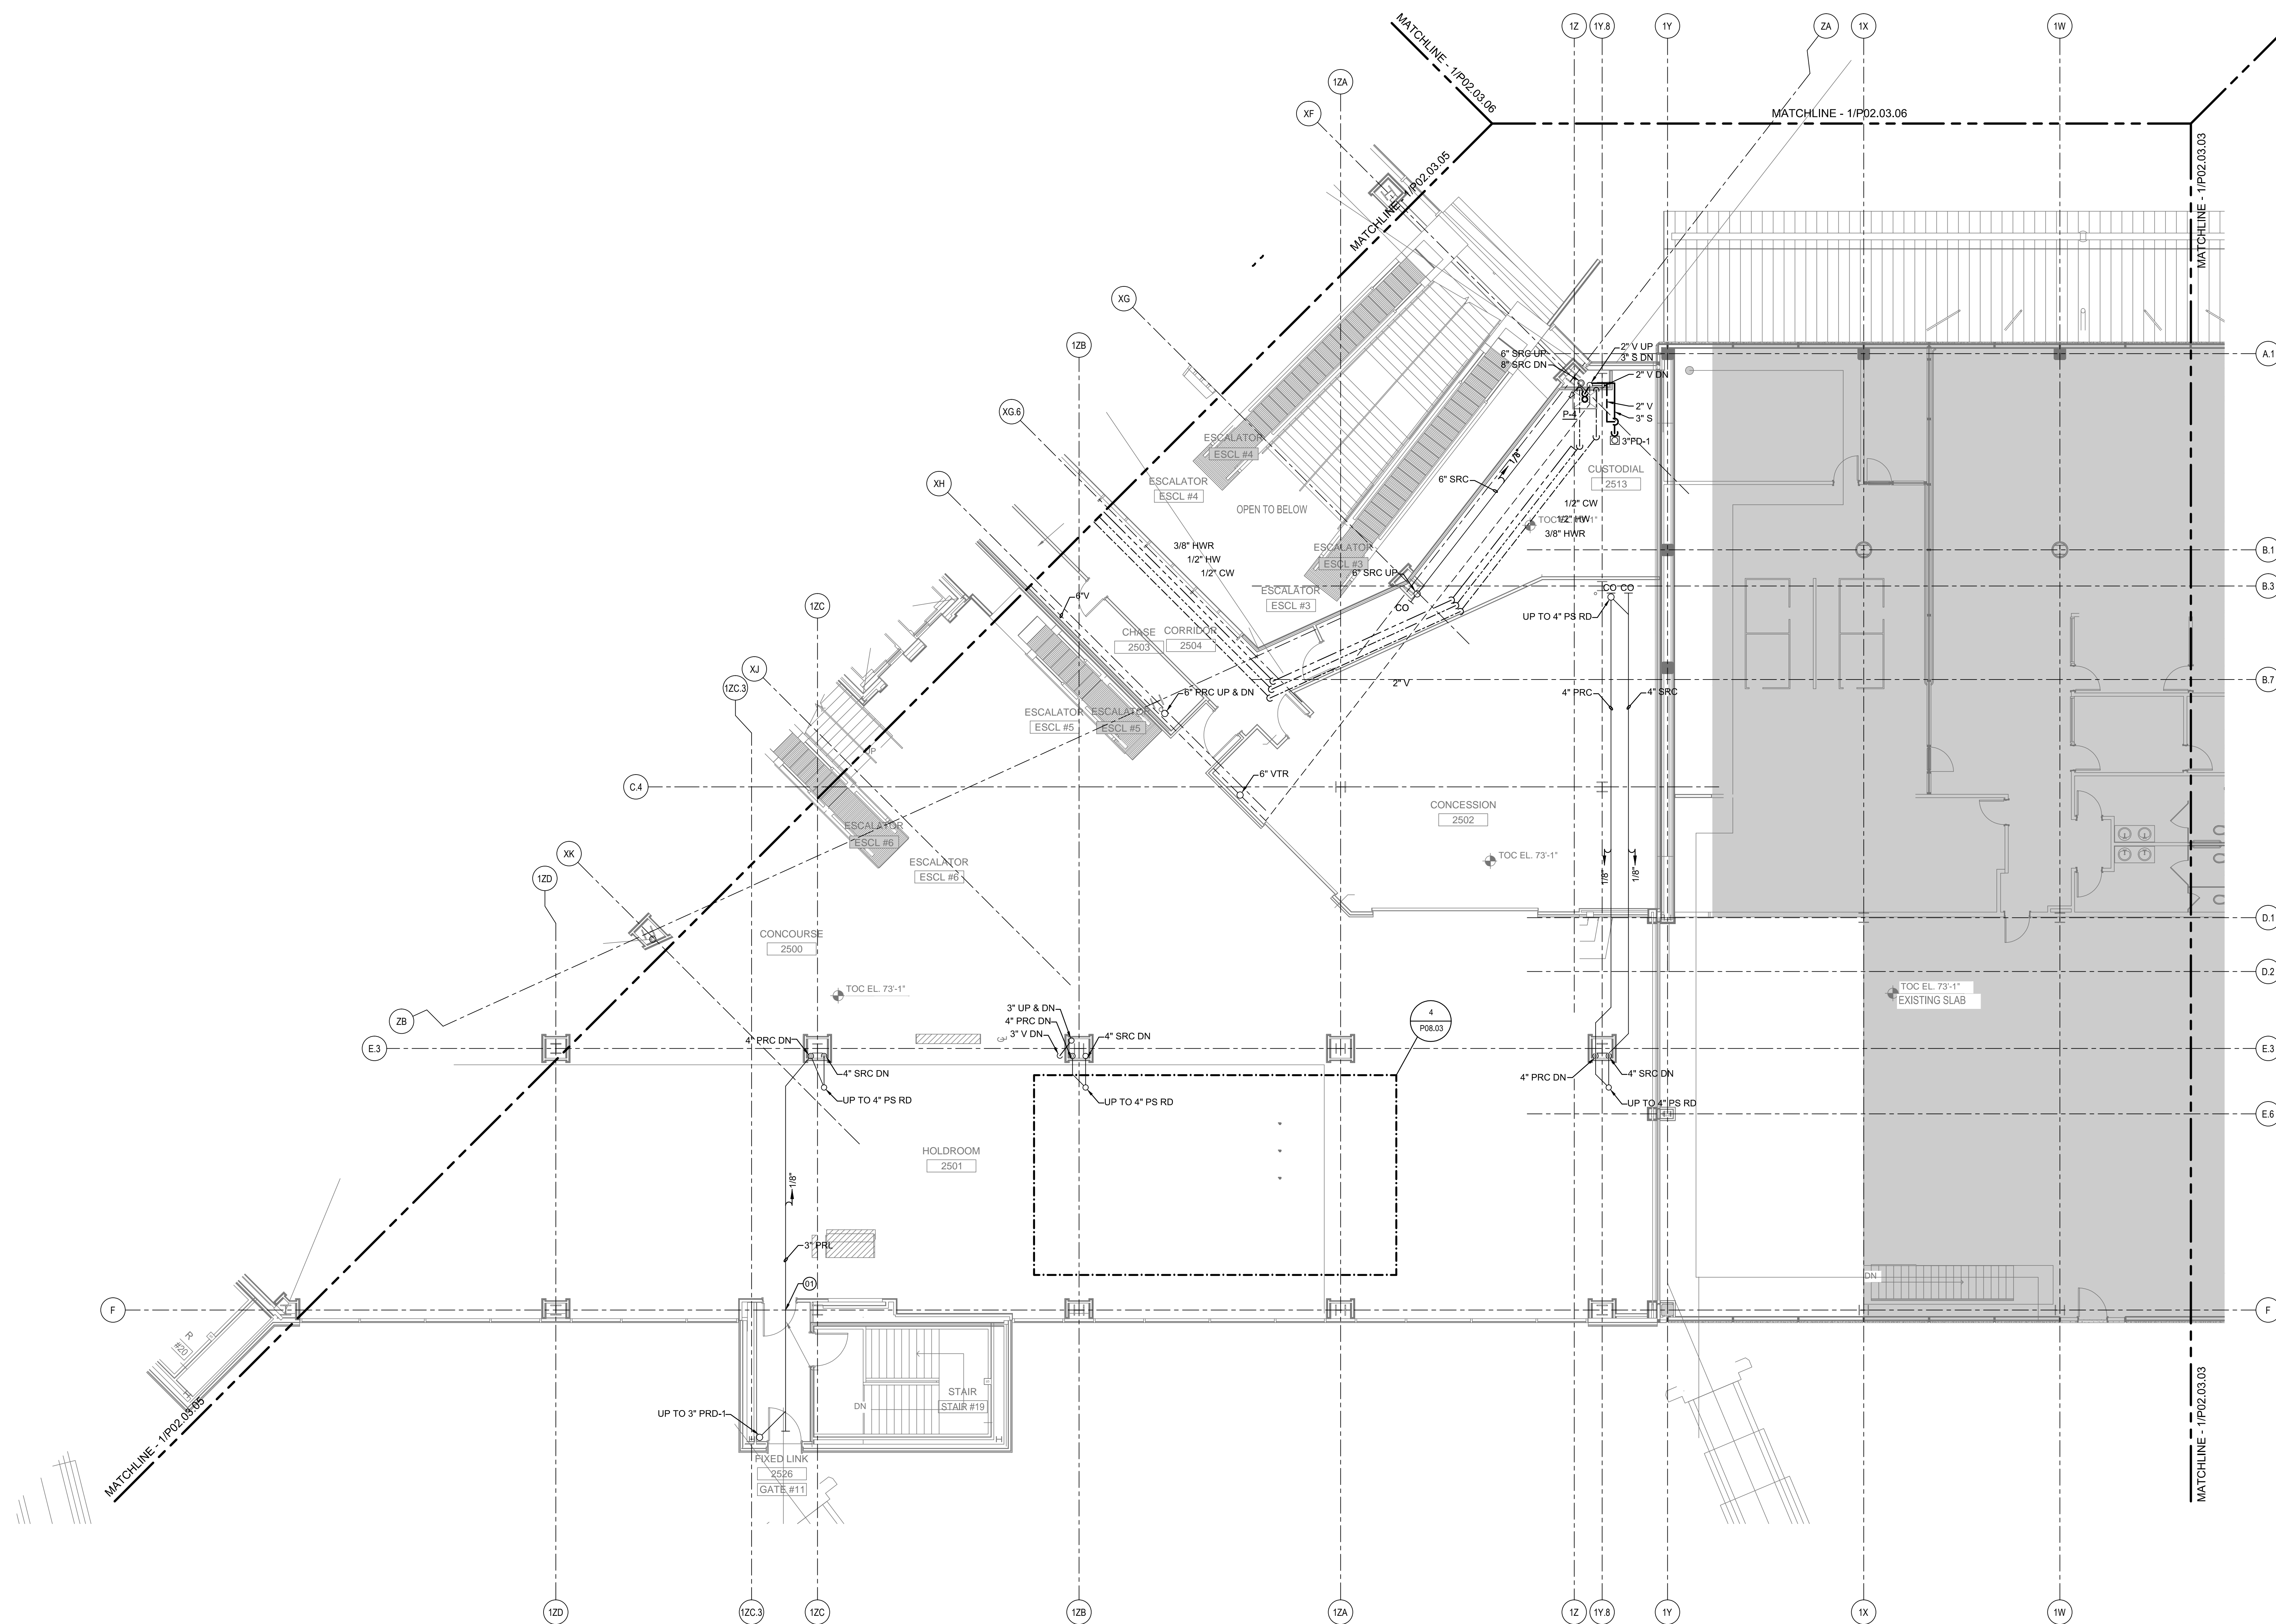

**PLUMBING PLAN - LEVEL 3 - ZONE 4**

SCALE: 1/8" = 1'-0"