




CEILING LEGEND

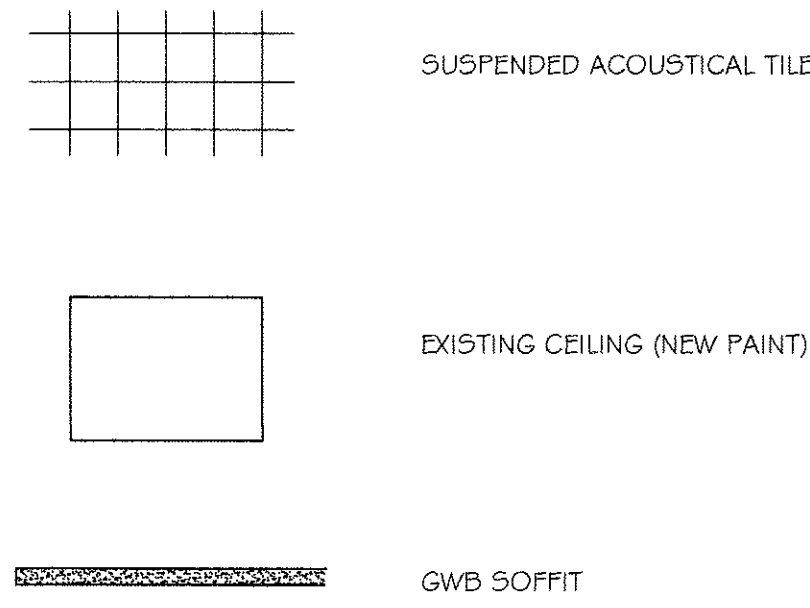


LIGHTING LEGEND

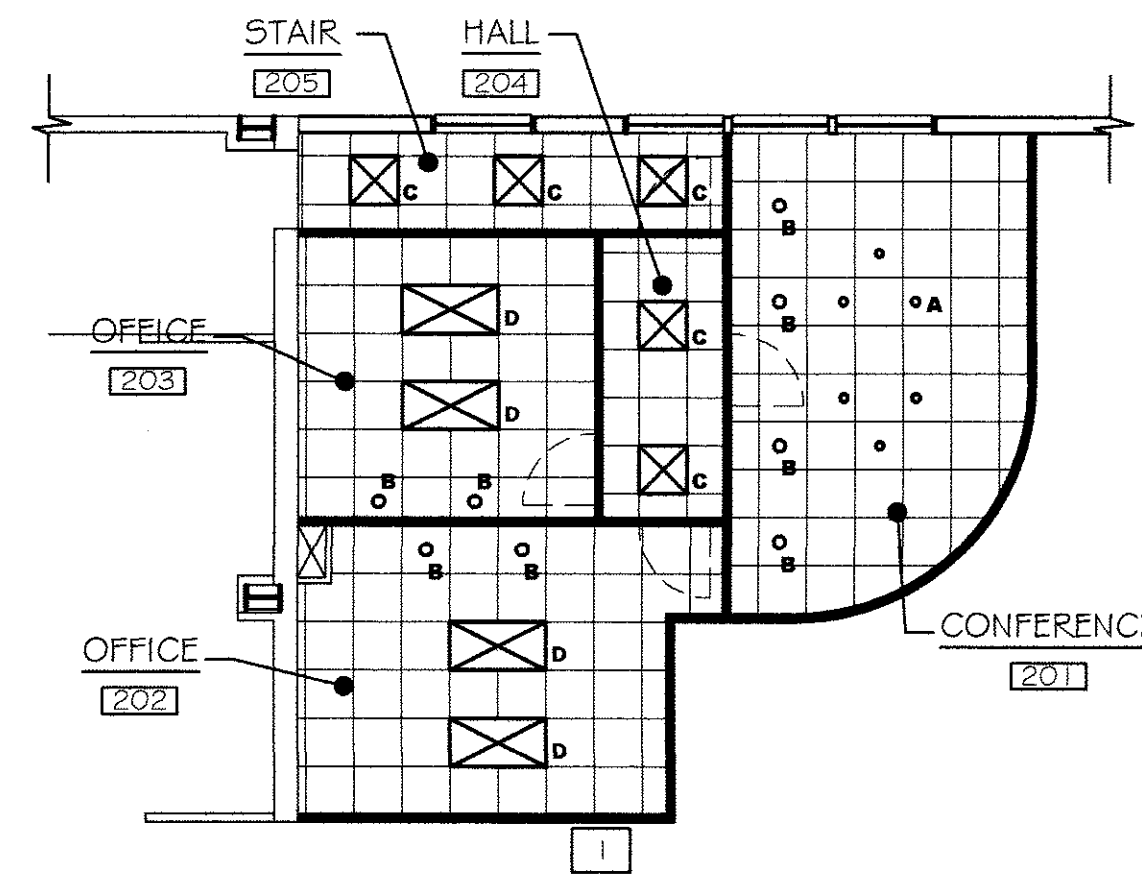


① OFFICES ABOVE PILOT'S SUITE  
SCALE: 1/8" = 1'-0"

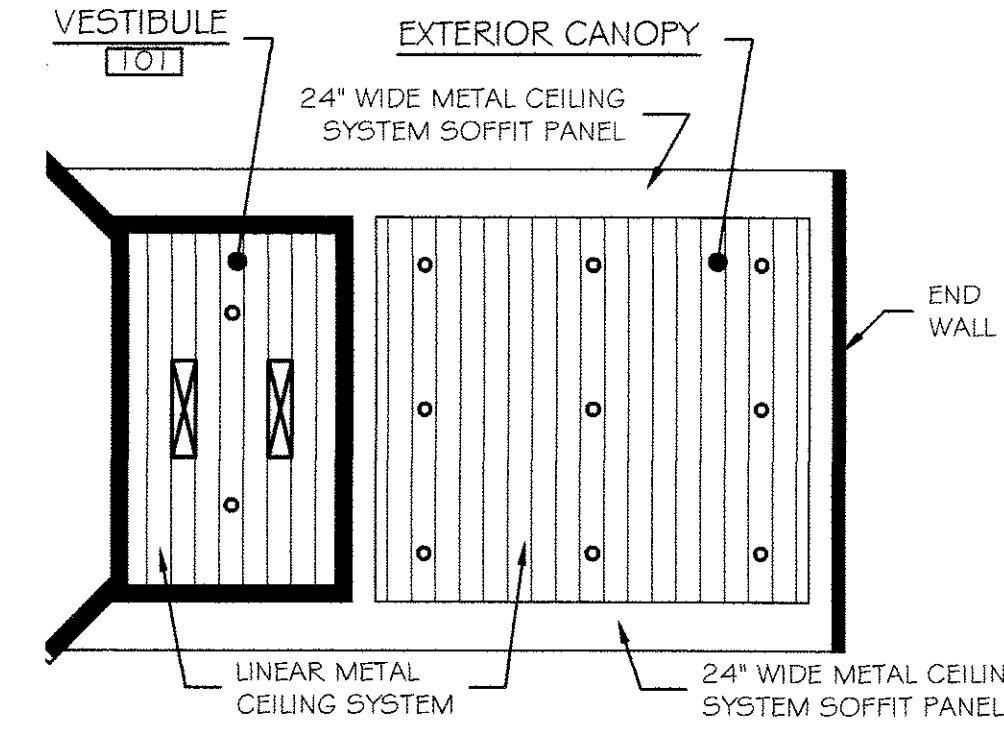



② VESTIBULE 101 REFLECTED CEILING PLAN  
SCALE: 1/8" = 1'-0"

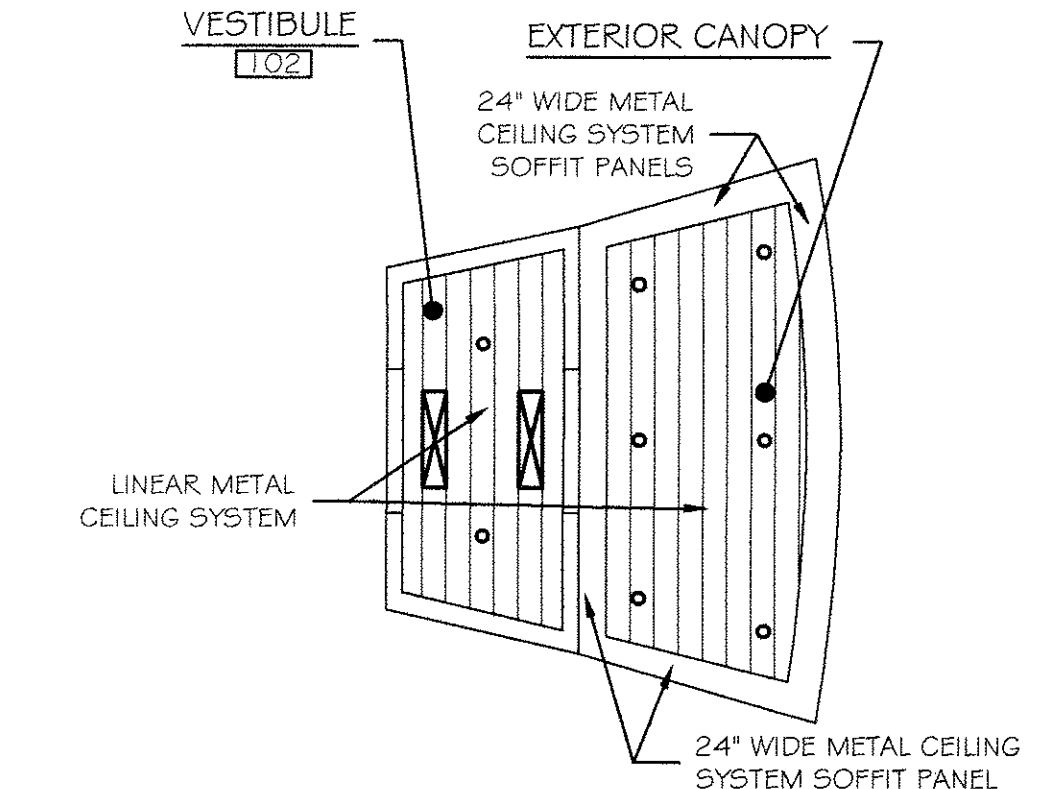

③ VESTIBULE 102 REFLECTED CEILING PLAN  
SCALE: 1/8" = 1'-0"

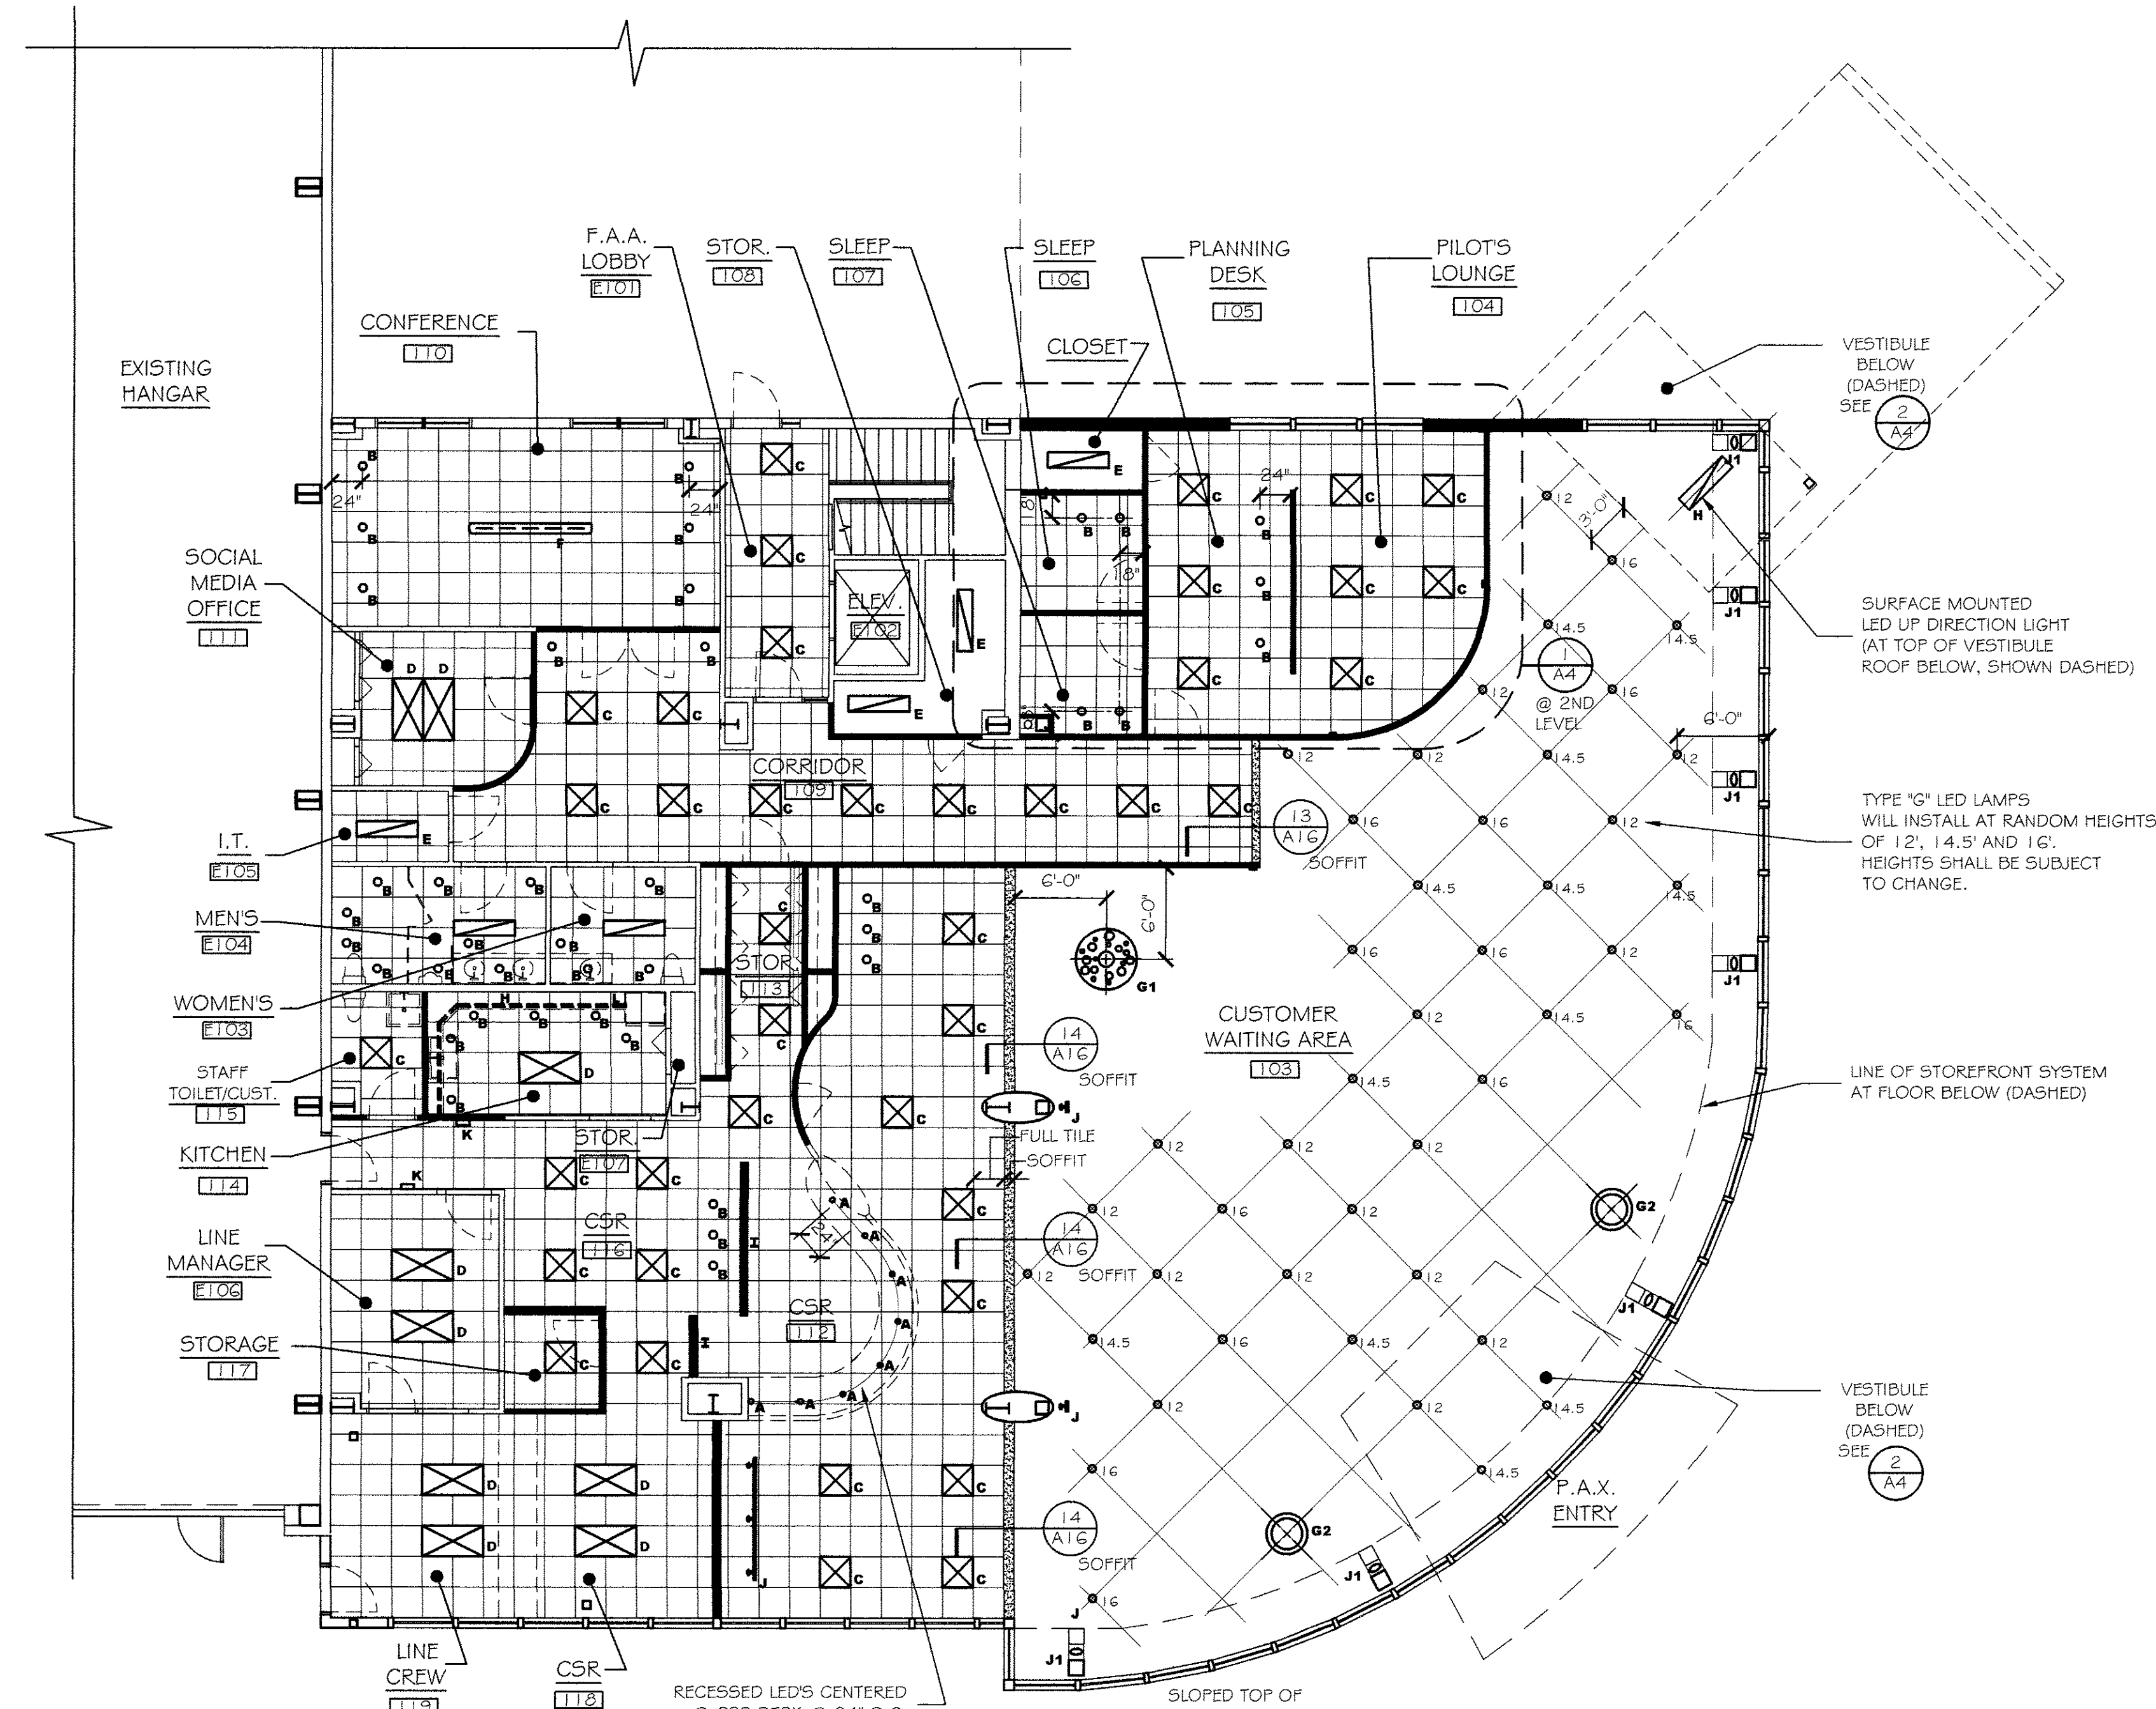

REFLECTED CEILING PLAN  
SCALE: 1/8" = 1'-0"

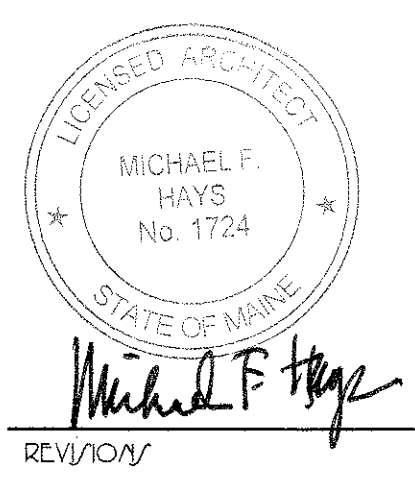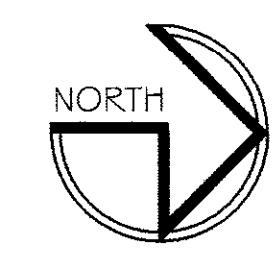

PHASE I REFLECTED CEILING PLAN

DATE: 14 DEC '15  
SCALE: 1/8" = 1'-0"  
DRAWN: BGH/mgk  
JOB NO.: 150655

SHEET: A4  
COPYRIGHT REPRODUCTION OR RELIANCE OF THIS DOCUMENT WITHOUT WRITTEN PERMISSION FROM GRANT HAYS ASSOCIATES IS PROHIBITED.