


N:\Projects\2015\15028 - Northeast Air Terminal Building\00 Drawing Files\201515028_E.rwg Dec 14, 2015 - 10:48am

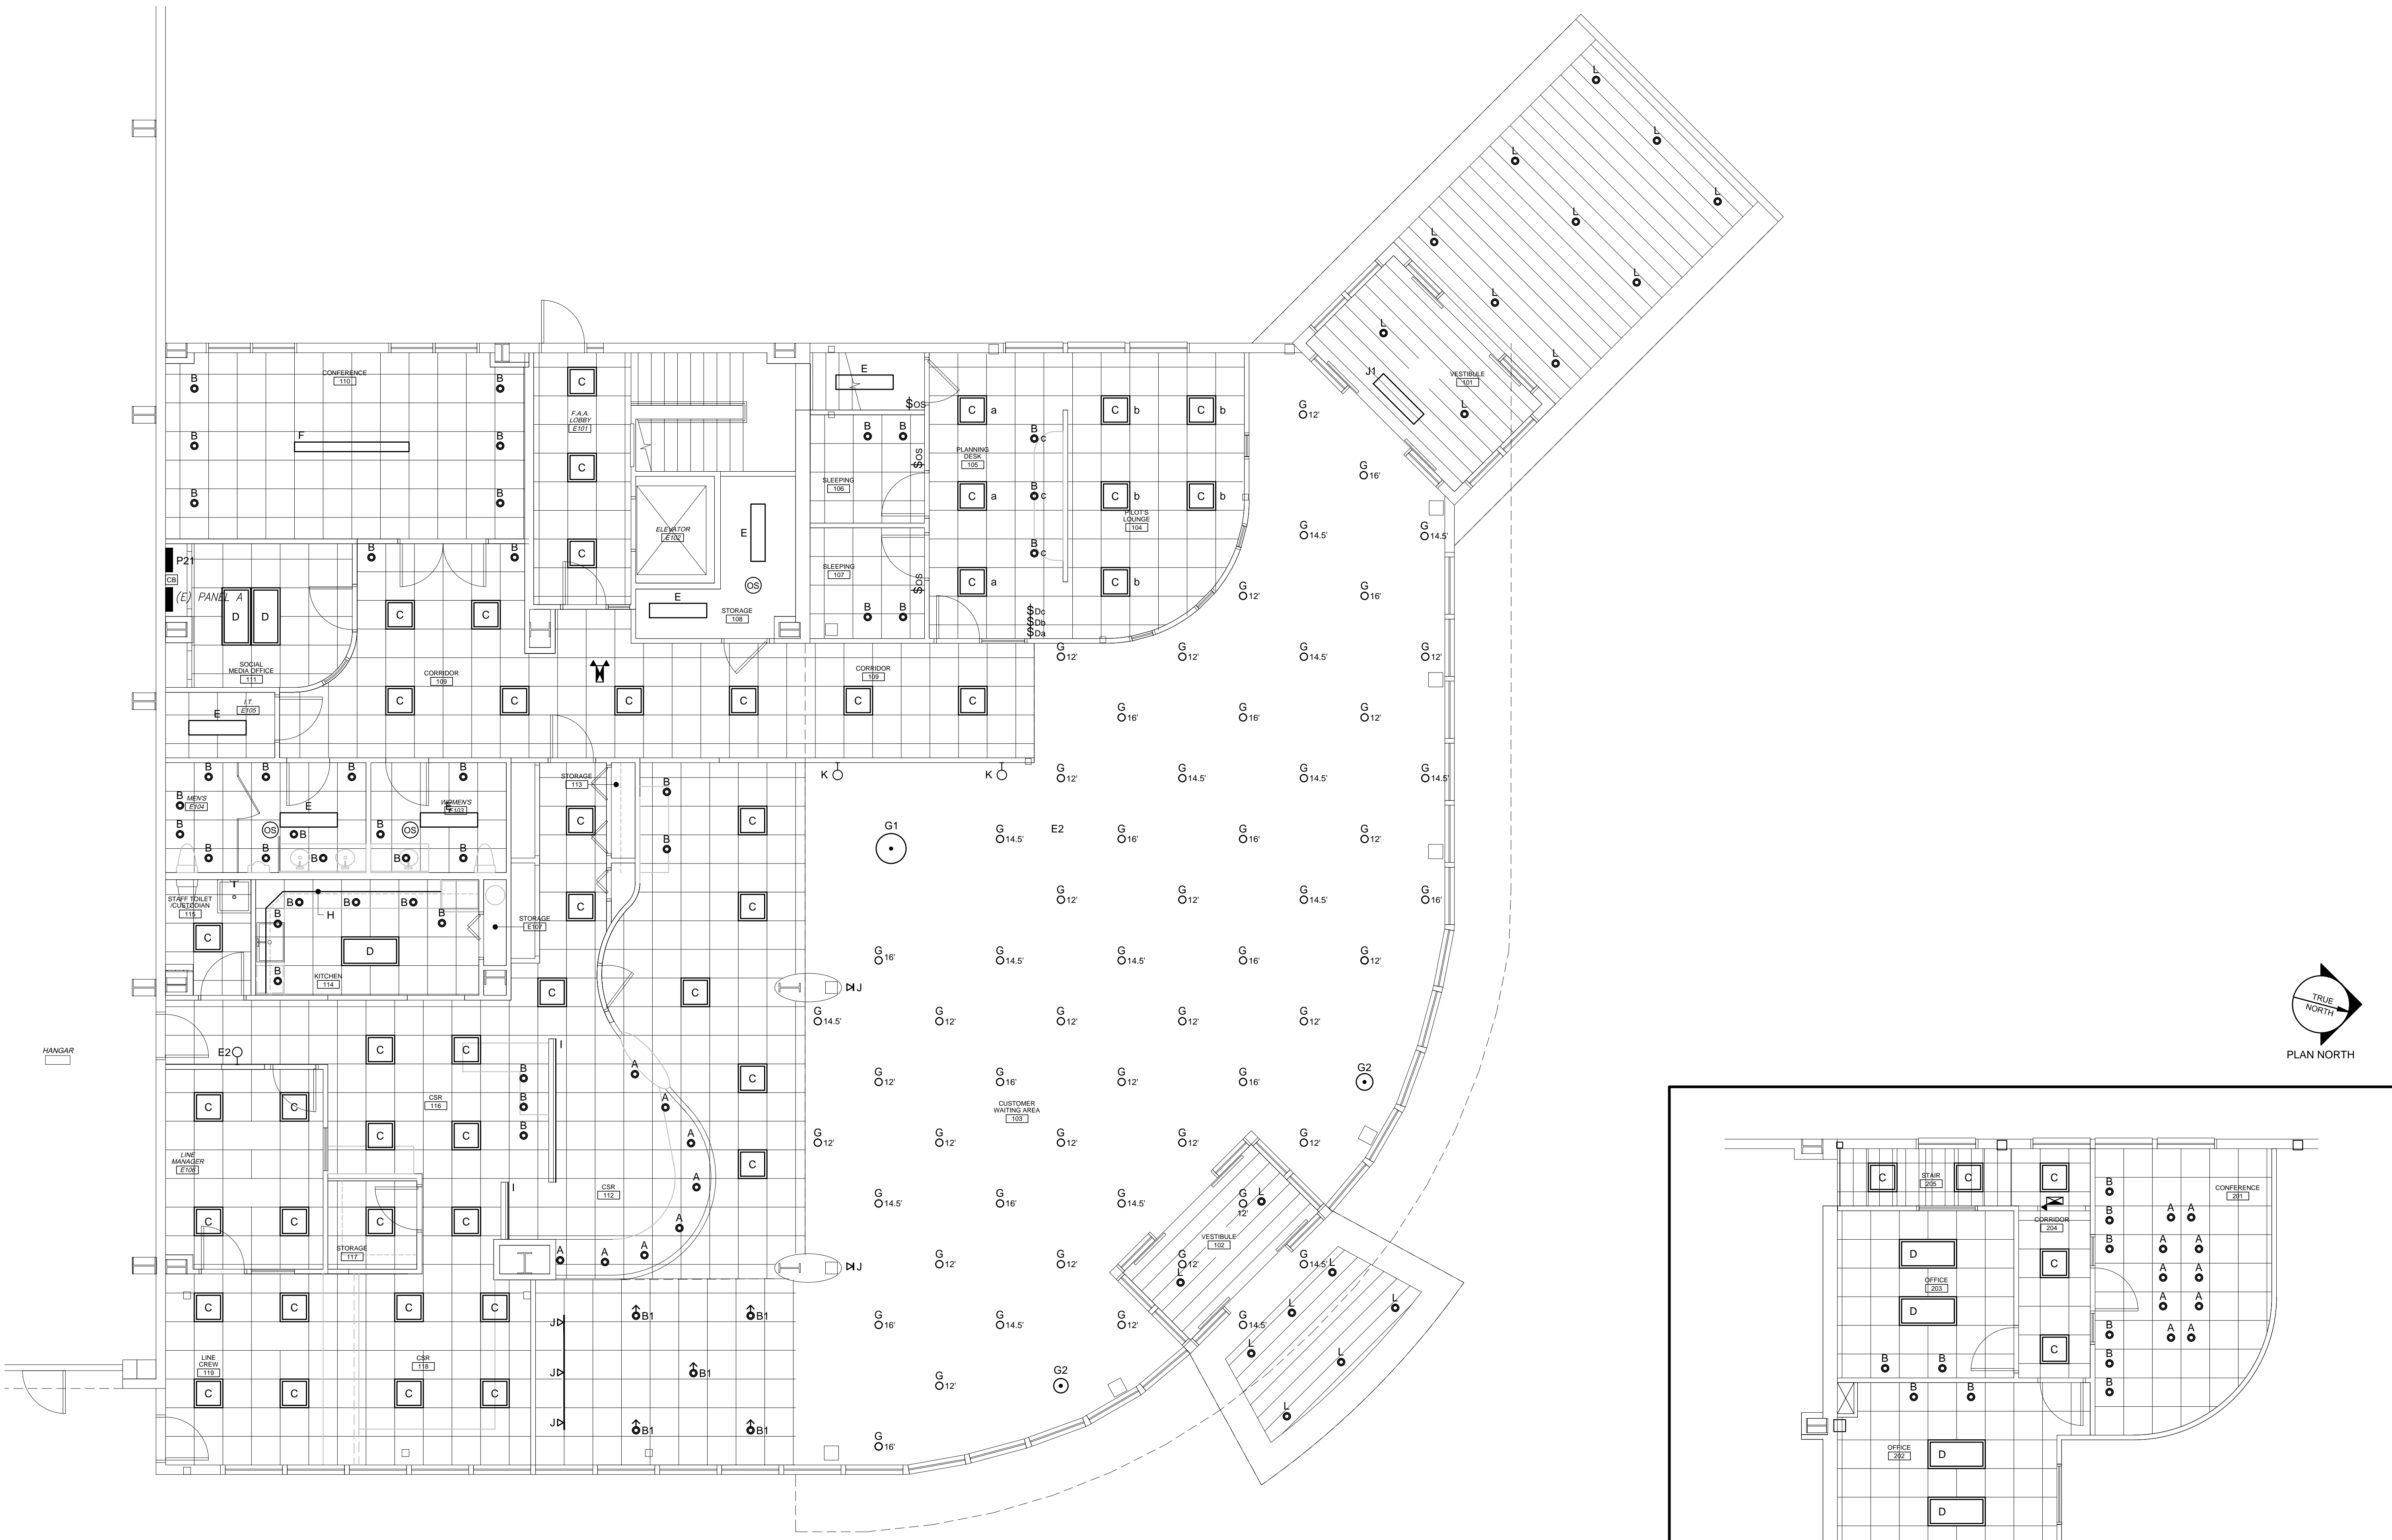

A1 LIGHTING PLAN
3/16" = 1'-0"

A8 SECOND FLOOR
3/16" = 1'-0"

LIGHTING PLANS

Date:	-
Drawn By:	DL
Checked By:	SRM
Project Mgr:	WPF
Project No.:	15028
Cad File:	15028_E.DWG
Graphic Scale:	0 1'

NEA NORTH EAST AIR
 PORTLAND INTERNATIONAL AIRPORT
 1011 WESTBROOK STREET
 PORTLAND, MAINE 04102
 © December 2015. ALL RIGHTS RESERVED.

EL-2

GRANT HAYS ASSOCIATES
 ARCHITECTURE & INTERIOR DESIGN
 P.O. BOX 6199 FALMOUTH MAINE 04103
 207.871.3900 gha@granthays.com

Allied Engineering
 Structural Mechanical Electrical Commissioning

160 Veranda Street
 Portland, Maine 04103
 T: 207.221.2260
 F: 207.221.2266
 Web: www.allied-eng.com

90% PRICING SET ~ 14 DECEMBER 2015 ~ NOT FOR CONSTRUCTION