


LUMINAIRE SCHEDULE								
TYPE	DESCRIPTION	MFR	CATALOG SERIES NUMBER SEE NOTE 1	MOUNTING	VOLTS	WATTS		KEY NOTES
							TYPE	
VS3	SMALL VIPER POLE LIGHT, TYPE 3 OPTICS	BEACON	VPS-30NB-70-T3-5K	POLE, 16.5'	277	70	LED ARRAY 5000K	
VS5	SMALL VIPER POLE LIGHT, TYPE 5 OPTICS	BEACON	VPS-30NB-70-T5QM	POLE, 20'	277	70	LED ARRAY 5000K	
VS3B	SMALL VIPER POLE LIGHT, TYPE 3 OPTICS	BEACON	VPS-30NB-BLC-5K	POLE, 16.5'	277	70	LED ARRAY 5000K	
VS3C	SMALL VIPER POLE LIGHT, TYPE 3 OPTICS	BEACON	VPS-30NB-BLC-5K	POLE, 16'	277	70	LED ARRAY 5000K	
NOTES								
1	NOTE THAT THESE NUMBERS ARE NOT COMPLETE CATALOG #S. PROVIDE ALL REQUIREMENTS ON SCHEDULE, NOTES, SPECS, AND DRAWINGS COMBINED.							
2	CATALOG SERIES NUMBERS ARE USED TO ESTABLISH A LEVEL OF QUALITY AND NOT INTENDED TO LIMIT COMPETITION. SERIES NUMBERS ARE NOT COMPLETE CATALOG NUMBERS. COMPLY WITH ADDITIONAL REQUIREMENTS IN SPECIFICATIONS AND DRAWINGS.							

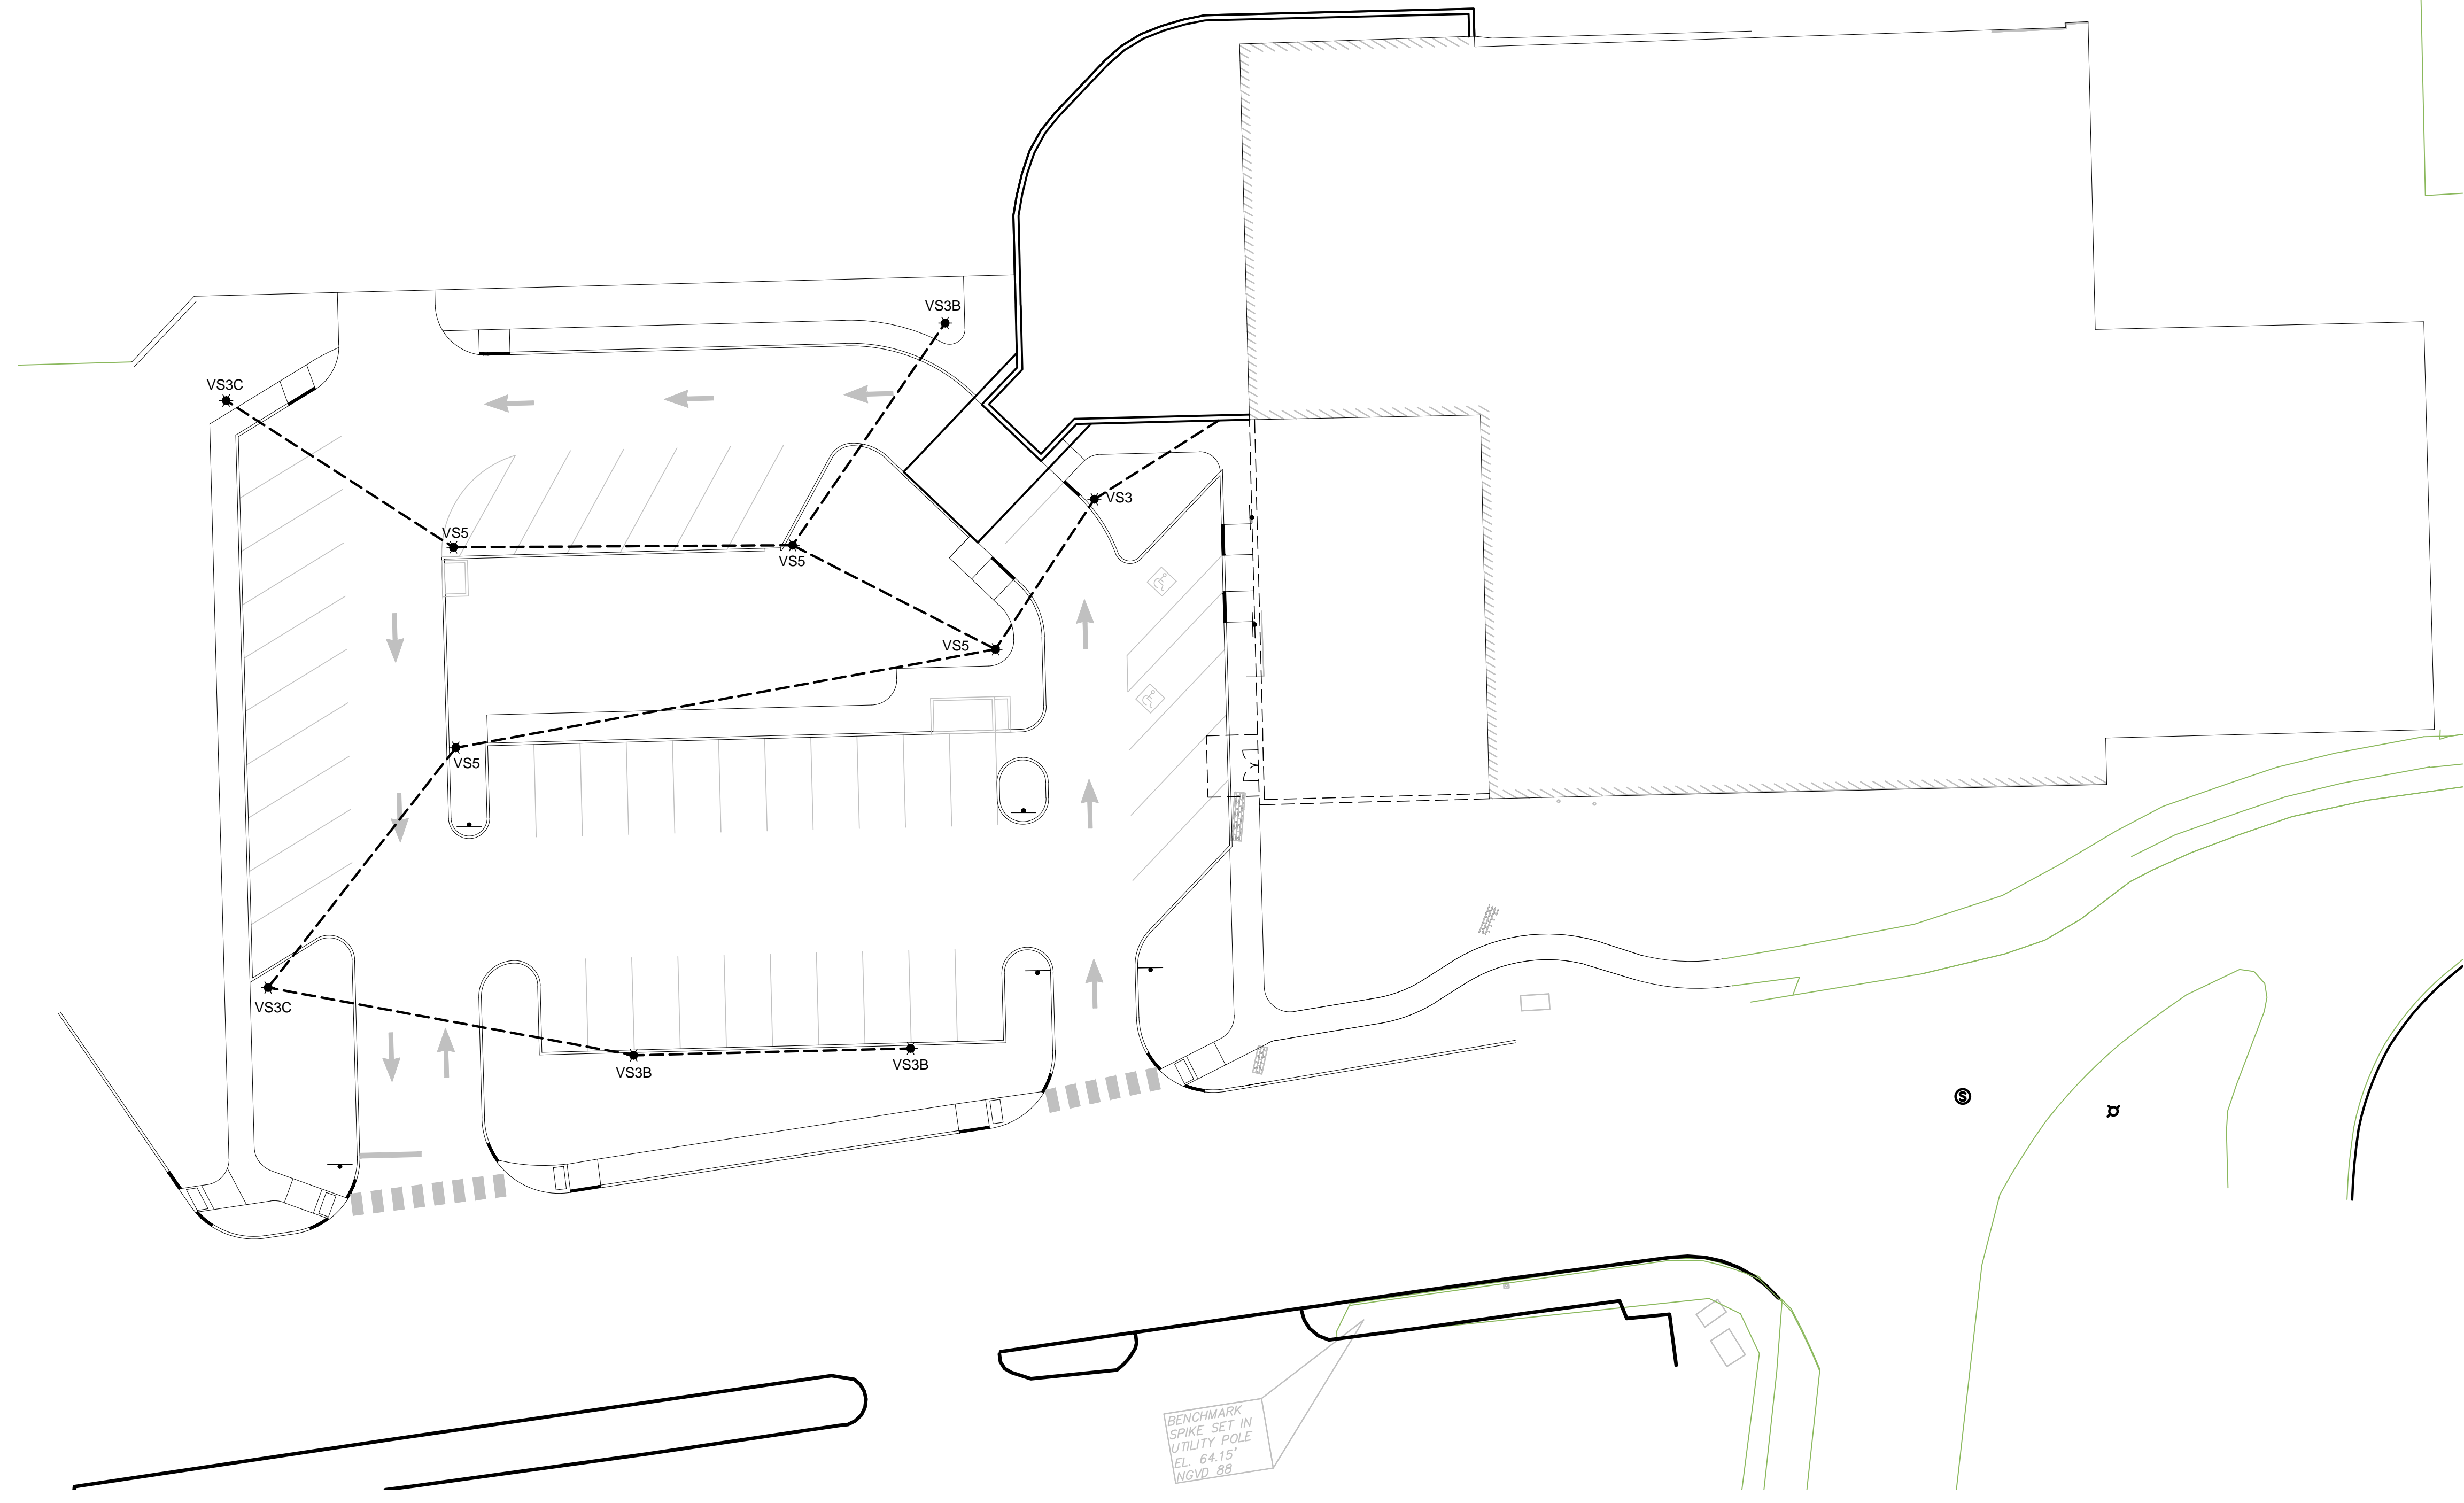

N:\Projects\2015\15028 - Northeast Air Terminal Building\00 Drawing Files\2015\15028_ES.dwg Dec 14, 2015 - 12:39pm

A1 ELECTRICAL SITE PLAN
1" = 20'-0"

Allied Engineering
Structural Mechanical Electrical Commissioning
160 Veranda Street
Portland, Maine 04103
T: 207.221.2260
F: 207.221.2266
Web: www.allied-eng.com

GRANT HAYS ASSOCIATES
ARCHITECTURE & INTERIOR DESIGN
P.O. BOX 6797 FALMOUTH MAINE 04105
207.871.9500 www.grant-hays.com

Date: -
Drawn By: DLL
Checked By: SRM
Project Mgr: WPF
Project No: 15028
Cad File: 15028_ES.DWG
Graphic Scale: 0 1'

ELECTRICAL SITE PLAN
NEA NORTH EAST AIR
PORTLAND INTERNATIONAL AIRPORT
1011 WESTBROOK STREET
PORTLAND, MAINE 04102
© COPYRIGHT 2015 ALLIED ENGINEERING, INC.

ES-1

90% PRICING SET ~ 14 DECEMBER 2015 ~ NOT FOR CONSTRUCTION