
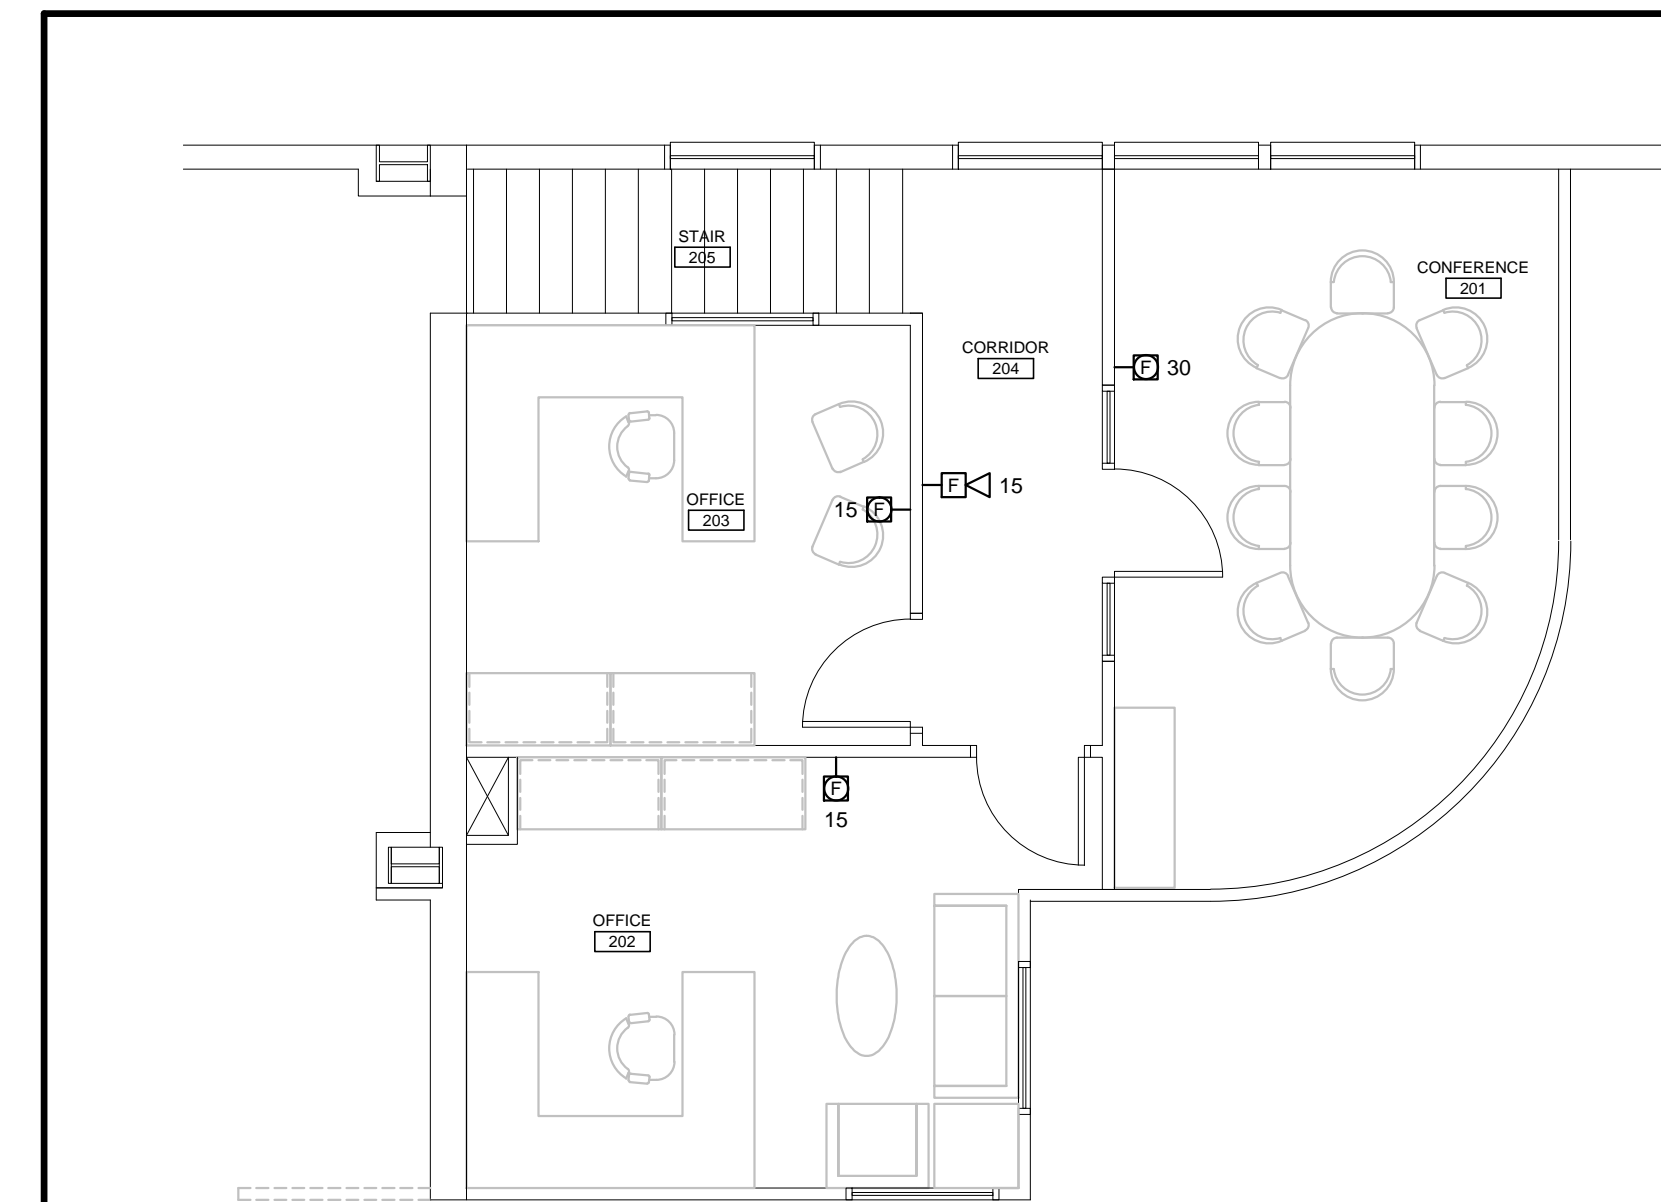


N:\Projects\2015\15028 - Northeast Air Terminal Building\00 Drawing Files\20151515028\_E.rwg Dec 14, 2015 - 10:05am

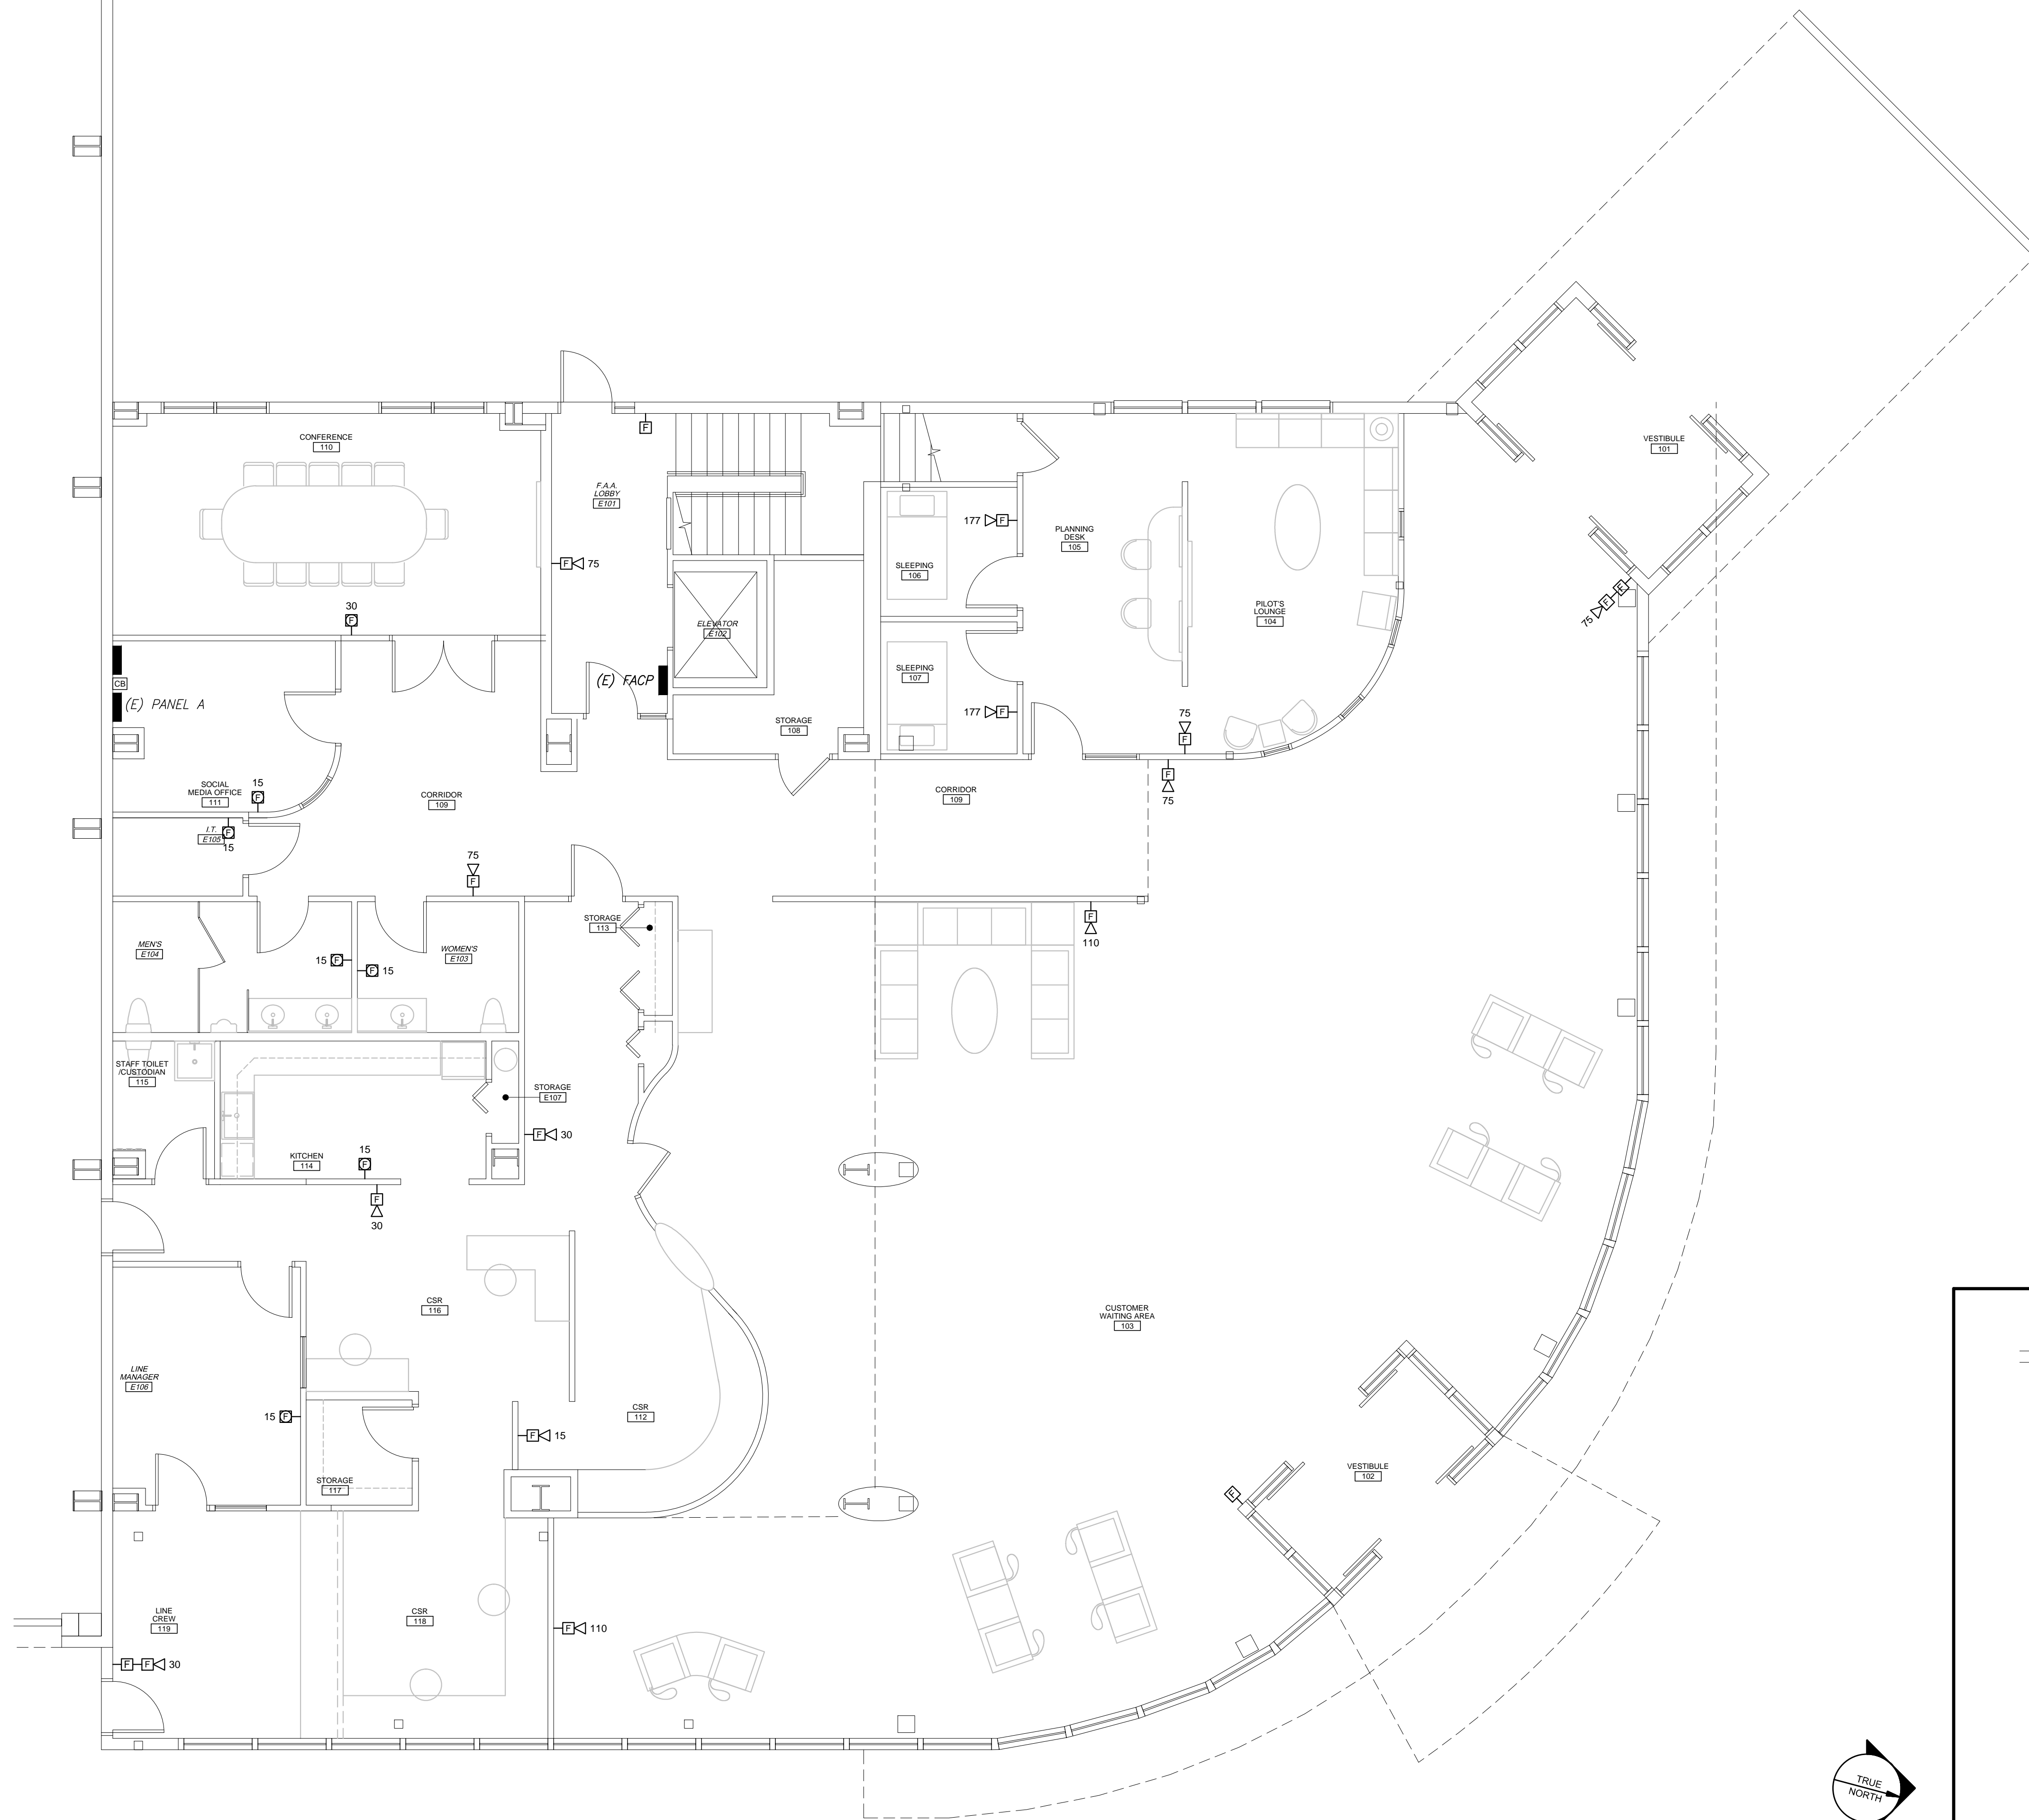

A1 ELECTRICAL POWER AND SYSTEMS PLAN

1/8" = 1'-0"

A8 SECOND FLOOR

3/16" = 1'-0"

FIRE ALARM PLAN

Date: -  
 Drawn By: DLL  
 Checked By: SRM  
 Project Mgr: WPF  
 Project No: 15028  
 Cad File: 15028\_E.DWG  
 Graphic Scale: 0 1'

**NEA** NORTH EAST AIR  
 PORTLAND INTERNATIONAL AIRPORT  
 1011 WESTBROOK STREET  
 PORTLAND, MAINE 04102  
 © 2015 NEA. ALL RIGHTS RESERVED.

**FA-1**

**GRANT HAYS ASSOCIATES**  
 ARCHITECTURE & INTERIOR DESIGN  
 P.O. BOX 6199 FALMOUTH MAINE 04103  
 207.871.3900 www.granthays.com

**Allied Engineering**  
 Structural Mechanical Electrical Commissioning  
 160 Veranda Street  
 Portland, Maine 04103  
 T: 207.221.2260  
 F: 207.221.2266  
 Web: www.allied-eng.com

90% PRICING SET ~ 14 DECEMBER 2015 ~ NOT FOR CONSTRUCTION