
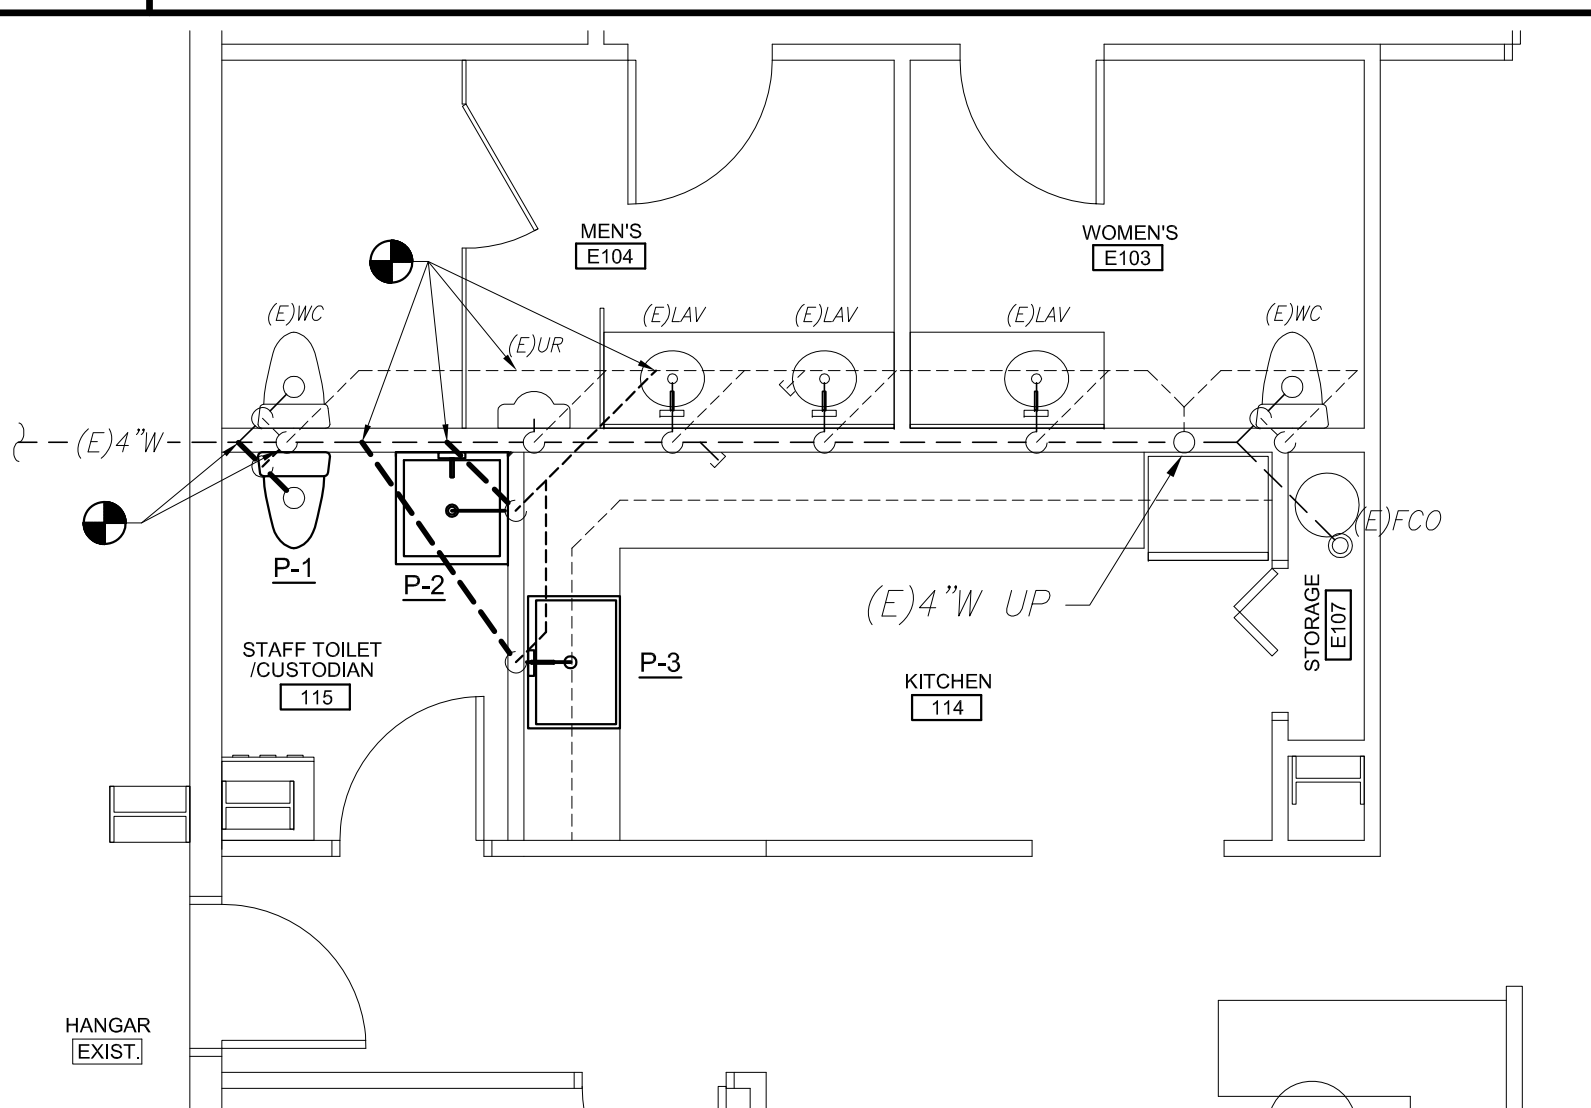
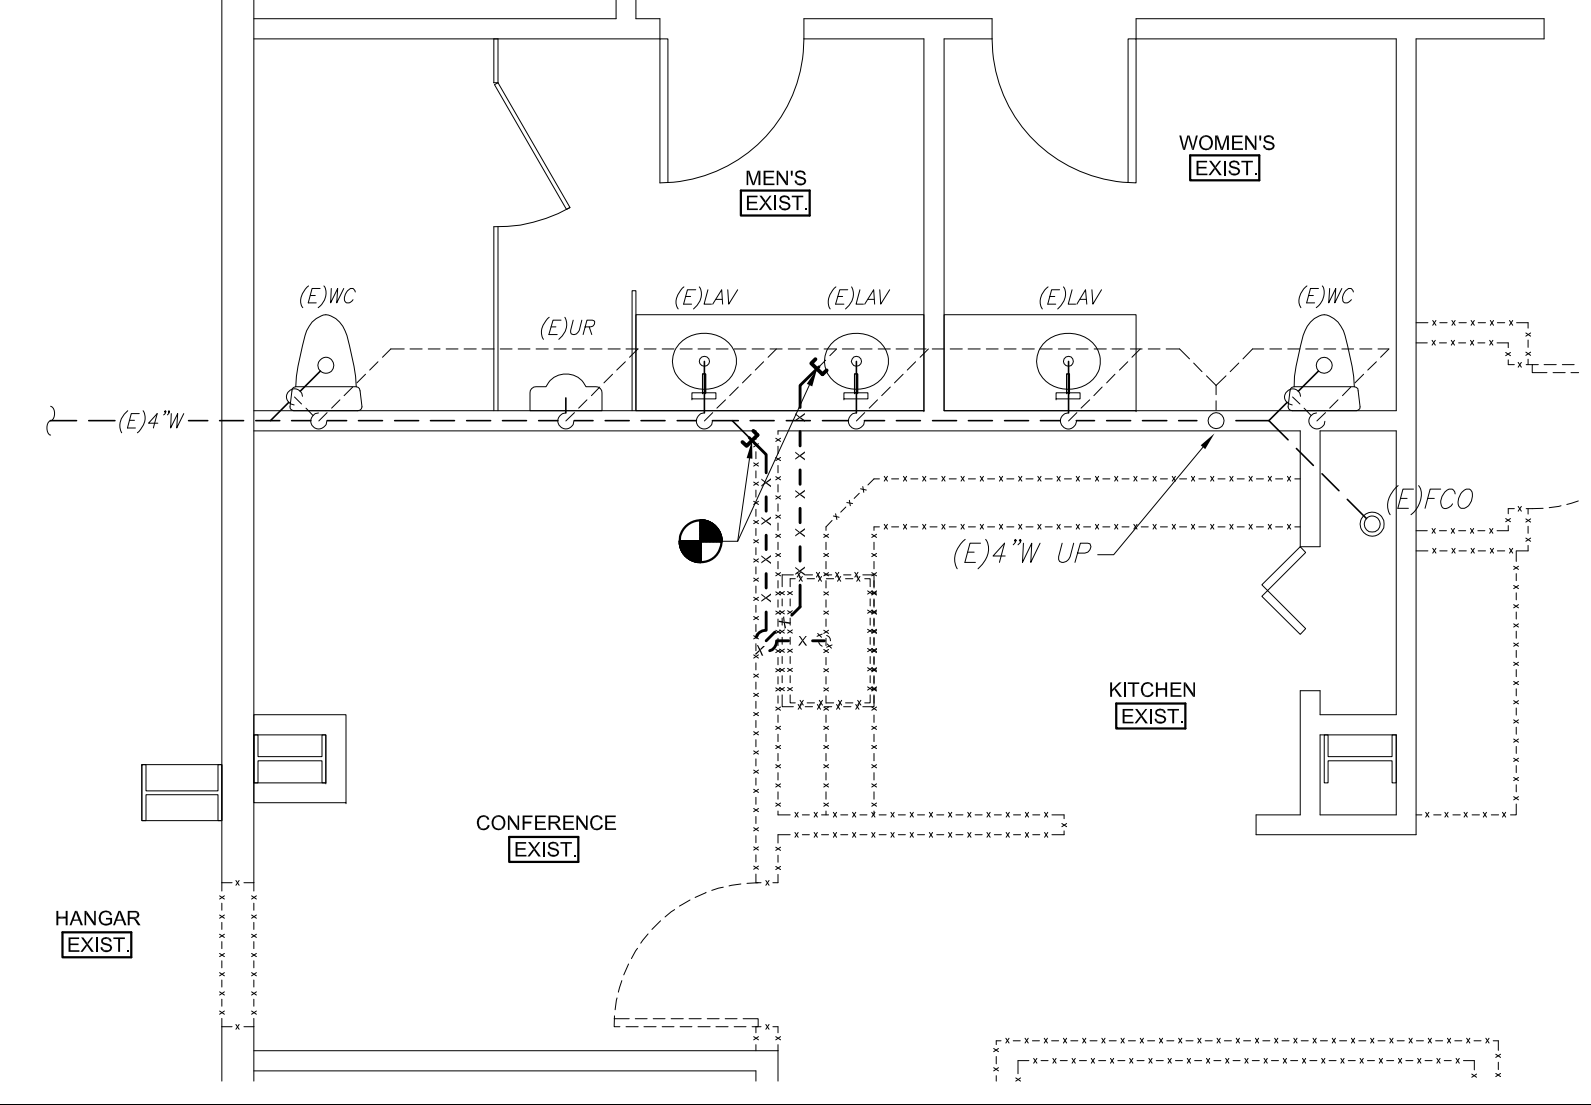
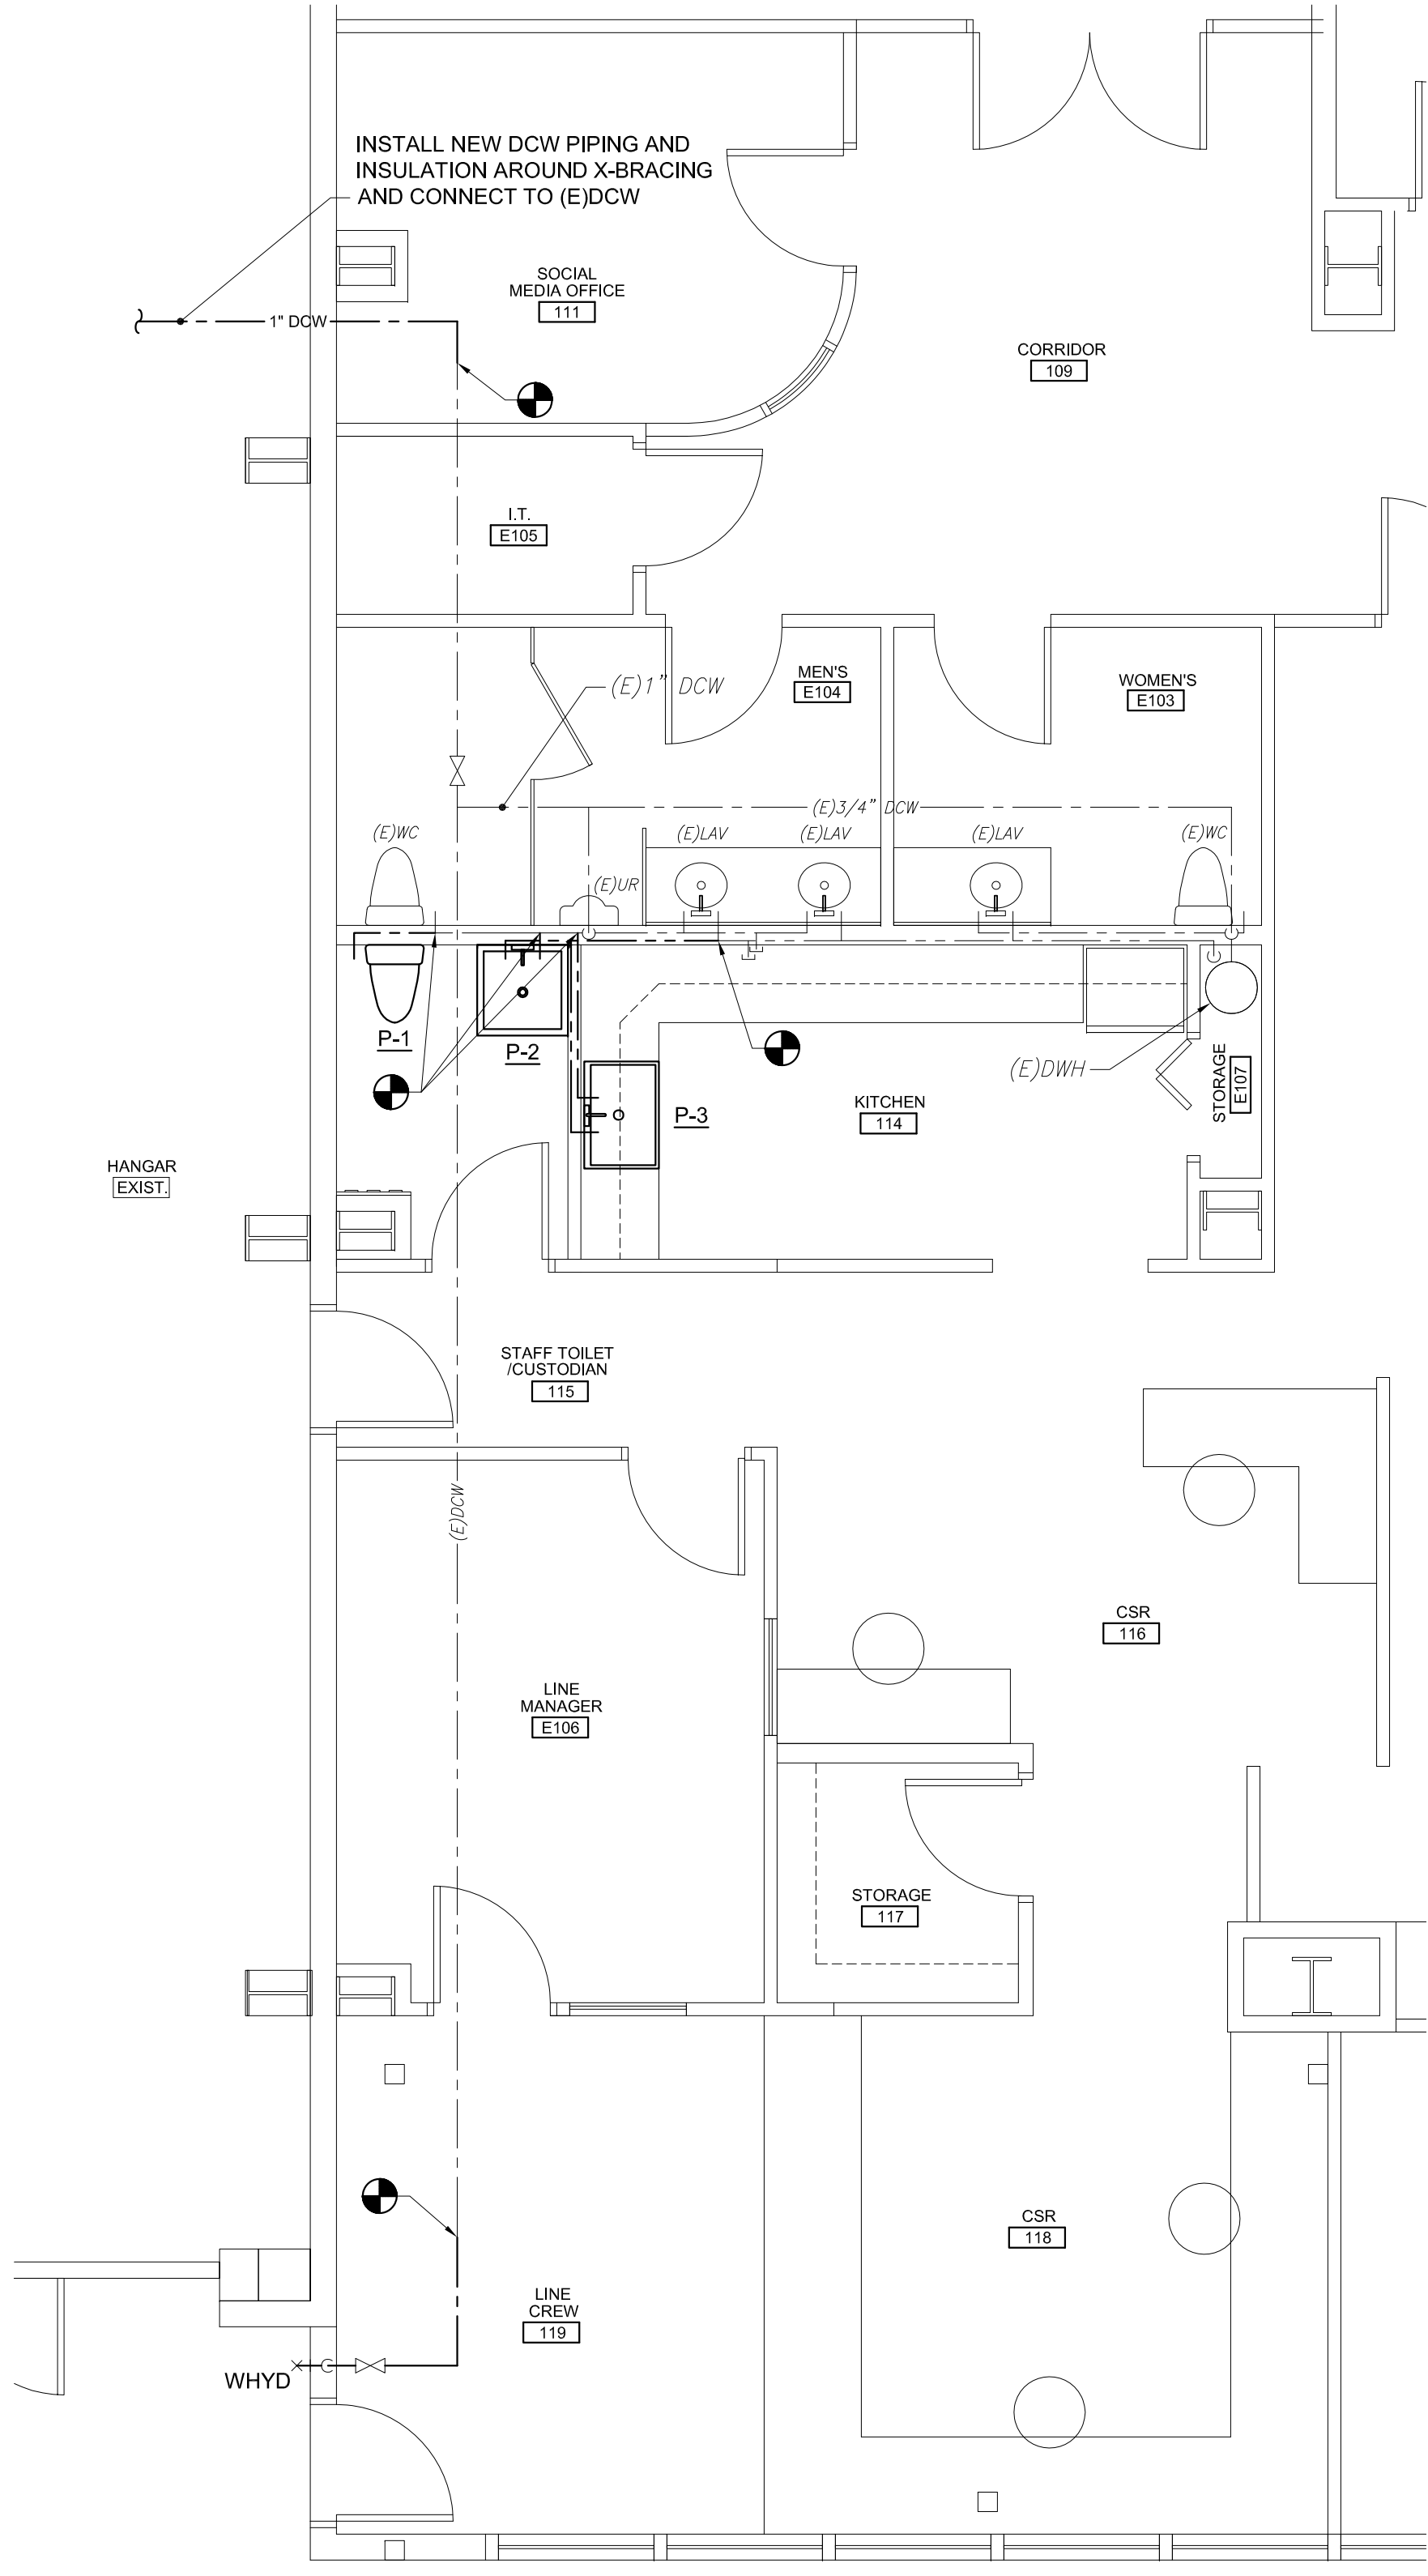


PLUMBING FIXTURE SCHEDULE						
TAG	DESCRIPTION	BRANCH SIZES				NOTES
		CW	HW	VENT	WASTE	
P-1	WATER CLOSET - TANK TYPE	1/2"	----	1-1/2"	3"	
P-2	MOP/SERVICE BASIN	1/2"	1/2"	1-1/2"	2"	
P-3	KITCHEN SINK	1/2"	1/2"	1-1/2"	2"	
WHYD	FREEZEPROOF WALL HYDRANT	1/2"	----	---	---	

NOTE:
FOR DETAIL OF PHASE I RAINWATER PIPING, SEE SHEET MH-2.

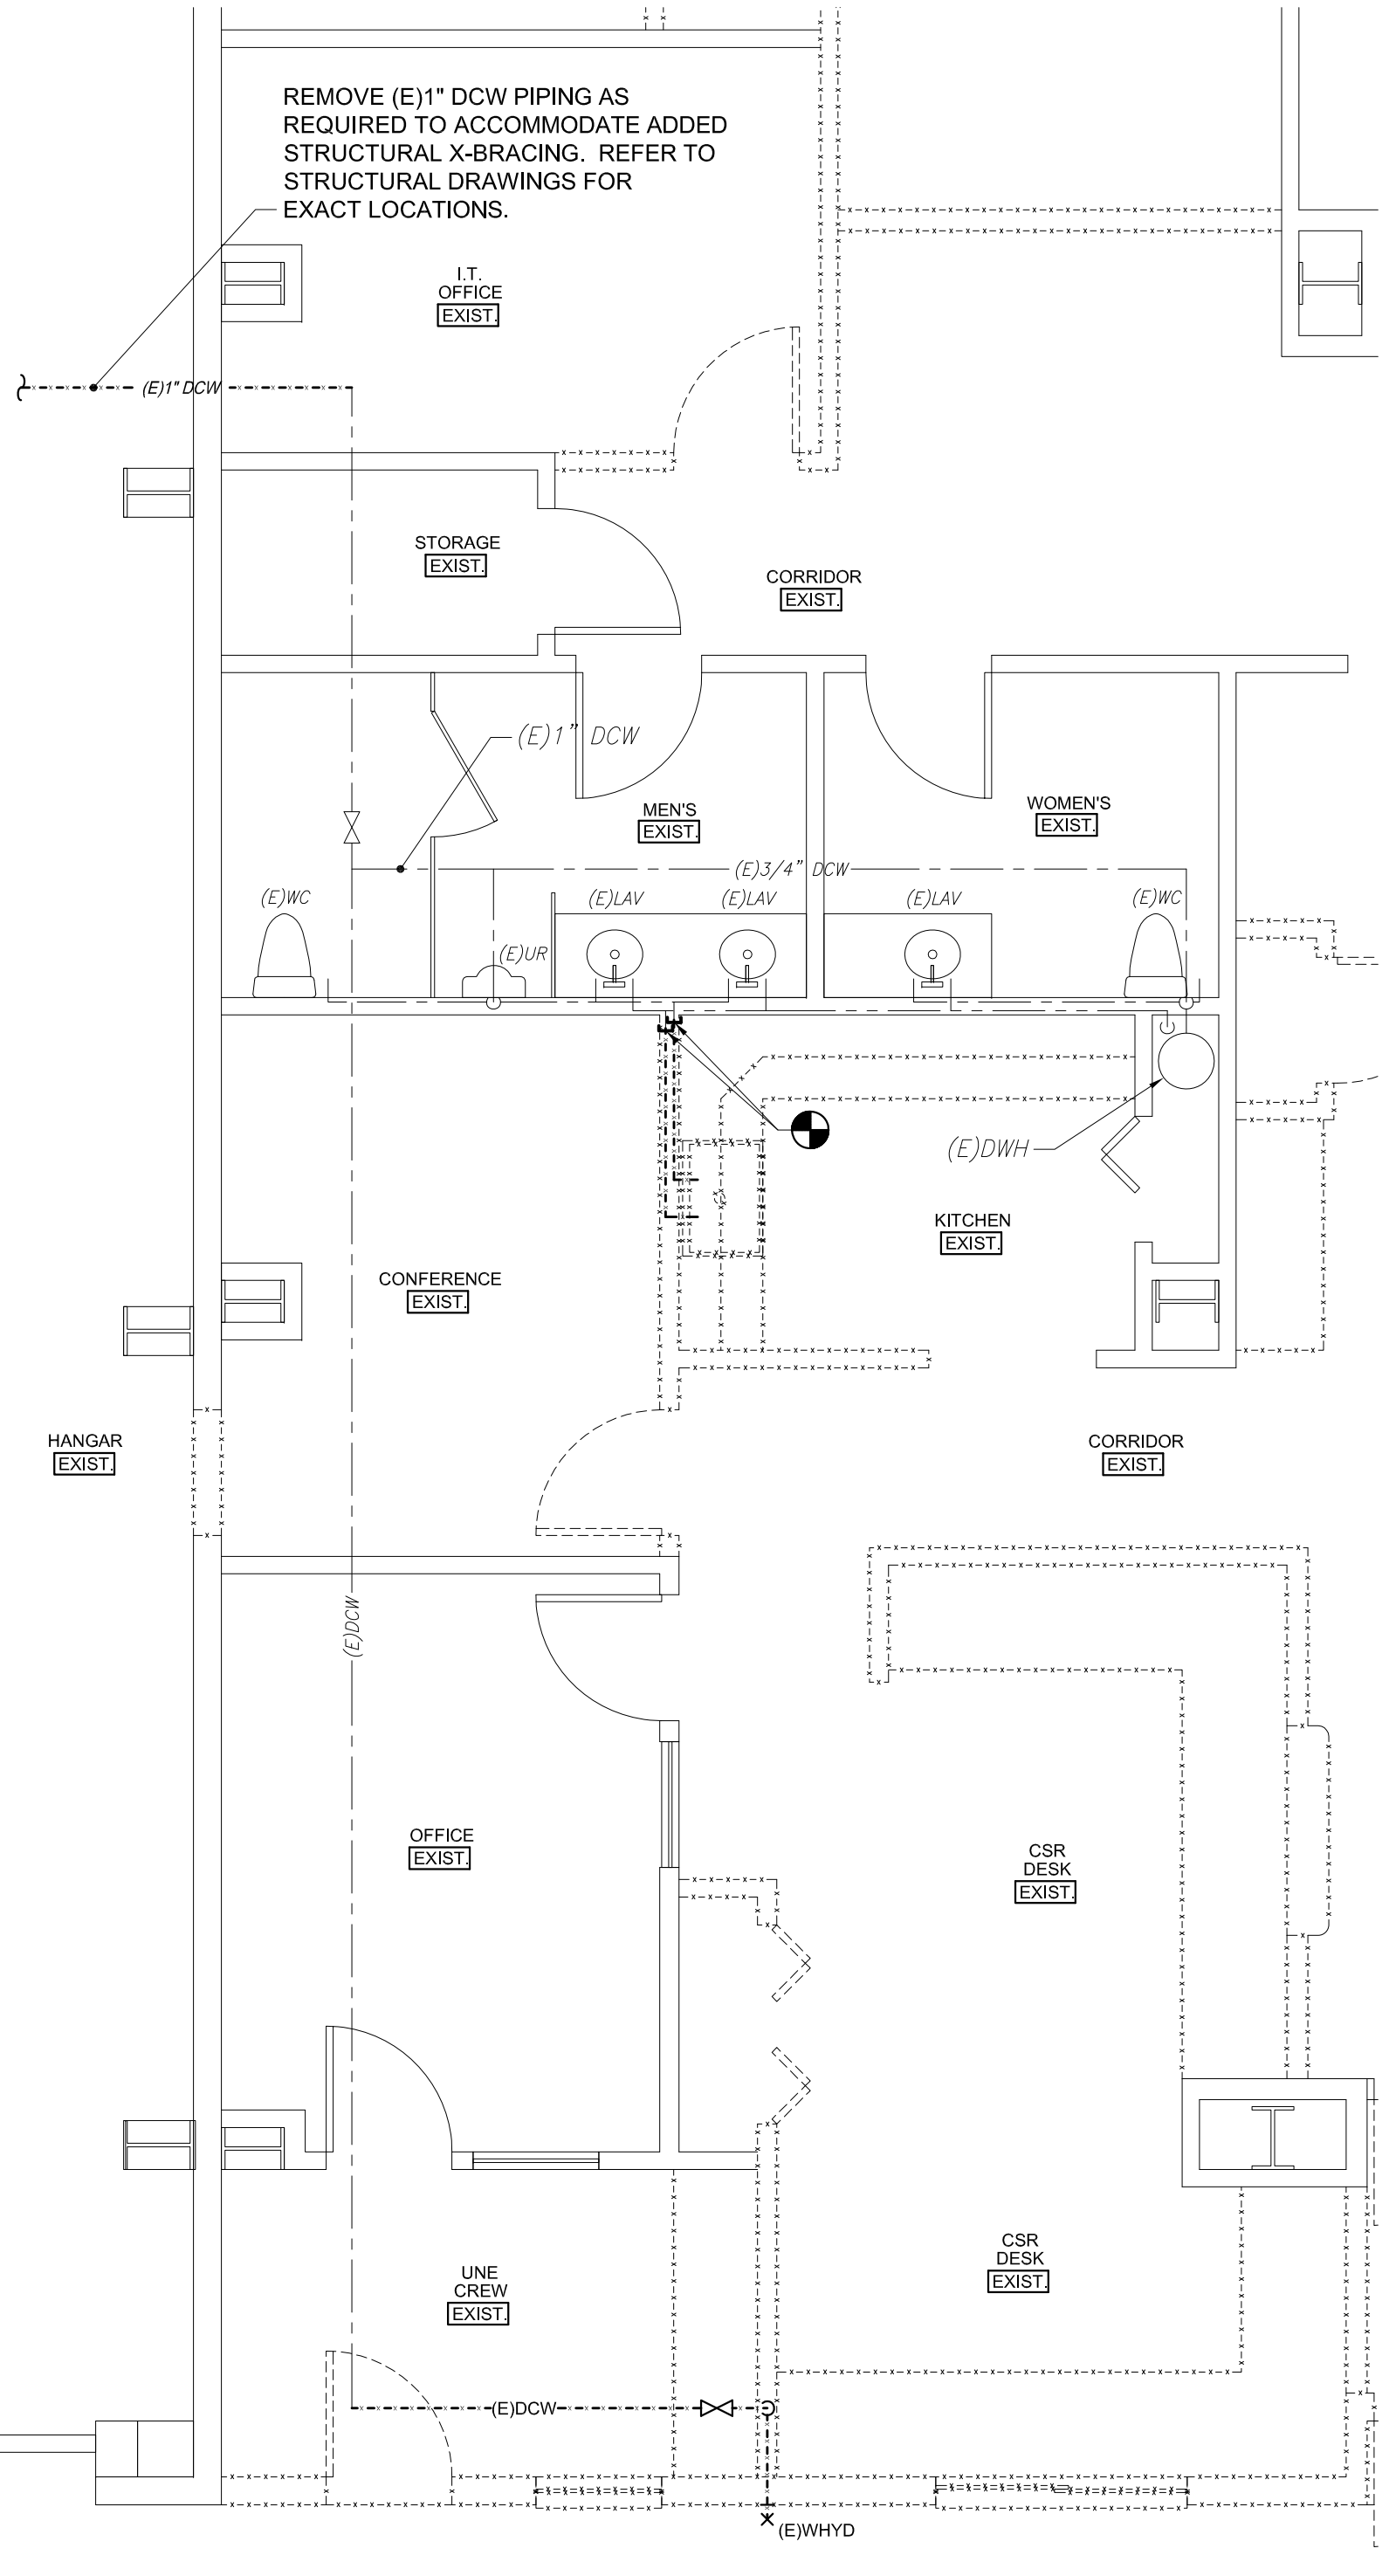

160 Veranda Street
Portland, Maine 04103
T: 207.221.2260
F: 207.221.2266
Web: www.allied-eng.com

Allied Engineering
Structural Mechanical Electrical Commissioning

GRANT HAYS ASSOCIATES
ARCHITECTURE & INTERIOR DESIGN
P.O. BOX 0179 FALMOUTH MAINE 04103
207.871.9500 www.granthays.com

Date: -
Drawn By: REW
Checked By: HAG
Project Mgr: WPF
Project No: 15028
Cad File: 15028M.DWG
Graphic Scale: 0' 1"

PLUMBING PART PLANS AND DETAILS

NEA NORTHEAST AIR
PORTLAND INTERNATIONAL JETPORT
1011 WESTBROOK STREET PORTLAND, MAINE 04102
© COPYRIGHT 2015 ALLIED ENGINEERING, INC.

PL-1

90% PRICING SET ~ 14 DECEMBER 2015 ~ NOT FOR CONSTRUCTION

N:\Projects\2015\15028 - Northeast Air Terminal Building\05 Drawing Files\2015\15028M.dwg Dec 14, 2015 10:08am