


N:\Project\201515028 - Northeast Air Terminal Building\00 Drawing Files\201515028_E.dwg Feb 16, 2016 - 2:48pm

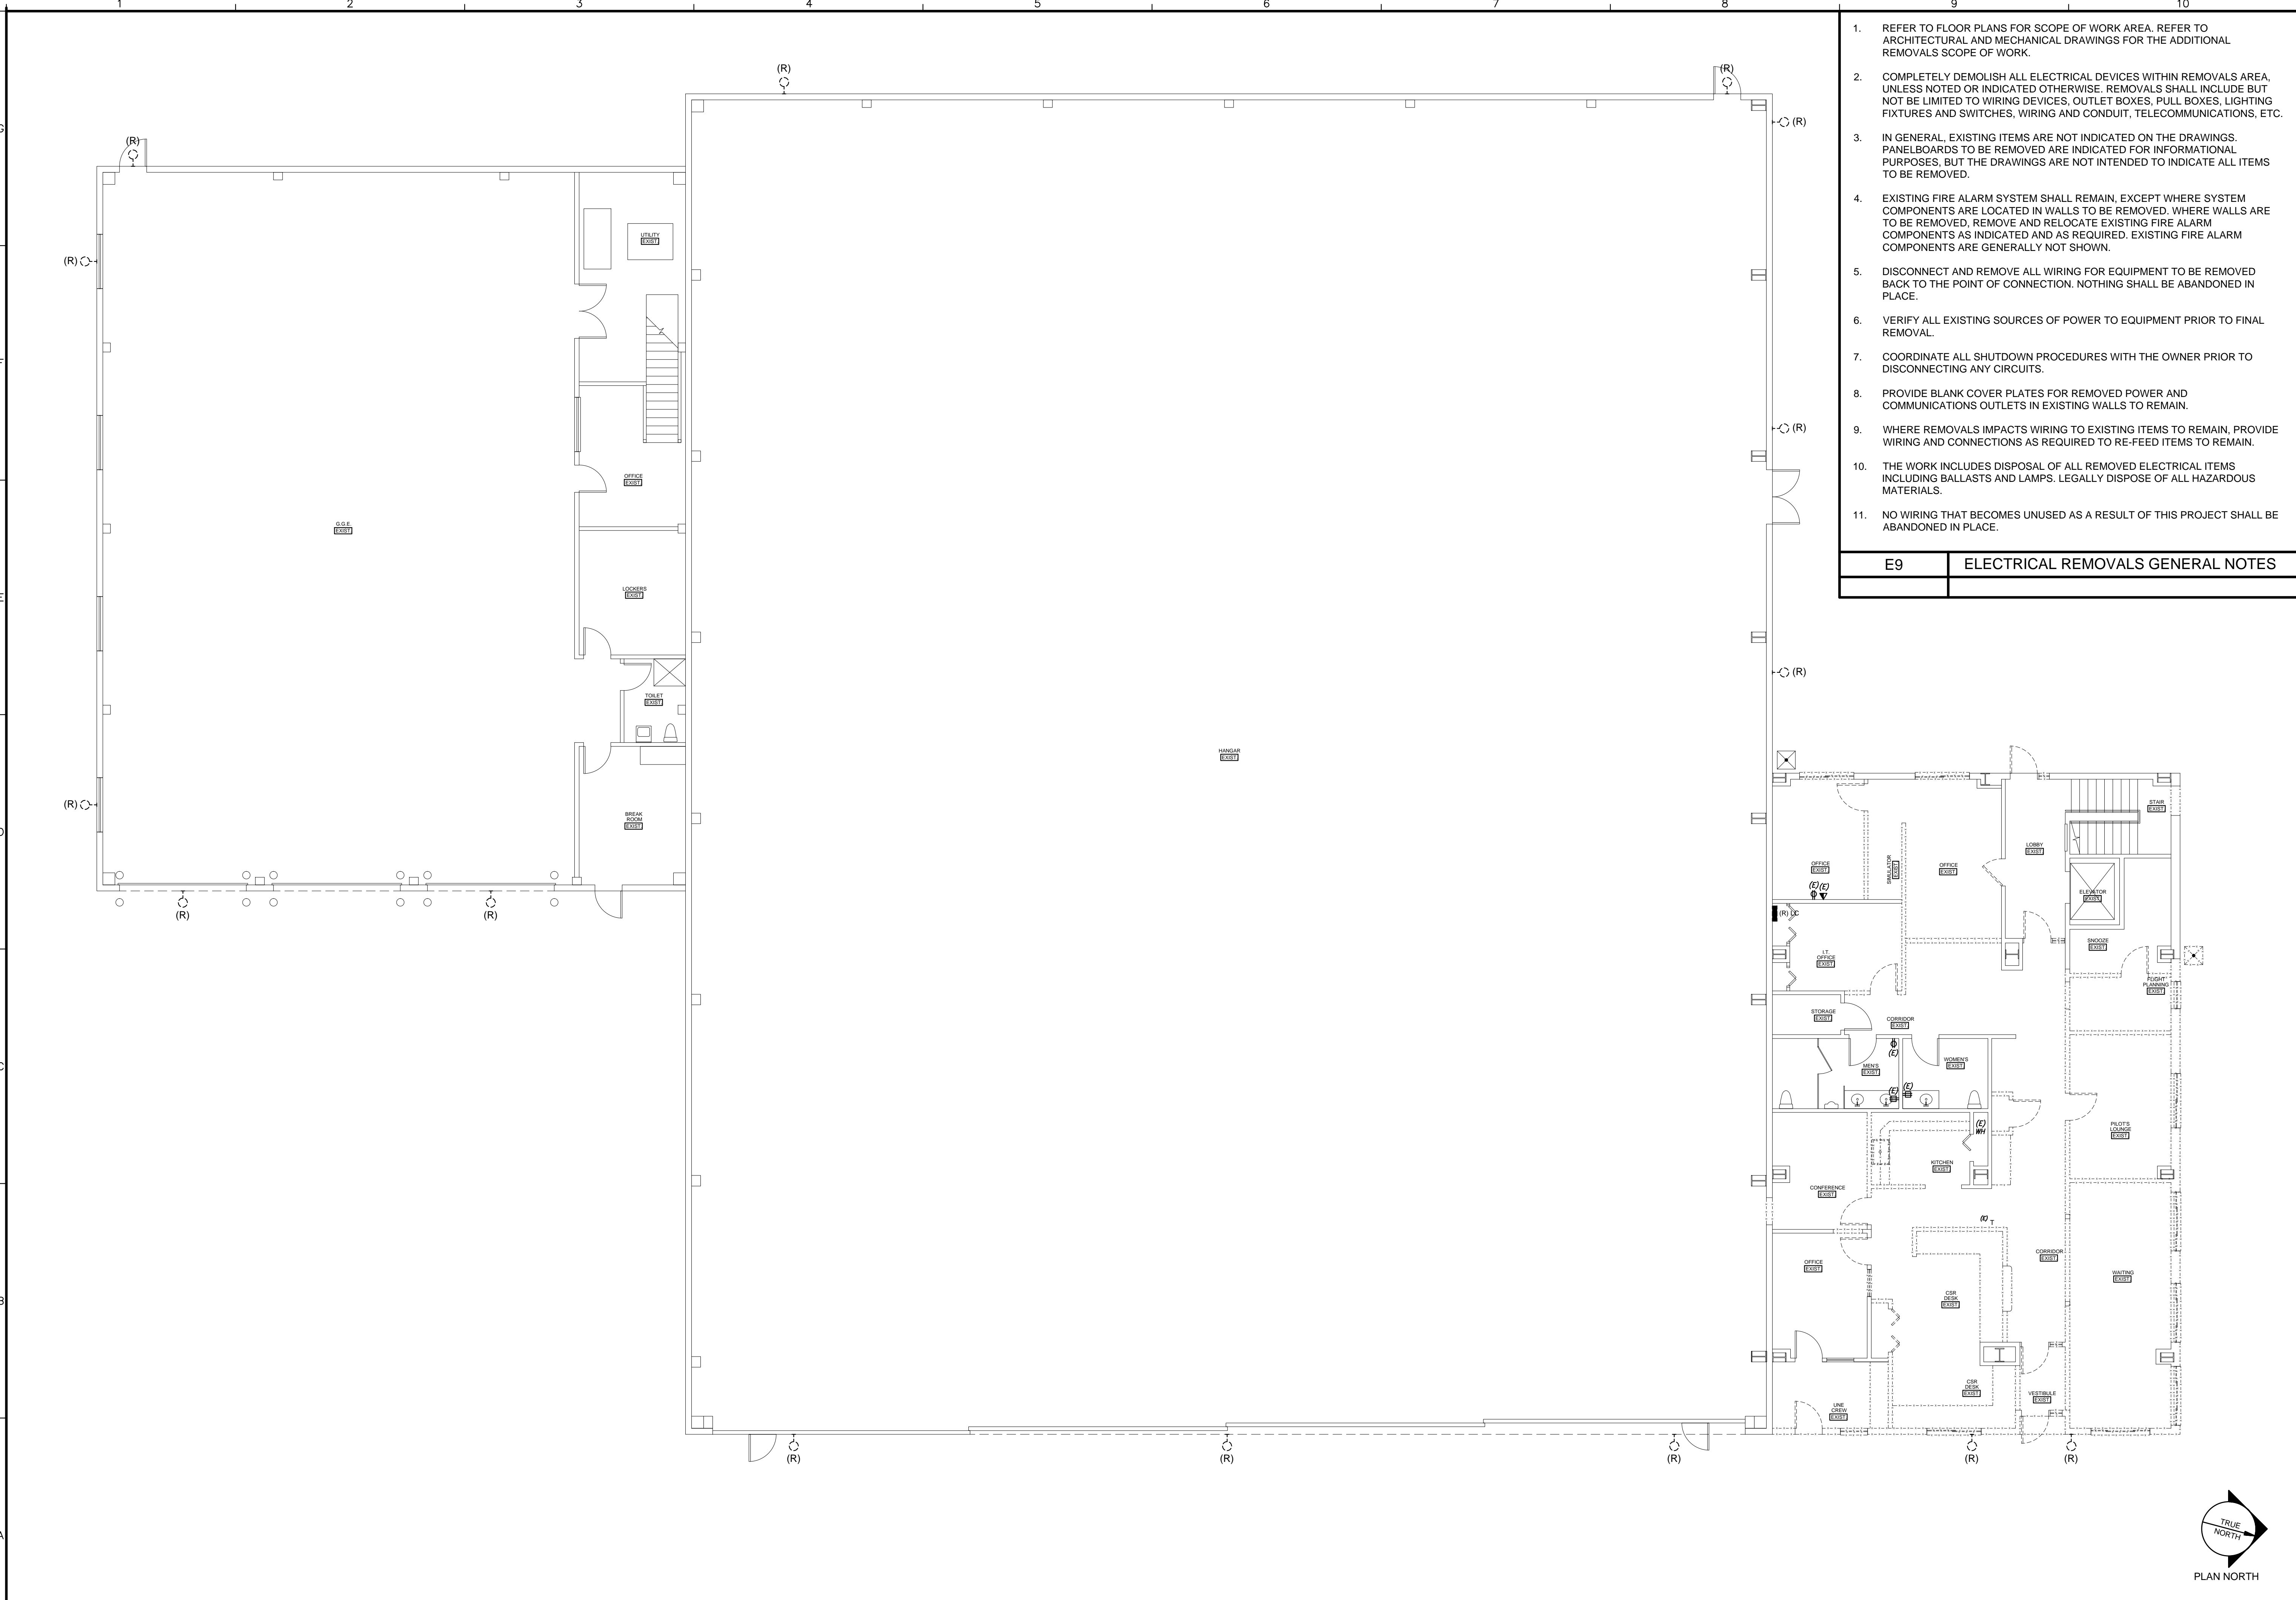


1. REFER TO FLOOR PLANS FOR SCOPE OF WORK AREA. REFER TO ARCHITECTURAL AND MECHANICAL DRAWINGS FOR THE ADDITIONAL REMOVALS SCOPE OF WORK.
2. COMPLETELY DEMOLISH ALL ELECTRICAL DEVICES WITHIN REMOVALS AREA, UNLESS NOTED OR INDICATED OTHERWISE. REMOVALS SHALL INCLUDE BUT NOT BE LIMITED TO WIRING DEVICES, OUTLET BOXES, PULL BOXES, LIGHTING FIXTURES AND SWITCHES, WIRING AND CONDUIT, TELECOMMUNICATIONS, ETC.
3. IN GENERAL, EXISTING ITEMS ARE NOT INDICATED ON THE DRAWINGS. PANELBOARDS TO BE REMOVED ARE INDICATED FOR INFORMATIONAL PURPOSES, BUT THE DRAWINGS ARE NOT INTENDED TO INDICATE ALL ITEMS TO BE REMOVED.
4. EXISTING FIRE ALARM SYSTEM SHALL REMAIN, EXCEPT WHERE SYSTEM COMPONENTS ARE LOCATED IN WALLS TO BE REMOVED. WHERE WALLS ARE TO BE REMOVED, REMOVE AND RELOCATE EXISTING FIRE ALARM COMPONENTS AS INDICATED AND AS REQUIRED. EXISTING FIRE ALARM COMPONENTS ARE GENERALLY NOT SHOWN.
5. DISCONNECT AND REMOVE ALL WIRING FOR EQUIPMENT TO BE REMOVED BACK TO THE POINT OF CONNECTION. NOTHING SHALL BE ABANDONED IN PLACE.
6. VERIFY ALL EXISTING SOURCES OF POWER TO EQUIPMENT PRIOR TO FINAL REMOVAL.
7. COORDINATE ALL SHUTDOWN PROCEDURES WITH THE OWNER PRIOR TO DISCONNECTING ANY CIRCUITS.
8. PROVIDE BLANK COVER PLATES FOR REMOVED POWER AND COMMUNICATIONS OUTLETS IN EXISTING WALLS TO REMAIN.
9. WHERE REMOVALS IMPACTS WIRING TO EXISTING ITEMS TO REMAIN, PROVIDE WIRING AND CONNECTIONS AS REQUIRED TO RE-FEED ITEMS TO REMAIN.
10. THE WORK INCLUDES DISPOSAL OF ALL REMOVED ELECTRICAL ITEMS INCLUDING BALLASTS AND LAMPS. LEGALLY DISPOSE OF ALL HAZARDOUS MATERIALS.
11. NO WIRING THAT BECOMES UNUSED AS A RESULT OF THIS PROJECT SHALL BE ABANDONED IN PLACE.

E9	ELECTRICAL REMOVALS GENERAL NOTES
----	-----------------------------------

**160 Veranda Street
Portland, Maine 04103**
**T: 207.221.2260
F: 207.221.2266
Web: www.allied-eng.com**

Allied Engineering
 Structural Mechanical Electrical Commissioning

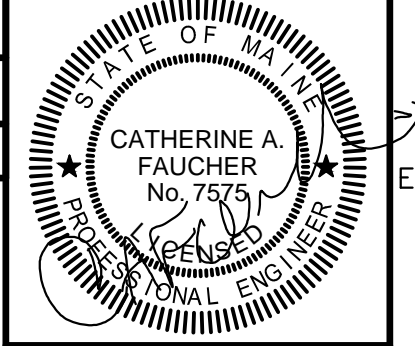

GRANT HAYS ASSOCIATES
 ARCHITECTURE & INTERIOR DESIGN
 P.O. BOX 6199 FALMOUTH MAINE 04105
 207.571.9100 www.granthays.com

Date:	02-12-2016
Drawn By:	DLL
Checked By:	SRM
Project Mgr:	WPF
Project No.:	15028
Card File:	15028_E.DWG
Graphic Scale:	0 1"

ELECTRICAL REMOVALS PLAN

NEA NORTH EAST AIR
 PORTLAND INTERNATIONAL AIRPORT
 PORTLAND, MAINE 04102
 1011 WESTBROOK STREET

© Copyright 2016 NEA ENGINEERING, INC.