


N:\Projects\2015\15028 - Northeast Air Terminal Building\03 Drawing Files\2015\15028M.dwg Feb 12, 2016 6:48am

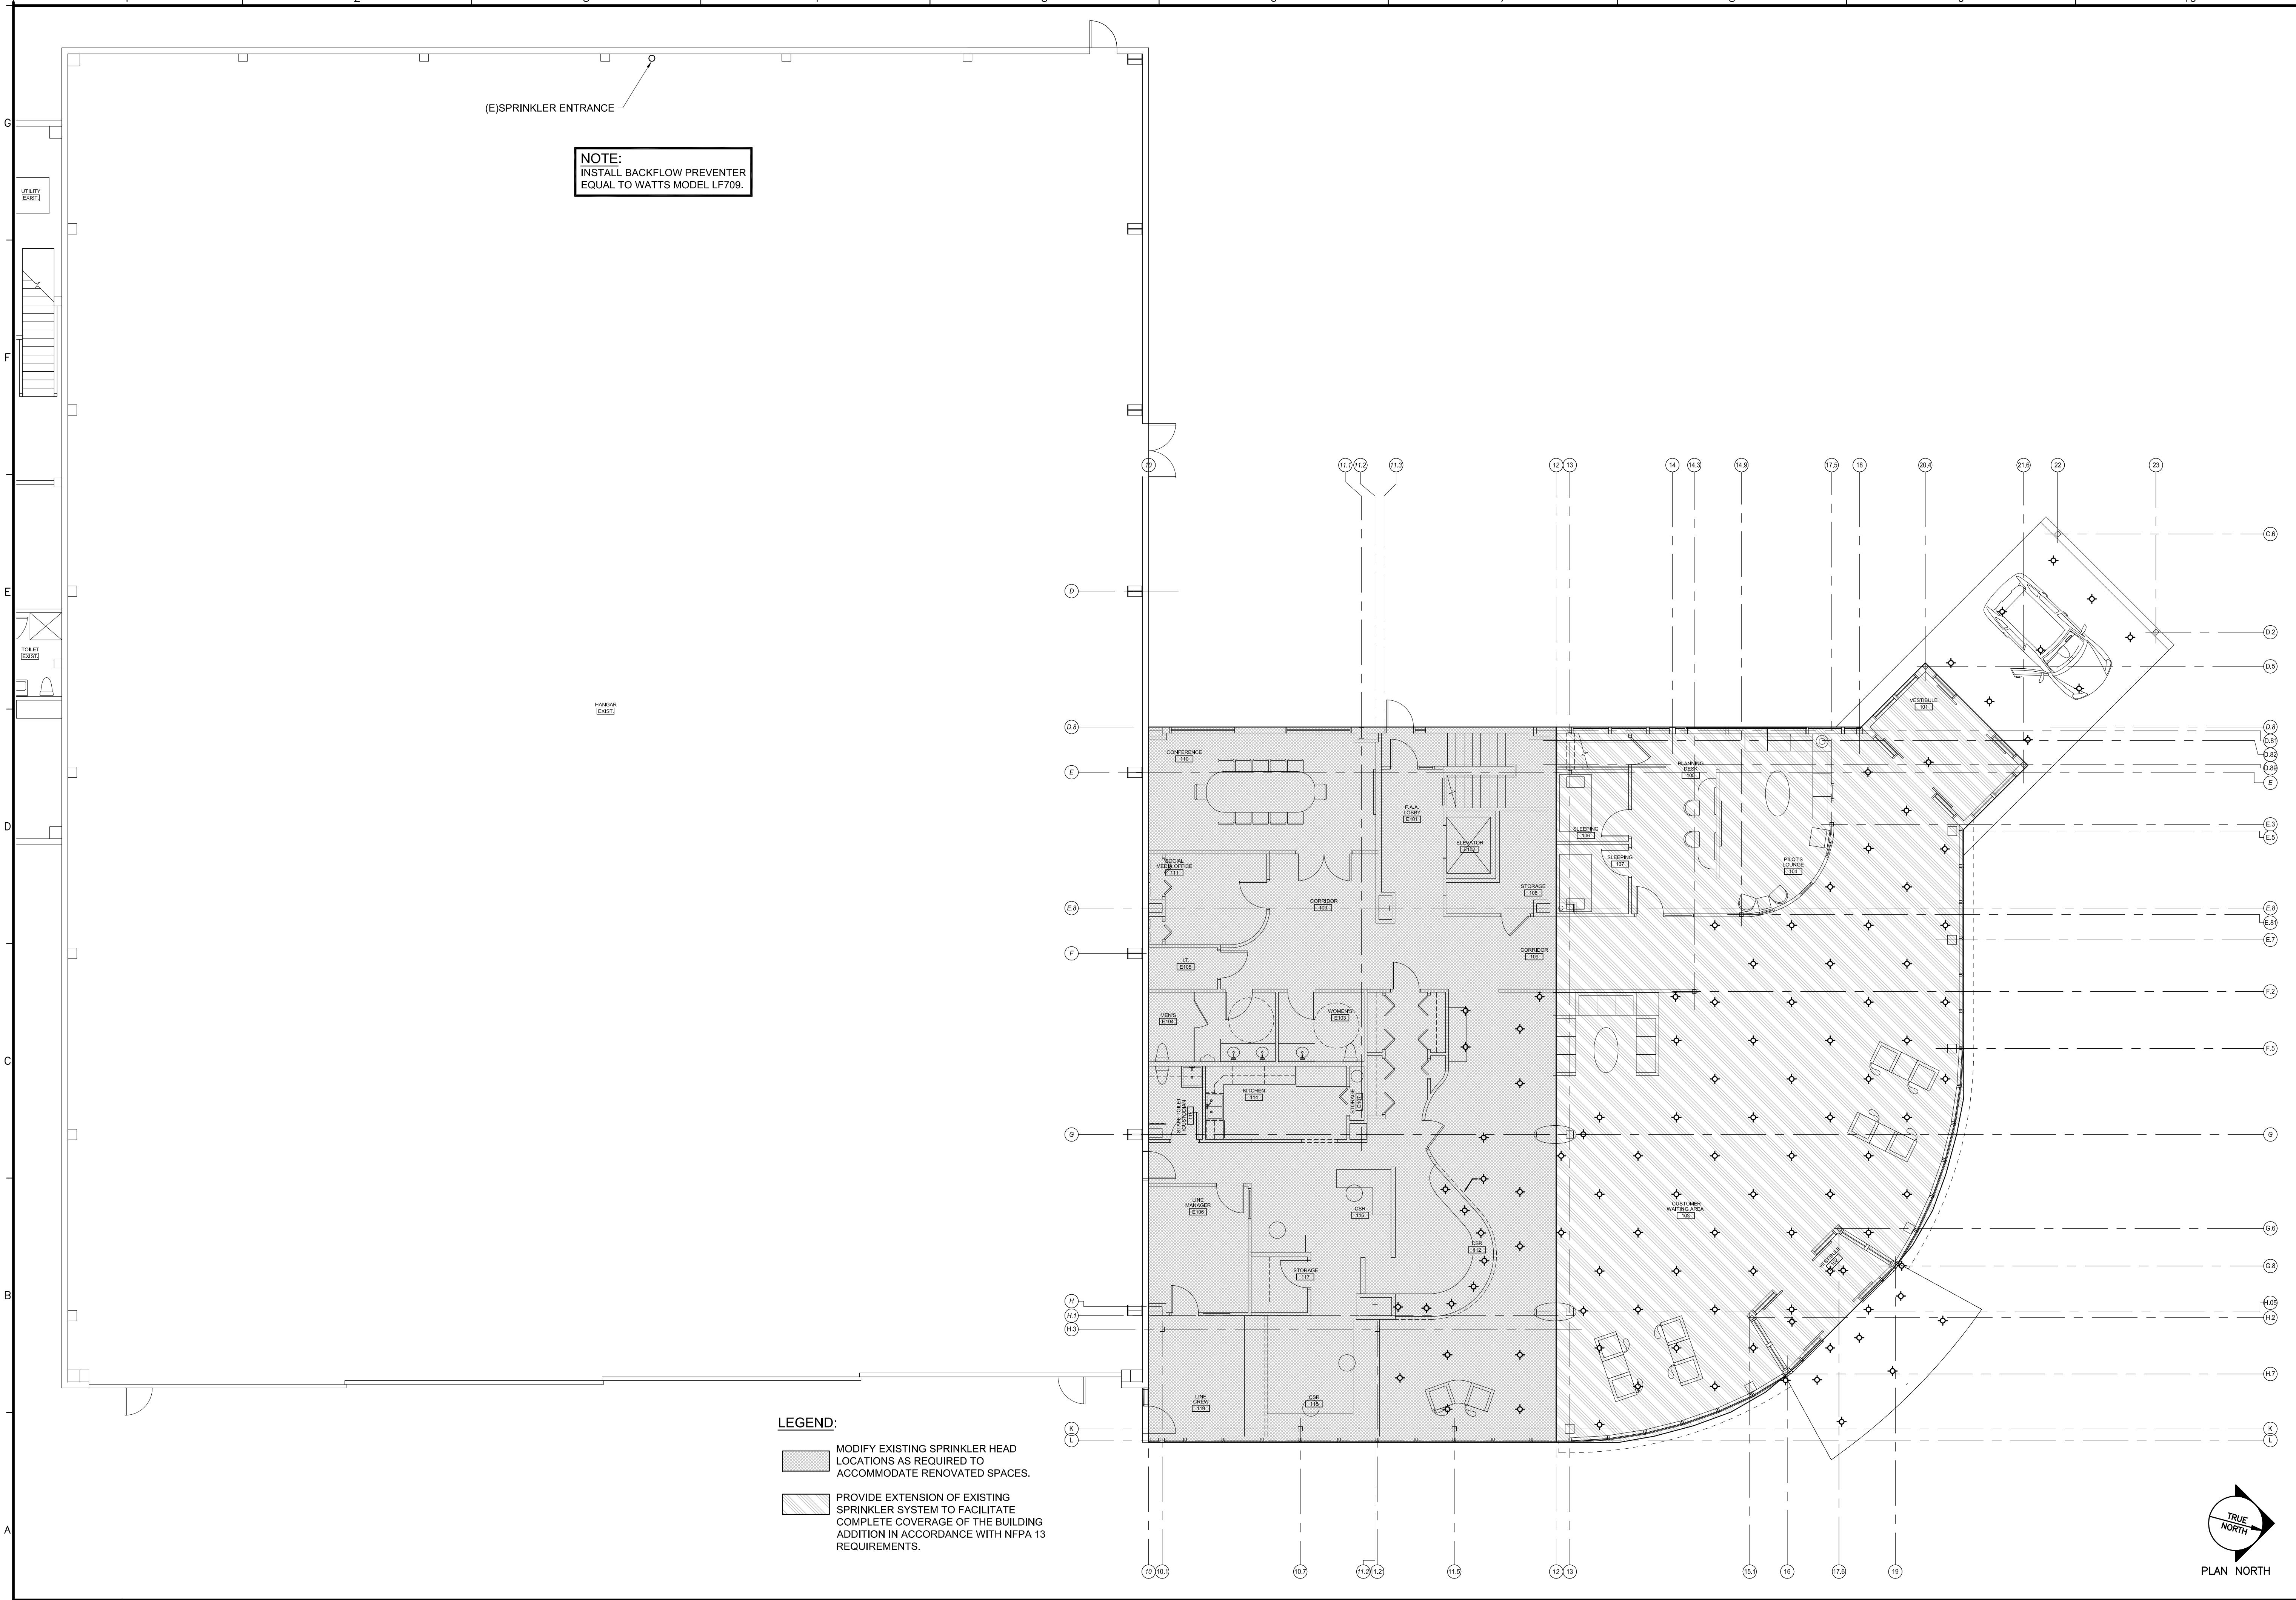


A1 MECHANICAL PLAN  
1/8" = 1'-0"

Date:	02-12-2016
Drawn By:	REW
Checked By:	HAG
Project Mgr:	WPF
Project No.:	15028
Card File:	15028M.DWG
Graphic Scale:	0 1'

**FIRE PROTECTION PLAN**

**NEA**  
NORTHEAST AIR  
PORTLAND INTERNATIONAL JETPORT  
PORTLAND, MAINE 04102  
1011 WESTBROOK STREET

© COPYRIGHT 2015 ALLIED ENGINEERING, INC.

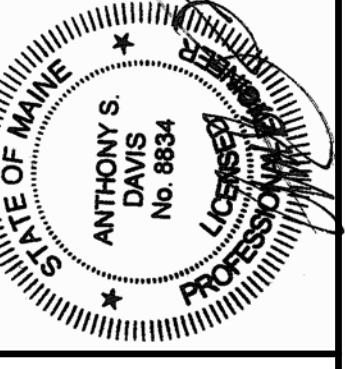

**GRANT HAYS ASSOCIATES**  
ARCHITECTURE & INTERIOR DESIGN  
P.O. BOX 6179 FALMOUTH MAINE 04105  
207.871.9500 www.granthays.com

**Allied Engineering**  
Structural Mechanical Electrical Commissioning

160 Veranda Street  
Portland, Maine 04103  
T: 207.221.2260  
F: 207.221.2266  
Web: www.allied-eng.com

**FP-1**