
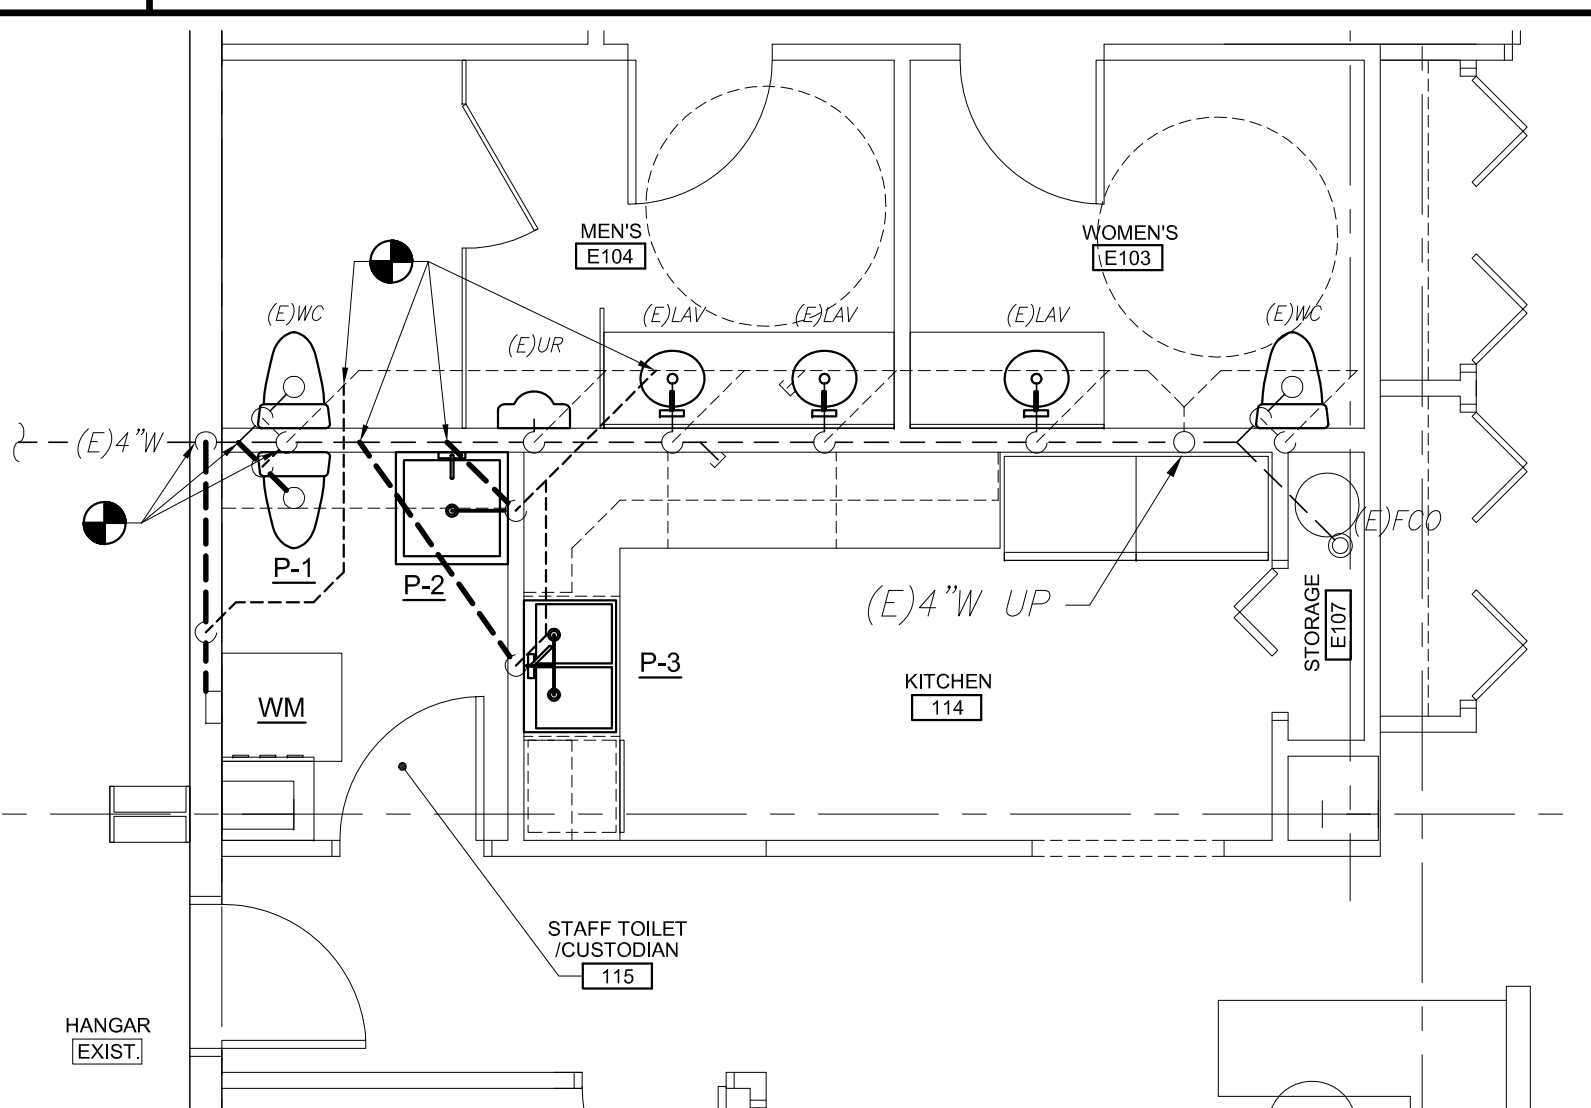
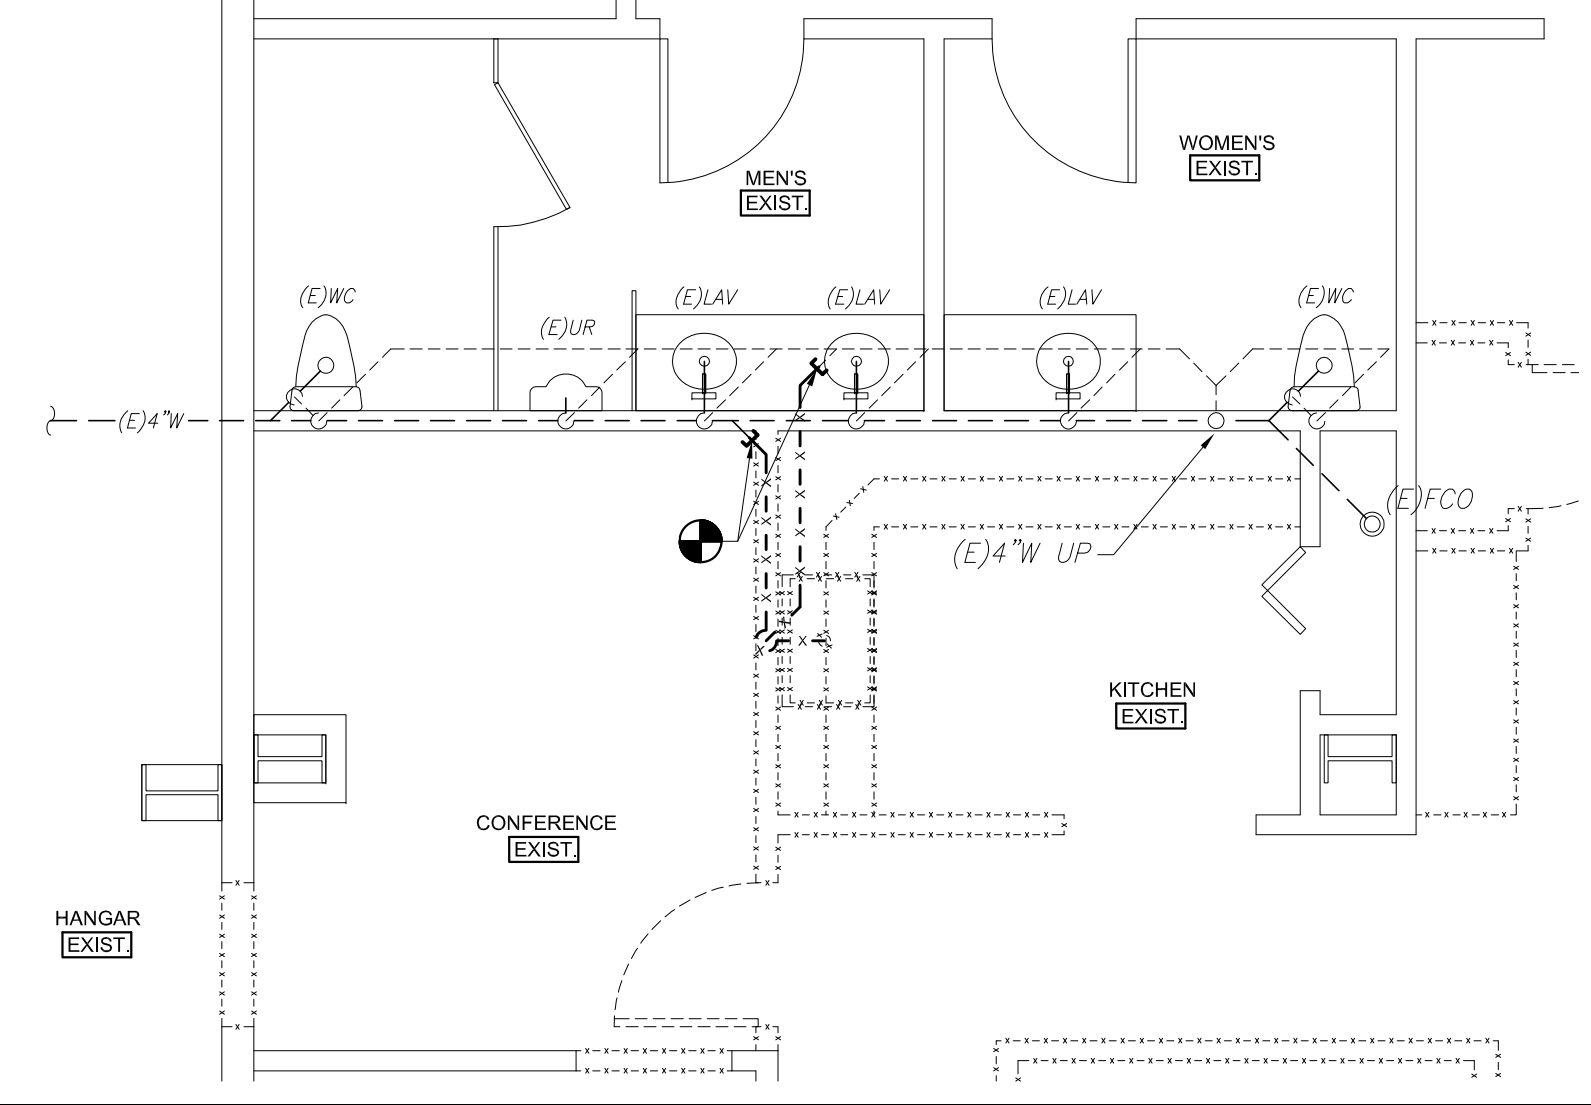
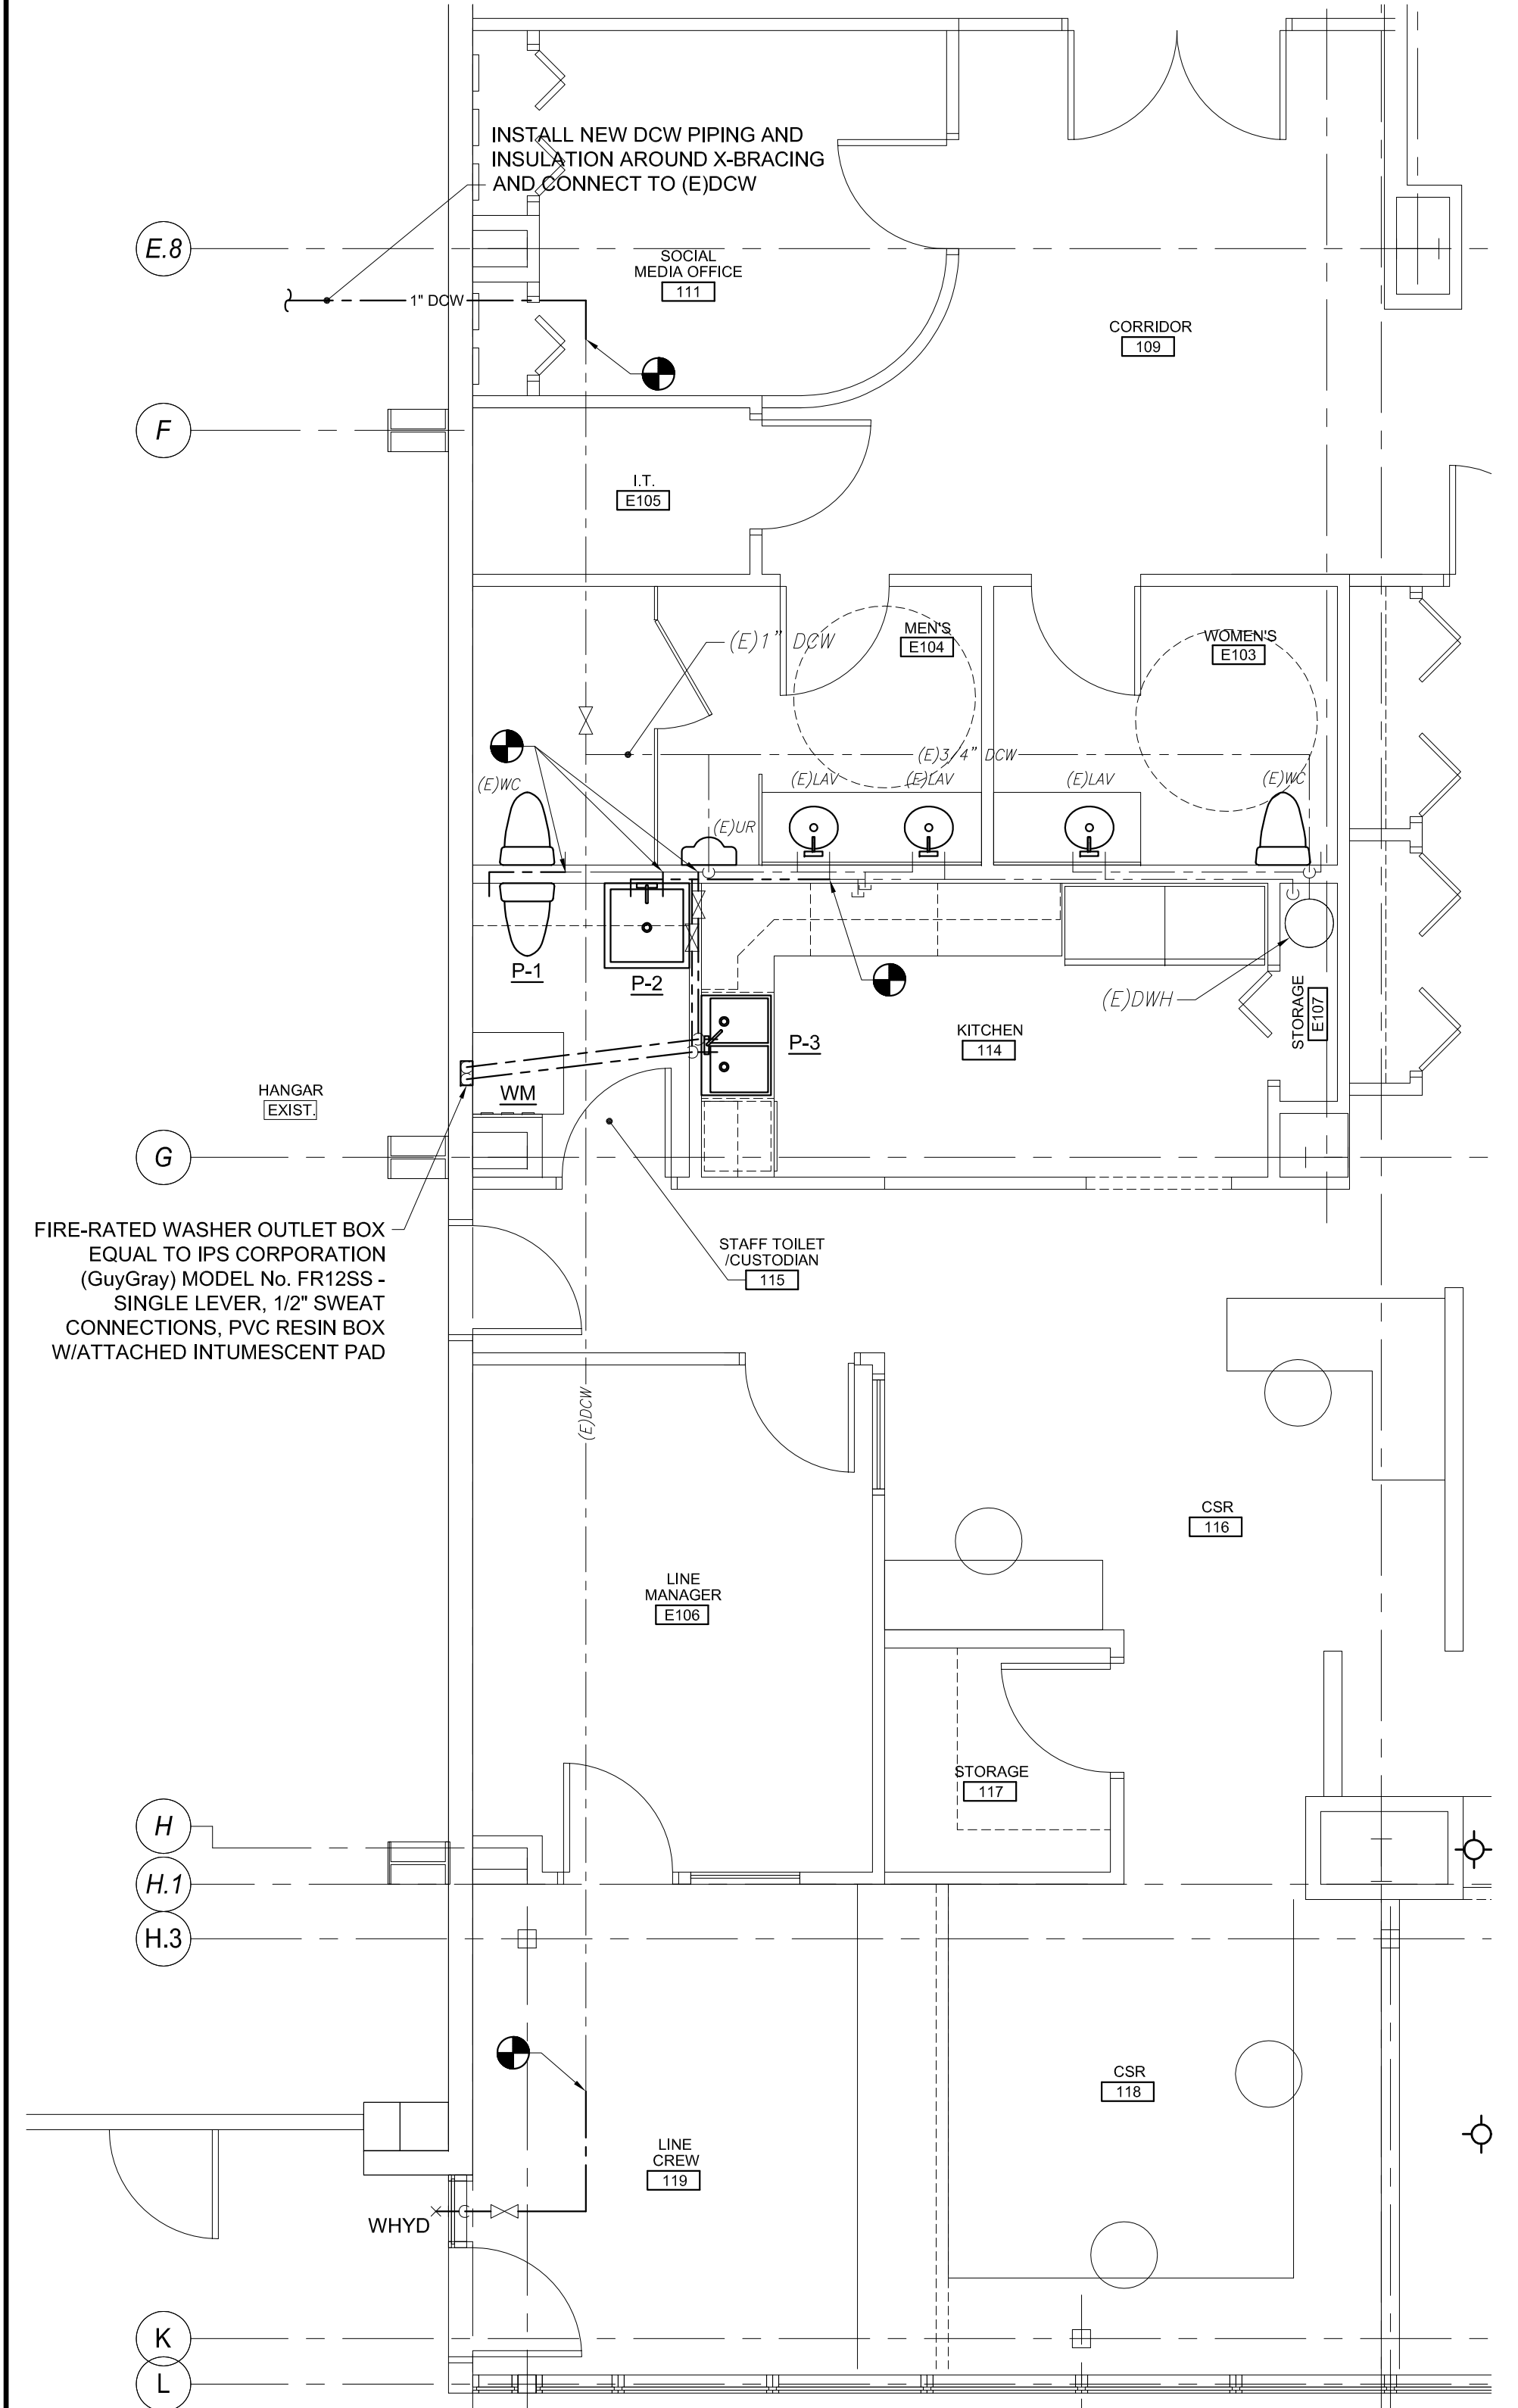



PLUMBING FIXTURE SCHEDULE						
TAG	DESCRIPTION	BRANCH SIZES			NOTES	
		CW	HW	WASTE		
P-1	WATER CLOSET - TANK TYPE	1/2"	----	1-1/2"	3"	
P-2	MOP/SERVICE BASIN	1/2"	1/2"	1-1/2"	2"	
P-3	KITCHEN SINK	1/2"	1/2"	1-1/2"	2"	
WM	WASHING MACHINE	1/2"	1/2"	1-1/2"	2"	PROVIDED BY OWNER
WHYD	FREEZEPROOF WALL HYDRANT	1/2"	----	----	----	

NOTE:
FOR DETAIL OF PHASE I RAINWATER PIPING, SEE SHEET MH-2.

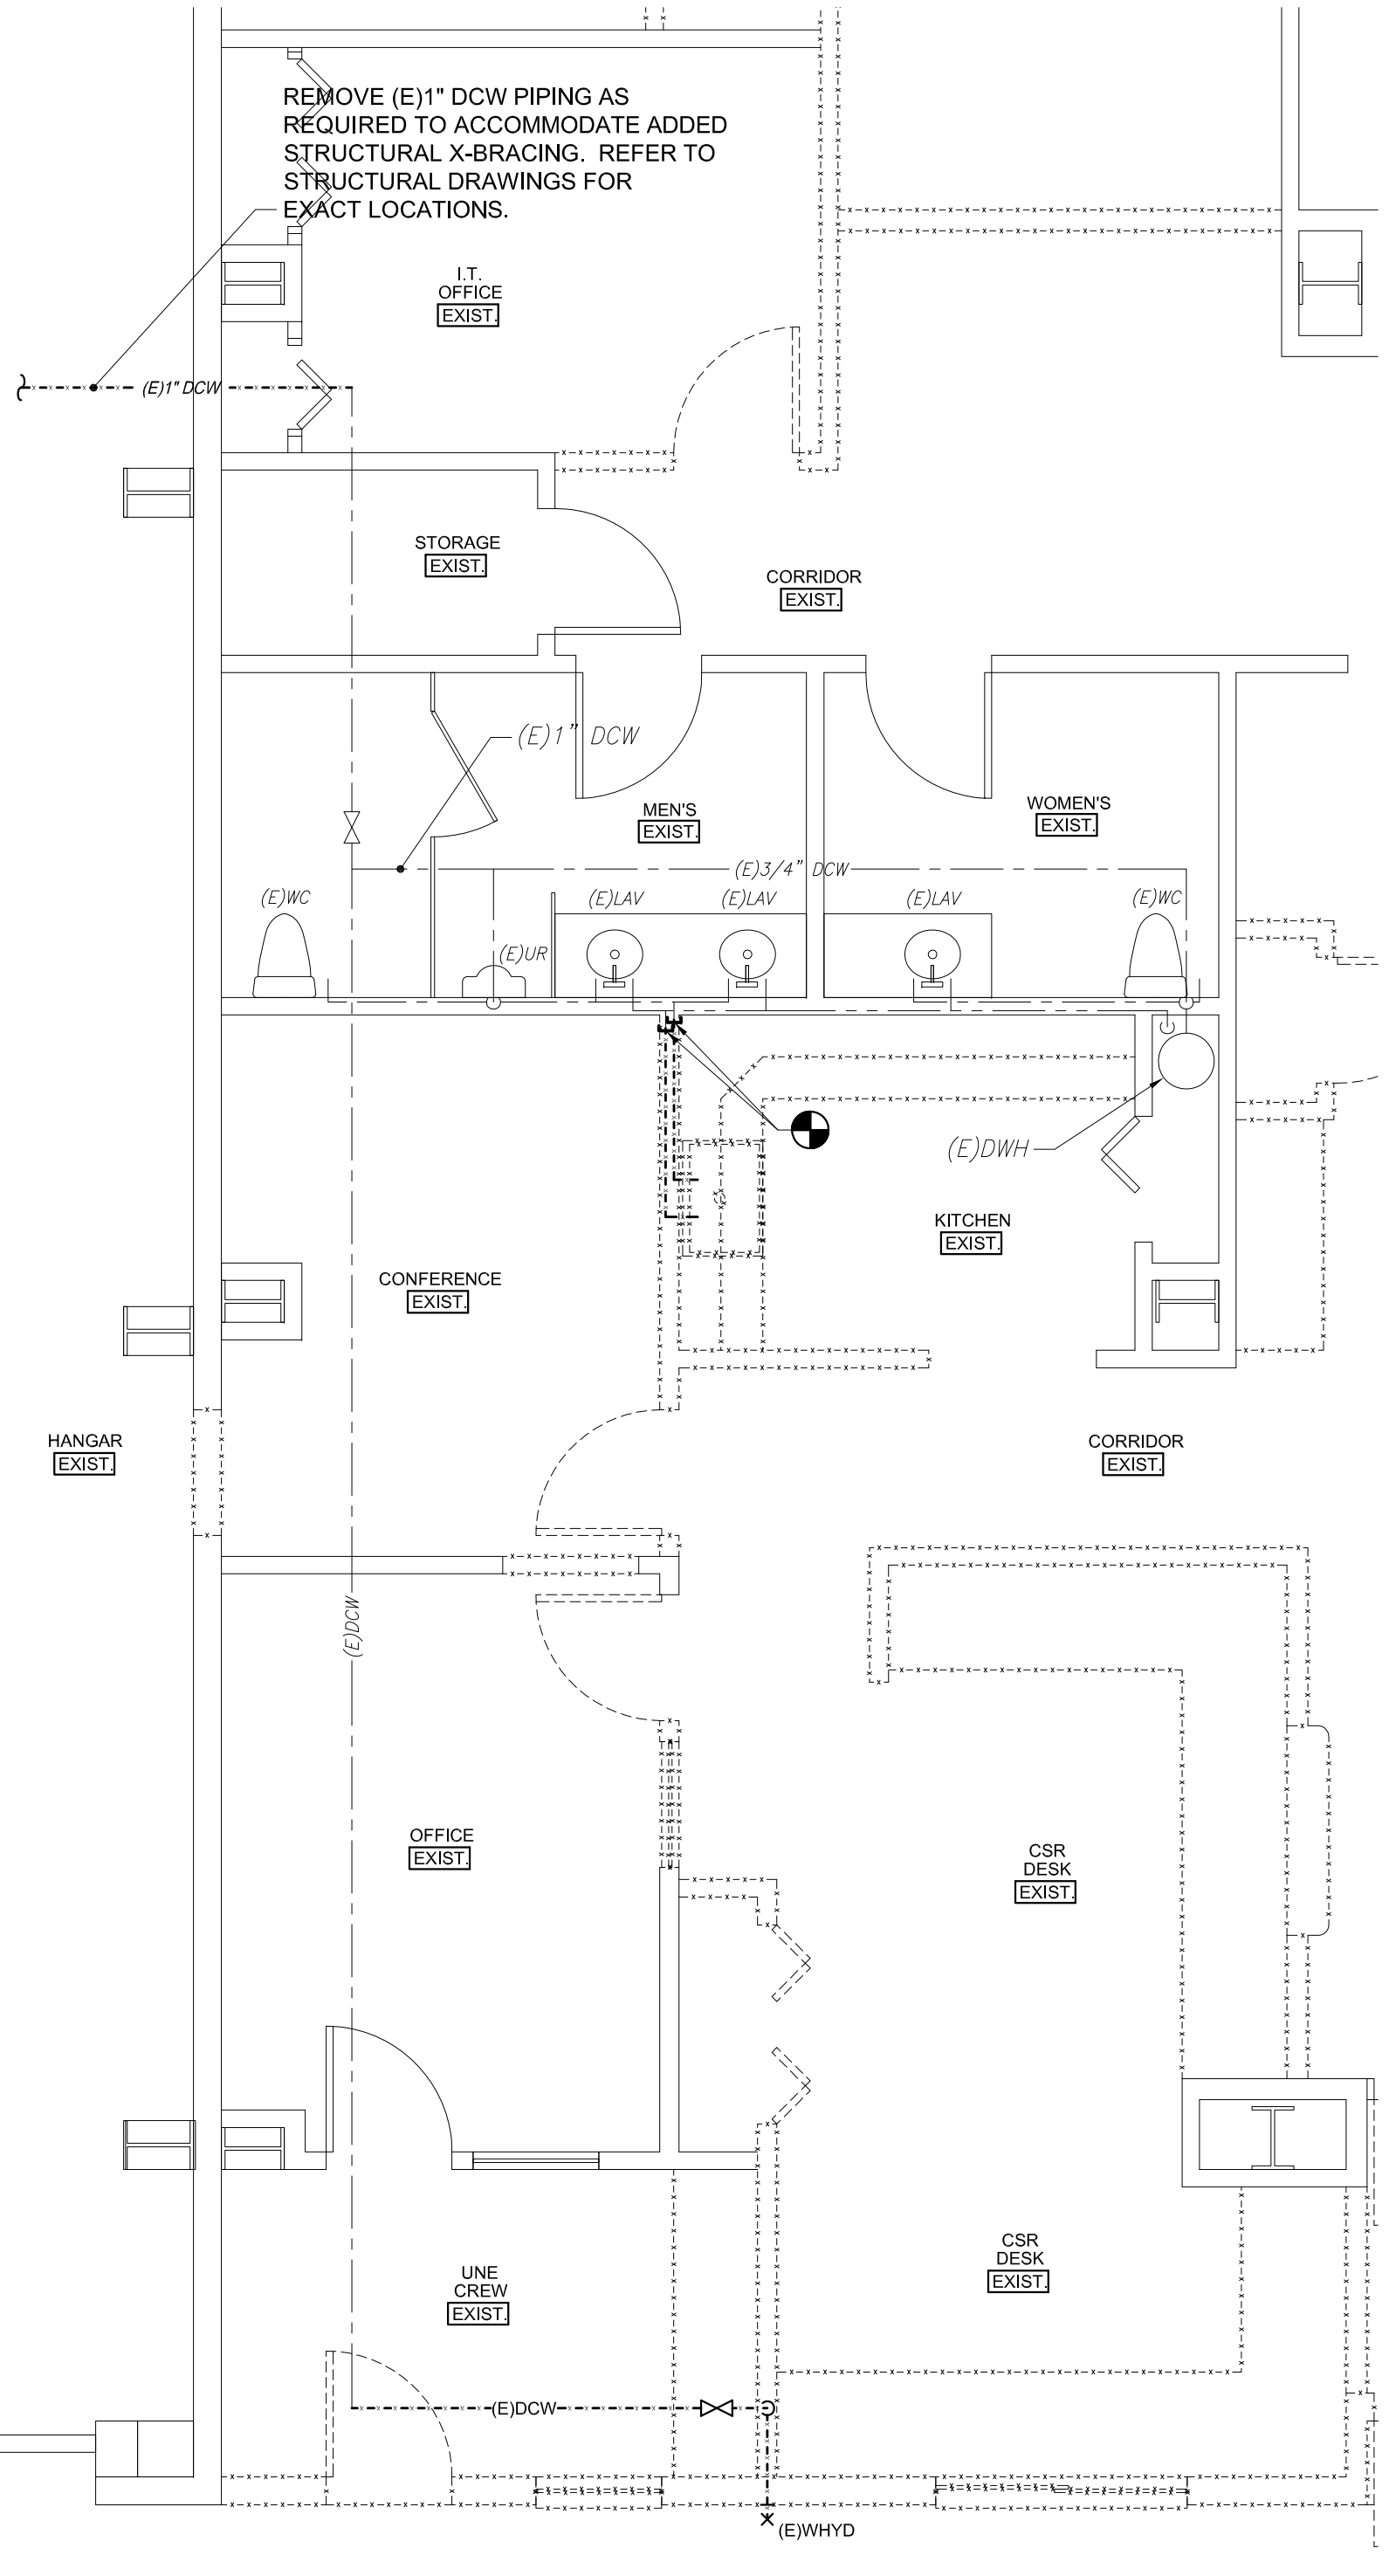

160 Veranda Street
Portland, Maine 04103
T: 207.221.2260
F: 207.221.2266
Web: www.allied-eng.com

Allied Engineering
Structural Mechanical Electrical Commissioning

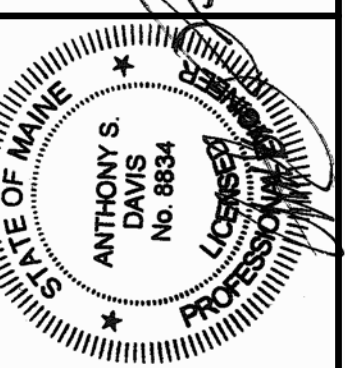

GRANT HAYS ASSOCIATES
ARCHITECTURE & INTERIOR DESIGN
P.O. BOX 6179 FALMOUTH MAINE 04103
207.871.9500 www.granthays.com

Date: 02-12-2016
Drawn By: REV
Checked By: HAG
Project Mgr: WPF
Project No: 15028
Cad File: 15028M.DWG
Graphic Scale: 0' 1"

PLUMBING PART PLANS AND DETAILS
NFA NORTHEAST AIR
PORTLAND INTERNATIONAL JETPORT
1011 WESTBROOK STREET PORTLAND, MAINE 04102
© COPYRIGHT 2015 ALLIED ENGINEERING, INC.

PL-1

N:\Projects\2015\15028 - Northeast Air Terminal Building\05 Drawing Files\2015\15028M.dwg Feb 12, 2016 - 6:48am