



Stantec Consulting Services Inc.
 5 Dartmouth Drive, Suite 101
 Auburn NH U.S.A.
 03032-3984
 Tel. 603.669.8672
 Fax. 603.669.7636
 www.stantec.com

Stantec


Copyright Reserved

The Contractor shall verify and be responsible for all dimensions. DO NOT scale the drawing - any errors or omissions shall be reported to Stantec without delay.
 The Copyrights to all designs and drawings are the property of Stantec. Reproduction or use for any purpose other than that authorized by Stantec is forbidden.

Consultants

Legend

Notes

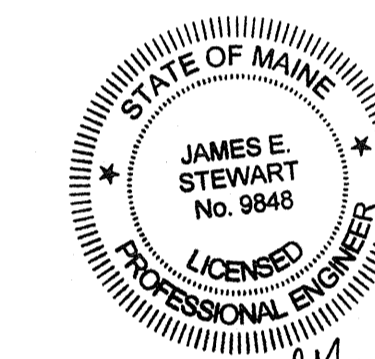

JES 9-27-13

Revision	By	Appd.	YY.MM.DD
ISSUE FOR PERMIT	JES	JES	13.09.27
ISSUE FOR BID	JES	JES	13.09.10
Issued	By	Appd.	YY.MM.DD

File Name	JSW	JKM/JSC	JSW	1-20-12
	Dwn.	Chkd.	Degn.	YY.MM.DD
03_191711186_FS.P.dwg				




Client/Project
 THE HERTZ CORPORATION

ABOVEGROUND STORAGE TANK
 INSTALLATION AND RELATED WORK
 PORTLAND, ME

Title
 UNDERGROUND PIPING PLAN

Project No.	Scale	
191711186	AS NOTED	
Drawing No.	Sheet	Revision
FS.P.1	13 of 19	0

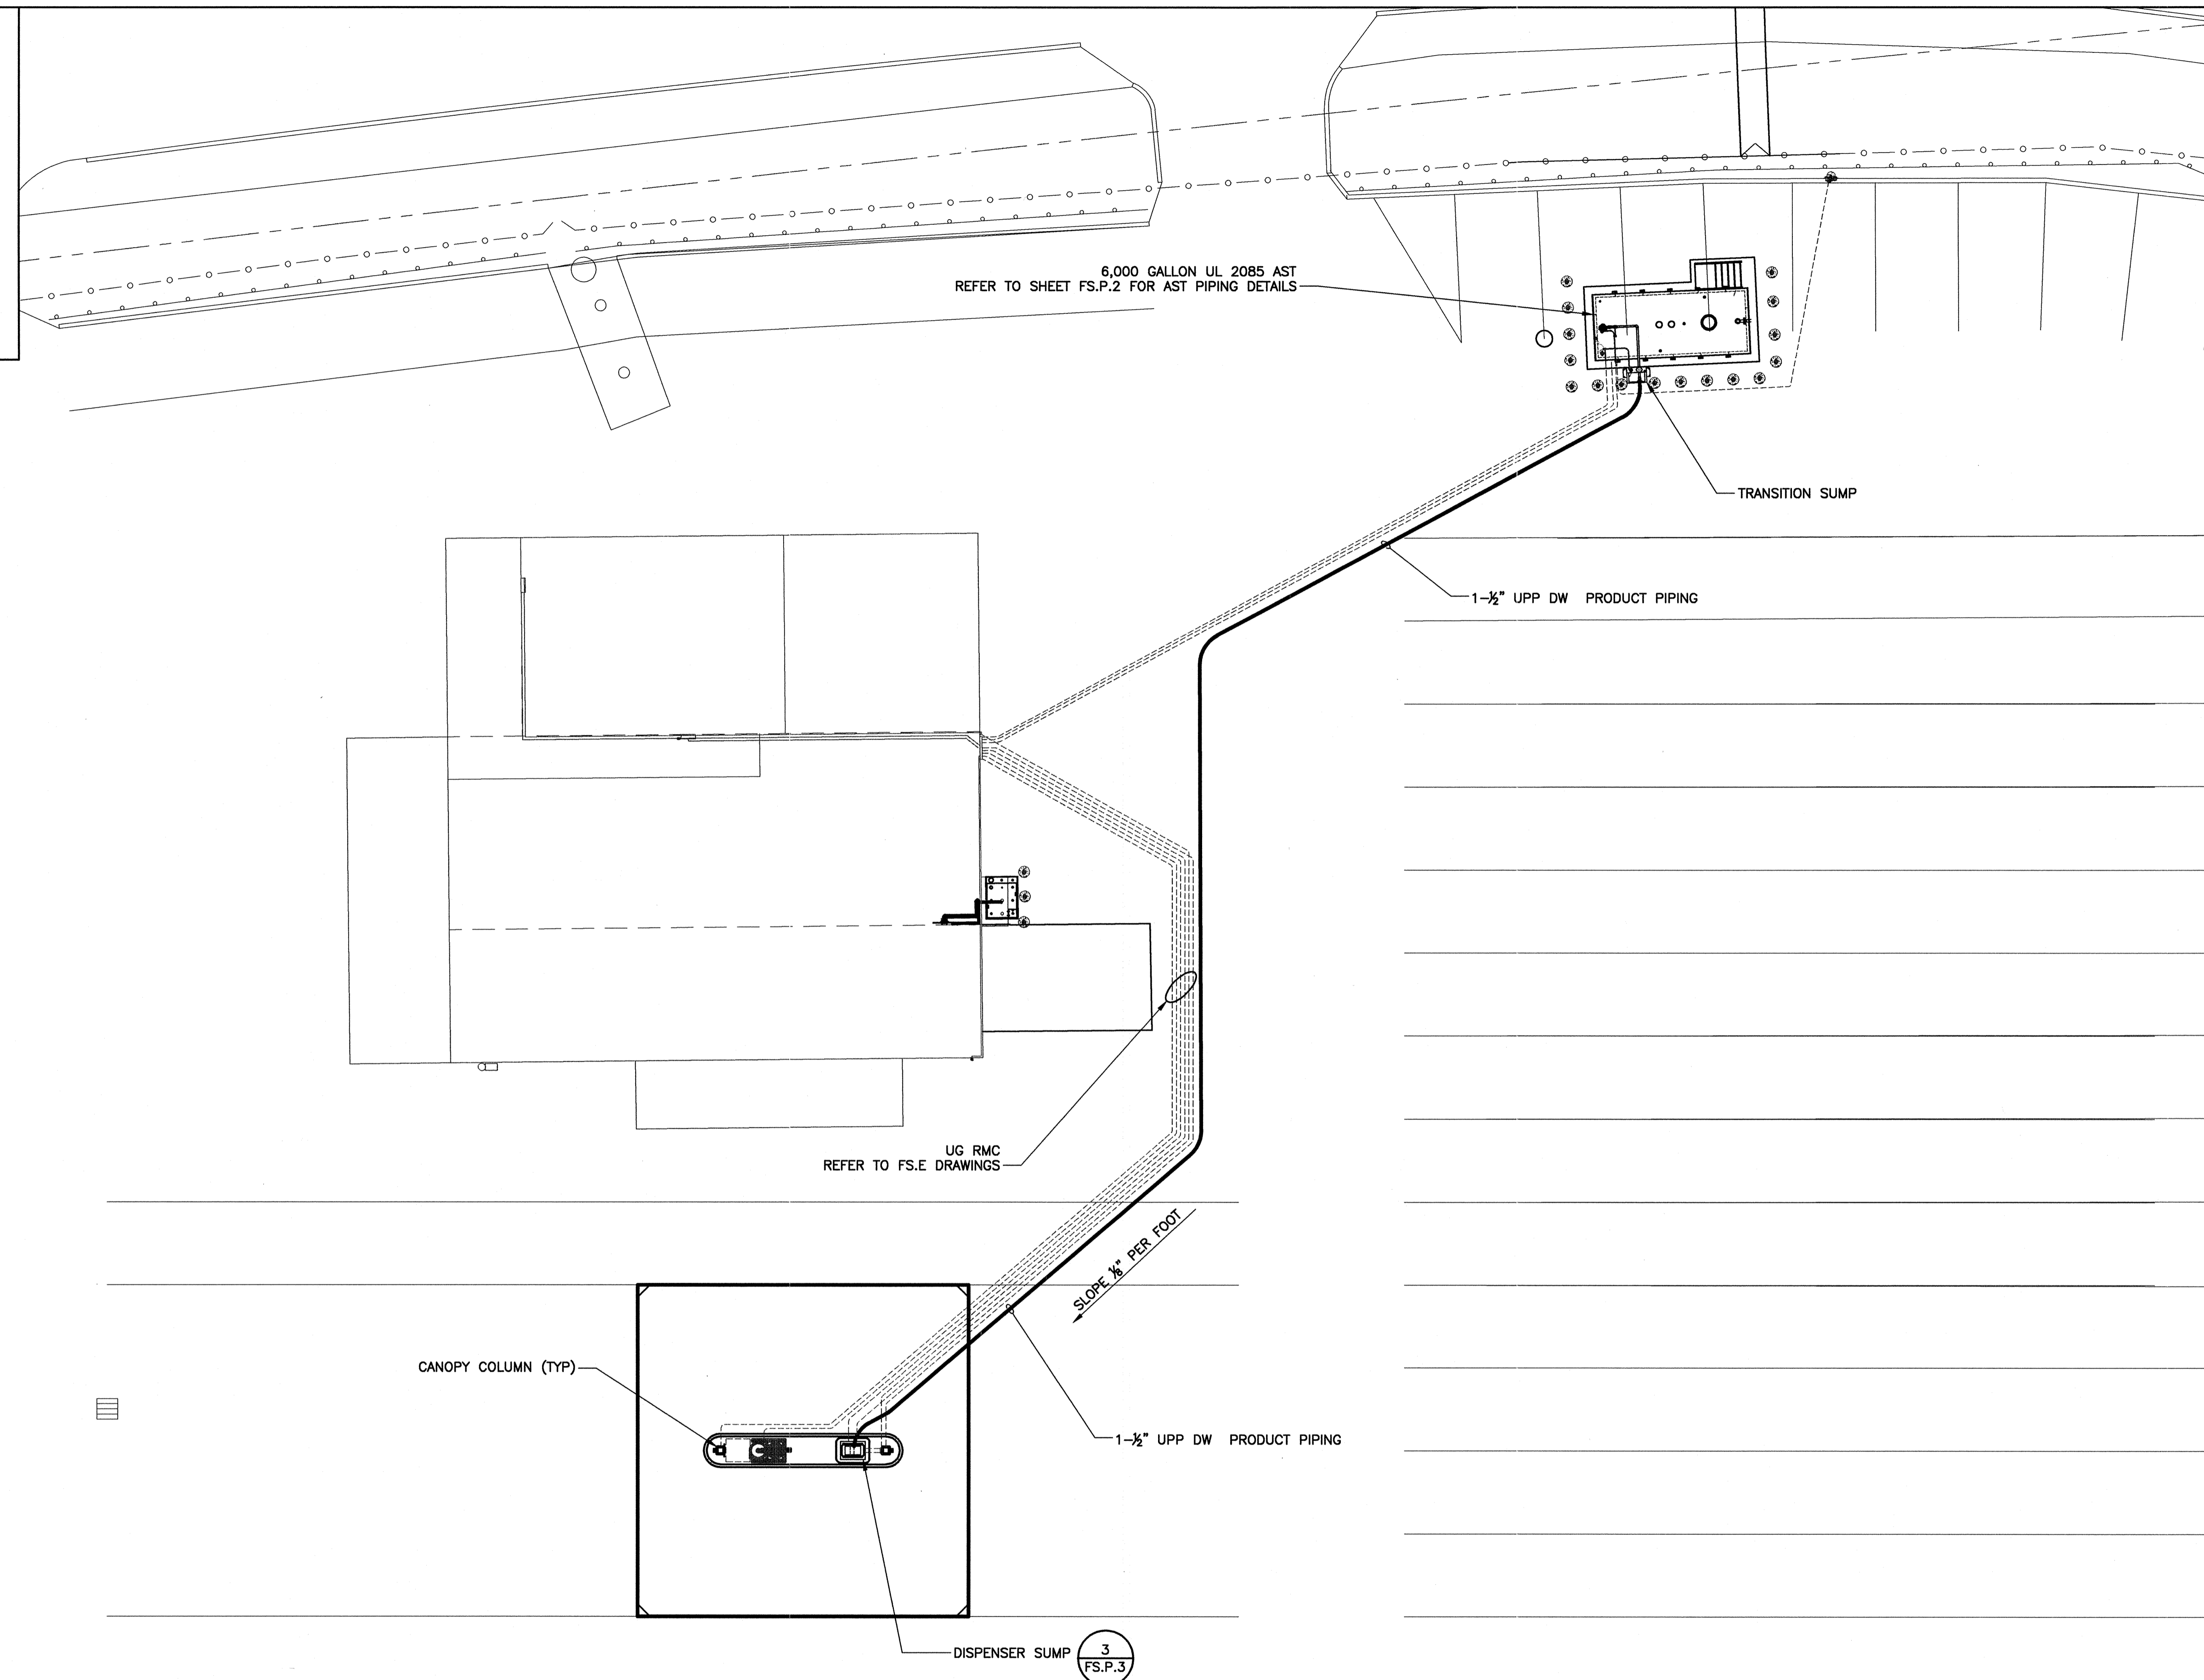

PER UPP INSTALLATION INSTRUCTIONS, INSTALL PIPING OVER 39' IN LENGTH IN GENTLE "S" CURVES AND NOT IN A STRAIGHT LINE FOR THERMAL CONTRACTION/EXPANSION

1 FS.P.1 UNDERGROUND PIPING PLAN

