




1 Preliminary Lighting Plan
 Scale: 3/16"=1'0"

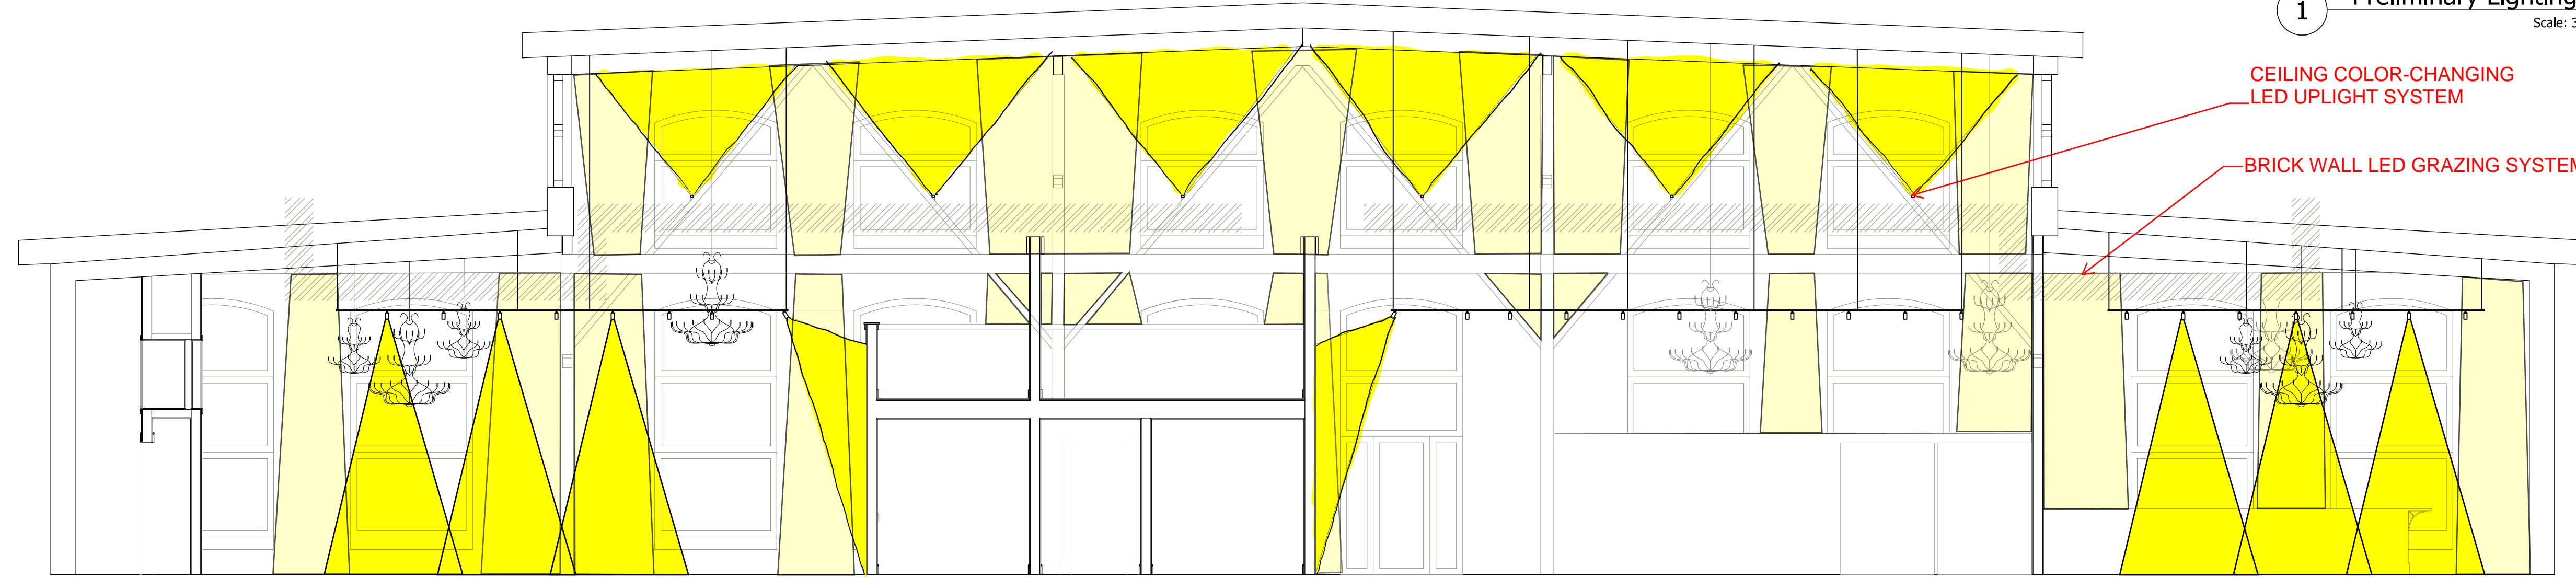

2 Preliminary Lighting Section A
 Scale: 3/16"=1'0"

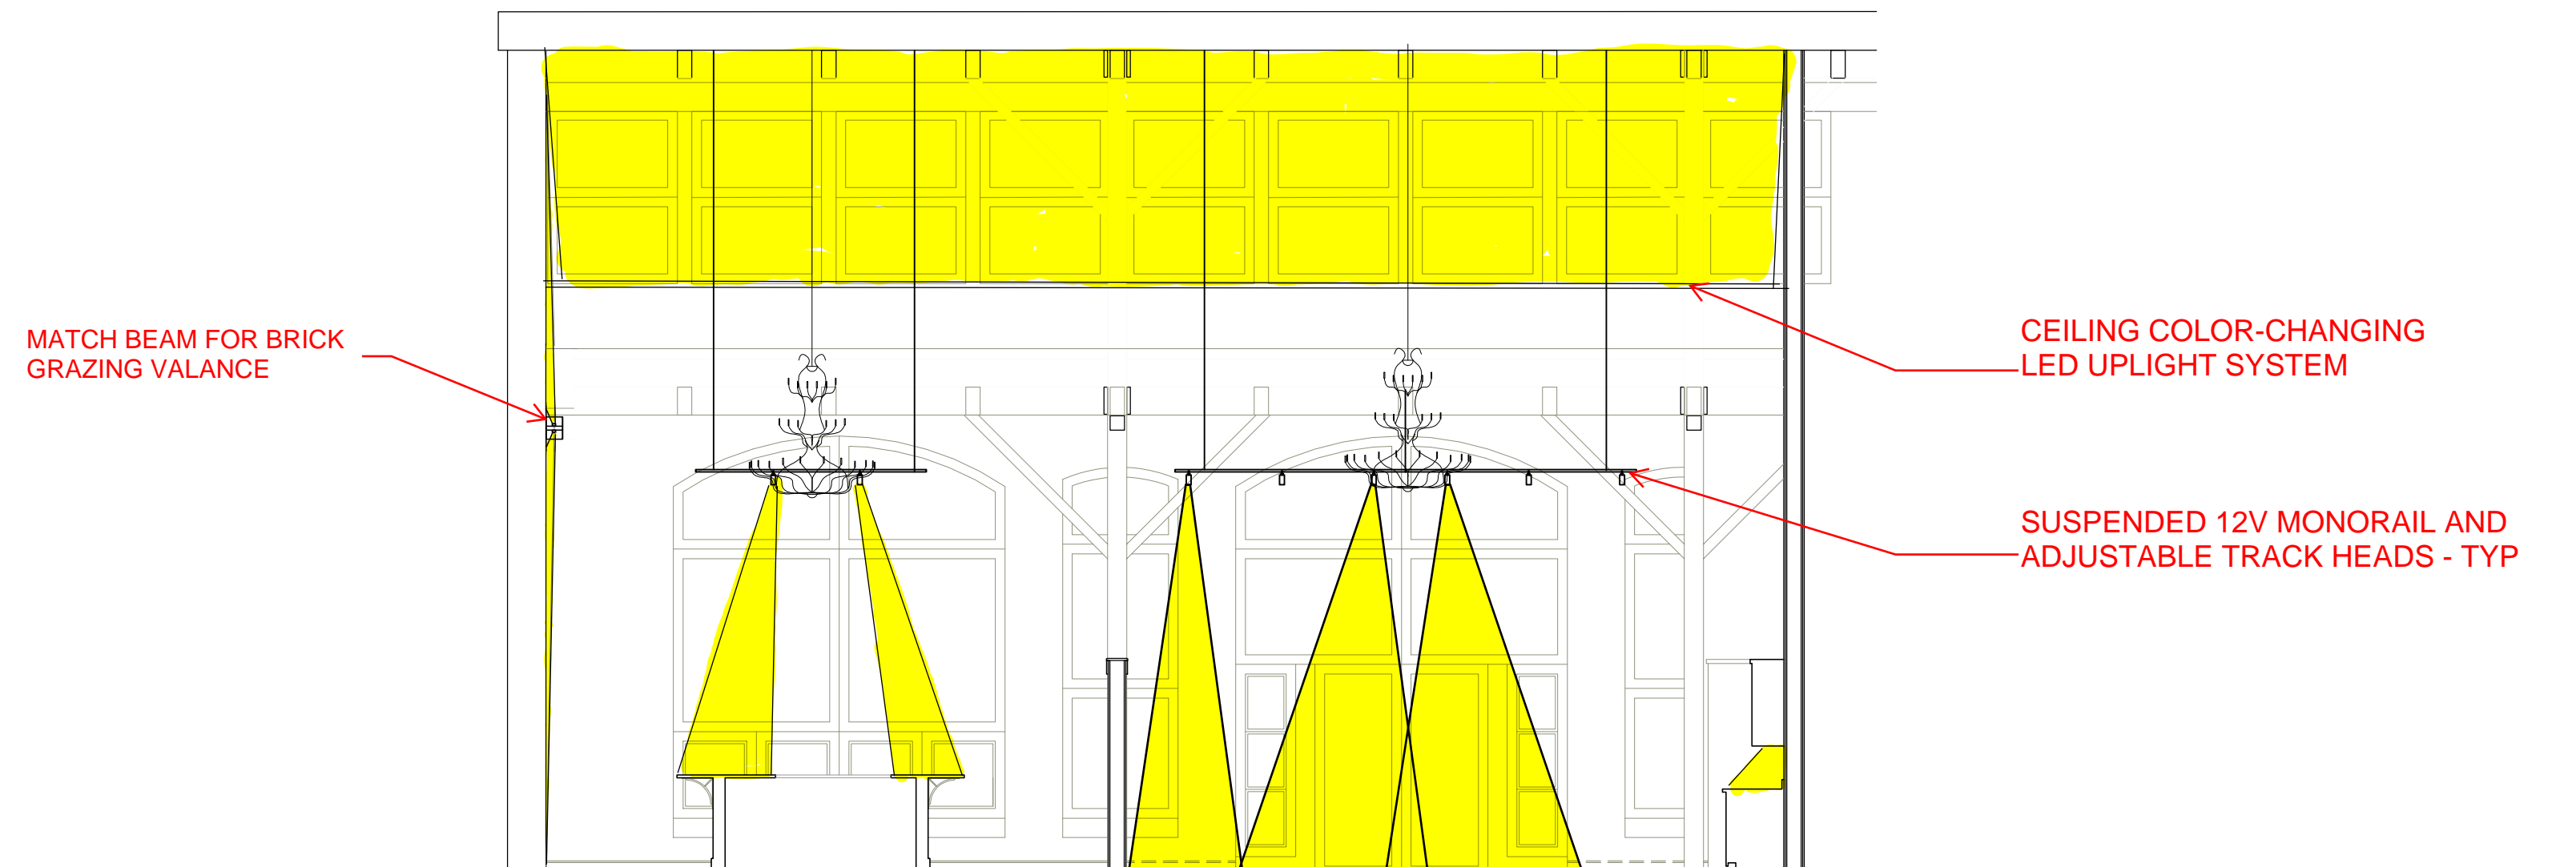

3 Preliminary Lighting Section B
 Scale: 3/16"=1'0"

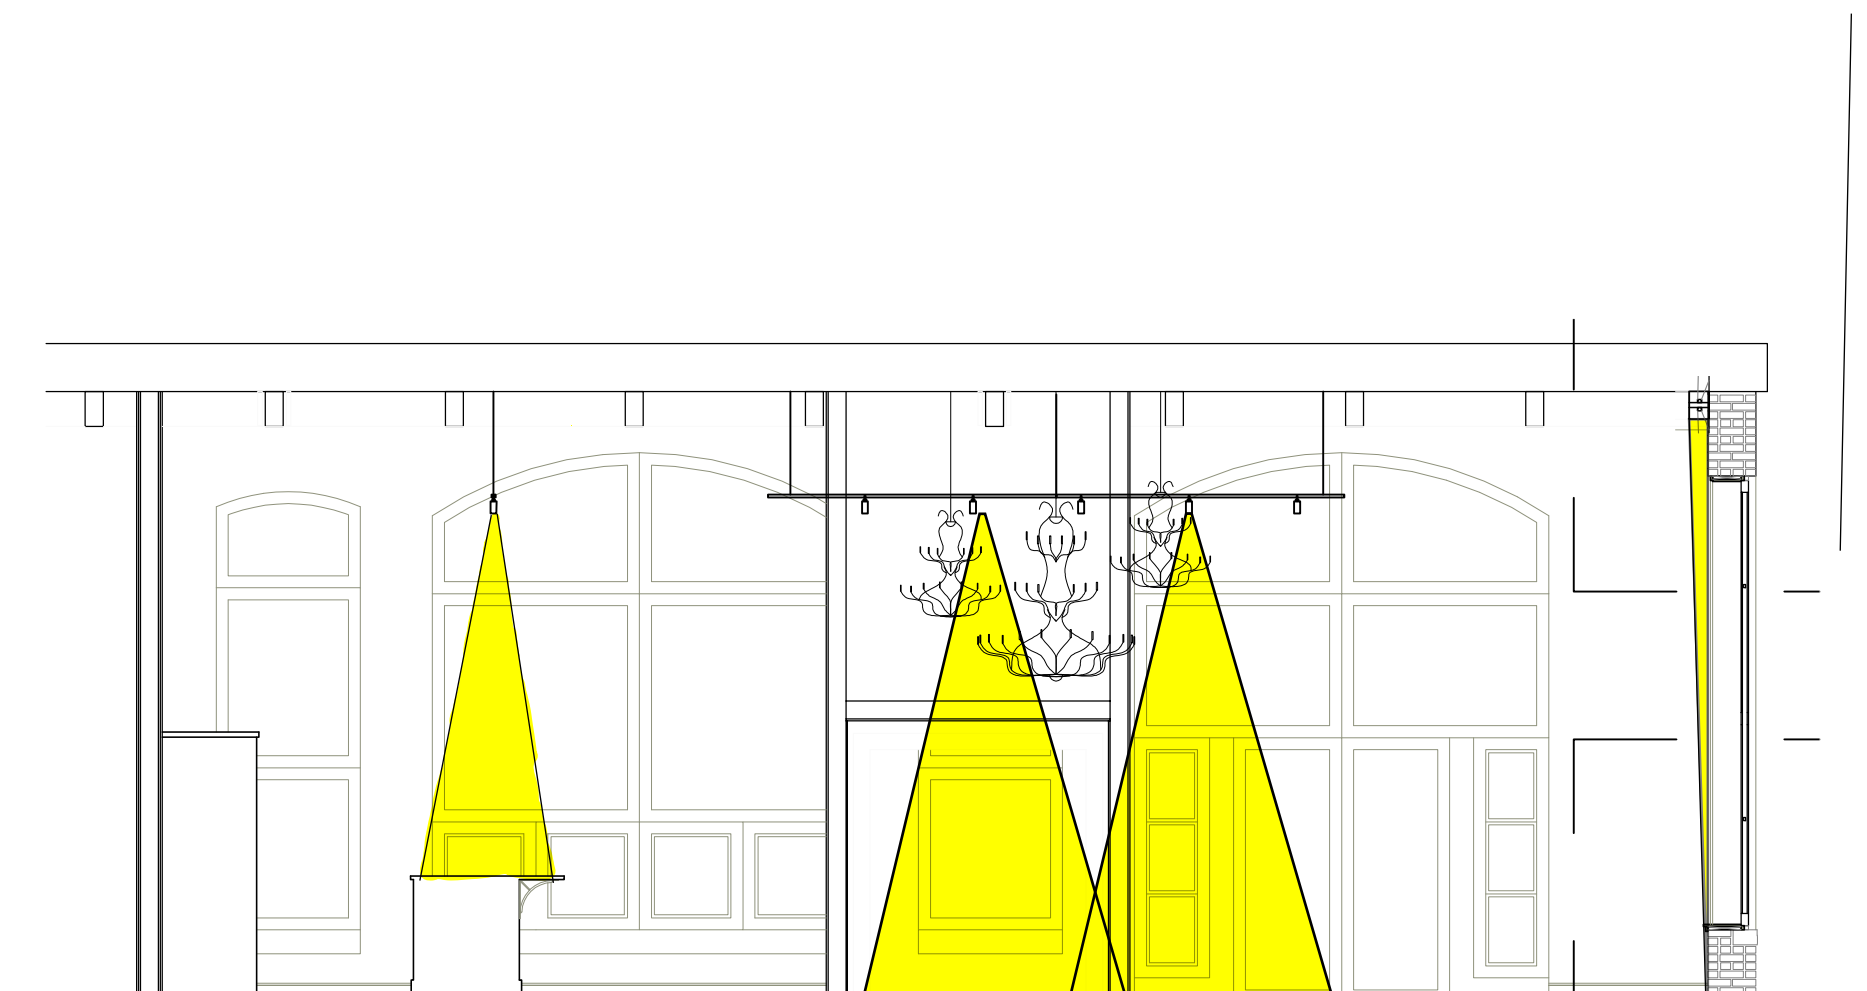

4 Preliminary Lighting Section C
 Scale: 3/16"=1'0"

Cellardoor at
 The Point
 Thompson's Point
 Portland, Maine

Date: 22. JAN. 16
 Scale: 3/16"=1'0"

Drawing Title:
 Preliminary
 Lighting
 Drawings

LT.1
 Not For
 Construction