


# CELLARDOOR AT THE POINT

THOMPSON'S POINT PORTLAND, MAINE  
OWNER: CELLARDOOR WINERY

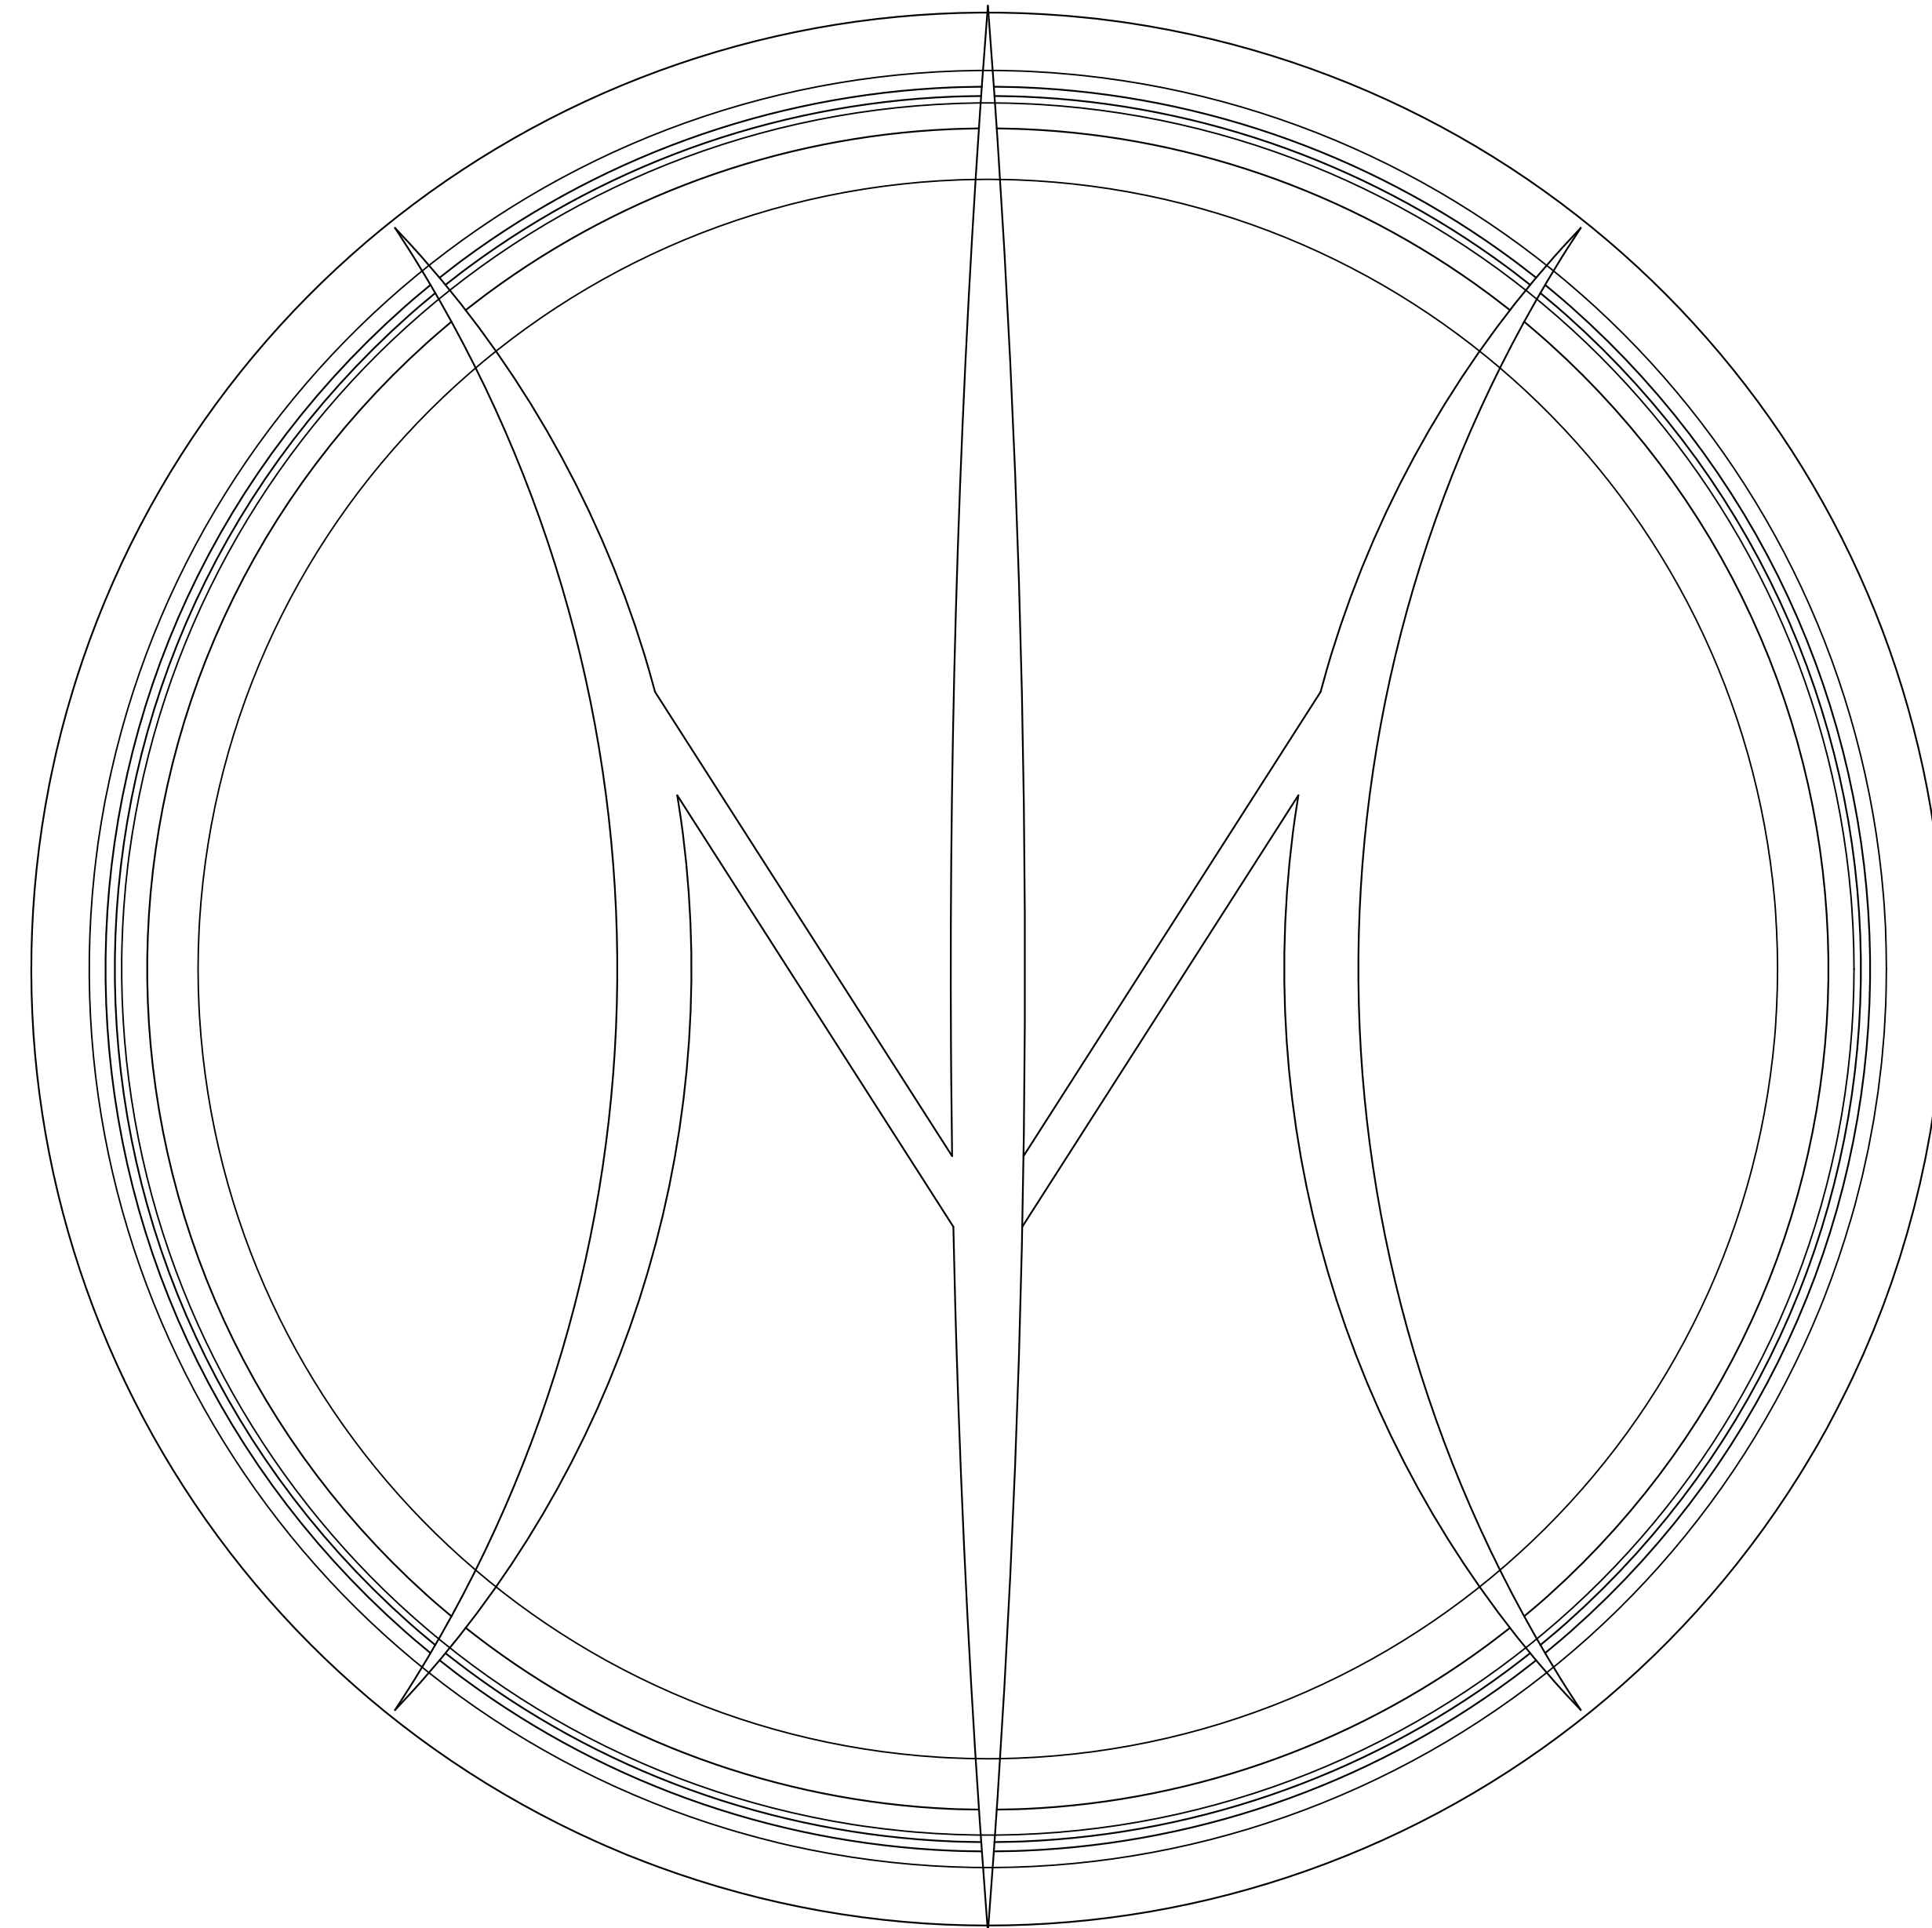

## PROJECT DIRECTORY

**OWNER:** Cellardoor Winery  
367 Youngtown Road  
Lincolville, Maine 04849  
207.763.4478

**DESIGNER:** Phi Home Designs  
446 West Street  
Rockport, ME 04856  
207.230.0034  
Contact: Chris Grotton

**CONTRACTOR:** Landry/French  
160 Pleasant Hill Road  
Scarborough, ME 04074  
207.730.5566  
Contact: Geoff Mitchell

**STRUCTURAL:** Civil & Structural Design  
627 Western Road  
Warren, ME 04864  
207.273.3021  
Contact: Randy Scamfer

## DRAWING INDEX

CS1	COVER SHEET
A100	FLOOR PLANS
A300	BUILDING SECTIONS & DETAILS
A301	BUILDING SECTIONS & DETAILS
A302	BUILDING SECTIONS & DETAILS
A303	BUILDING SECTIONS & DETAILS
A304	BUILDING SECTIONS & DETAILS
A305	BUILDING SECTIONS & DETAILS
A400	INTERIOR ELEVATIONS
E1	ELECTRICAL PLANS
LT.1	LIGHTING DRAWINGS
LS100	LIFE SAFETY DRAWINGS
M1.01	MECHANICAL AND PLUMBING PLANS
M2.01	MECHANICAL LEGEND AND SCHEDULES
M2.02	MECHANICAL DETAILS
S-1	STRUCTURAL DRAWINGS
Z1	DINING CABINETRY DETAILS
Z2	MAIN BAR CABINETRY
Z3	MARKET CABINETRY
Z4	BATH & CHECKOUT CABINETRY



446 WEST STREET  
ROCKPORT, ME 04856  
TEL: 207.230.0034  
FAX: 207.230.0274  
PHIHOMEDESIGNS.COM  
©PHI HOME DESIGNS LLC

CELLARDOOR AT THE POINT  
THOMPSON'S POINT PORTLAND, MAINE  
OWNER: CELLARDOOR WINERY



DATE:

FEBRUARY 9, 2016

DRAWN BY:

CG

CHECKED BY:

ECD

COVER SHEET

CS1

ISSUED FOR PRICING & FOR CONSTRUCTION