


WORK NOTES:

- ① REFER TO KITCHEN PLAN DRAWING E103 FOR KITCHEN POWER REQUIREMENTS.
- ② COORDINATE COOLER LIGHTING WITH COOLER SUPPLIER PRIOR TO ROUGH-IN.

LIGHTING FLOOR PLAN

SCALE: 3/16"=1'-0"
REFER TO DRAWINGS E102 FOR LIGHT FIXTURE INFORMATION

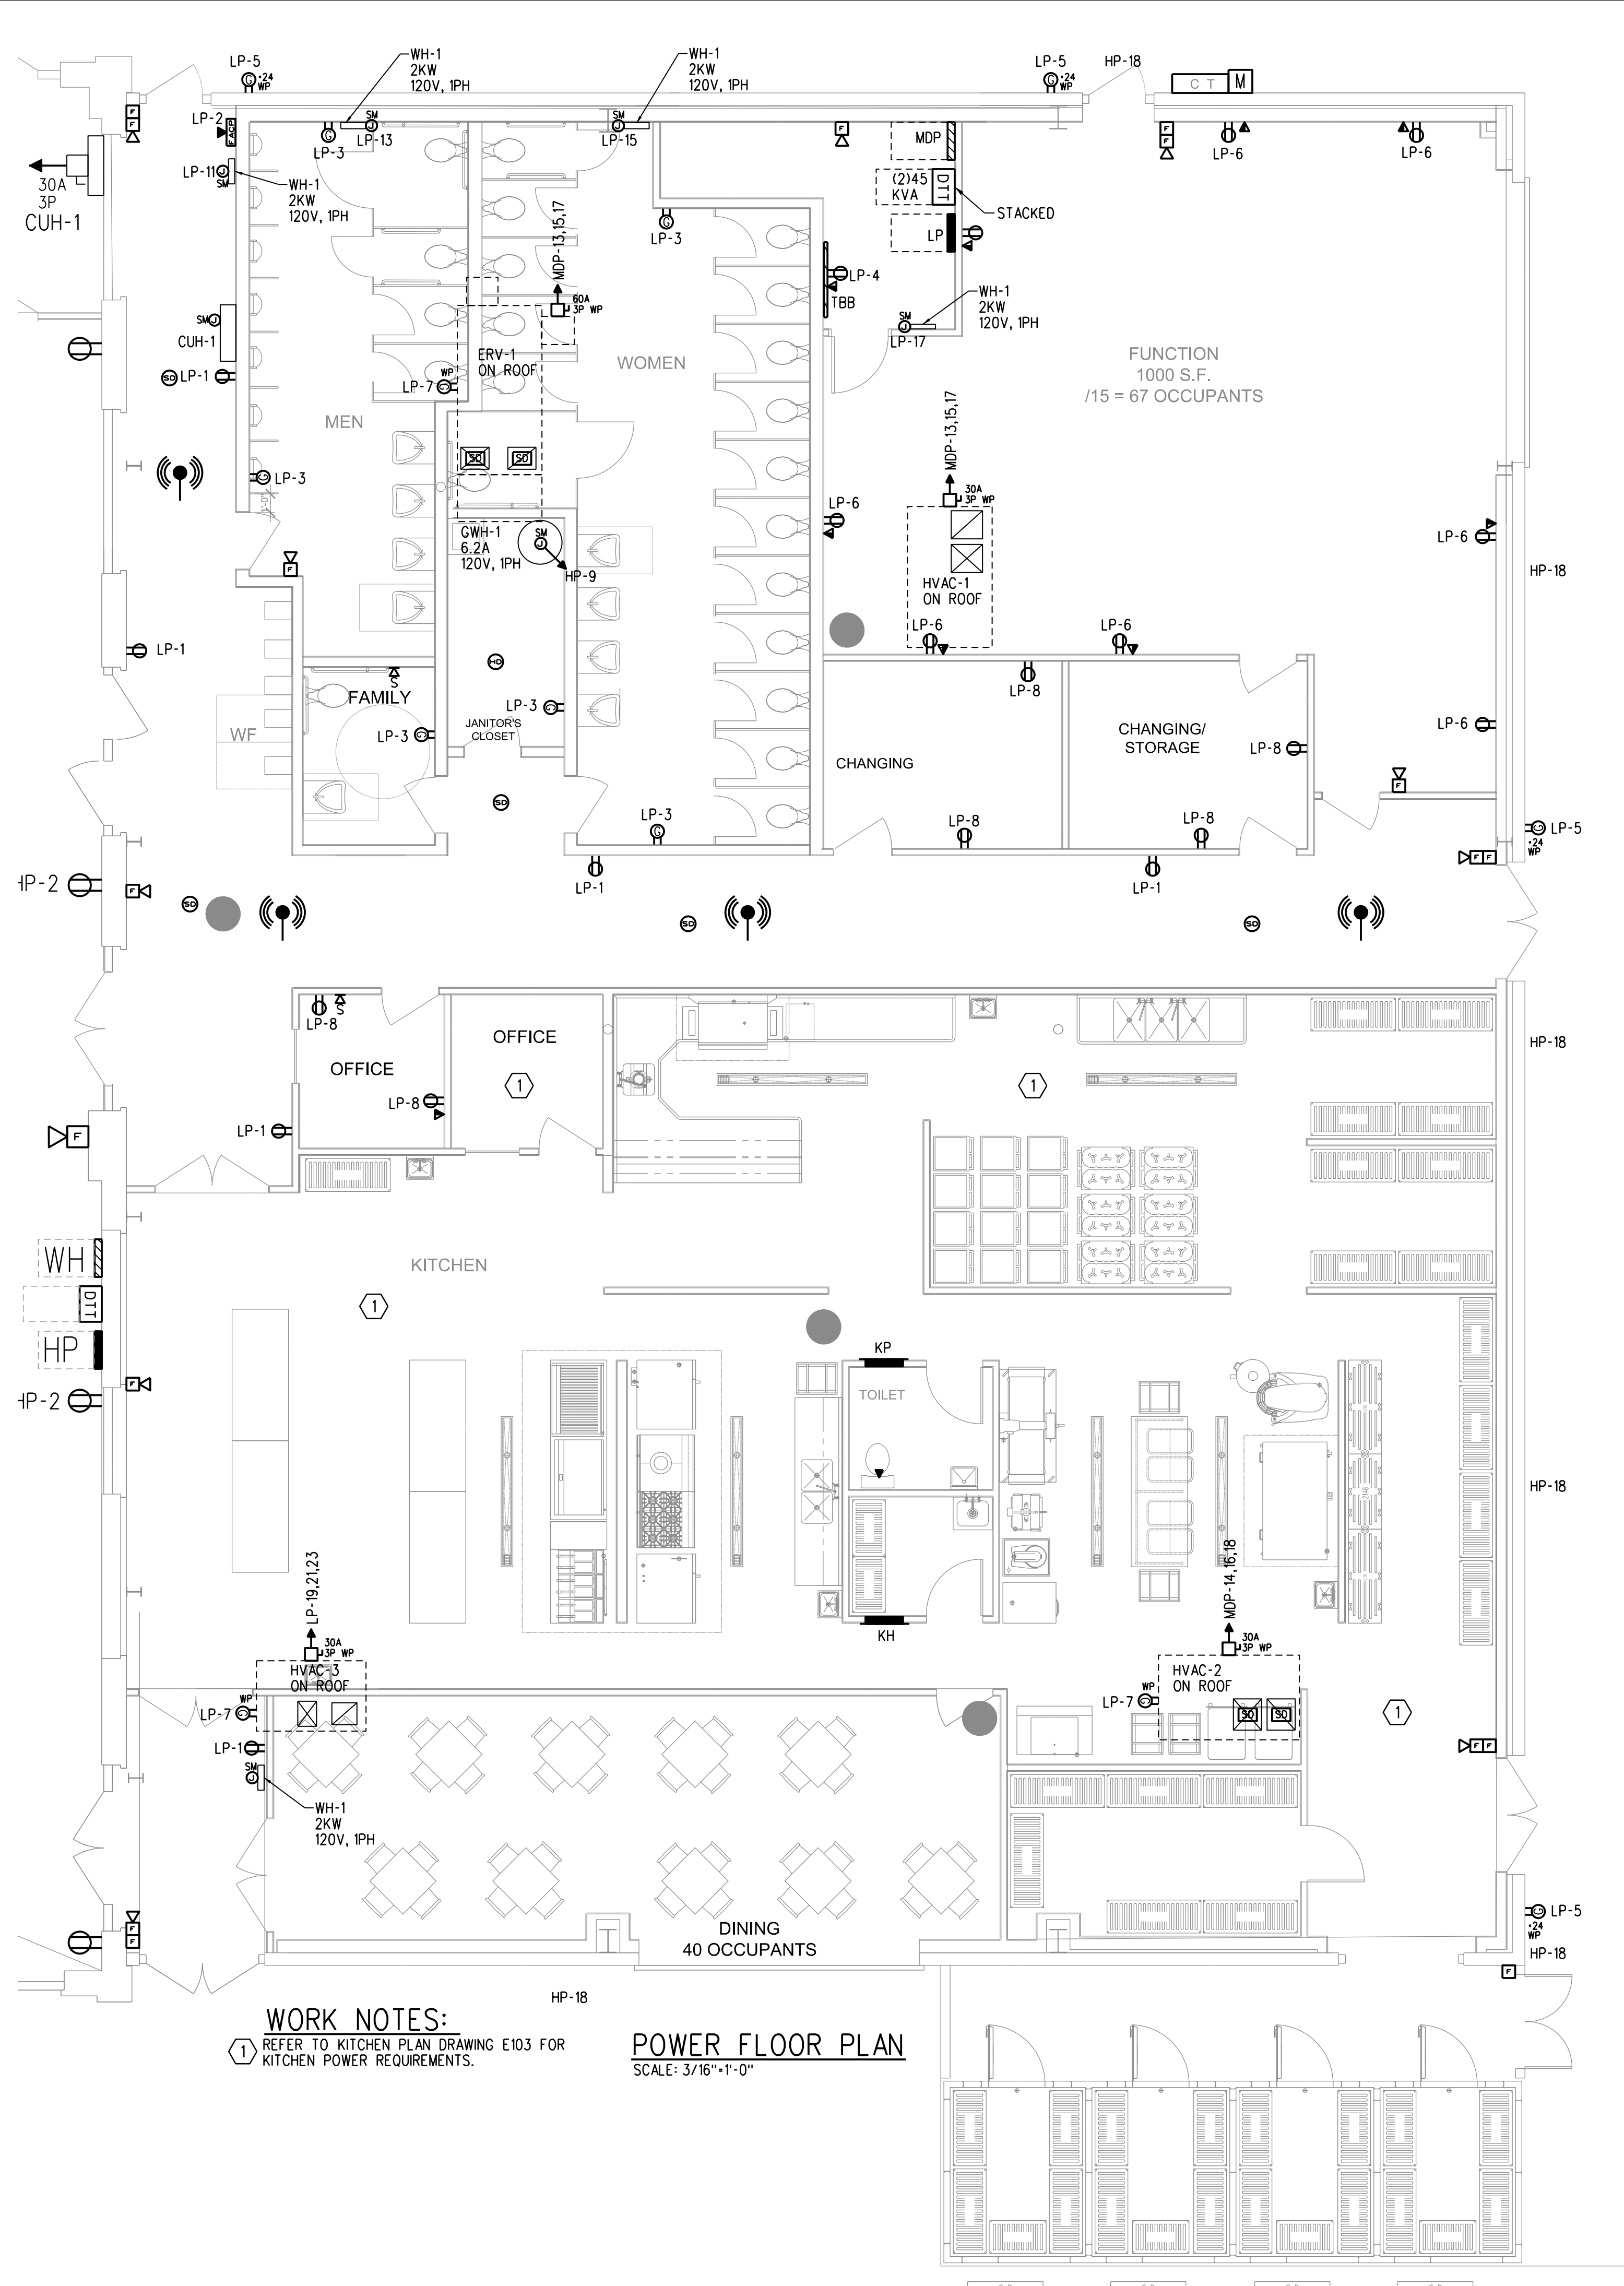


WORK NOTES:


- ① REFER TO KITCHEN PLAN DRAWING E103 FOR KITCHEN POWER REQUIREMENTS.

POWER FLOOR PLAN

SCALE: 3/16"=1'-0"

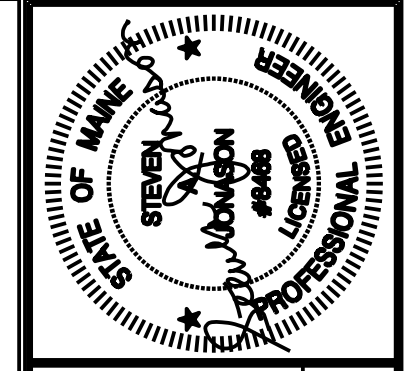

Prepared For:

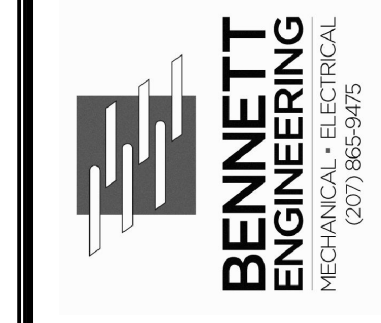

Consultant:

ARCHETYPE
48 Union Wharf Portland, Maine 04101
(207) 772-6022 Fax (207) 772-4056

Architect:

THOMPSON'S POINT- BRICK SOUTH
THOMPSON'S POINT, PORTLAND ME

Project:

Revisions:
1 08/04/2016 ISSUED FOR PERMIT

Scale:

AS NOTED

Date:

08-04-2016

KITCHEN PARTIAL PLAN,

E101