


Prepared For:

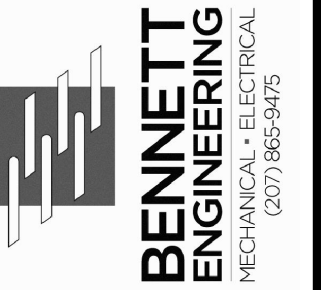

Consultant:

ARCHETYPE
48 Union Wharf Portland, Maine 04101
(207) 772-6022 Fax (207) 772-4056

Architect:

THOMPSON'S POINT -
BRICK SOUTH
THOMPSON'S POINT,
PORTLAND ME

Project:

Revisions:
1 | 08/04/2016 | ISSUED FOR PERMIT


Scale: AS NOTED

Date: 08-04-2016


BAR PLUMBING PLANS
AND KITCHEN EQUIPMENT
CONNECTION SCHEDULE

M2.02

FOODSERVICE EQUIPMENT SCHEDULE																				
MK.	QTY	DESCRIPTION	ELECTRICAL				WATER		WASTE		GAS		STEAM		VENTILATION		MAKE-UP AIR		REMARKS	
			LAMPS	AMP	HP	WATTS	COLD	HOT	DIRECT	INDIRECT	SIZE	MT/DW	PSY/HR	PSIG	INLET	RETURN	SIZE	CFM		SIZE
1	1	WALK-IN COOLER	15.0			120														
2	1	EVAPORATOR COIL COOLER	0.8			208-230	1	2			3/4"									
3	1	COMPRESSOR COOLER	7.5	1/2		208-230	1	2												
4	1	WALK-IN COOLER	15.0			120														
5	1	EVAPORATOR COIL COOLER	0.8			208-230	1	2			3/4"									
6	1	COMPRESSOR COOLER	7.5	1/2		208-230	1	2												
7	1	WALK-IN COOLER	15.0			120														
8	1	EVAPORATOR COIL COOLER	0.8			208-230	1	2			3/4"									
9	1	COMPRESSOR COOLER	7.5	1/2		208-230	1	2												
10	1	WALK-IN FREEZER	15.0			120														
11	1	EVAPORATOR COIL FREEZER	4.3	0.5		115	1	1			3/4"									
12	1	COMPRESSOR FREEZER	11.7			208-230	1	2												
13	20	COOLER/FREEZER SHELVING	13.2	2-1/2		208-230	3	2												
14	-	- SPARE NUMBER -																		
15	6	DRY STORAGE SHELVING																		
16	5	SHEET PAN RACK																		
17	3	ICE STORAGE BIN									3/4"									
18	3	ICE MAKER				208	1	2			3/8"									
19	5	HAND SINK	14.2			208	1	2			1/2"	1/2"	1-1/2"							
20	1	EXHAUST HOOD	15.0			120	1	2												
21	1	STONE DECK OVEN W/PROOFER	14.0	2.8		208	1	2			1/2"									
22	1	MIXER, 80-QUART	12.0	3		208	3	2												
23	1	BAKER'S TABLE																		
24	4	INGREDIENT BIN																		
25	1	REFRIGERATOR, 1-SECTION	5.5	1/4		115	1	1			X									
26	1	MIXER STAND																		
27	1	MIXER, 20-QUART	8.0	1/2		120	1	1			X									
28	1	DOUGH DIVIDER/ROUNDER	4.0			208	1	1			X									
29	1	MOBILE EQUIPMENT STAND																		
30	1	SHEETER, COUNTERTOP	4.0			120	1	1			X									
31	-	- SPARE NUMBER -																		
32	3	DUNNAGE RACK																		
33	4	SECURITY CAGE																		
34	10	EXHAUST WASTE RECEPTACLE									3"									
35	1	MOP SINK									1/2"	1/2"	2"							
36	2	CHEMICAL STORAGE SHELVING									1/2"	1/2"	2"							
37	1	WORK TABLE W/TH SINKS									1/2"	1/2"	2"							
38	2	WALL SHELF																		
39	-	- SPARE NUMBER -																		
40	1	EXHAUST HOOD	15.0			120	1	2												
41	1	COMB-OVEN, ROLL-IN	18.0			208	3	2			3/4"									
42	1	RANGE, 6-BURNER													1-1/4"	248				
43	1	RANGE, FRENCH TOP													1-1/4"	25				
44	1	COMB-OVEN, DOUBLE	59.0	21.0		208	3	2			3/4"									
45	1	EQUIPMENT STAND	59.0	21.0		208	3	2			3/4"									
46	1	CHARBROILER									3/4"	136								
47	1	GRIDDLE									3/4"	108								
48	1	FRYER BATTERY W/FILTER DRAWER	7.0	1/2		115	1	1			X									
49	1	WORK TABLE																		
50	4	WORK TABLE																		
51	-	- SPARE NUMBER -																		
52	1	SHELVING UNIT									1/2"	1/2"								
53	1	DISHTABLE, SOLED									1/2"	1/2"								
54	1	DISPOSER	1.1	2		208	3	2			1/2"									
55	1	DISHWASHER, CONVEYOR-TYPE	59.7	18.0		208	3	2			1/2"	1-1/2"								
56	-	- SPARE NUMBER -																		
57	1	DISHTABLE, CLEAN									1/2"	1/2"	3"							
58	1	SINK, 3-COMPARTMENT									1/2"	1/2"	3"							
59	8	CATERING STORAGE SHELVING									1/2"	1/2"								
60	12	GLASS RACK DOLLY																		
61	6	PLATE DOLLY									3/4"	3/4"								
62	1	BOOSTER HEATER	66.7	24.0		208	3	2			3/4"	3/4"								
63	-	- SPARE NUMBER -																		
64	-	- SPARE NUMBER -																		
65	1	WALK-IN BEER COOLER	15.0			120	1	2			3/4"									
66	1	EVAPORATOR COIL COOLER	1.4			208-230	1	2			3/4"									
67	1	COMPRESSOR COOLER	8.3	3/4		208-230	1	2												
68	3	COOLER SHELVING																		
69	1	KEG STACKER																		
70	1	BEER LINE CHILLER (BY OTHERS)	13.0	1/3		120	1	1			X									
71	4	DRAPE BEER TOWER (BY OTHERS)																		
72	2	BEVERAGE COUNTER	15.0			120	1	2			1/2"	1/2"	1-1/2"							
73	2	COFFEE BREWER (BY OTHERS)	25.6	9.1		120/208	3	2			3/8"									
74	2	COFFEE DISPENSER (BY OTHERS)																		
75	2	REFRIGERATOR, 2-SECTION	8.4	1/3		115	1	1			X									
76	4	BACK BAR COOLER	6.5	1/4		120	1	1			X									
77	4	UNDERBAR HAND SINK									1/2"	1/2"	1-1/2"							
78	4	UNDERBAR DRY WASTE CHUTE									1/2"	1/2"	1-1/2"							
79	4	UNDERBAR BLENDER STATION	15.0			115	1	2			1/2"	1/2"	1-1/2"							
80	4	UNDERBAR DRAINBOARD									1/2"	1/2"	1-1/2"							
81	4	UNDERBAR SODA GUN HOLDER																		
82	4	UNDERBAR SINGLE SPEED RAIL																		
83	4	UNDERBAR COMBO ICE BIN																		
84	4	UNDERBAR DRAINBOARD/GLASS RACK																		
85	6	LIQUOR STORAGE SHELVING																		

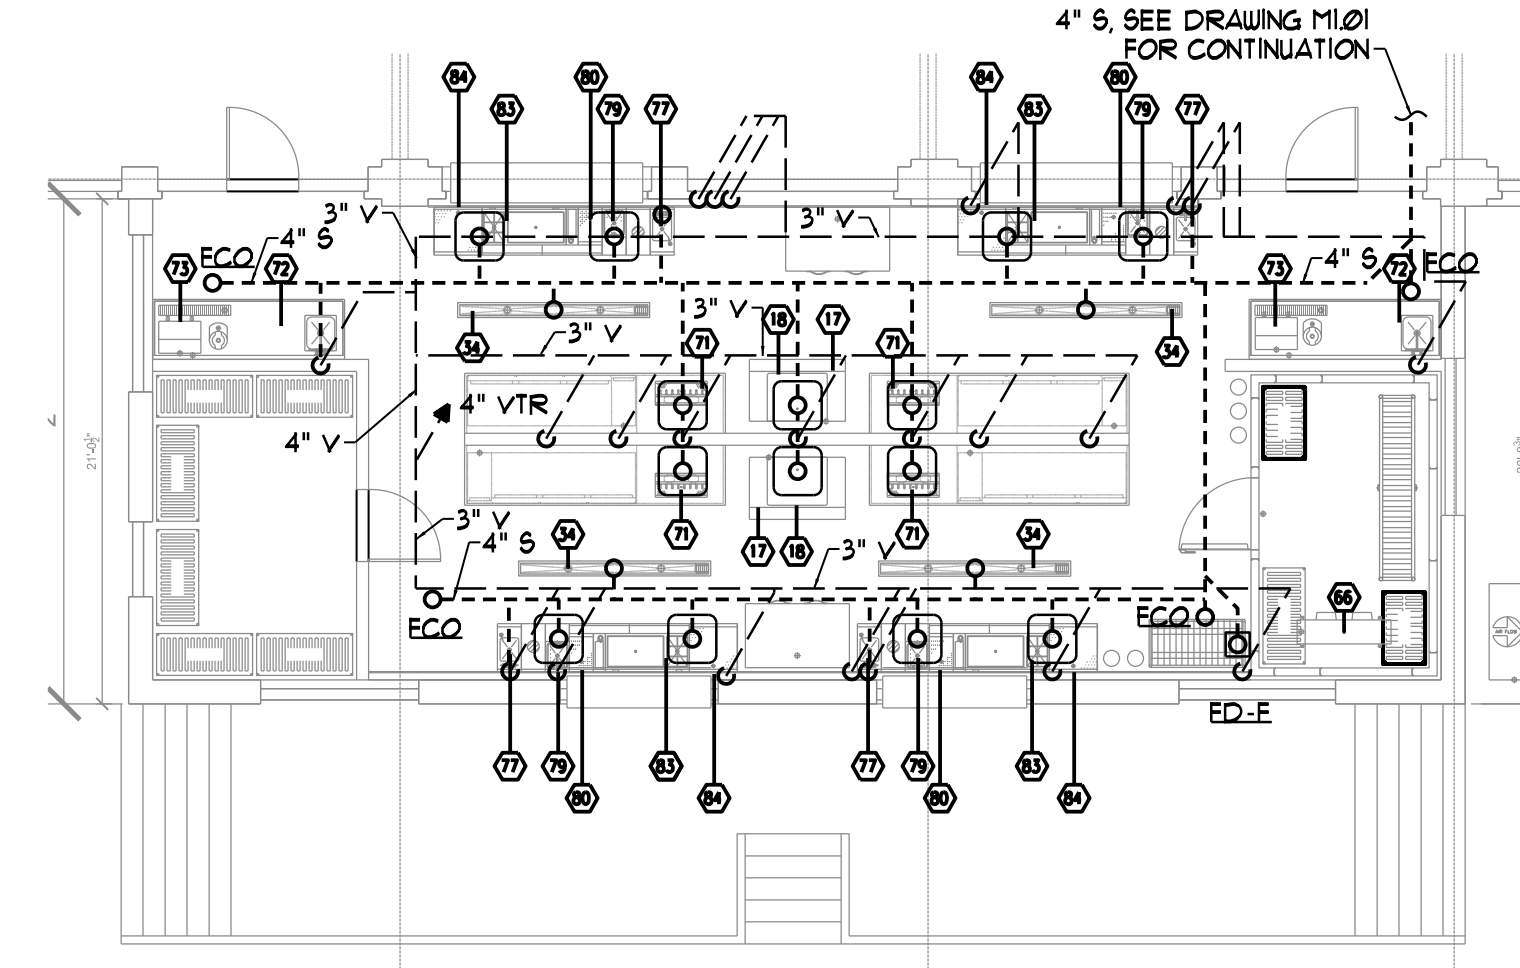

BAR AREA SANITARY PLUMBING PLAN
SCALE - 1/8" = 1'-0"

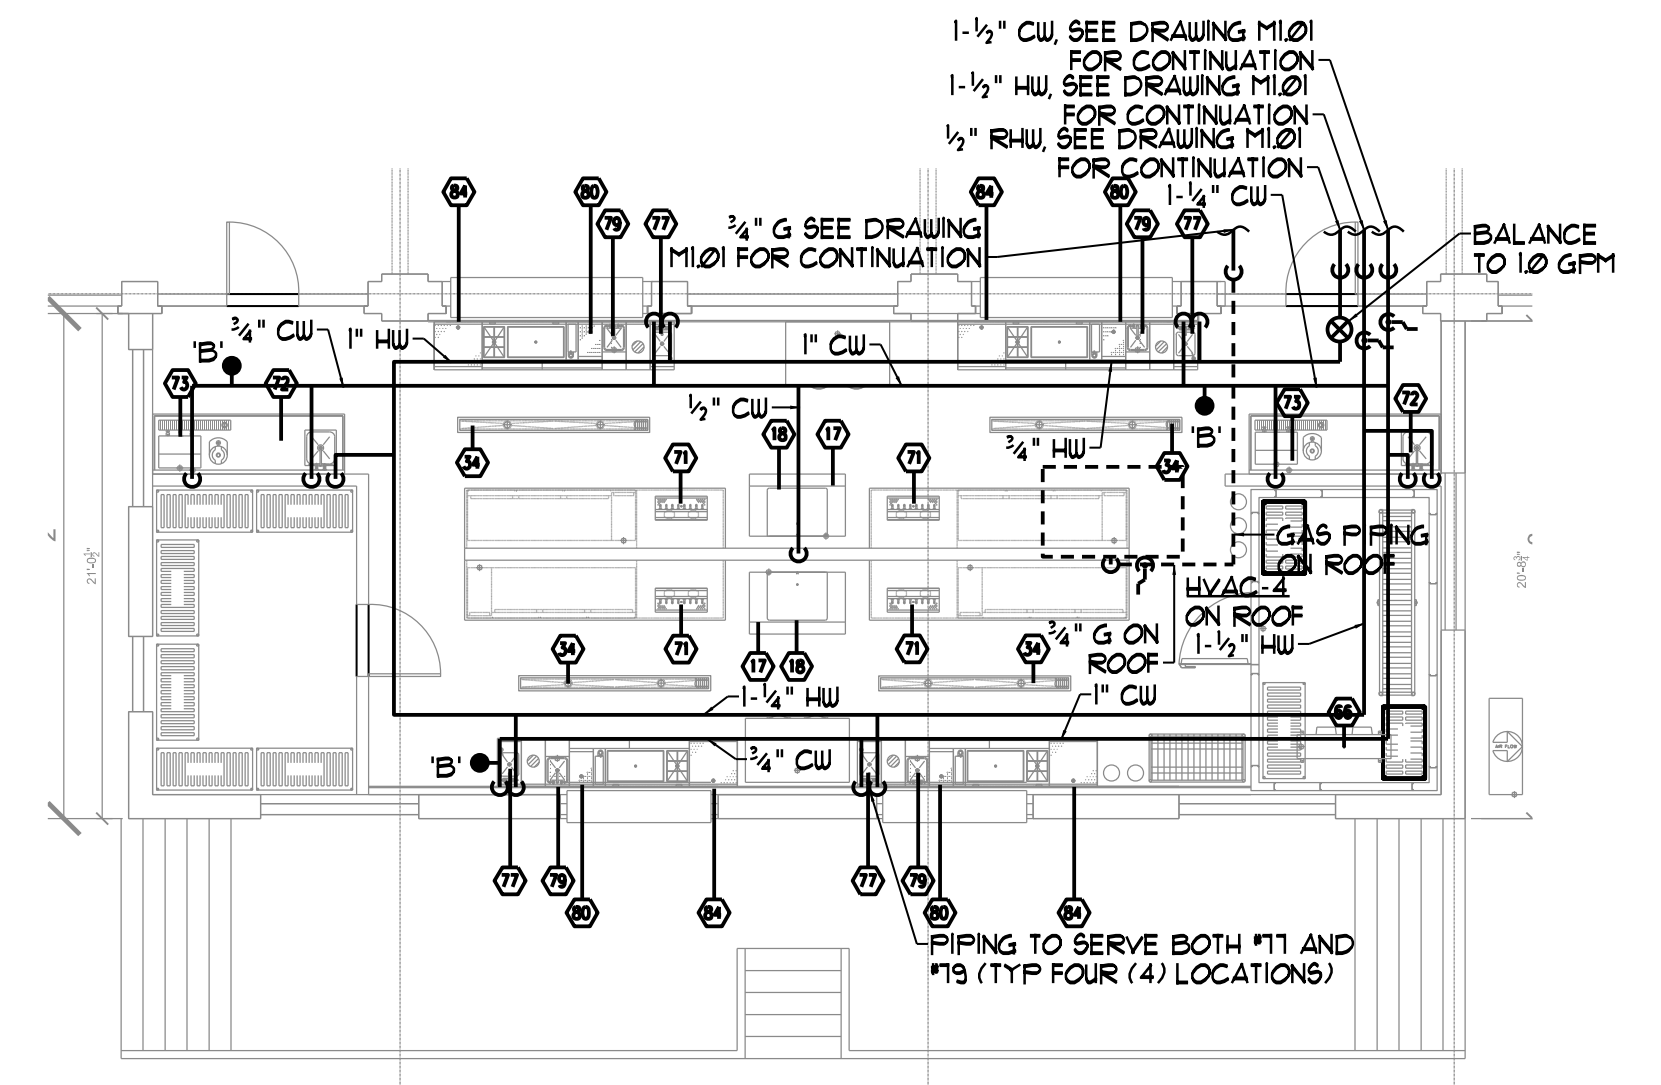

BAR AREA DOMESTIC WATER PLUMBING AND GAS PIPING PLAN
SCALE - 1/8" = 1'-0"

NOTE - PROVIDE ISOLATION VALVE AND REGULATOR AT ALL GAS-FIRED EQUIPMENT