


Prepared For:

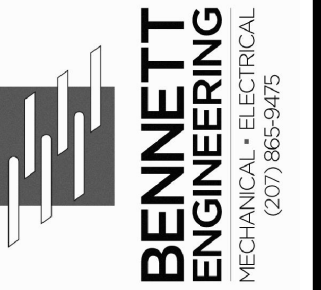

Consultant:


Architect:  
**ARCHETYPE**  
 48 Union Wharf Portland, Maine 04101  
 (207) 772-6022 Fax (207) 772-4056

Project:  
**THOMPSON'S POINT - BRICK SOUTH**  
 THOMPSON'S POINT, PORTLAND ME

Revisions:

Scale: AS NOTED  
 Date: 12-22-16  
**WAREHOUSE PARTIAL PLAN**

**E1.02**

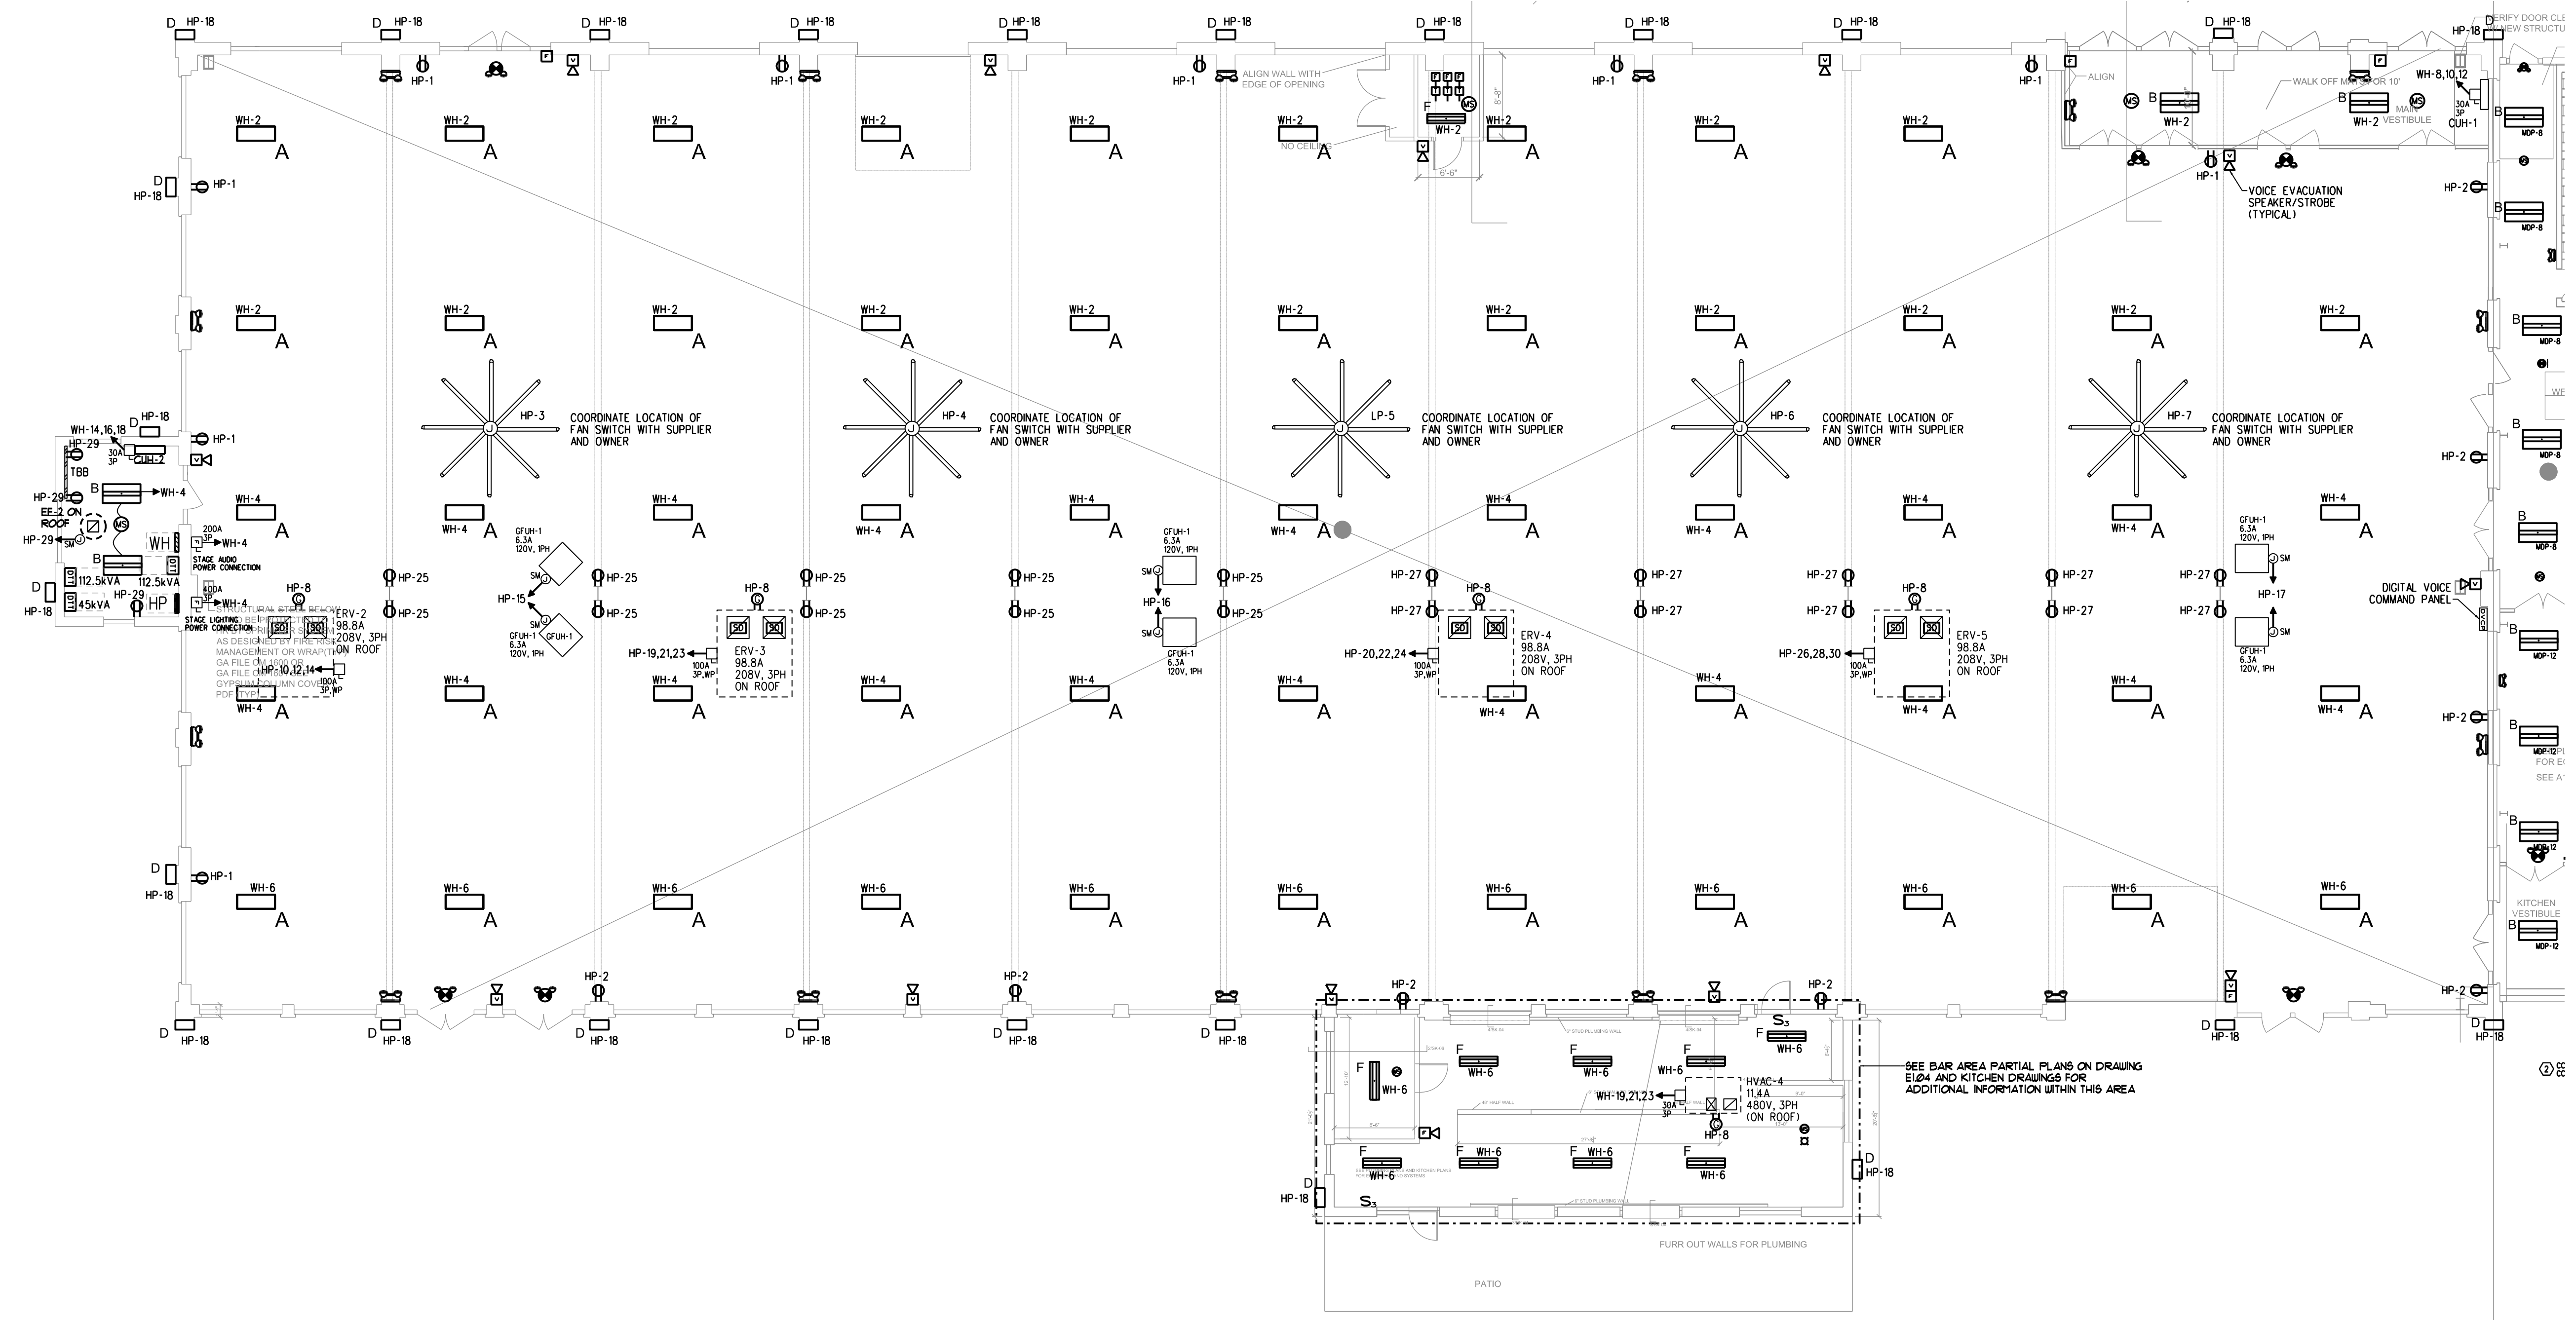

**POWER AND LIGHTING PLAN**  
 SCALE - 3/32" = 1'-0"

**LIGHT FIXTURE SCHEDULE**

TYPE	MANUFACTURER AND MODEL NUMBER	LAMP INFO	REMARKS
A	LITHONIA IBH 18LM LLENS MD MVOLT OZ10 35K 80CRI GLR LAOZU	146W, LED, 3500K	MOUNT TO BOTTOM OF STEEL, CONFIRM PRIOR TO ROUGH-IN
B	LITHONIA 2ALLS4 30L EZ1 LP835 GLR	25W, LED, 3500K	SURFACE MOUNTED GENERAL USE 2x4
C1	LITHONIA 2GTL-2-33L-EZ1-LP835	35.4W, LED, 3500K	RECESSED LENS TROFFER 2x2-KITCHEN AREA
C	LITHONIA 2ALLS2 33L EZ1 LP835 GLR	29W, LED, 3500K	SURFACE MOUNTED 2x2
D	LITHONIA 0LWX1 LED 40W 40K PE	40W, LED, 4000K	EXTERIOR SURFACE MOUNTED, CONFIRM MOUNTING HEIGHT
E	LITHONIA LHQM LED R HO SD	LED	EXIT SIGN WITH DUAL LED LAMPS
E1	LITHONIA LHQM LED R HO RO SD	LED	EXIT SIGN WITHOUT LED LAMPS
E2	LITHONIA No ELM2 LED HO SD	LED	EMERGENCY LIGHT WITH DUAL HEADS
E3	LITHONIA ELA T QWP L0304 SD	LED	DUAL HEAD REMOTE EMERGENCY LIGHT WATERPROOF
F	LITHONIA ALLS4 30L EZ1 LP835 GLR	30W, LED, 3500K	SURFACE MOUNTED 1x4

NOTES:  
 1. NON LED FIXTURES SHALL BE ENERGY STAR RATED OR HAVE HIGH PERFORMANCE BALLASTS AND LAMPS TO MEET STATE EFFICIENCY CRITERIA.  
 2. CONTRACTOR SHALL APPLY FOR ALL STATE EFFICIENCY INSENTIVES ON OWNERS BEHALF.