



**STEAM PIPING PLAN**  
SCALE - 1/8" = 1'-0"

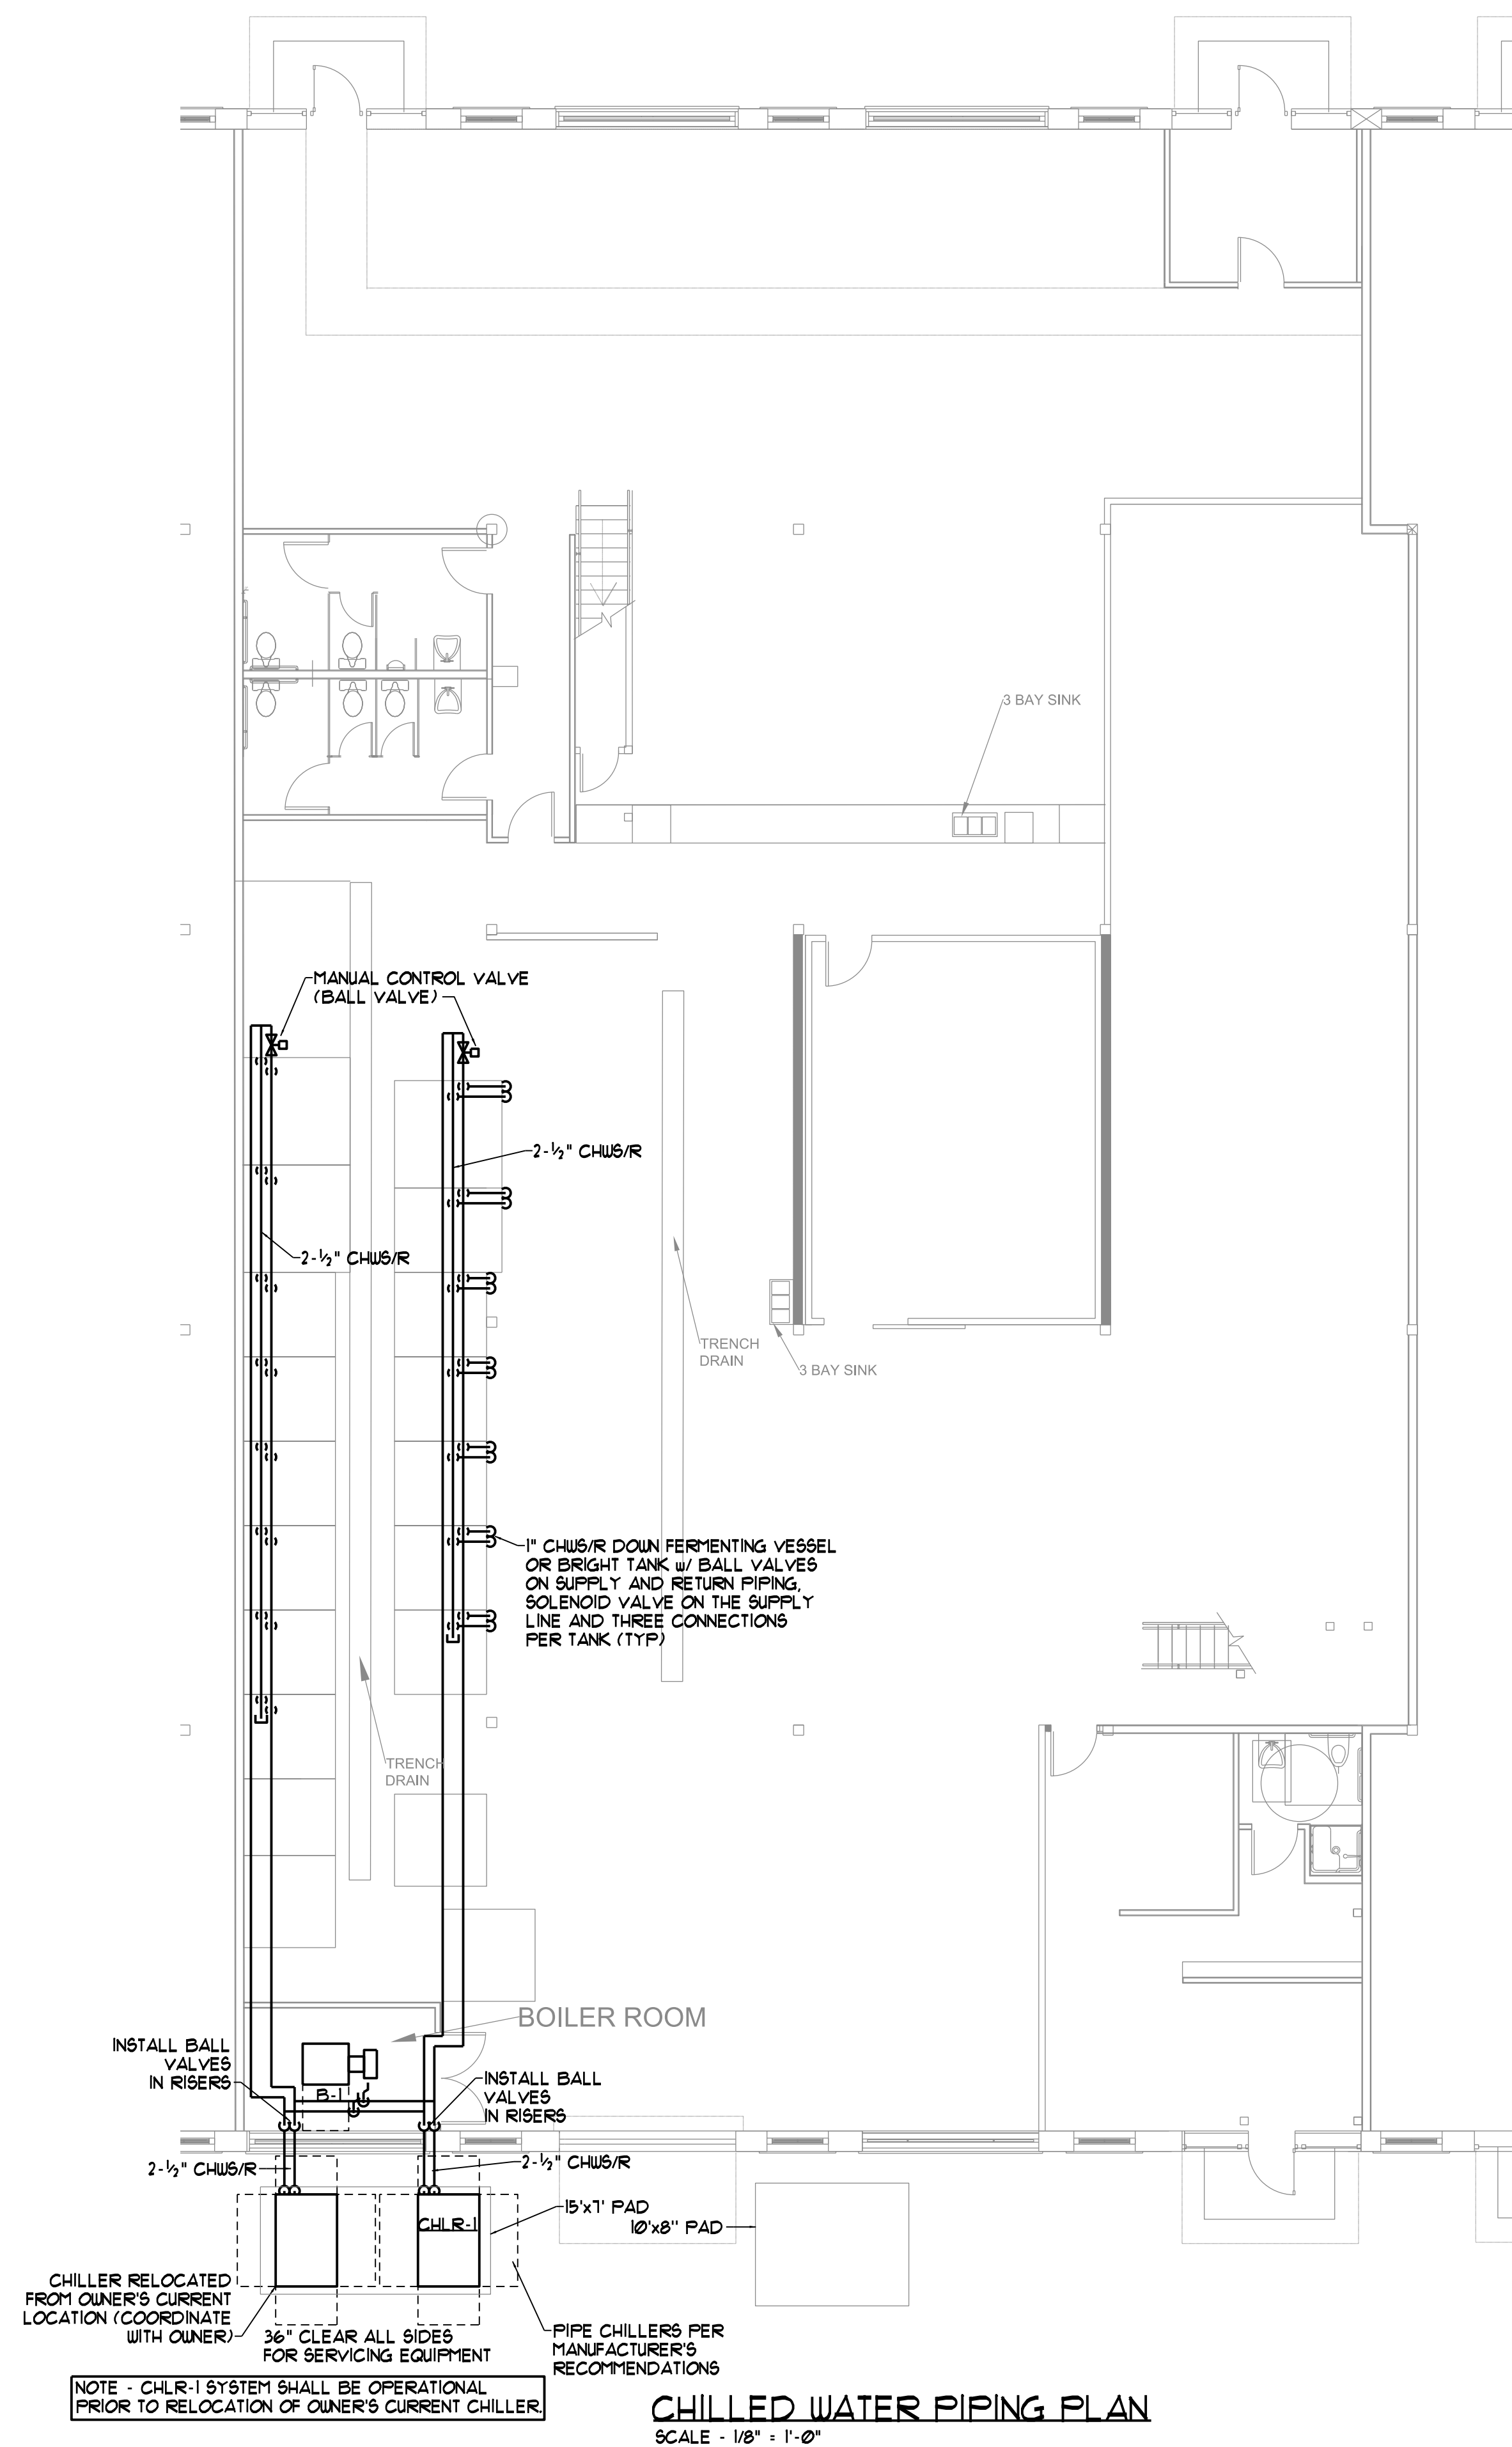

NOTE - CHLR-1 SYSTEM SHALL BE OPERATIONAL PRIOR TO RELOCATION OF OWNER'S CURRENT CHILLER

**CHILLED WATER PIPING PLAN**  
SCALE - 1/8" = 1'-0"

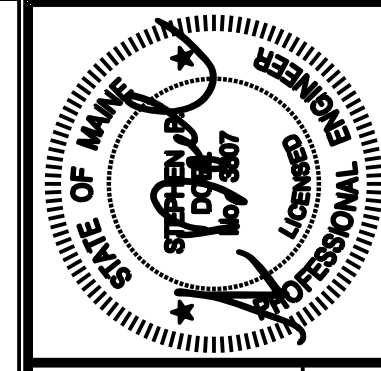

Prepared For:



Consultant:

Architect: **ARCHETYPE**  
48 Union Wharf Portland, Maine 04101  
(207) 772-6022 Fax (207) 772-4056

Project: **BRICK NORTH BISSELL BROTHERS BREWERY**  
THOMPSON'S POINT, PORTLAND ME

Revisions:	ISSUED FOR CONSTRUCTION
1	1-8-16
2	2-5-16

Scale: 1/8" = 1'-0"

Date: 2-5-16

**MECHANICAL PROCESS PLAN**

**M2.01**