



LIGHTING FIXTURES:  
 TYPE S1 ROADWAY LIGHTING POLE  
 HOTOPLANE #LEGO 072 035 4K AS K L3 D RCL P9 (FITTURE)  
 SITESINK #SUN7212221 HDI (BRACKET ARM) (POLE)  
 SITESLINK #SIDEVOROC3B7201 (BASE)  
 TYPE S2 PARKING LOT LIGHTING POLE  
 GARDOO #P21-DM-A1-1-2-SSJA-NW-UNV-BLP-PC(S)-PIN RECEP)-SPR (FITTURE)  
 PROVIDE A 3FT CONCRETE BASE  
 TYPE S3 PARKING LOT LIGHTING POLE  
 GARDOO #P21-DM-A1-1-4-105JA-NW-UNV-BLP-PC(S)-PIN RECEP)-SPR (FITTURE)  
 PROVIDE A 3FT CONCRETE BASE  
 TYPE S4 PARKING LOT LIGHTING POLE  
 GARDOO #TRC-AB-17-D1-BLP (POLE)  
 PROVIDE A 3FT CONCRETE BASE  
 TYPE S5 CANOPY LIGHT  
 STONOCO #S535C128H1B88CB  
 TYPE S6 WALL MOUNTED LIGHT  
 GARDOO #121-3-26JA-NW-120-BLP-PCB120

LETTERING ENCLOSURE  
 SELF CONTAINED SINGLE  
 PHASE COMMERCIAL  
 100 AMP - 120/240V  
 6"W X 6"W X 72"H  
 PRESSURE TREATED  
 POSS GEMBED FOR  
 CONCRETE (PH, 3M,  
 NEMA 3R ENCL.  
 RAINROOF PANEL 1" x  
 24" MIN.  
 FINISHED GRADE  
 ALL STREET LIGHTING  
 2 #4, 1 #BOND CONDUCTORS  
 TO LIGHTING  
 POLES



UTILITY METER  
 BONDING AND  
 GROUNDING PER  
 N.E.C. ART. 250  
 CONDUIT CLAMPS  
 PER N.E.C.  
 CU GND. WIRE  
 TO 3/4"x10'-0"  
 GND. ROD  
 TO OMP POLE #3  
 3 #2, 2" OBT  
 FRONT VIEW  
 SIDE VIEW

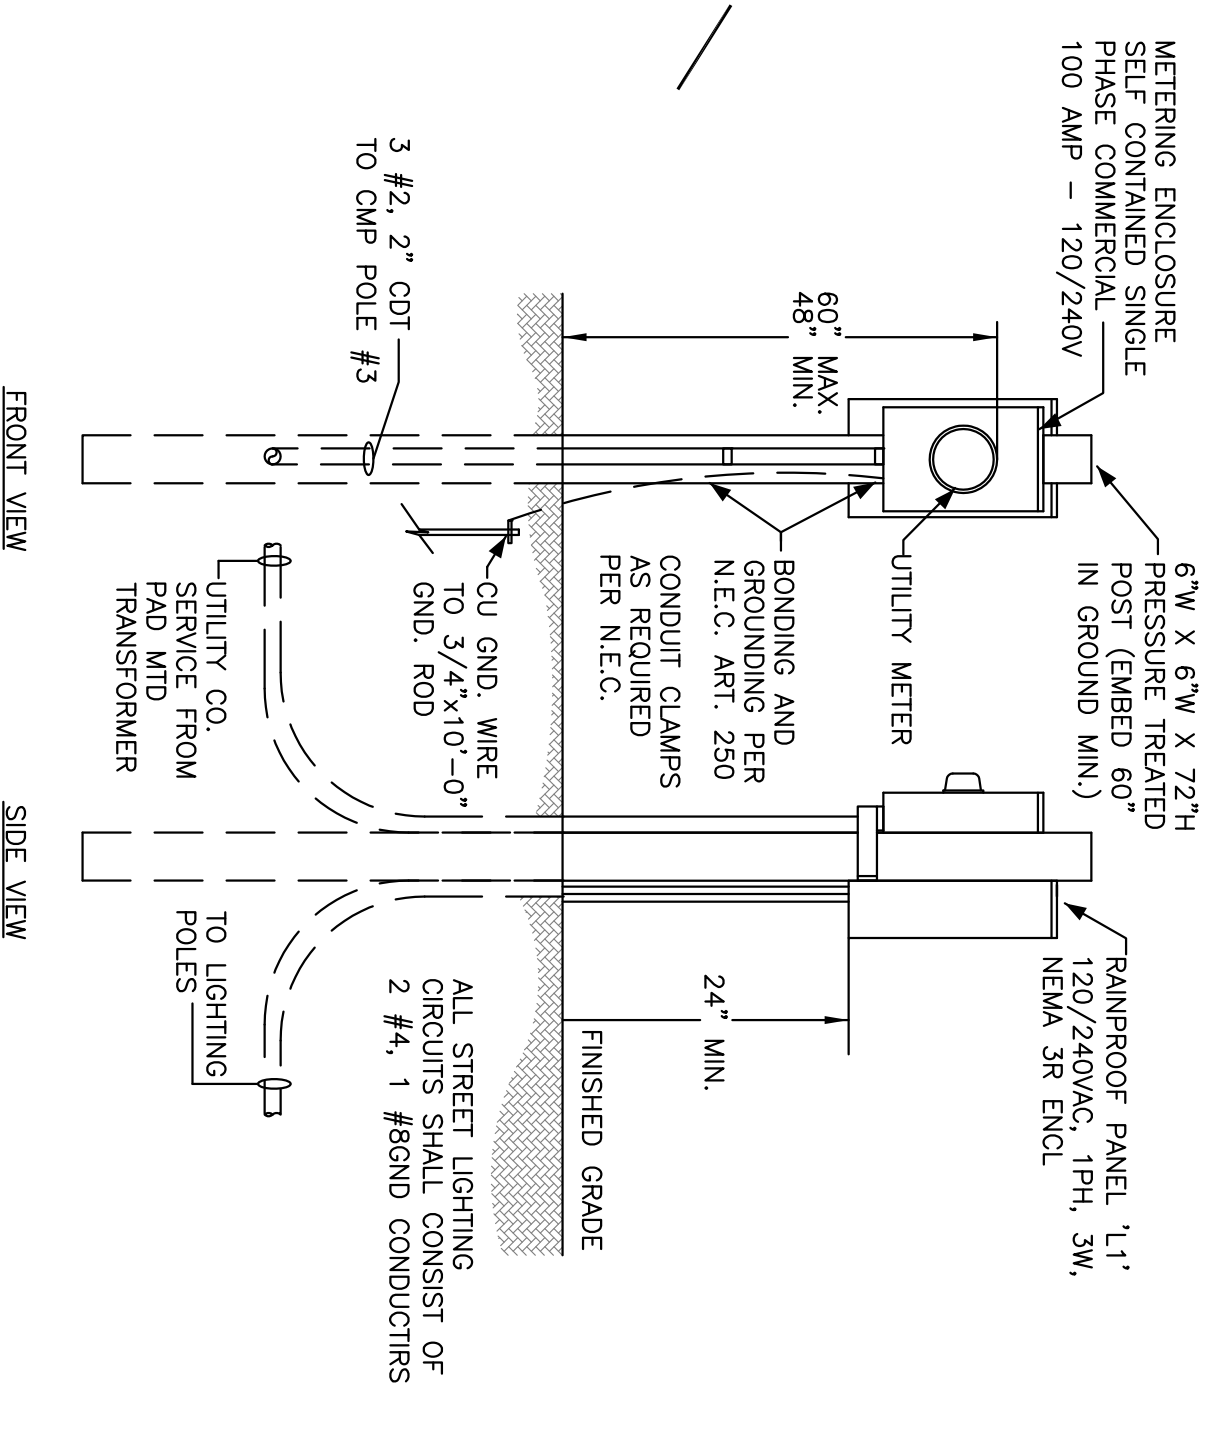

STREET LIGHTING SERVICE METER DETAIL  
 NOT TO SCALE

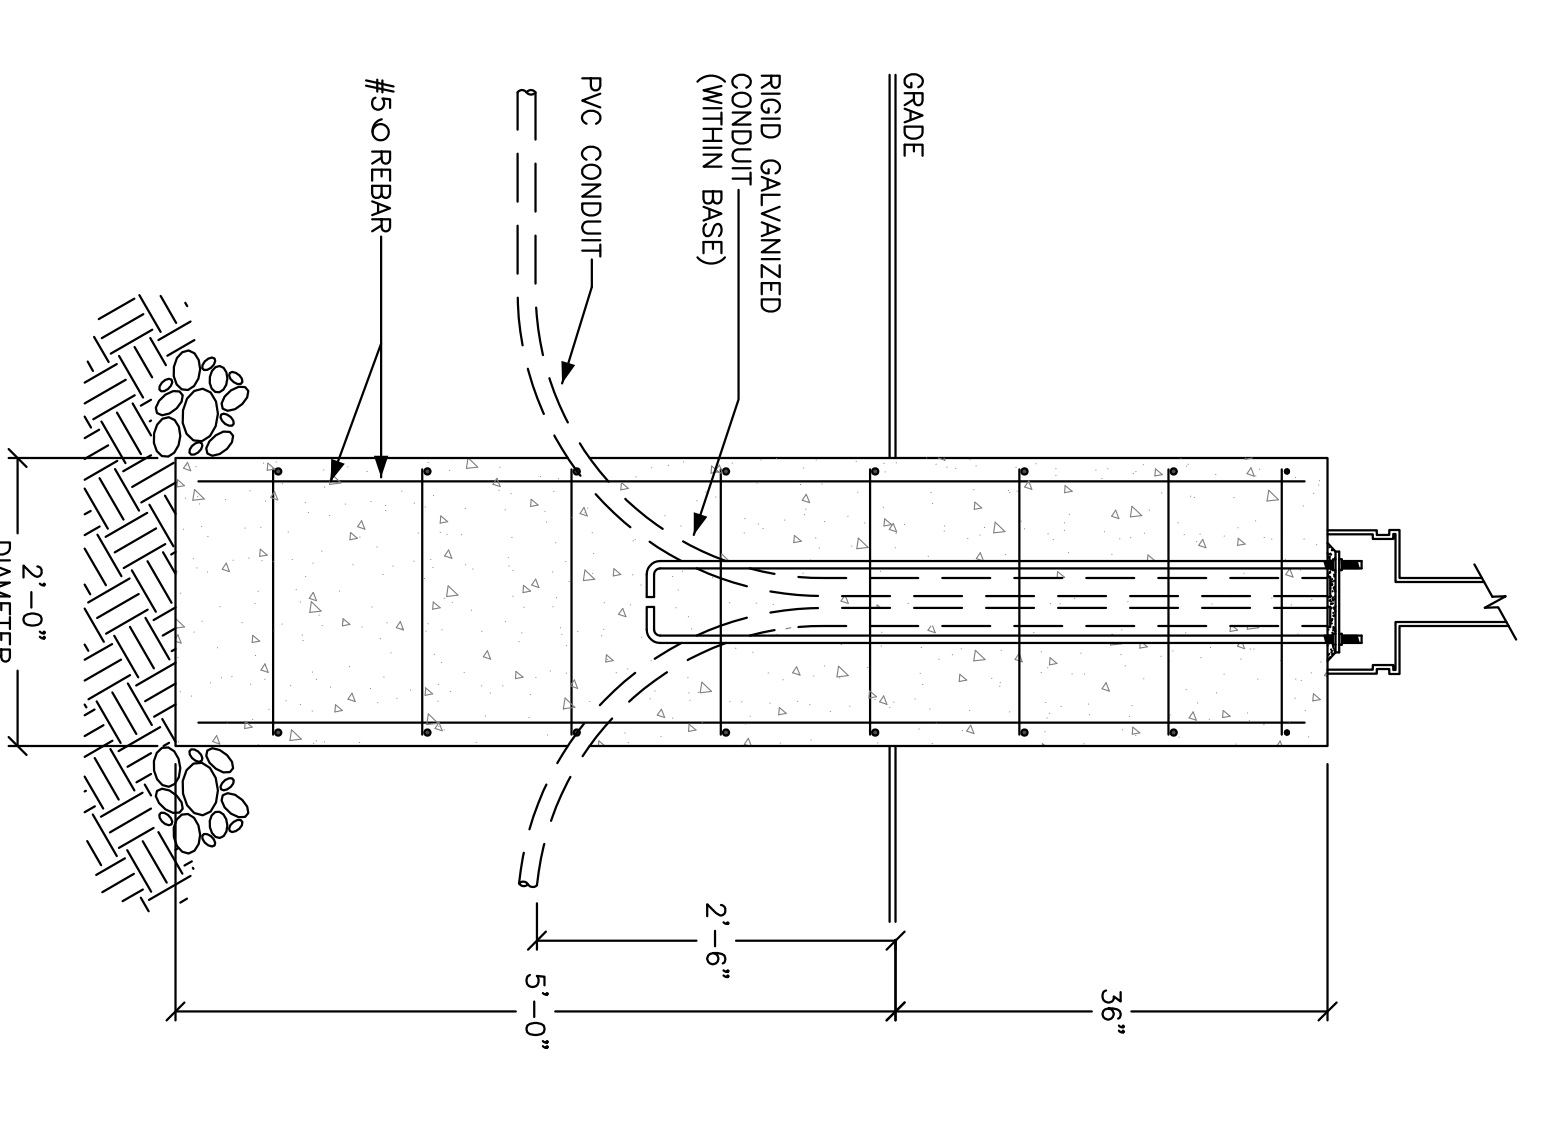

LIGHTING POLE BASE DETAIL  
 NOT TO SCALE

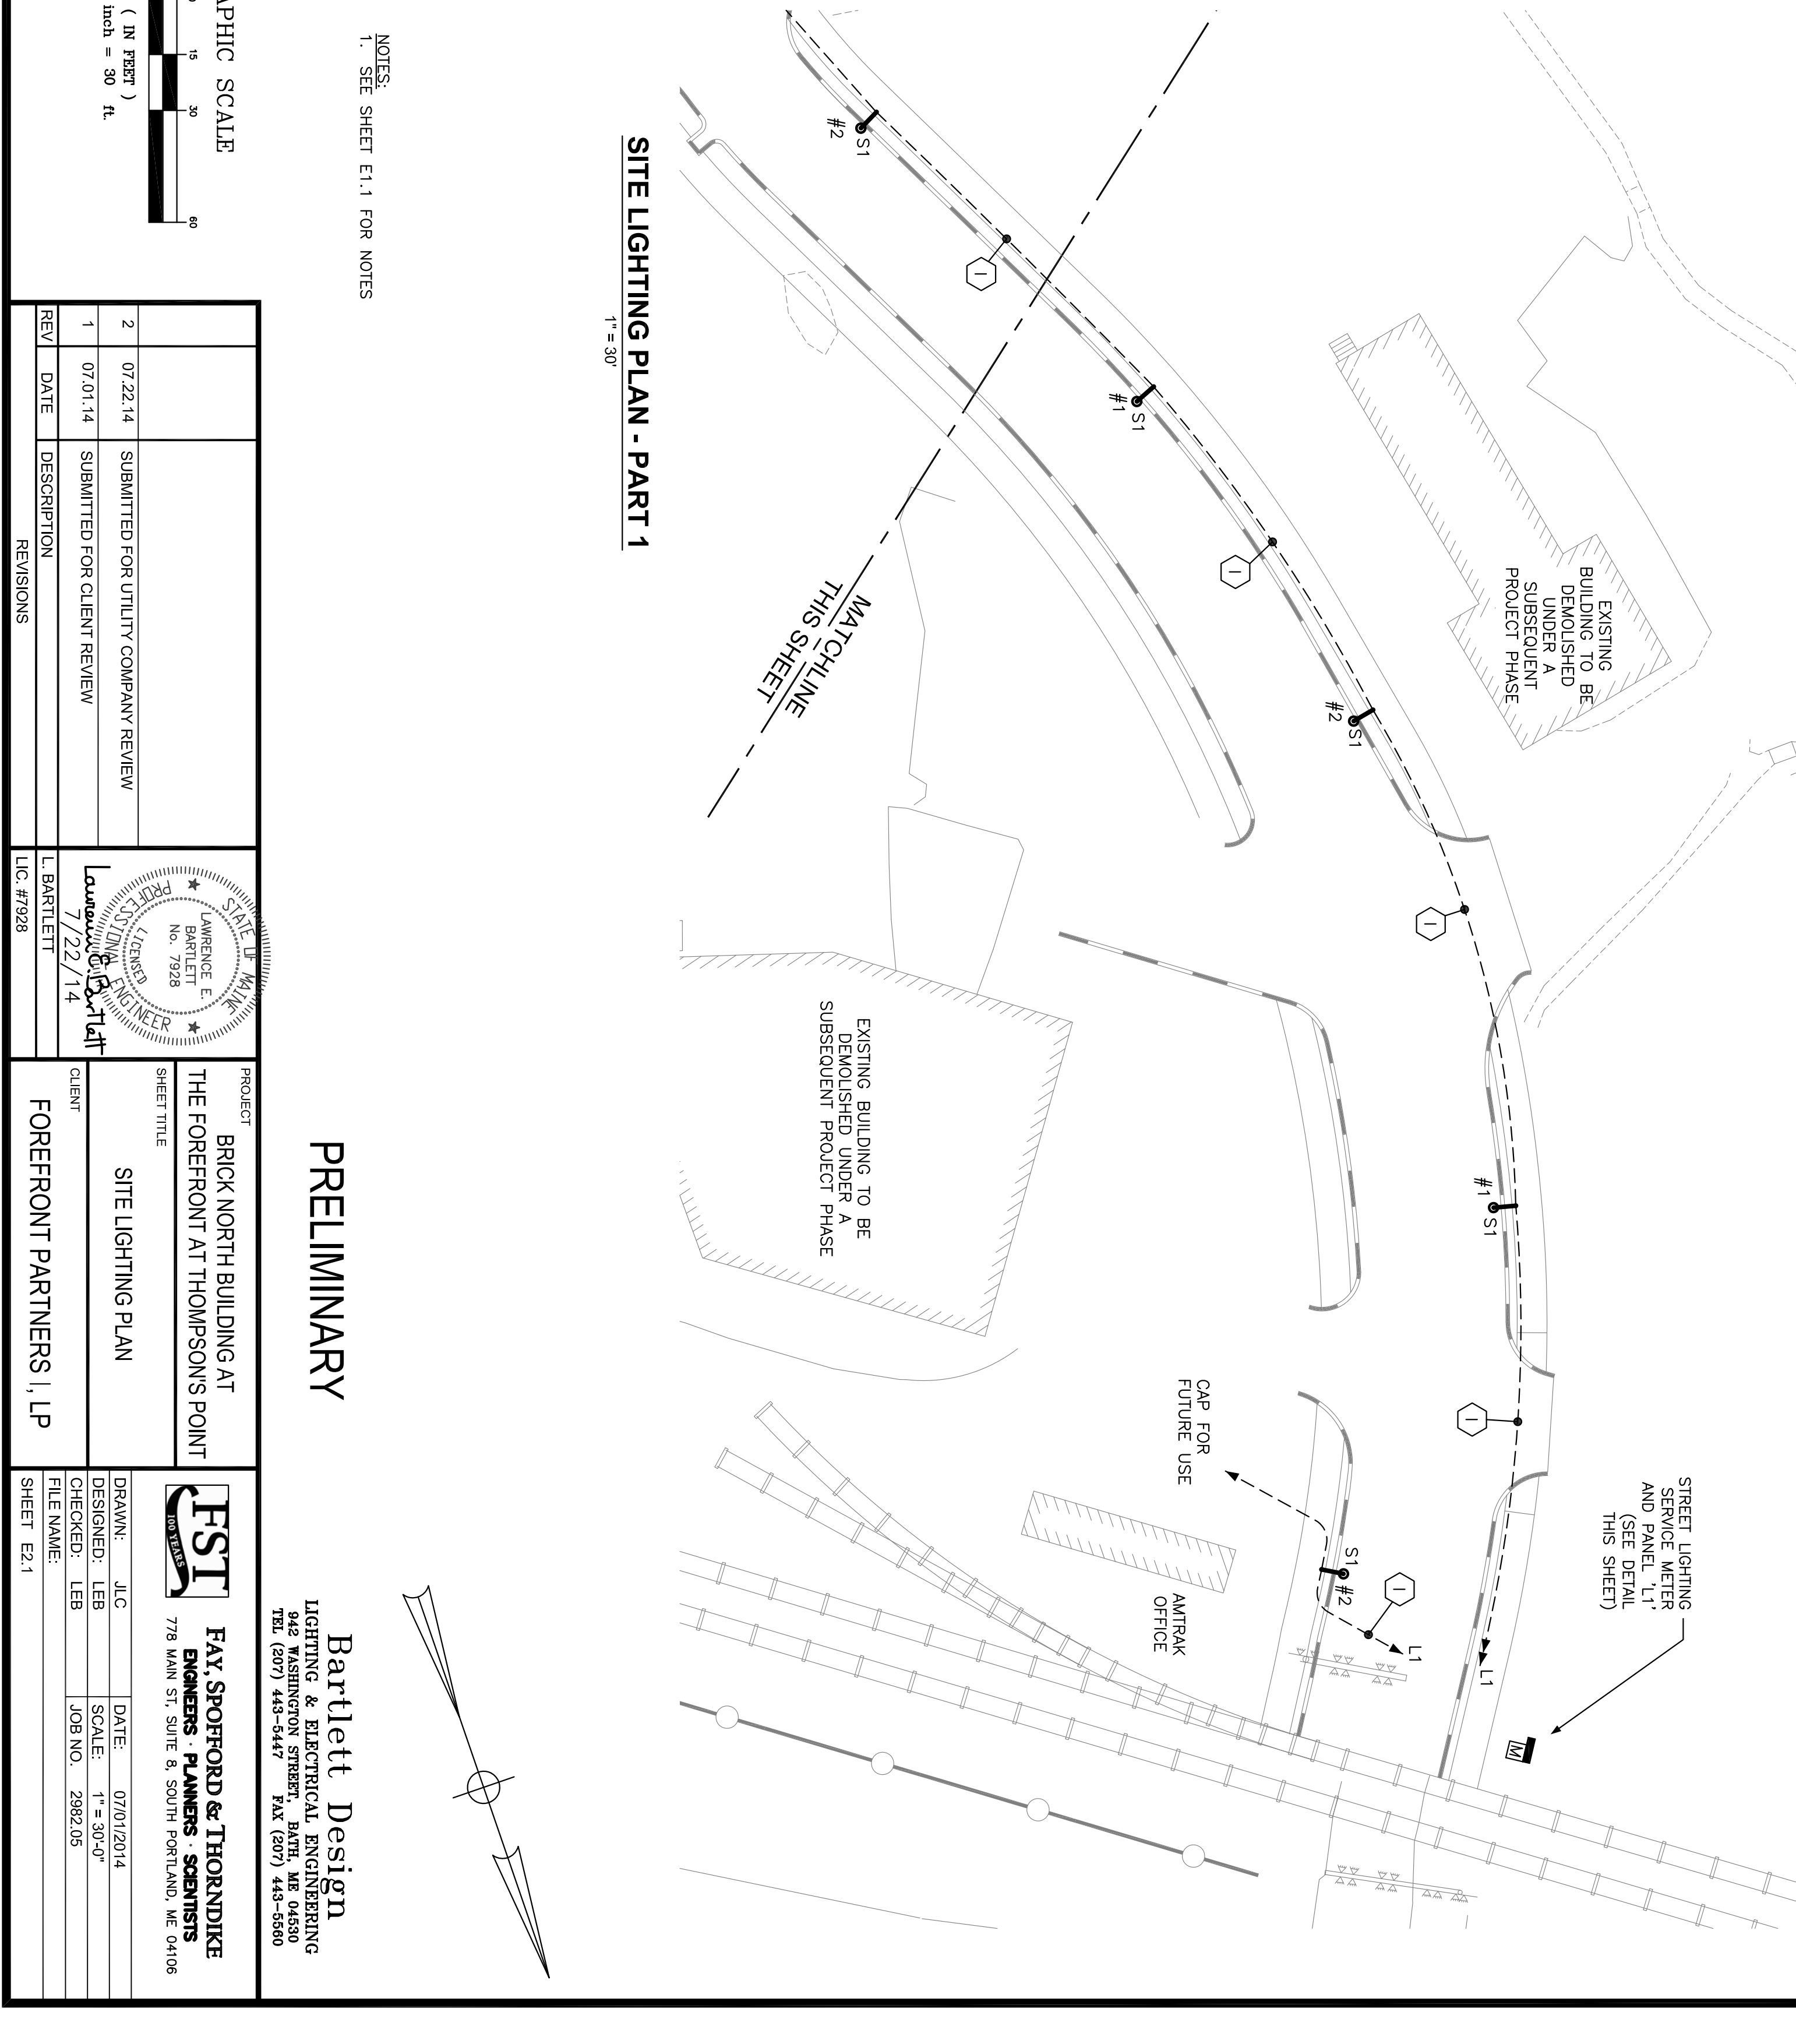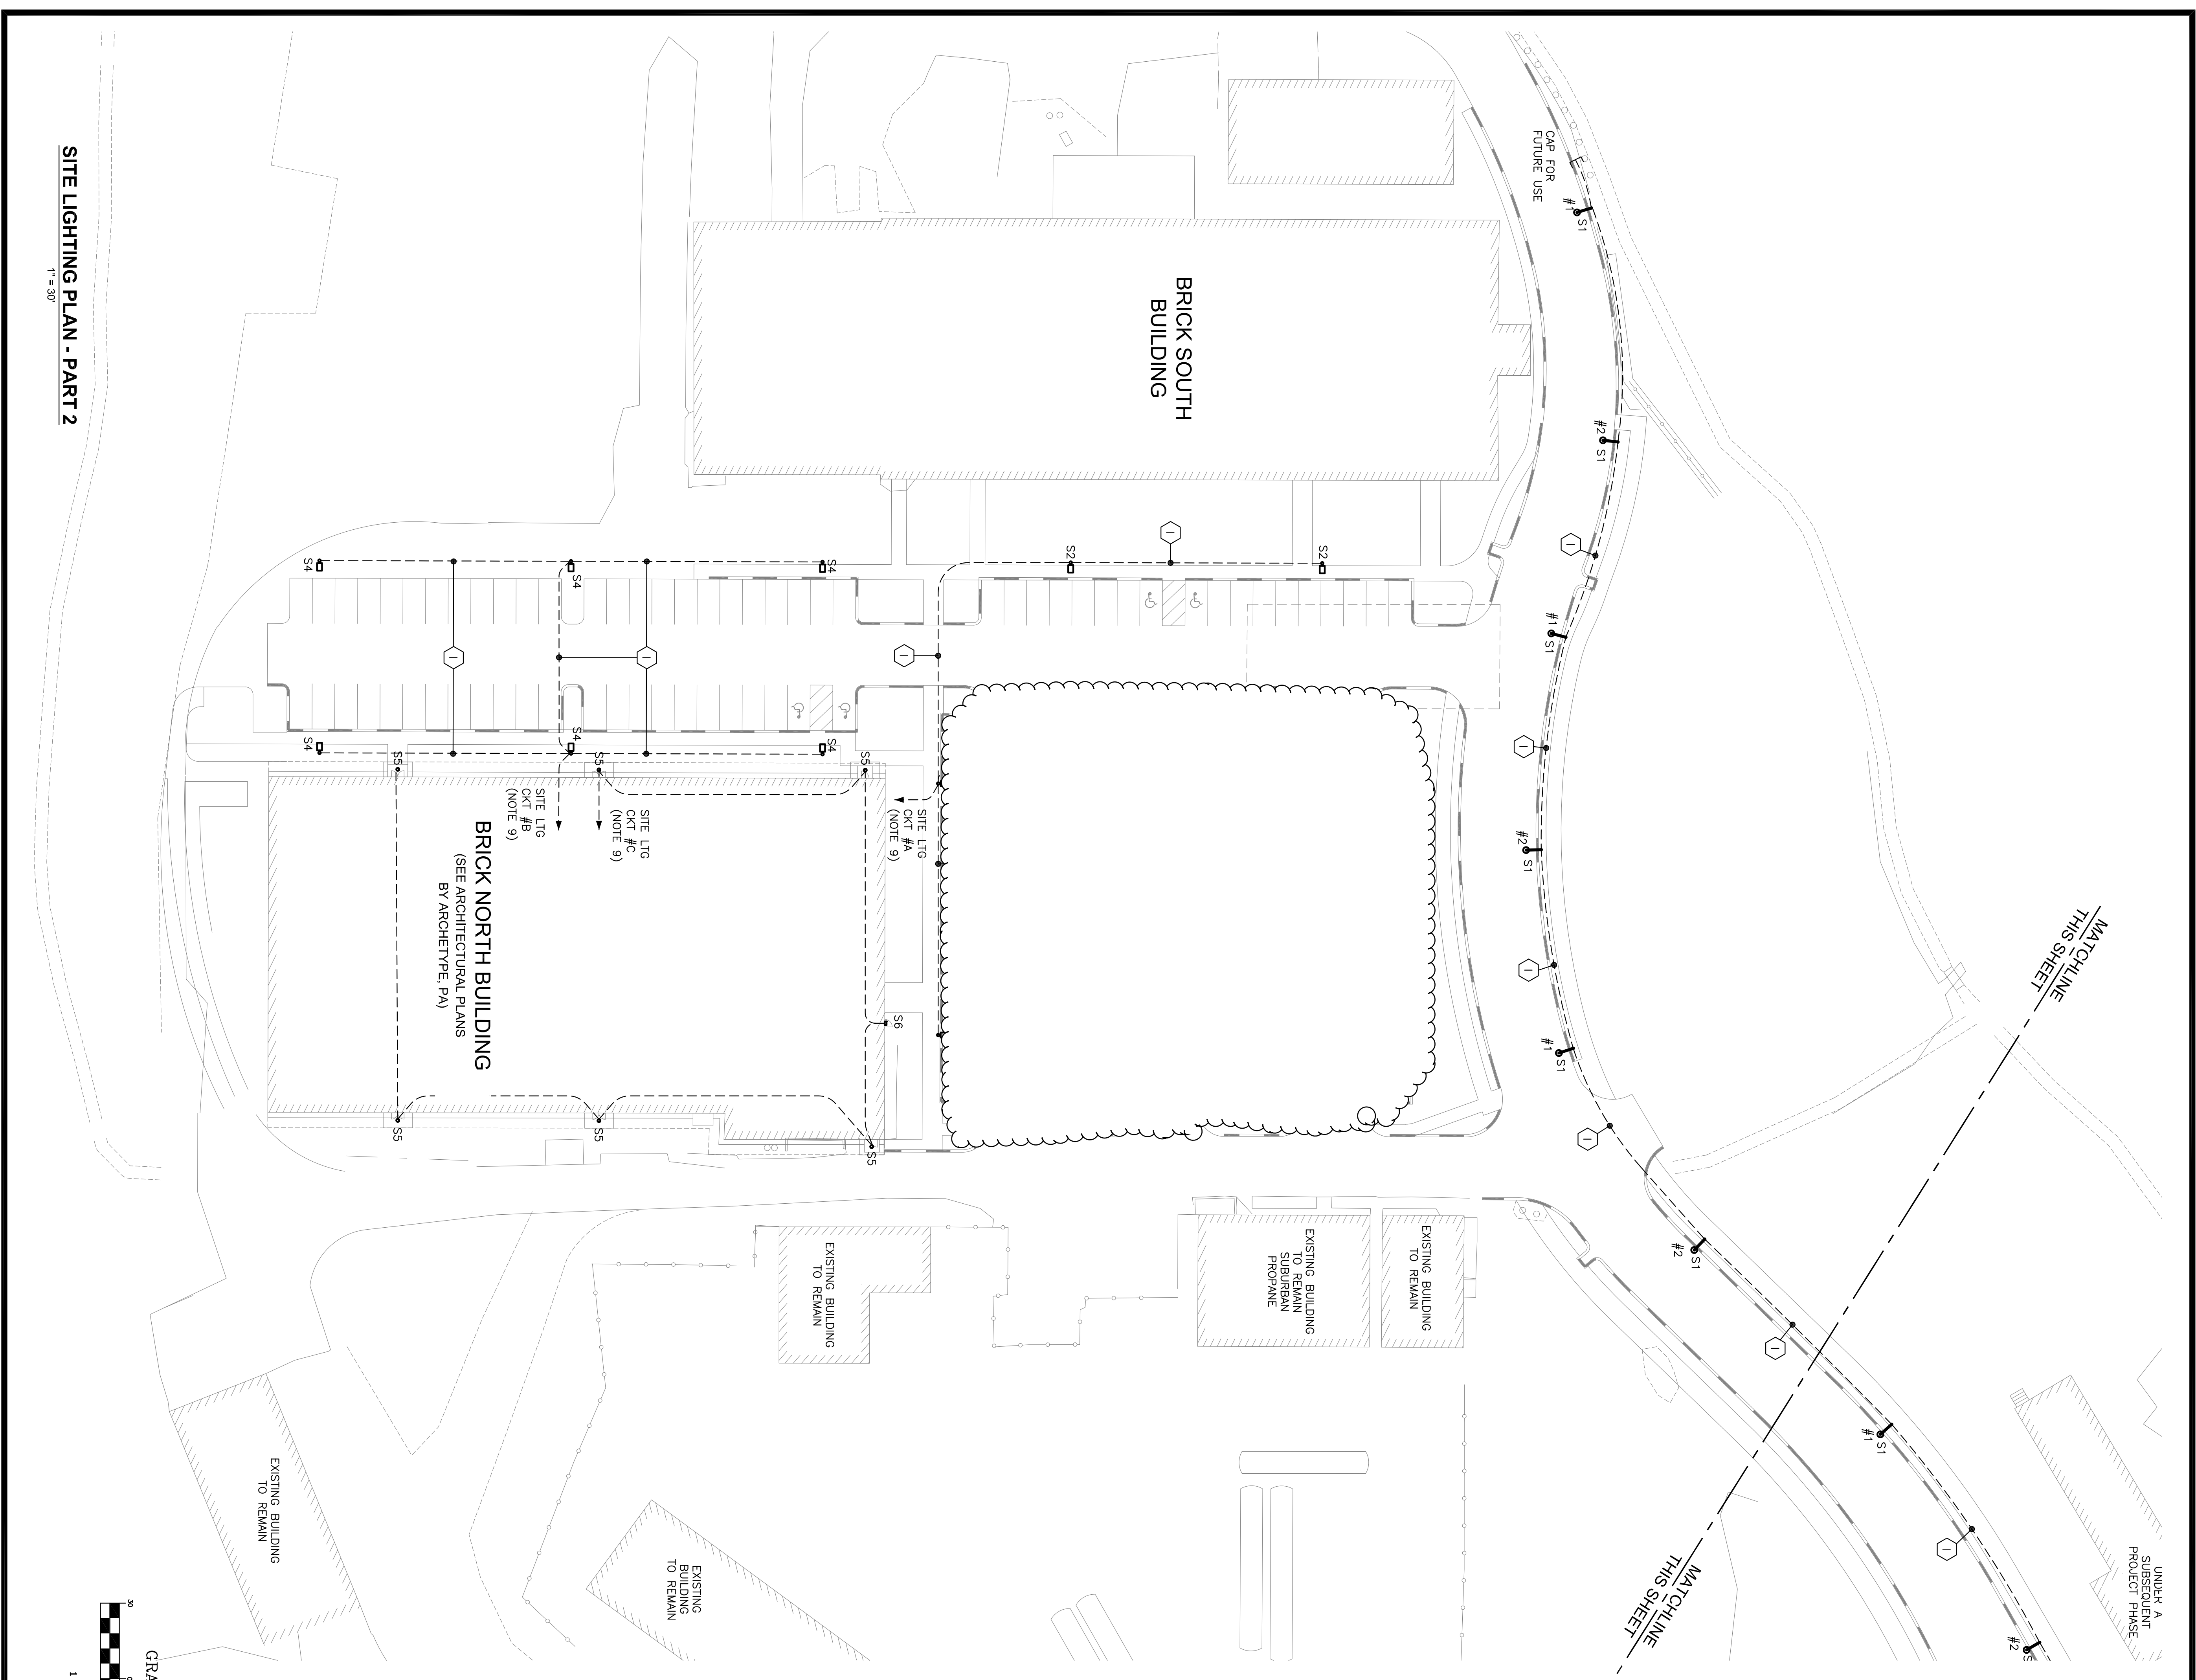

GRAPHIC SCALE  
 1 inch = 30' ft.

NOTES:  
 1. SEE SHEET E1.1 FOR NOTES

**PRELIMINARY**

PROJECT: BRICK NORTH BUILDING AT THE FOREFRONT AT THOMPSON'S POINT  
 SHEET TITLE: SITE LIGHTING PLAN  
 CLIENT: FOREFRONT PARTNERS, LP

**Bartlett Design**  
 LIGHTING & ELECTRICAL ENGINEERING  
 842 WASHINGTON STREET, BARTLETT, ME 04500  
 TEL (207) 448-3447 FAX (207) 448-5580

**FST**  
 FAY SPOFFORD & THORNDIKE  
 ENGINEERS - PLANNERS - SCIENTISTS  
 778 MAIN ST. SUITE B, SOUTH PORTLAND, ME 04106

REV	DATE	DESCRIPTION	REVISIONS
1	07/01/14	SUBMITTED FOR CLIENT REVIEW	L. BARTLETT
2	07/23/14	SUBMITTED FOR UTILITY COMPANY REVIEW	L. BARTLETT

DRAWN: JLC DATE: 07/01/2014  
 DESIGNER: LEB SCALE: 1" = 30'-0"  
 CHECKED: LEB JOB NO.: 282205  
 SHEET: E2.1