

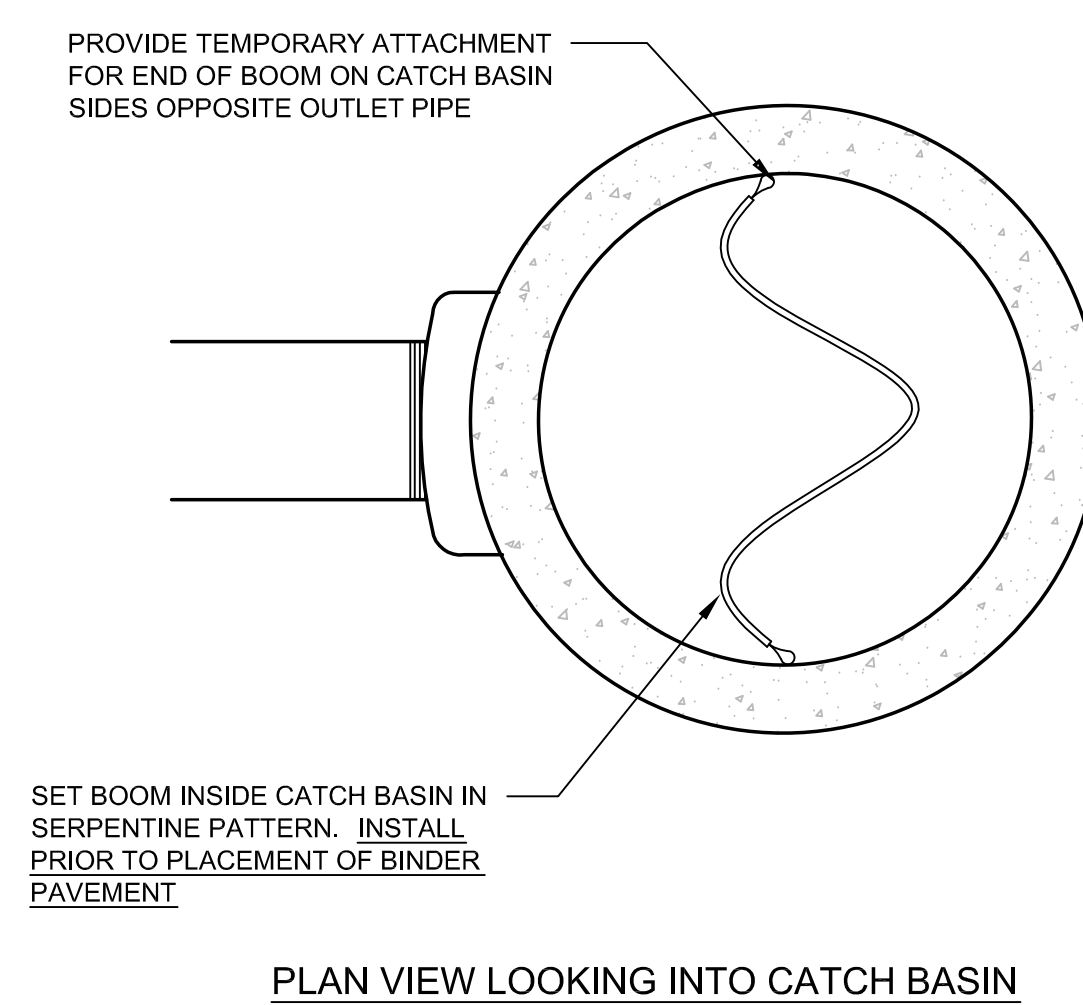


(A) ANTISEEP COLLAR
N.T.S.

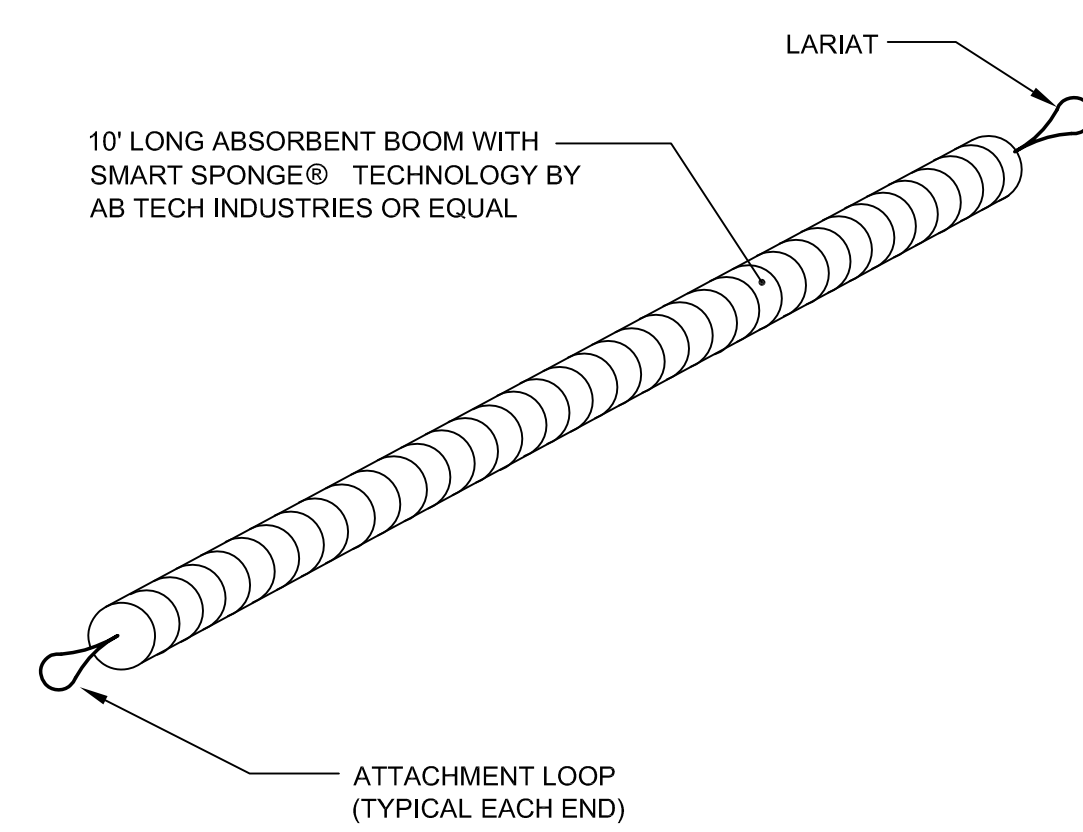

- NOTES:
1. REQUIRED FOR ALL CATCH BASINS WHICH RECEIVE RUNOFF FROM PAVED AREAS.
 2. REFER TO EROSION CONTROL REPORT FOR ADDITIONAL INFORMATION.
 3. CONTRACTOR MAY SELECT OTHER TYPE OF EQUIVALENT OIL ABSORBENT PRODUCTS.
 4. SUBMITTALS ARE REQUIRED FOR THESE ITEMS.

(B) TEMPORARY WATER QUALITY MEASURE INSIDE OF CATCH BASINS
N.T.S.

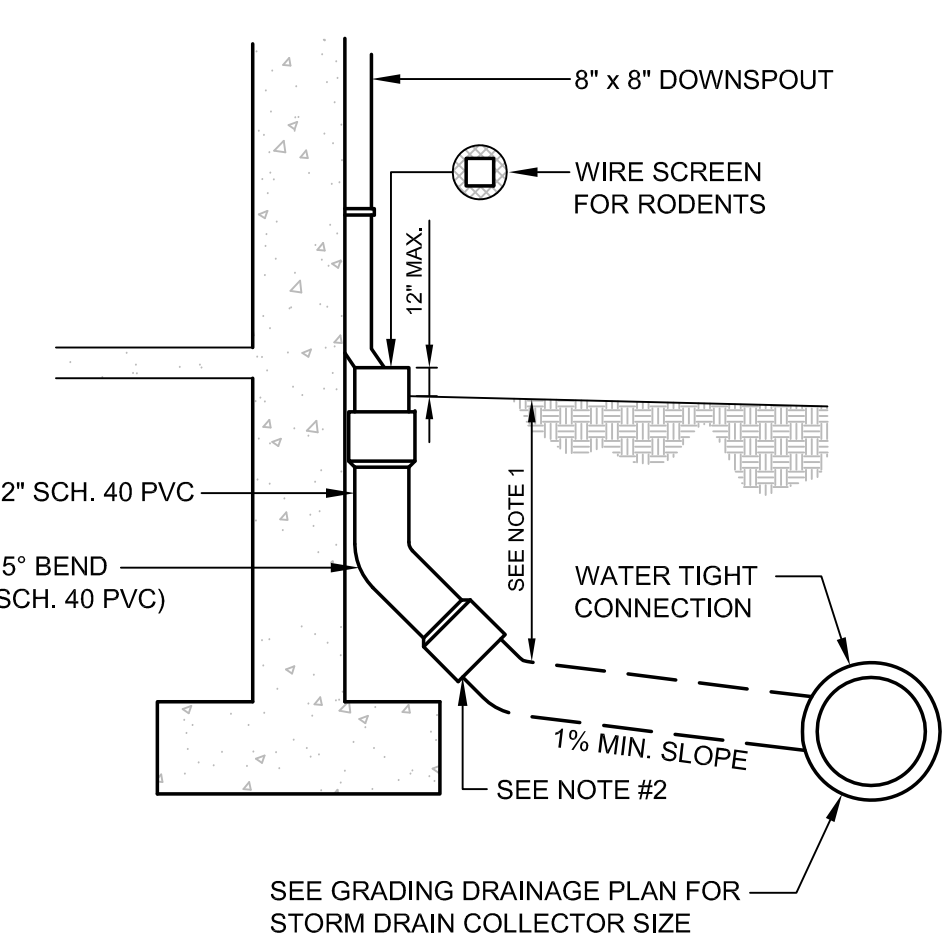


- NOTES:
1. FOR ALL DEPTHS OF COVER LESS THAN TWO (2) FEET, PIPE MUST BE SCHEDULE 40 PVC. FOR DEPTHS OF COVER GREATER THAN TWO (2) FEET, FLEXIBLE PIPE MAY BE USED. REFER TO SPECIFICATIONS FOR ALLOWABLE PIPE TYPES.
 2. A WATERTIGHT CONNECTION SHALL BE MAINTAINED WITH ANY TRANSITION FROM SCHEDULE 40 PVC PIPE TO ANY OTHER PIPE TYPE.
 3. THE DOWNSPOUT COLLECTOR DRAIN SHALL BE INSTALLED BEFORE THE DOWNSPOUTS ARE INSTALLED ON THE BUILDING. SITE WORK CONTRACTOR SHALL BE RESPONSIBLE FOR ALL WORK TO AND INCLUDING THE RODENT SCREEN. BUILDING CONTRACTOR SHALL BE RESPONSIBLE FOR THE CONNECTION AT THE POINT OF THE RODENT SCREEN.
- NOTE:
ARCHITECT MAY ELECT TO USE INTERNAL ROOF DRAINS - REFER TO ARCHITECTURAL PLANS

(C) ROOF DRAIN DETAIL
N.T.S.

PRELIMINARY - NOT FOR CONSTRUCTION

REV	DATE	DESCRIPTION	REVISIONS
1	09.01.15	FINAL BRICK SOUTH LEVEL III SITE PLAN	

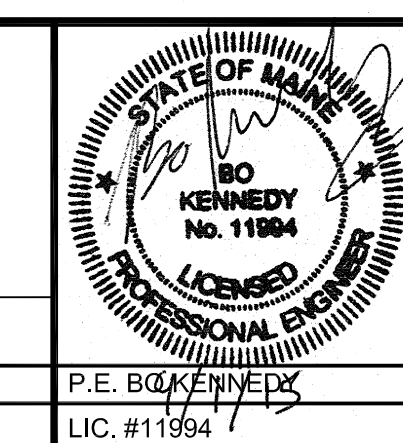

PROJECT: BRICK NORTH AND SOUTH BUILDINGS AT THE FOREFRONT AT THOMPSON'S POINT

SHEET TITLE: STORMWATER DETAILS

CLIENT: FOREFRONT PARTNERS | LP

FST FAY, SPOFFORD & THORNDIKE
ENGINEERS - PLANNERS - SCIENTISTS
778 MAIN ST., SUITE 6, SOUTH PORTLAND, ME 04106

DRAWN: DED DATE: APRIL 2015
DESIGNED: BEK SCALE: N.T.S.
CHECKED: SRB JOB NO. 2982.05
FILE NAME: 2982.05-BS-DET
SHEET: C-8.3