



1 HVAC Upper Level Floor Plan
1/4"=1'-0"

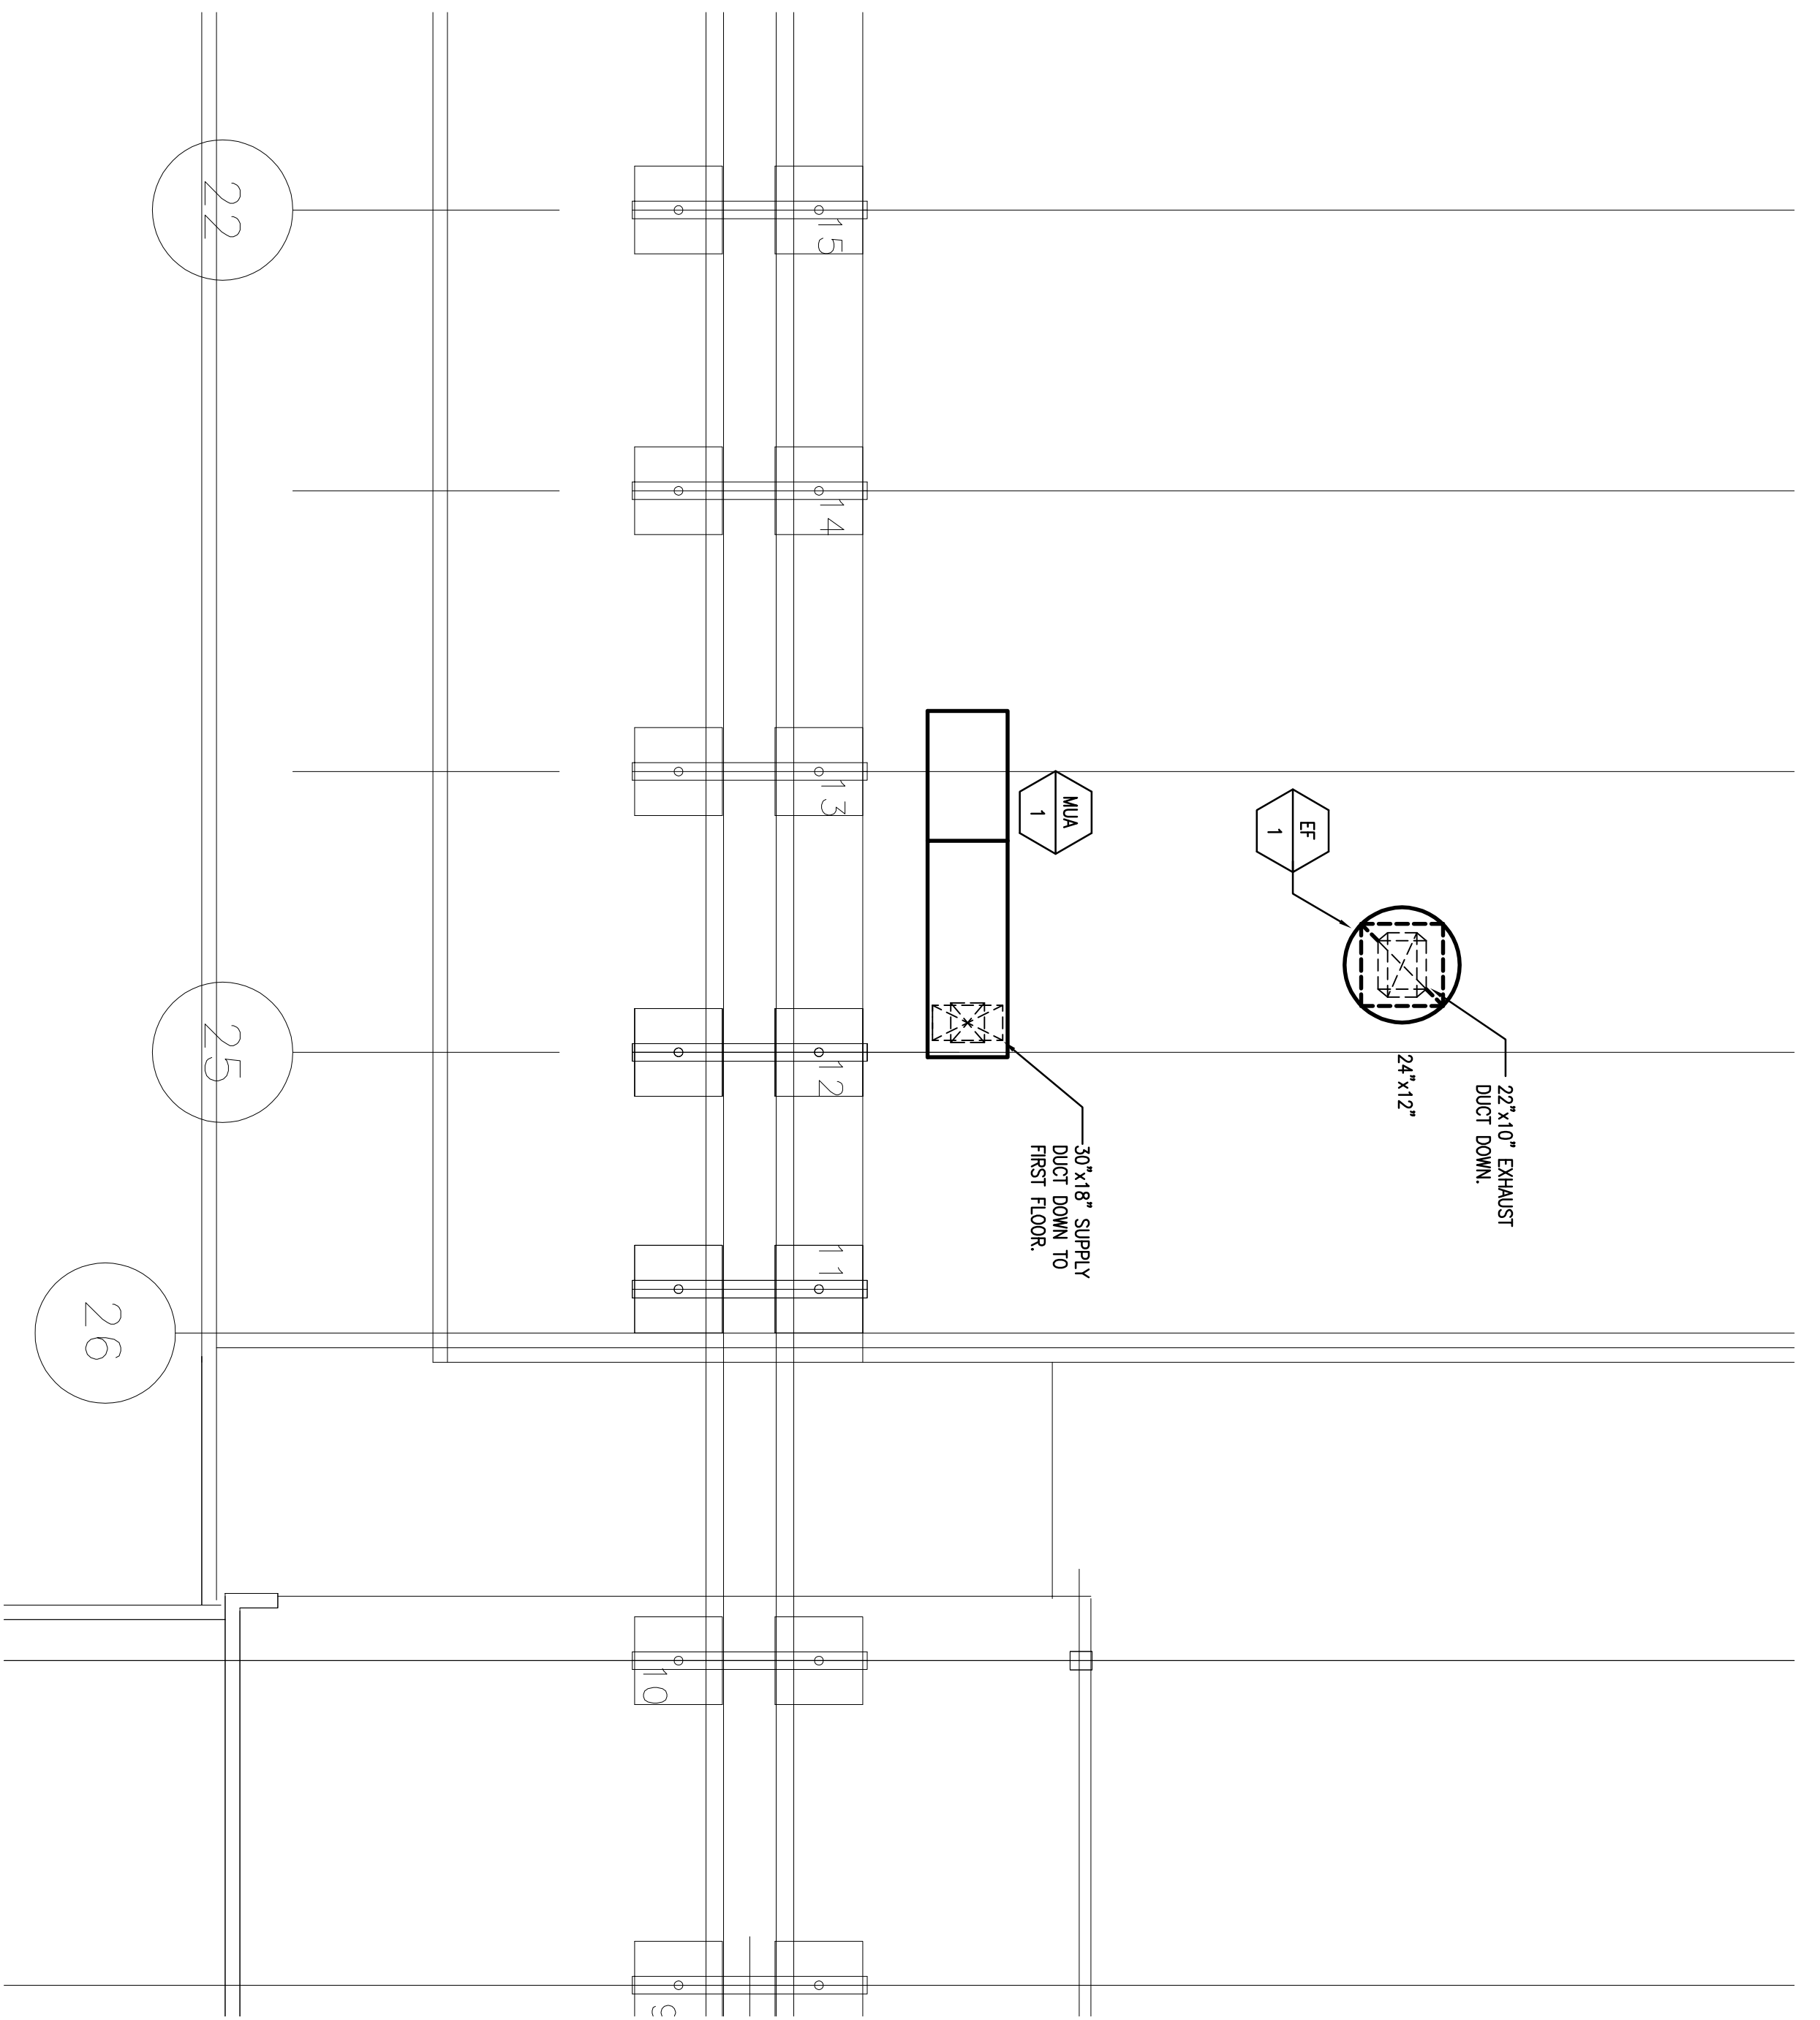

2 HVAC Roof Plan
1/4"=1'-0"

Item	Date

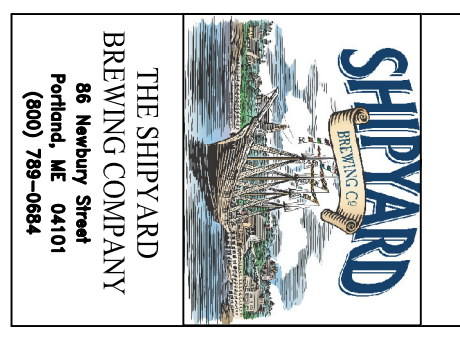

The Shipyard
Main Terminal - Lower Level
Portland International Jetport
1001 Westbrook Street
Portland, ME 04102

HMS Host
6600 Rockledge Drive
Bethesda, MD 20817
Ph: (202) 694-4925
Fax: (202) 694-4175

L2M Foodservice Design Group
8117 Cornwell Park Drive
Glen Burnie, MD 21061
Ph: (410) 863-1302
Fx: (410) 863-1308

Building Engineering Resources, Inc.
28 Main Street, Bldg. 43A
North Easton, MA 02556
T: (508) 250-0200
F: (508) 250-0201
E: ber@ber-engineering.com

LLOYD ARCHITECTS
Two High Cliff, Plymouth MA 02360
TEL: (508) 746-4646
FAX: (508) 746-1236
E-MAIL: info@lloydarch.com

Job No: 07417
Scale: 1/4"=1'-0"
Issued: 12/11/07

Mechanical Floor Plans

M3