
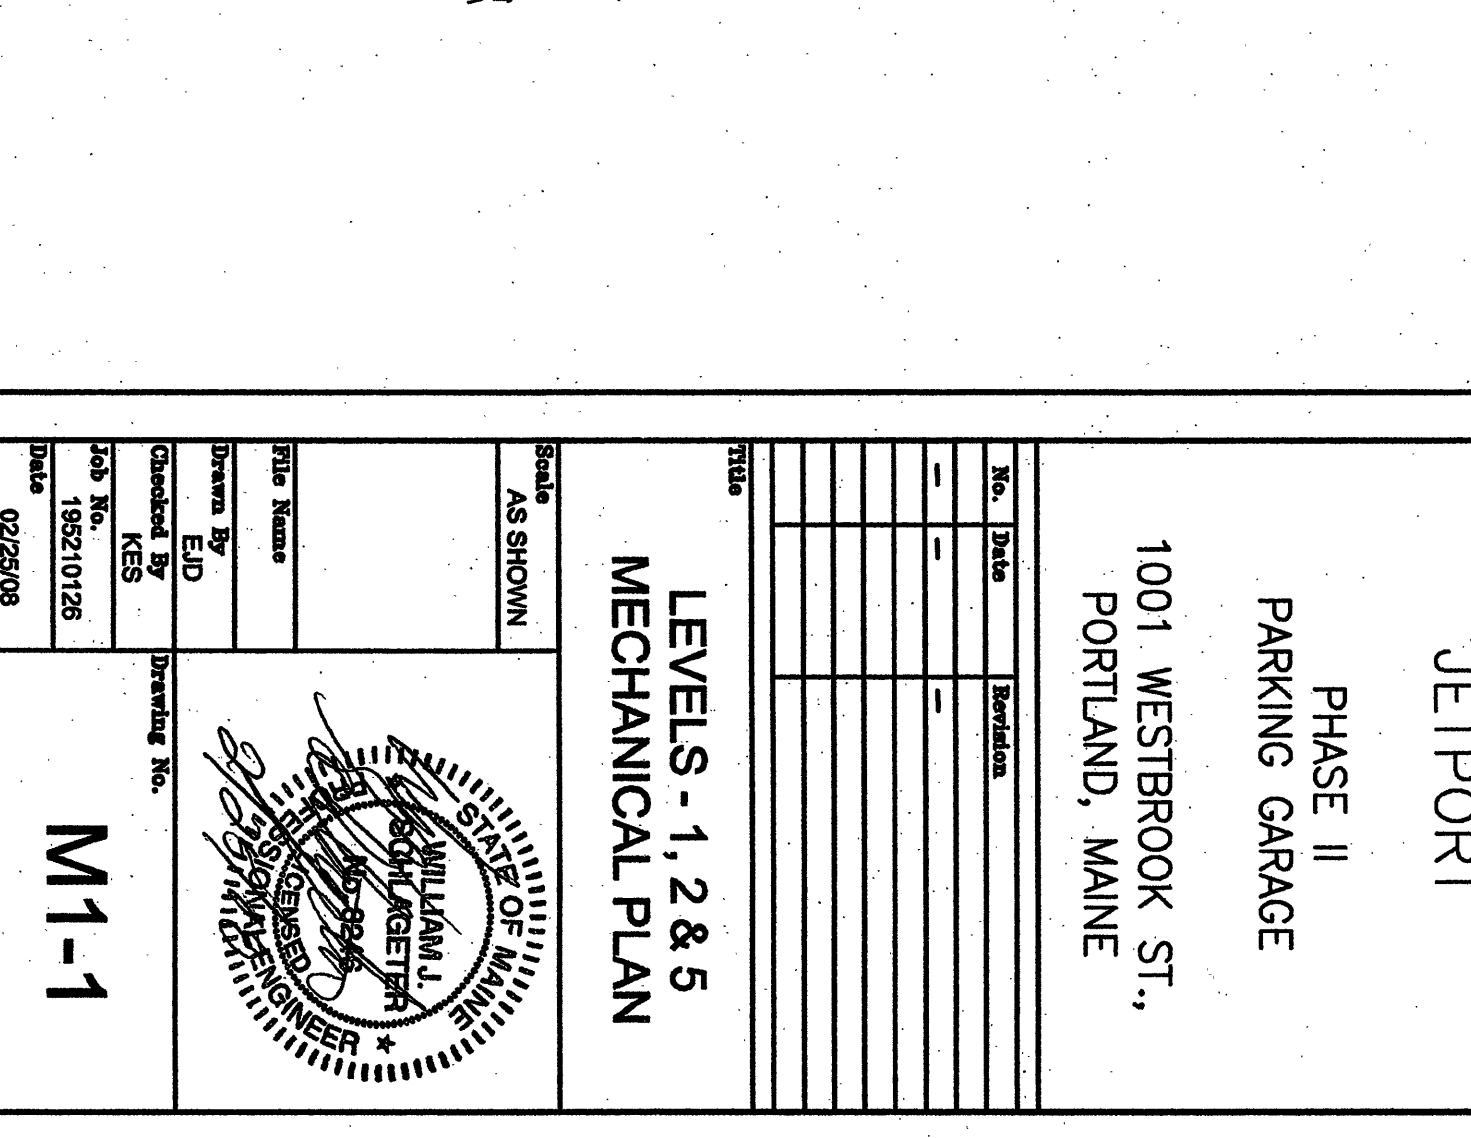
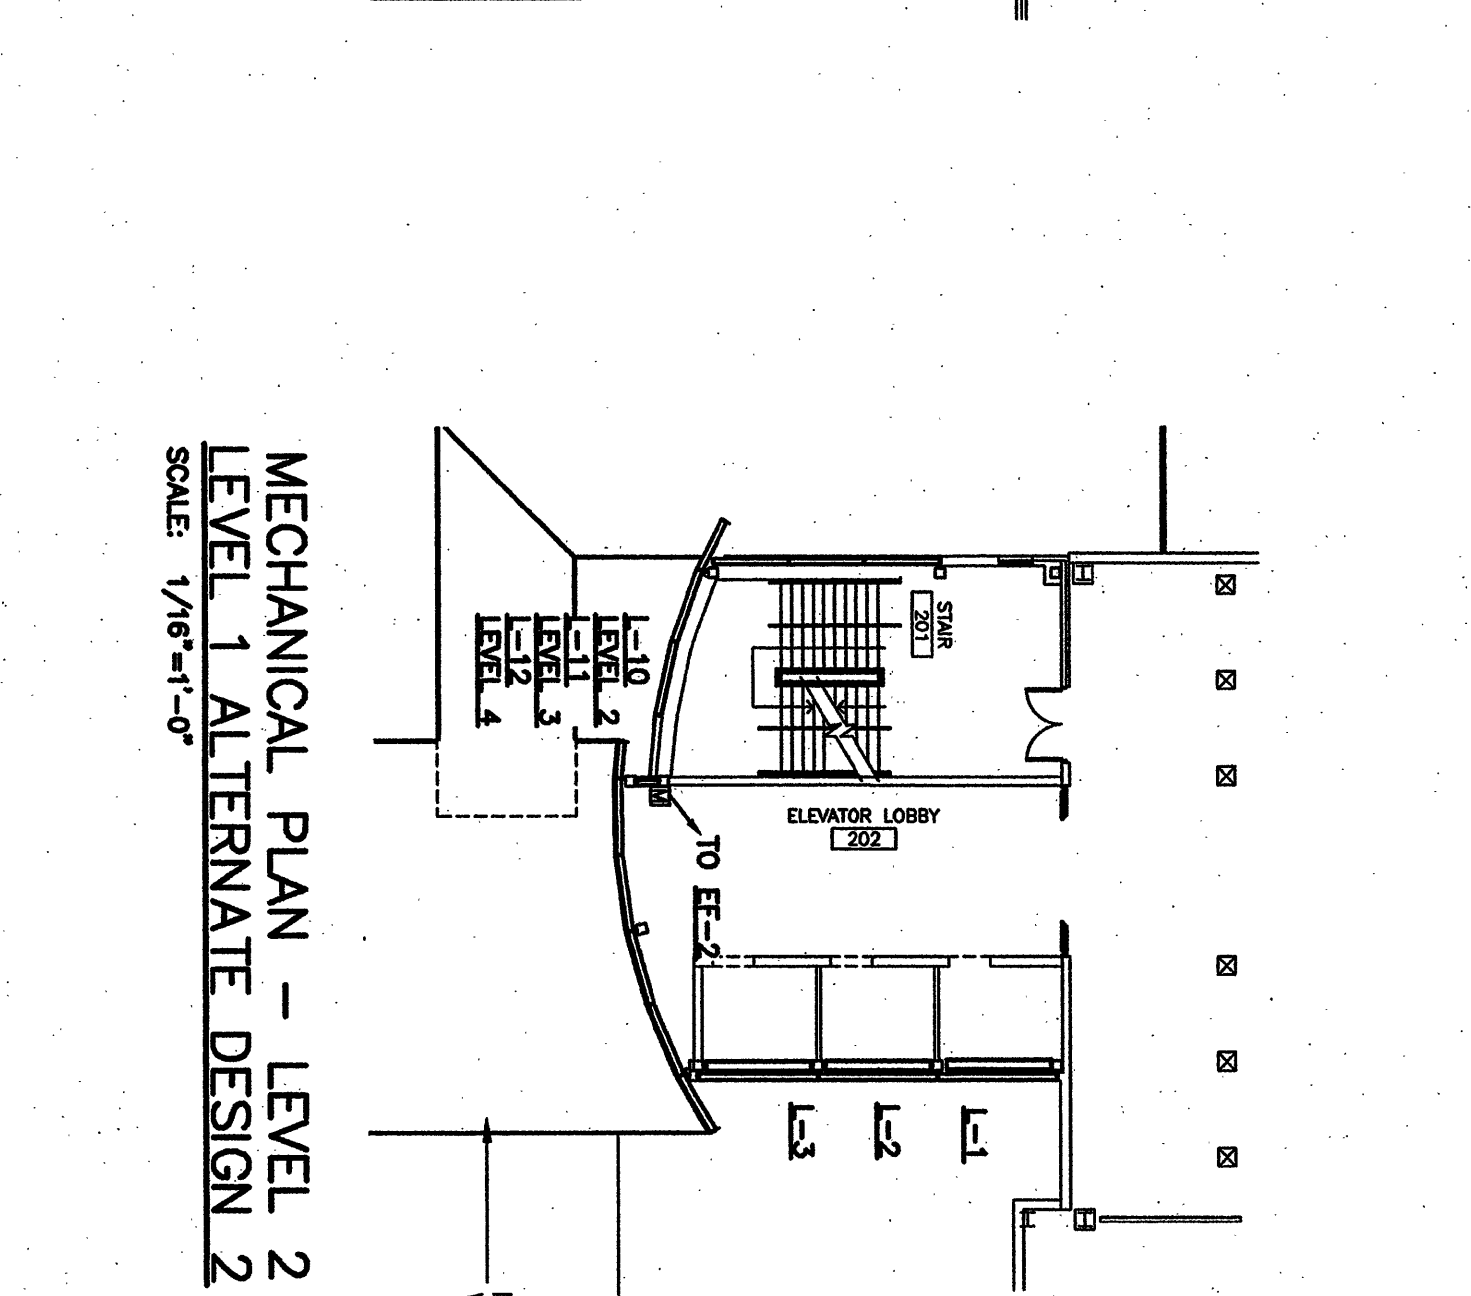
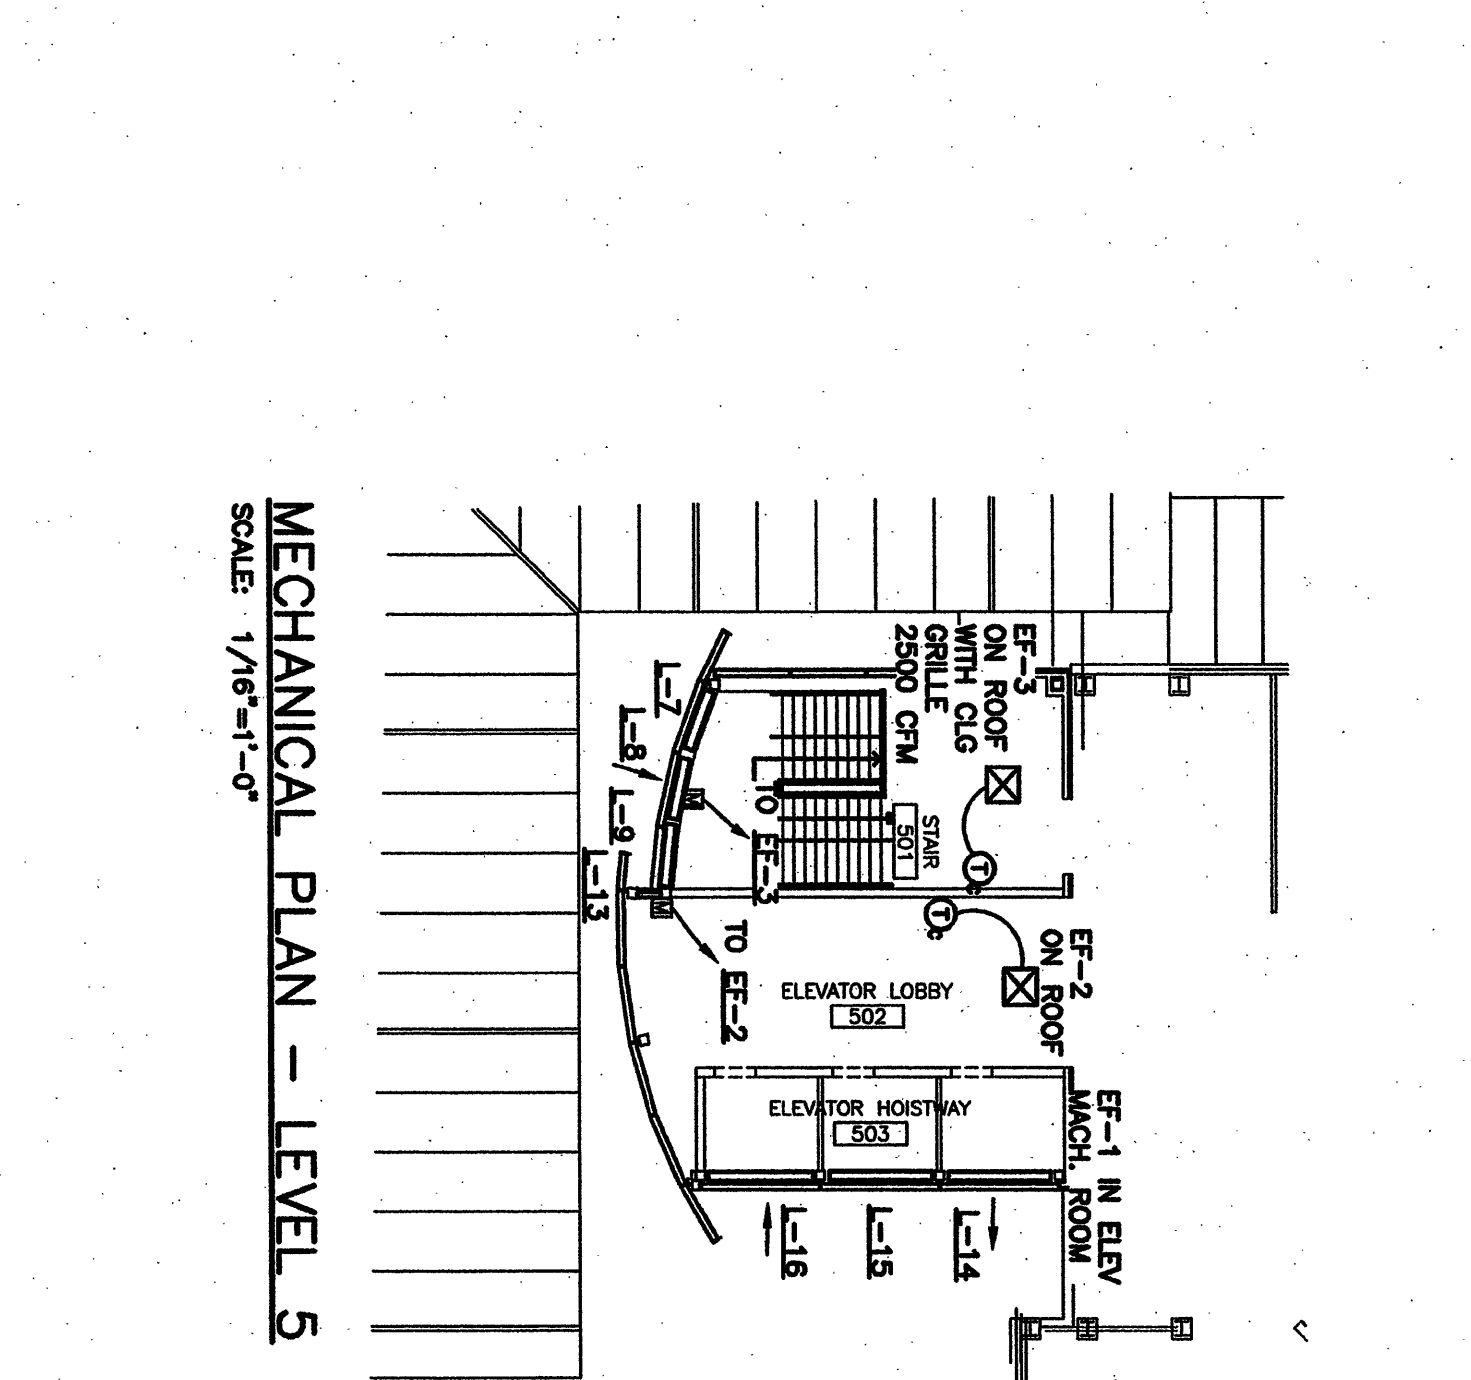
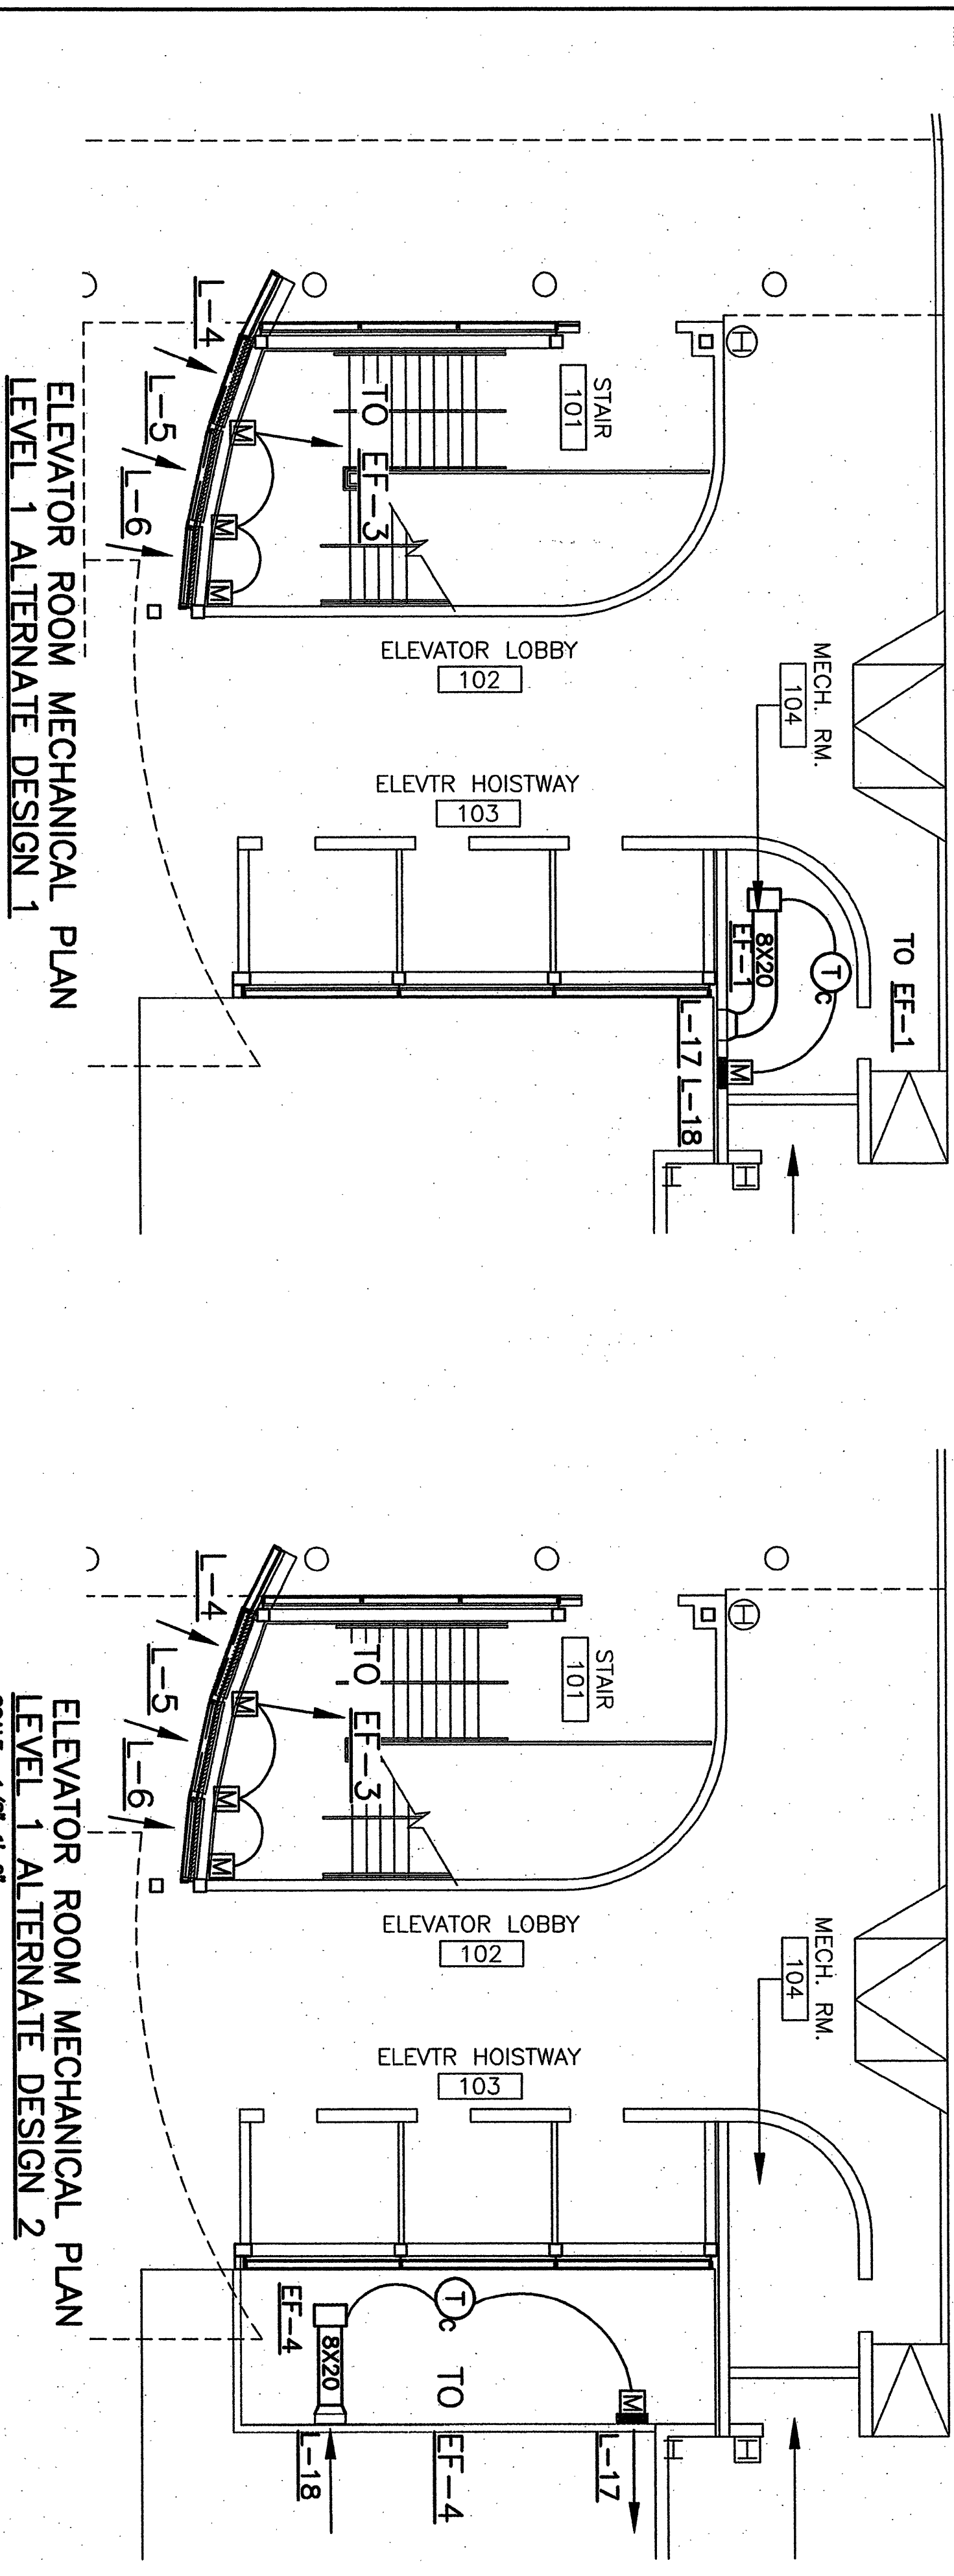


1/16"=1' 5 0 10 20 30 40ft 1/8"=1' 5 0 5 10 15 20ft 1/4"=1' 2 0 2 4 6 8 10ft 1/2"=1' 0 1 2 3 4 5ft 3/4"=1' 0 1 2 3ft 1"=1' 0 1 2ft 1 1/2"=1' 0 1 2ft 3"=1' 0 1ft

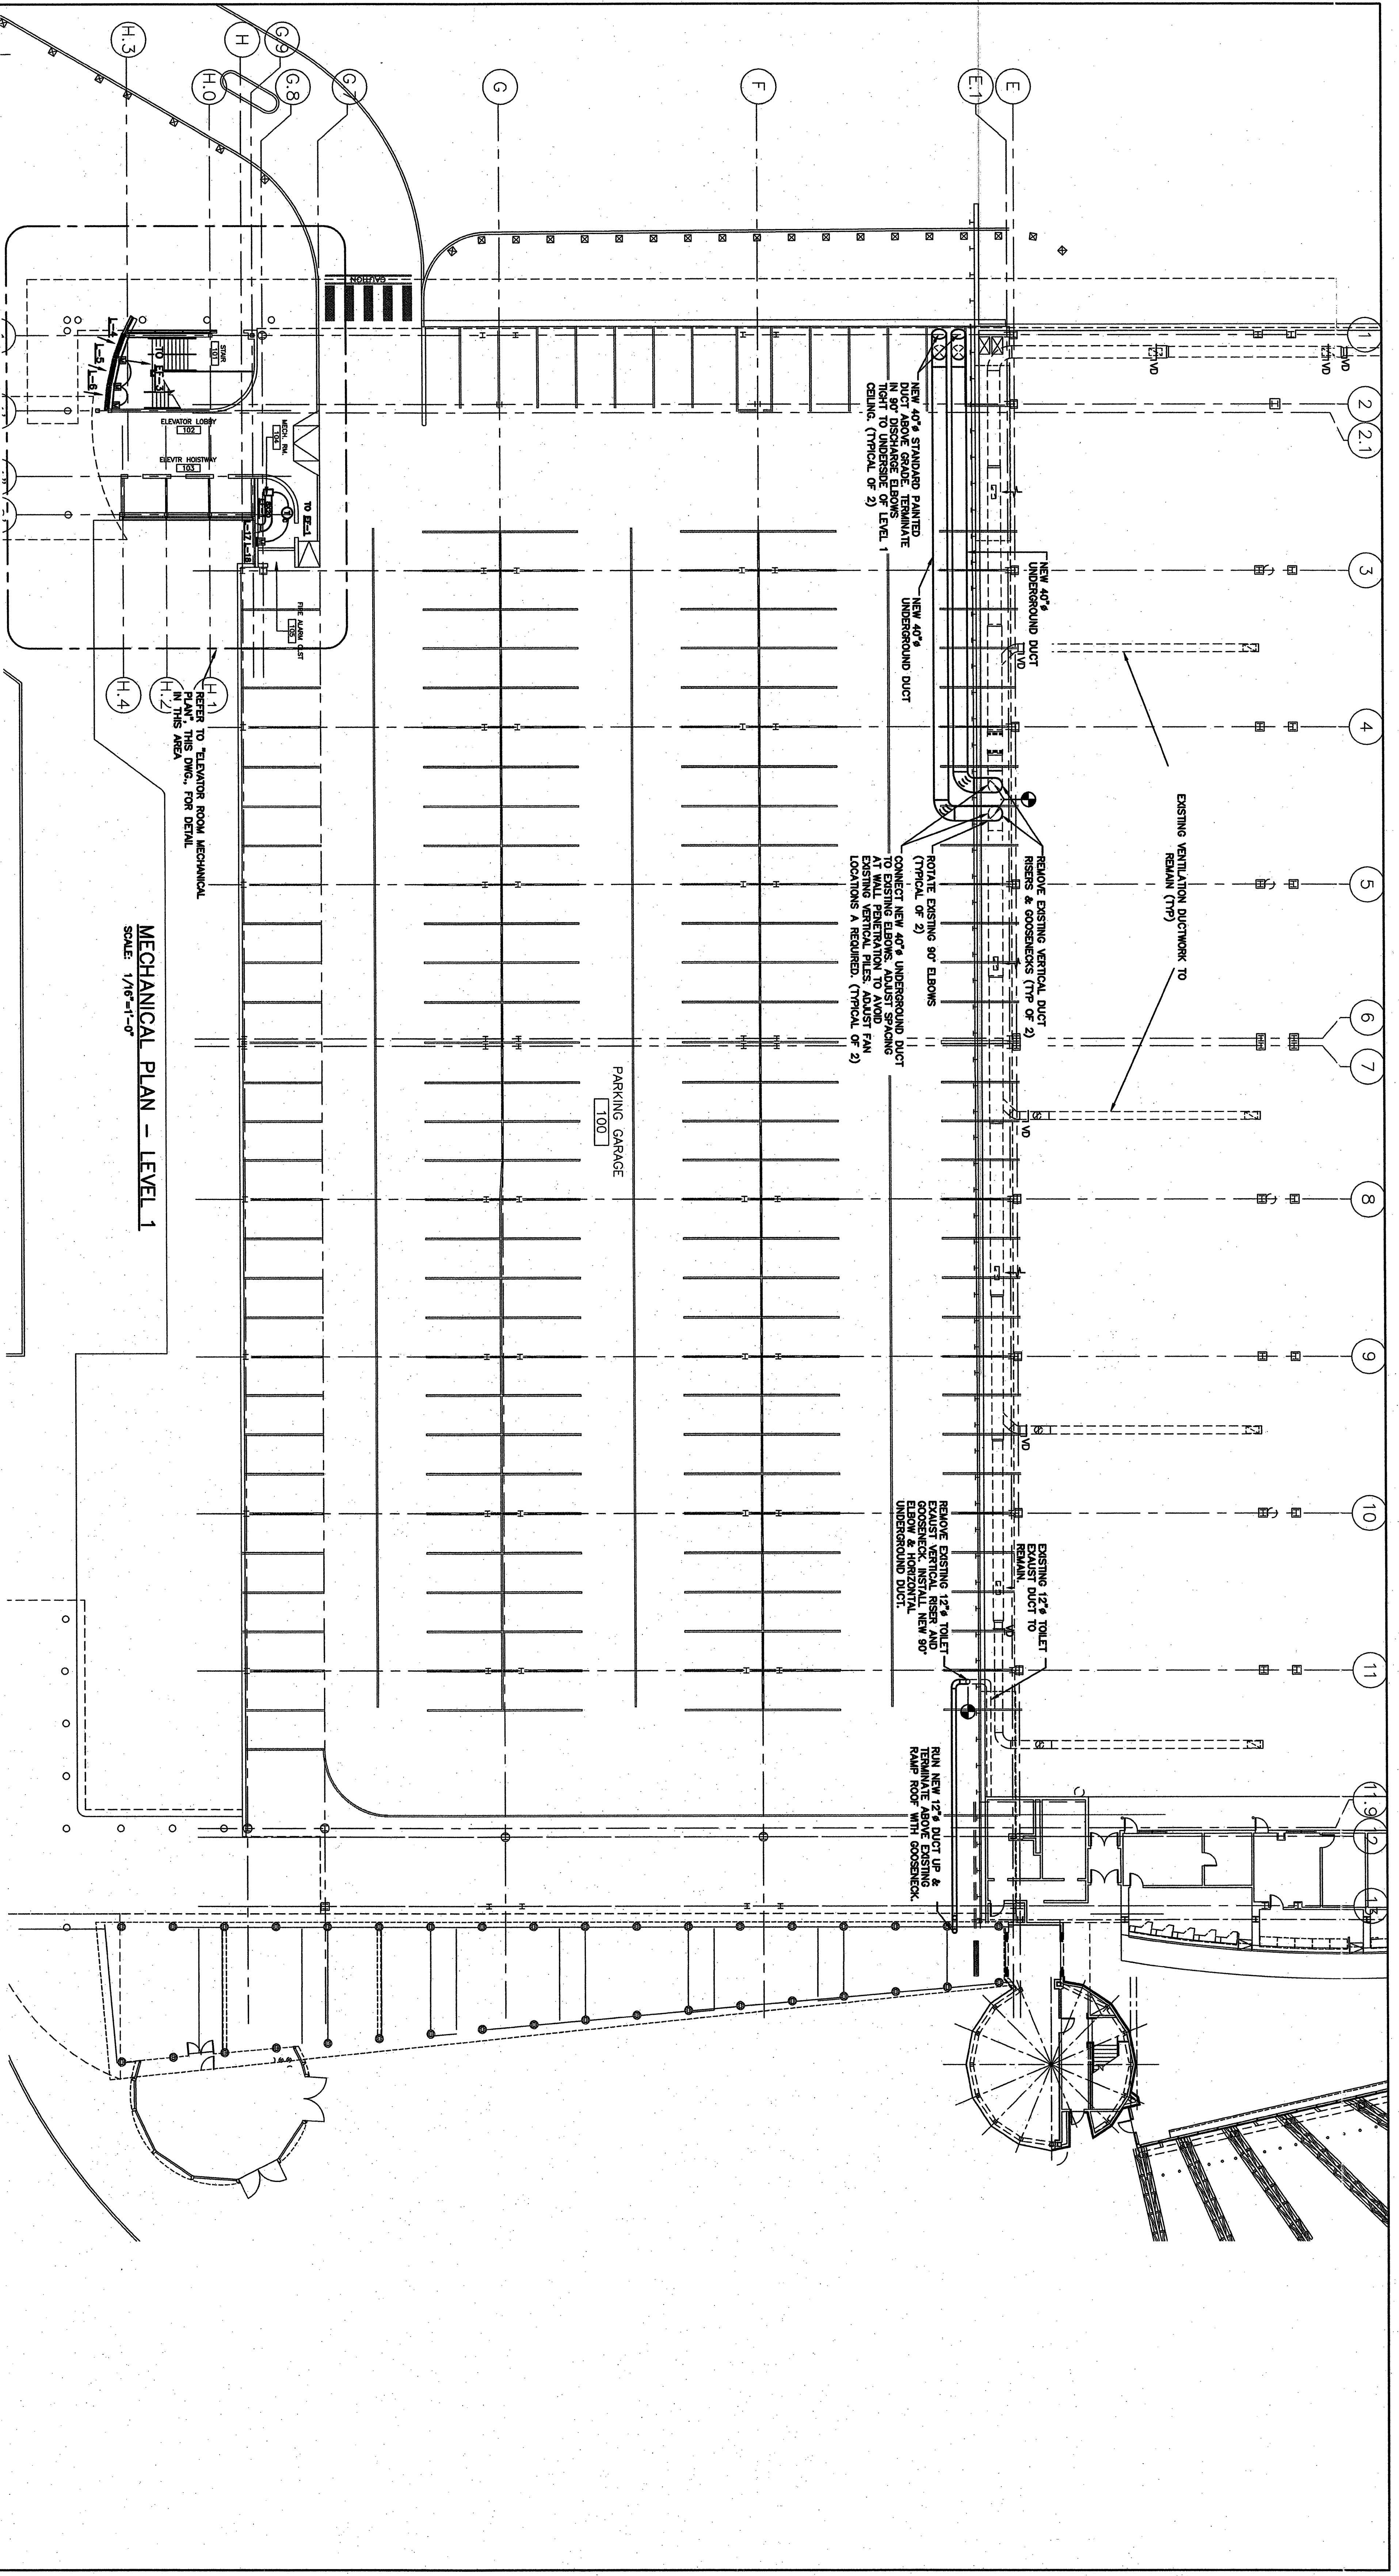

If this sheet is less than 30"x42" in size, it has been reduced. Graphic scales must be adjusted accordingly.

DOMENECH HICKS & KROCKMANN ARCHITECTS
 155 Massachusetts Ave., Boston, MA 02115
 617-267-6408
 Fax 617-267-1890

Santec
 Santec Consulting Services Inc.
 22 Free Street, Suite 205
 Portland, ME USA
 Tel. 207-775-3211
 Fax. 207-775-6434
 www.santec.com

CONFORMED SET
 FOR FIELD USE

PMI
 PORTLAND INTERNATIONAL JETPORT
 PHASE II
 PARKING GARAGE
 1001 WESTBROOK ST., PORTLAND, MAINE

LEVELS - 1, 2 & 5
 MECHANICAL PLAN

M1-1