




CU-2 (TEL/COMM ROOM EXISTING PHASE 1 GARAGE), MITSUBISHI ELECTRIC
SPUT SYSTEM INSIDE UNIT HORIGT 6500 BTU/H COOLING 115V/1/60
AC-2 (TEL/COMM ROOM EXISTING PHASE 1 GARAGE), OUTDOOR UNIT
MOOREY 115V/1/60 PRE SIZE 1/4" LIQUID 3/8" GAS

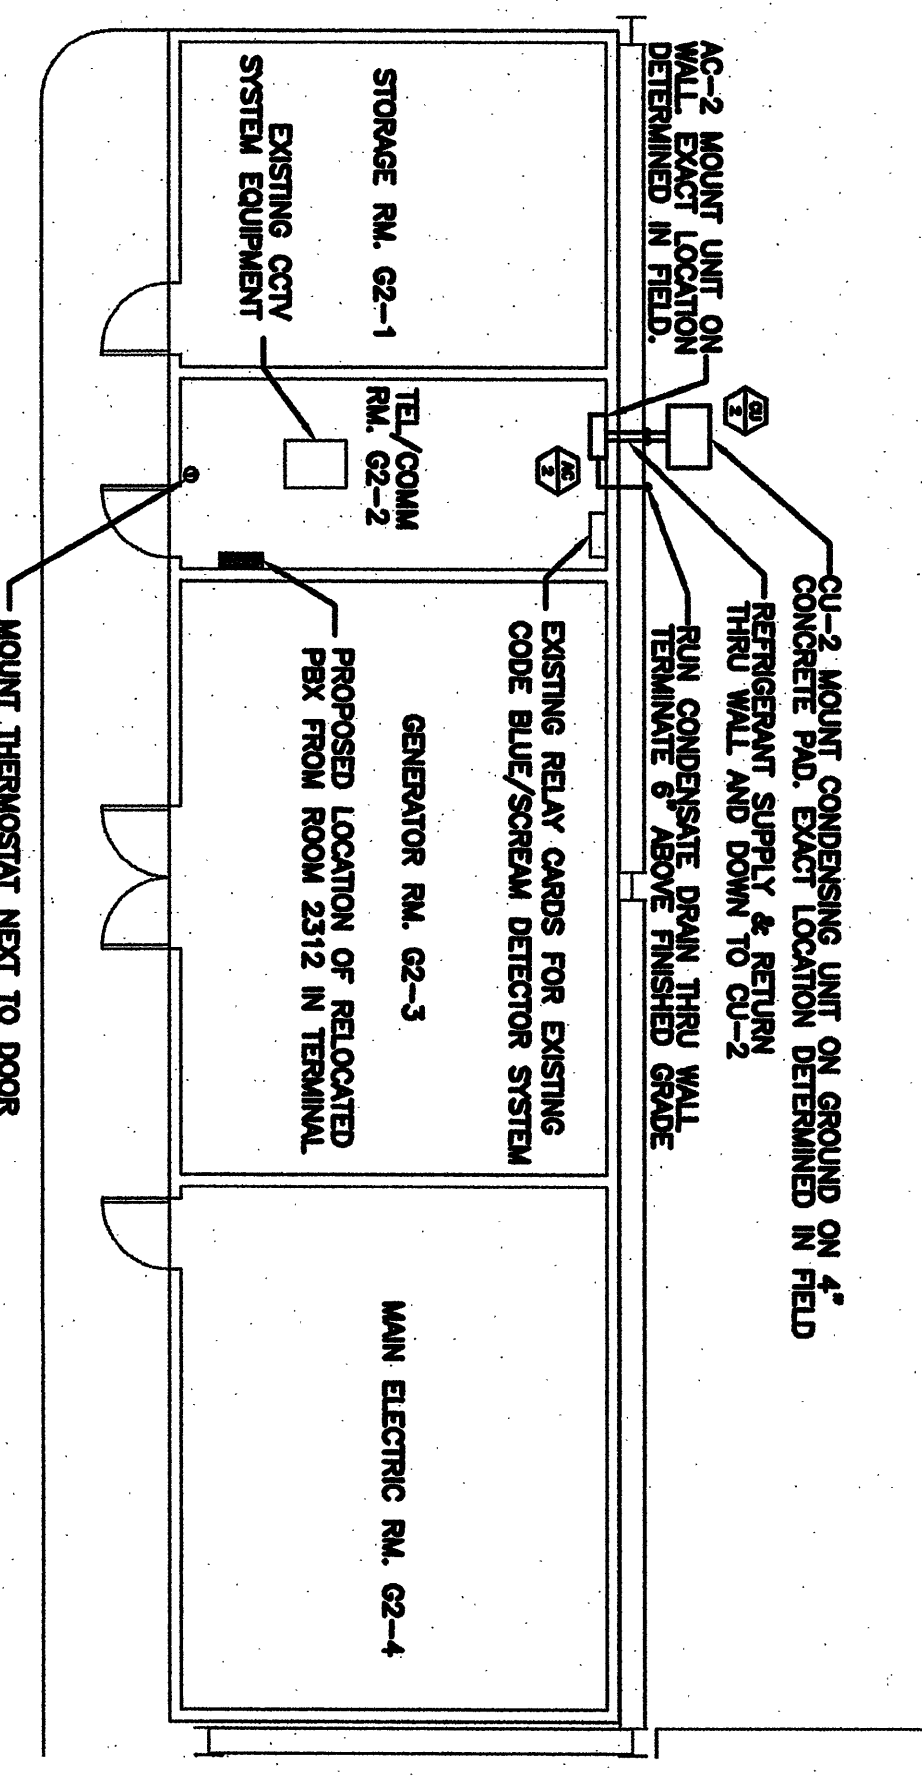


MECHANICAL PLAN - EXISTING TEL/COMM ROOM #207 UPPER LEVEL OF TERMINAL
SCALE: 1/8"=1'-0"

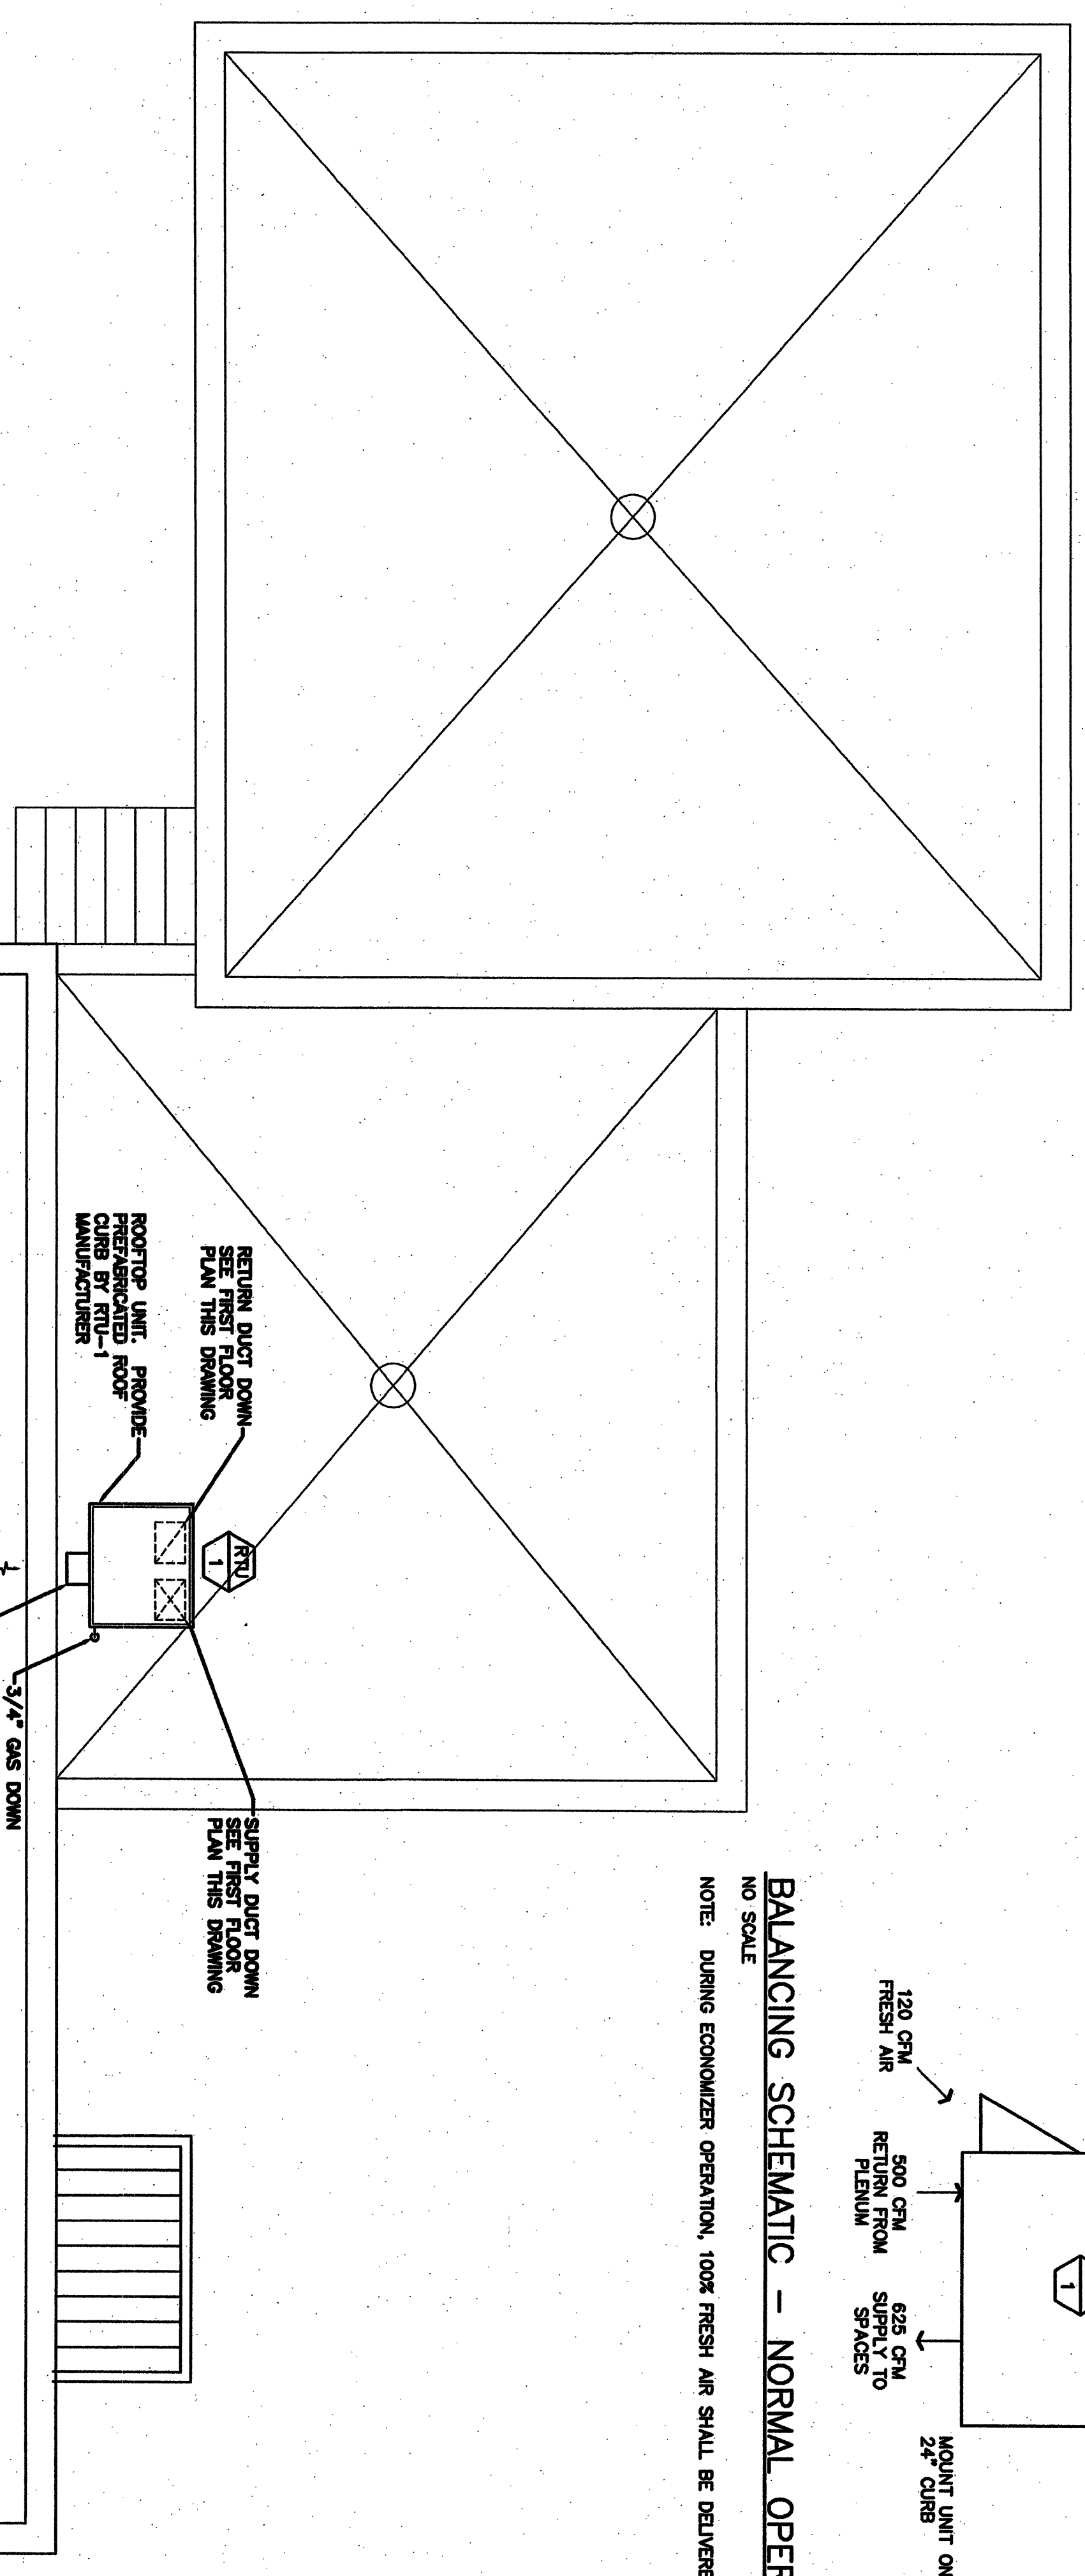

BALANCING SCHEMATIC - NORMAL OPERATION
NOTE: DURING ECONOMIZER OPERATION, 100% FRESH AIR SHALL BE DELIVERED TO SPACES.

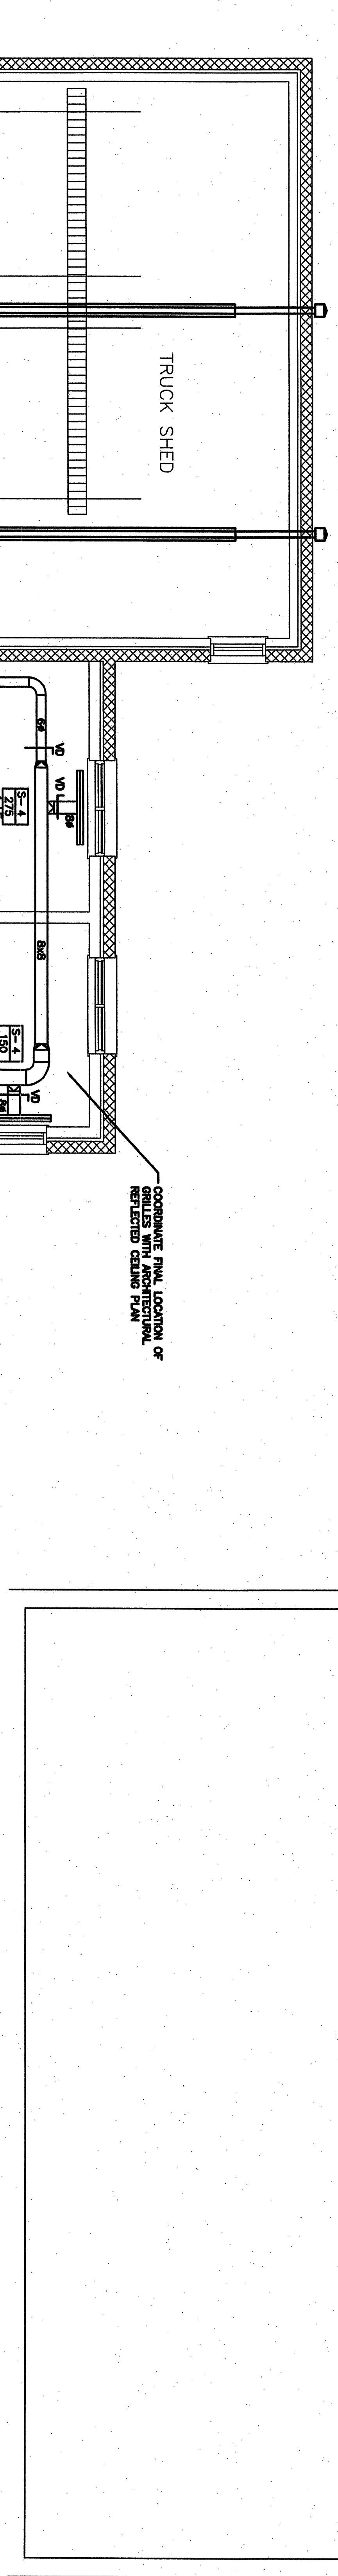

MECHANICAL PLAN - OPERATORS BLDG FLOOR
SCALE: 1/4"=1'-0"

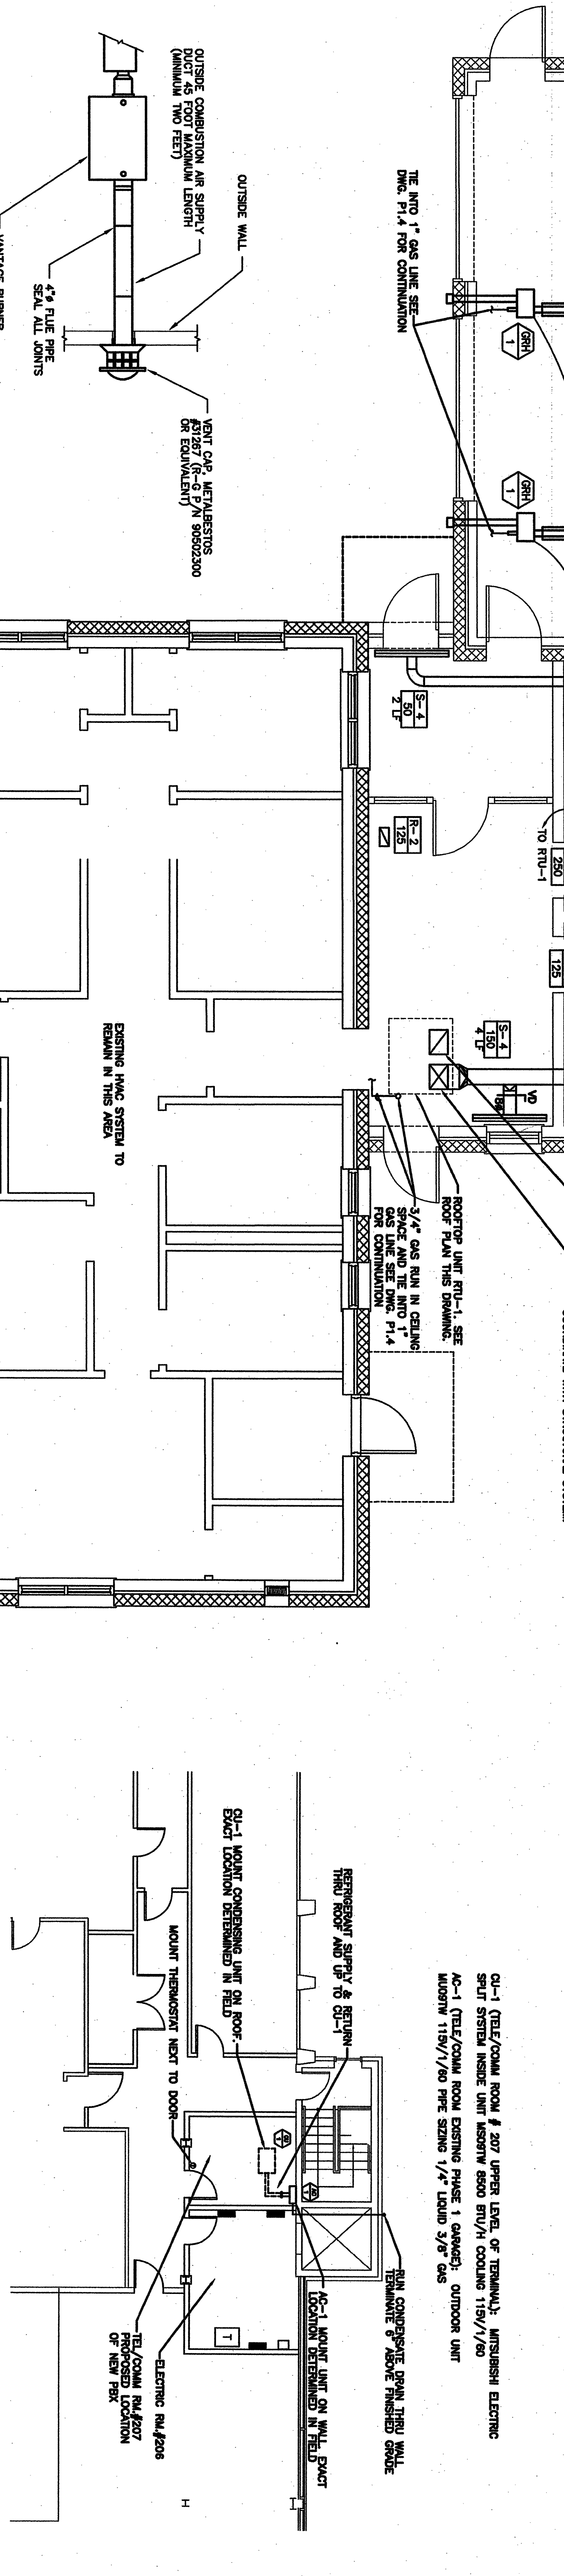


MECHANICAL PLAN - EXISTING TEL/COMM ROOM IN EXISTING PHASE 1 GARAGE
SCALE: 1/8"=1'-0"


IRH HORIZONTAL COMBUSTION AIR DETAIL
NO SCALE

MECHANICAL PLAN - OPERATORS BLDG FLOOR
SCALE: 1/4"=1'-0"

If this sheet is less than 30"x42" in size, it has been reduced. Graphic scales must be adjusted accordingly.

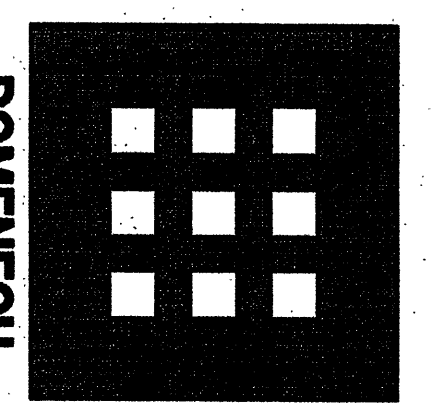

**DOMENECH
HICKS &
KROCKMALNIC
ARCHITECTS**
155 Massachusetts Ave.
Boston, MA 02115
617-267-4408
Fax 617-267-1990

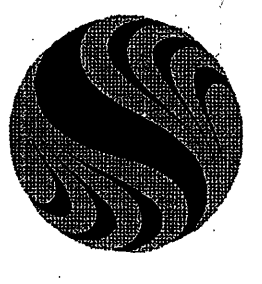

Stantec
Stantec Consulting Services Inc.
225 State Street, Suite 200
Portland, ME U.S.A.
04101-3900
Tel. 207.775.3211
Fax 207.775.6434
www.stantec.com

CONFORMED SET
FOR FIELD USE



**PORTLAND
INTERNATIONAL
JETPORT**

PHASE II
PARKING GARAGE
1001 WESTBROOK ST.,
PORTLAND, MAINE

OPERATORS BUILDING
MECHANICAL PLAN



M1-2