

MECHANICAL SYSTEMS ENGINEERS
 10 FOREST HILLS DRIVE
 YAKIMOUTH, MAINE 04096
 PHONE: (207) 848-1441
 FAX: (207) 848-1443
 mechsys@maine.rr.com



| NO. | DATE | DESCRIPTION | BY | CHKD | APP'D |
|-----|--------------|--------------------|----|------|-------|
| 1 | 4/22/04 | CONFORMED DRAWINGS | PO | HP | HP |
| 2 | 3/23/04 | ADDENDUM NO. 2 | PO | HP | HP |
| 1 | 3/10/04 | ADDENDUM NO. 1 | PO | HP | HP |
| | FEB 26, 2004 | BD SUBMITTAL | PO | HP | HP |

PDA Architects
 362 U.S. Route One, Falmouth, Maine 04105 • 201.781.8346
 Phillip J. Doughty Assoc. • Architects

MECHANICAL - WEST PENTHOUSE FLOOR PLAN

APPROVED: _____
 CHECKED: HLP
 DRAWN: PO
 DESIGNED: PO
 DATE: FEB 26, 2004
 SCALE: AS NOTED

PROJ: SHEET NO. **M14**

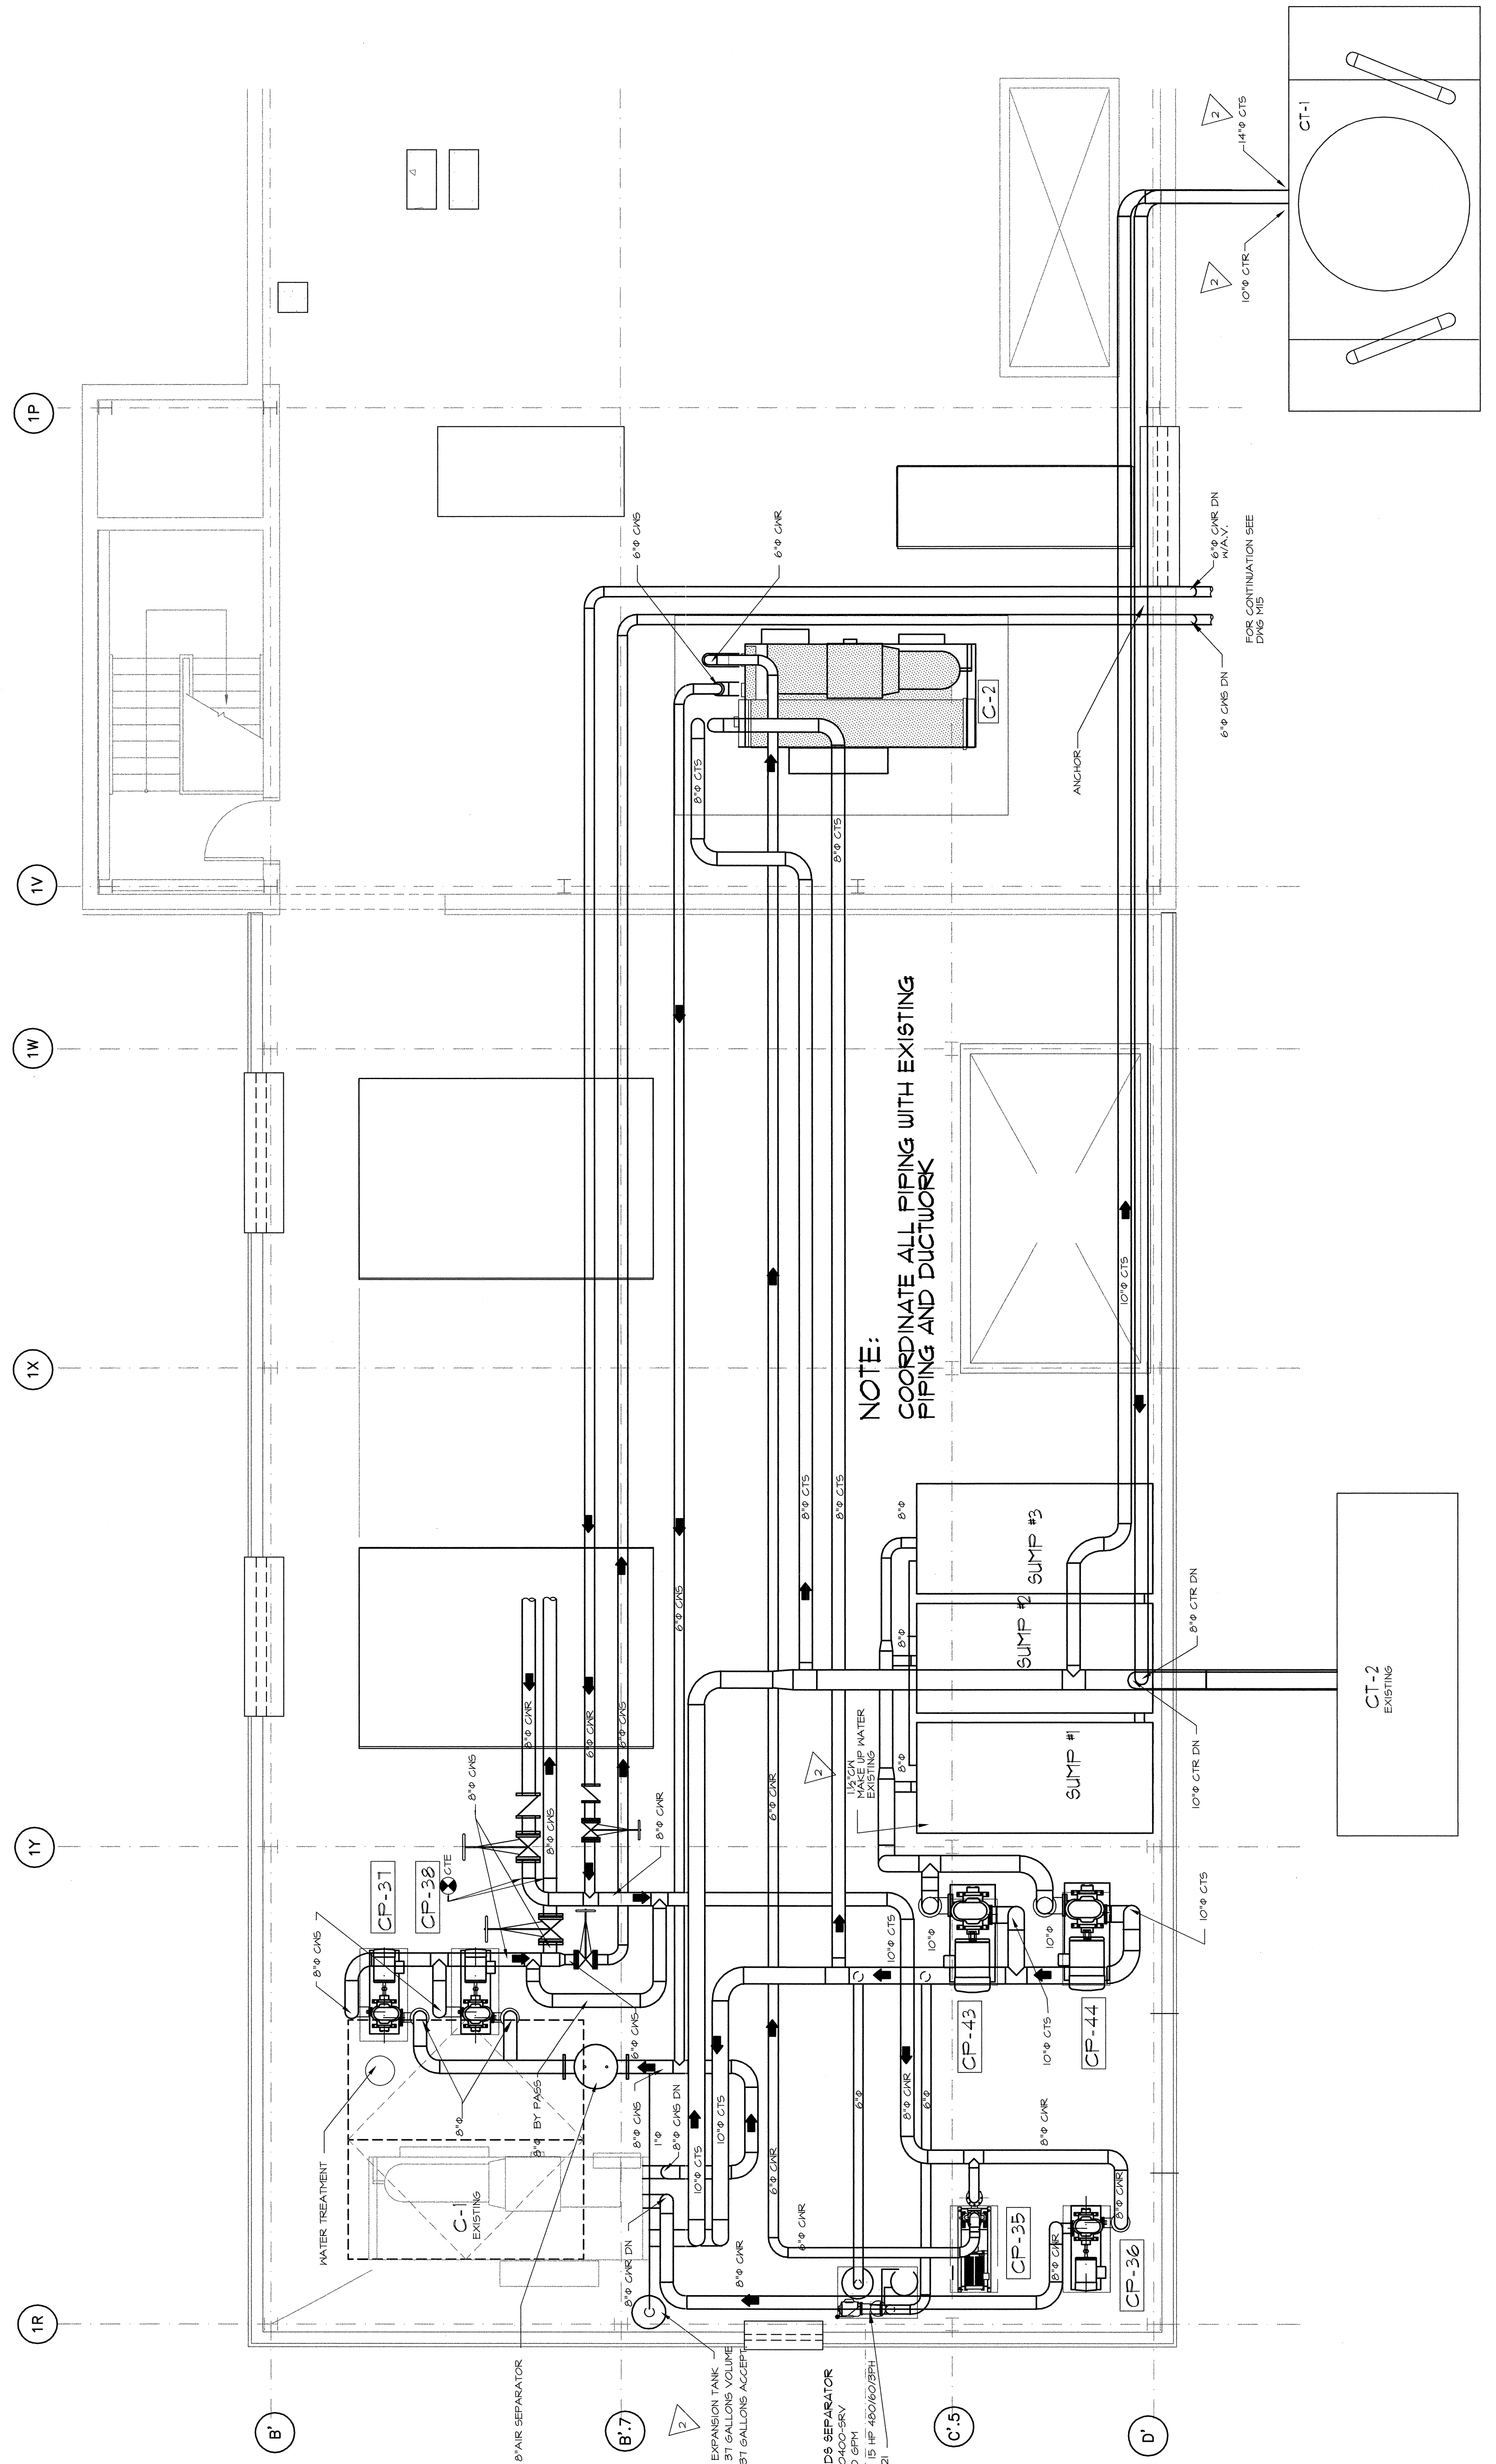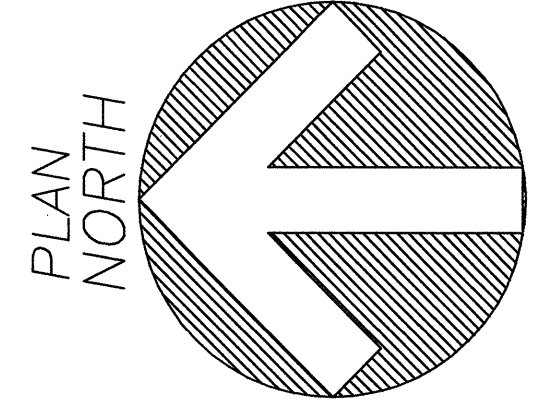

MECHANICAL - WEST PENTHOUSE FLOOR PLAN
 SCALE: 1/4" = 1'-0"

THIS DRAWING IS THE PROPERTY OF PDA ARCHITECTS AND IS NOT TO BE REPRODUCED, COPIED, OR TRANSMITTED IN ANY FORM OR BY ANY MEANS, ELECTRONIC OR MECHANICAL, WITHOUT THE WRITTEN PERMISSION OF PDA ARCHITECTS. ANY UNAUTHORIZED USE OF THIS DRAWING WILL BE AT THE USER'S SOLE RISK AND WITHOUT LIABILITY TO PDA ARCHITECTS. ARCHITECTS ON COMPLETION OF WORK, IF REQUESTED.