


TUNNEL PLUMBING PLAN
SCALE: 1/8" = 1'-0"


SCALE: AS NOTED
DATE: FEB. 29, 2004
DESIGNED: E.J.P.
DRAWN: E.J.P.
CHECKED: H.L.P.
APPROVED: PDA

ADDITIONS AND ALTERATIONS
EASTERLY EXPANSION OF BAGGAGE CLAIM FACILITY
PORTLAND INTERNATIONAL AIRPORT, PORTLAND, MAINE
PHILLIP J. DOUGHTY ASSOC., ARCHITECTS
362 U.S. ROUTE ONE, FALMOUTH, MAINE 04105 • 207.781.8346

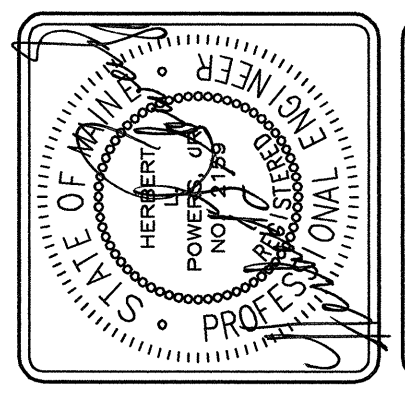

REVIS	N	DESCRIPTION	DATE
0	1	CONFERRED DRAWINGS	4/22/04
1	1	ADDITION NO. 2	3/10/04
2	1	ADDITION NO. 1	3/10/04
3	1	BID SUBMITTAL	FEB. 29, 2004

MECHANICAL SYSTEMS ENGINEERS
100 FOREST FALLS DRIVE
PORTLAND, MAINE 04106
TEL: (207) 846-1441
FAX: (207) 846-1443
msherry@maine-me.com

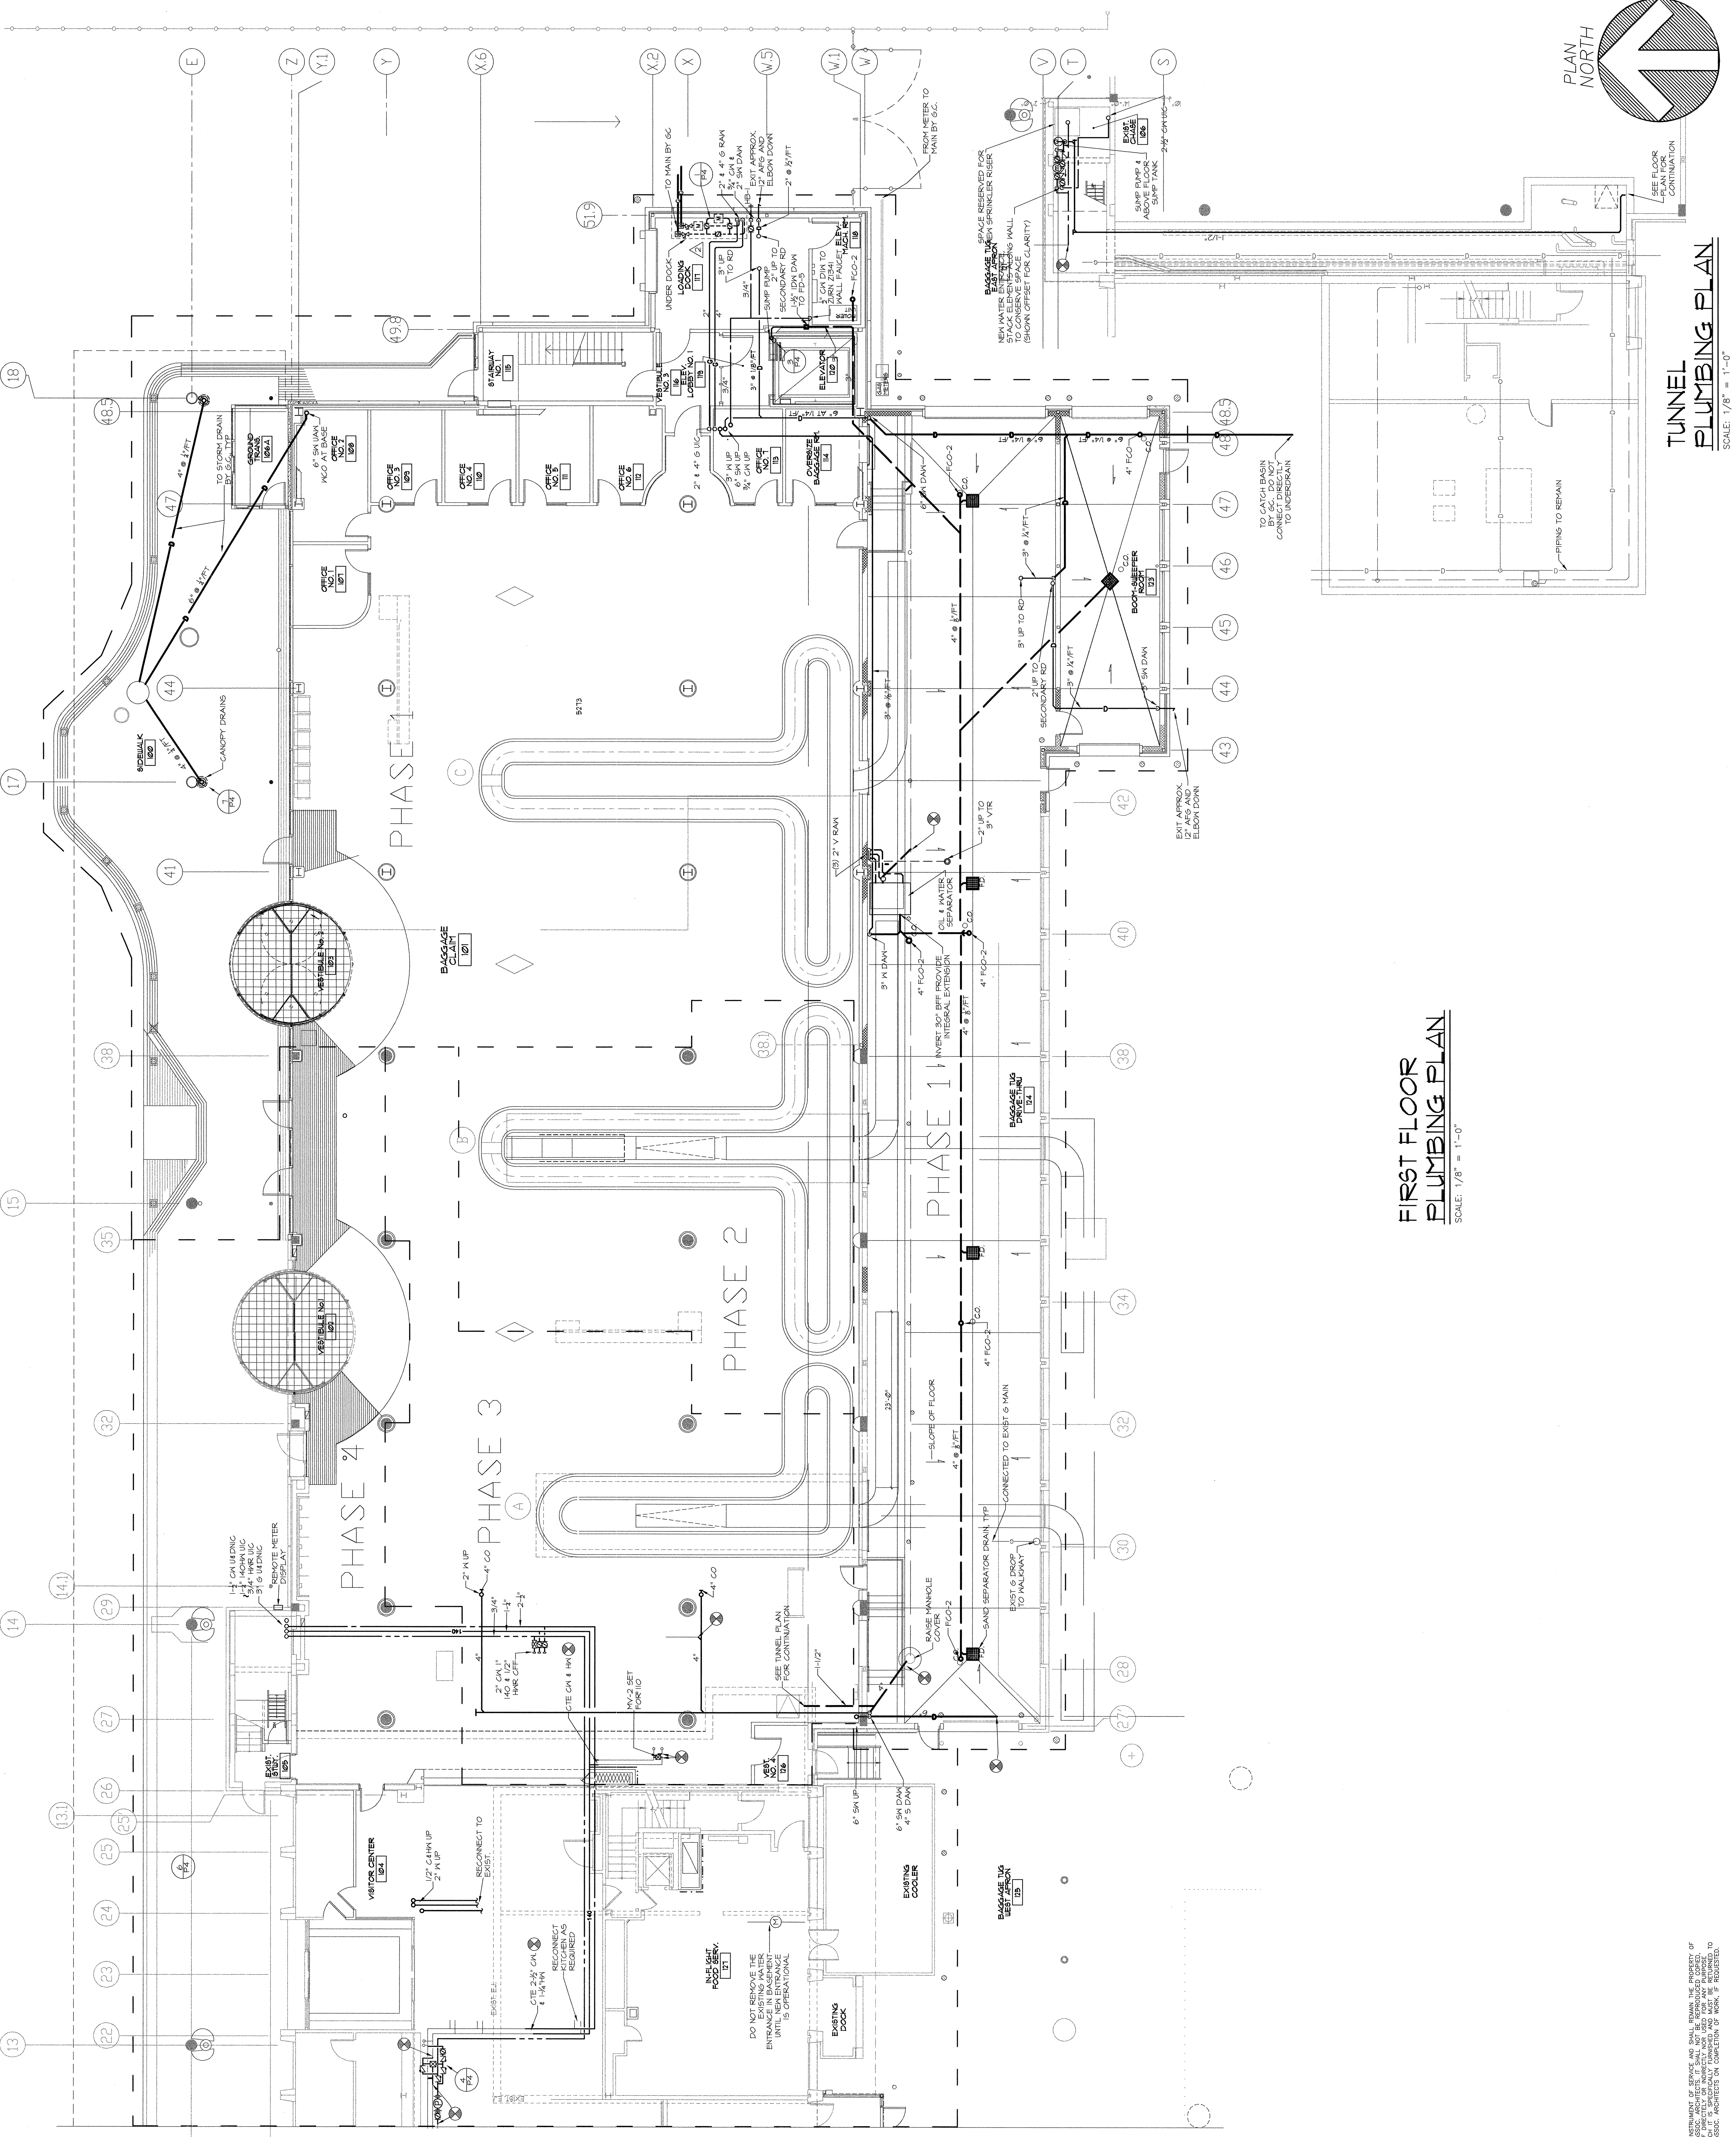

FIRST FLOOR PLUMBING PLAN
SCALE: 1/8" = 1'-0"

THIS DRAWING IS AN INSTRUMENT OF SERVICE AND SHALL REMAIN THE PROPERTY OF PHILLIP J. DOUGHTY ASSOCIATES, ARCHITECTS. IT IS TO BE USED ONLY FOR THE PROJECT AND SITE SPECIFICALLY IDENTIFIED HEREON. ANY REUSE, REPRODUCTION, OR ALTERATION OF THIS DRAWING WITHOUT THE WRITTEN PERMISSION OF PHILLIP J. DOUGHTY ASSOCIATES, ARCHITECTS IS PROHIBITED.