




5 TYPICAL CHASE DETAIL
SCALE 1 1/2"=1'-0"

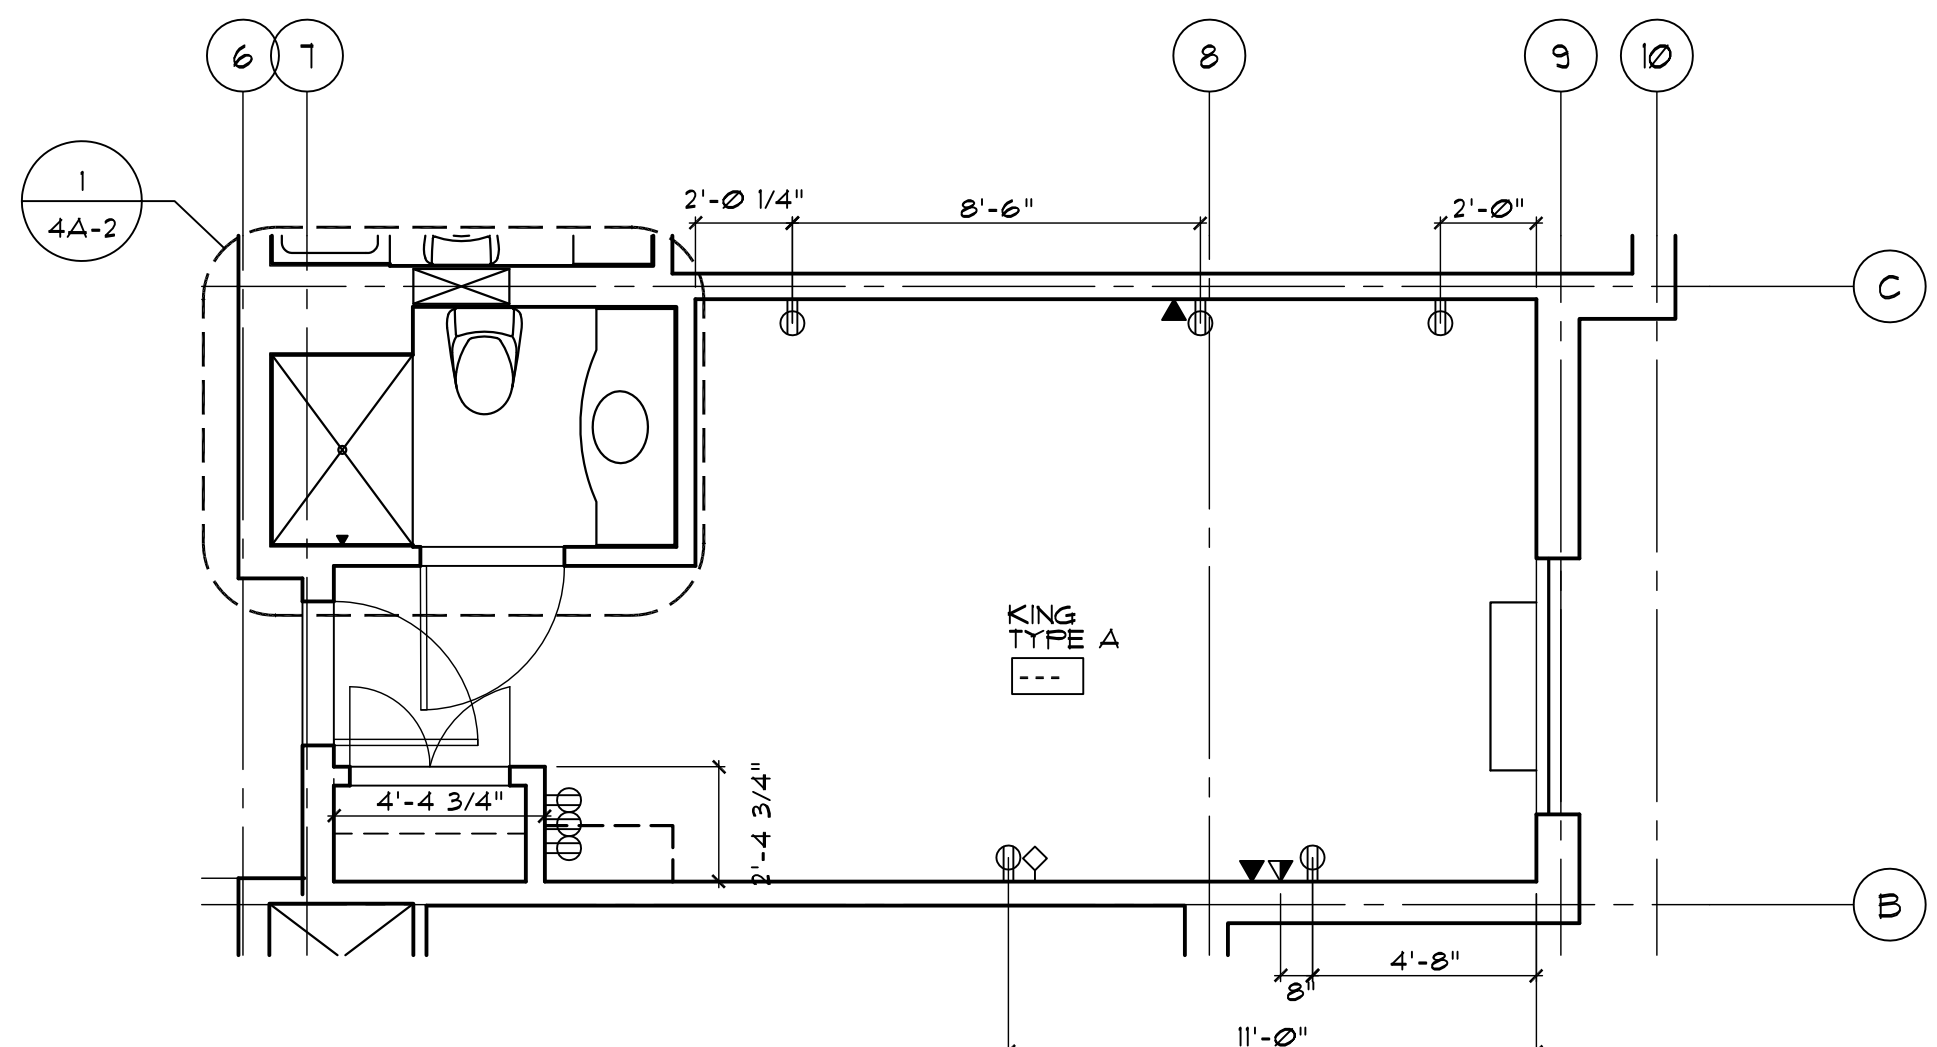


1 TYPE A KING ROOM ELECTRICAL LAYOUT
SCALE 1/4"=1'-0"

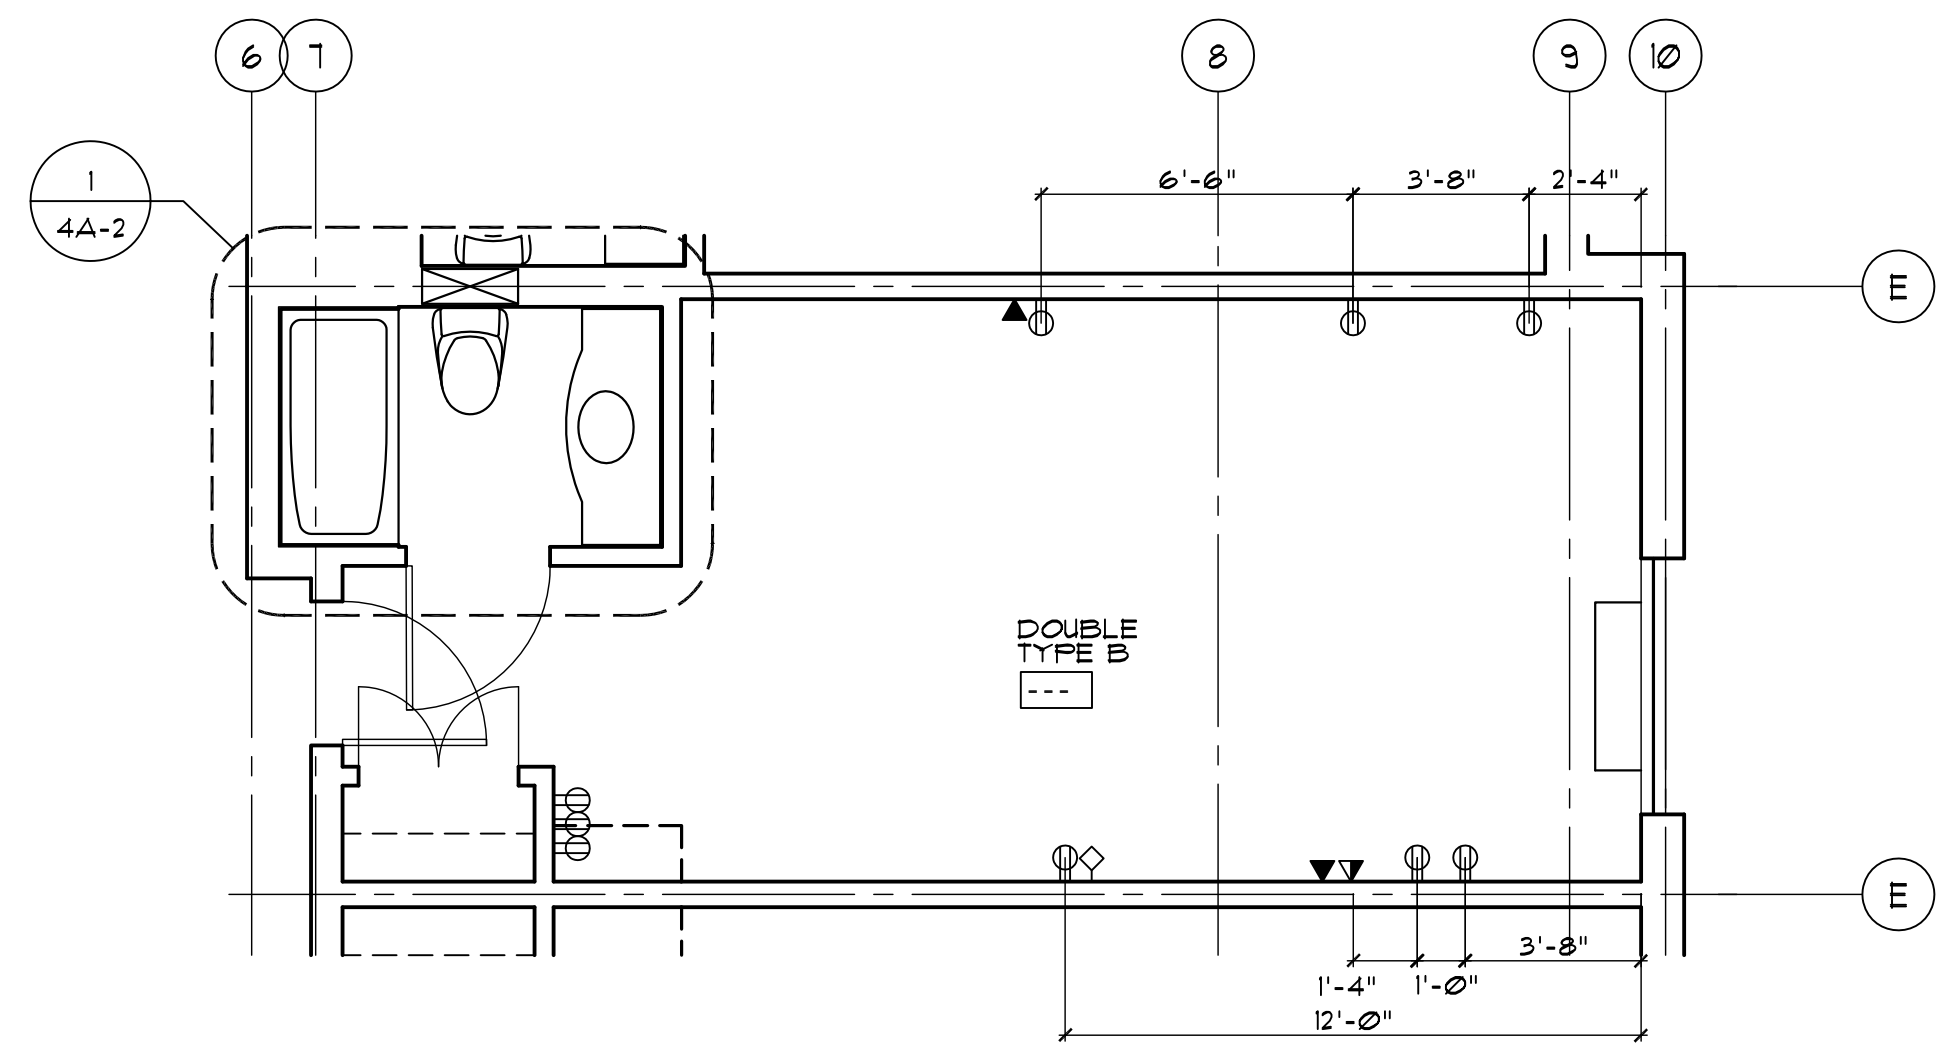

2 TYPE B DOUBLE ROOM ELECTRICAL LAYOUT
SCALE 1/4"=1'-0"

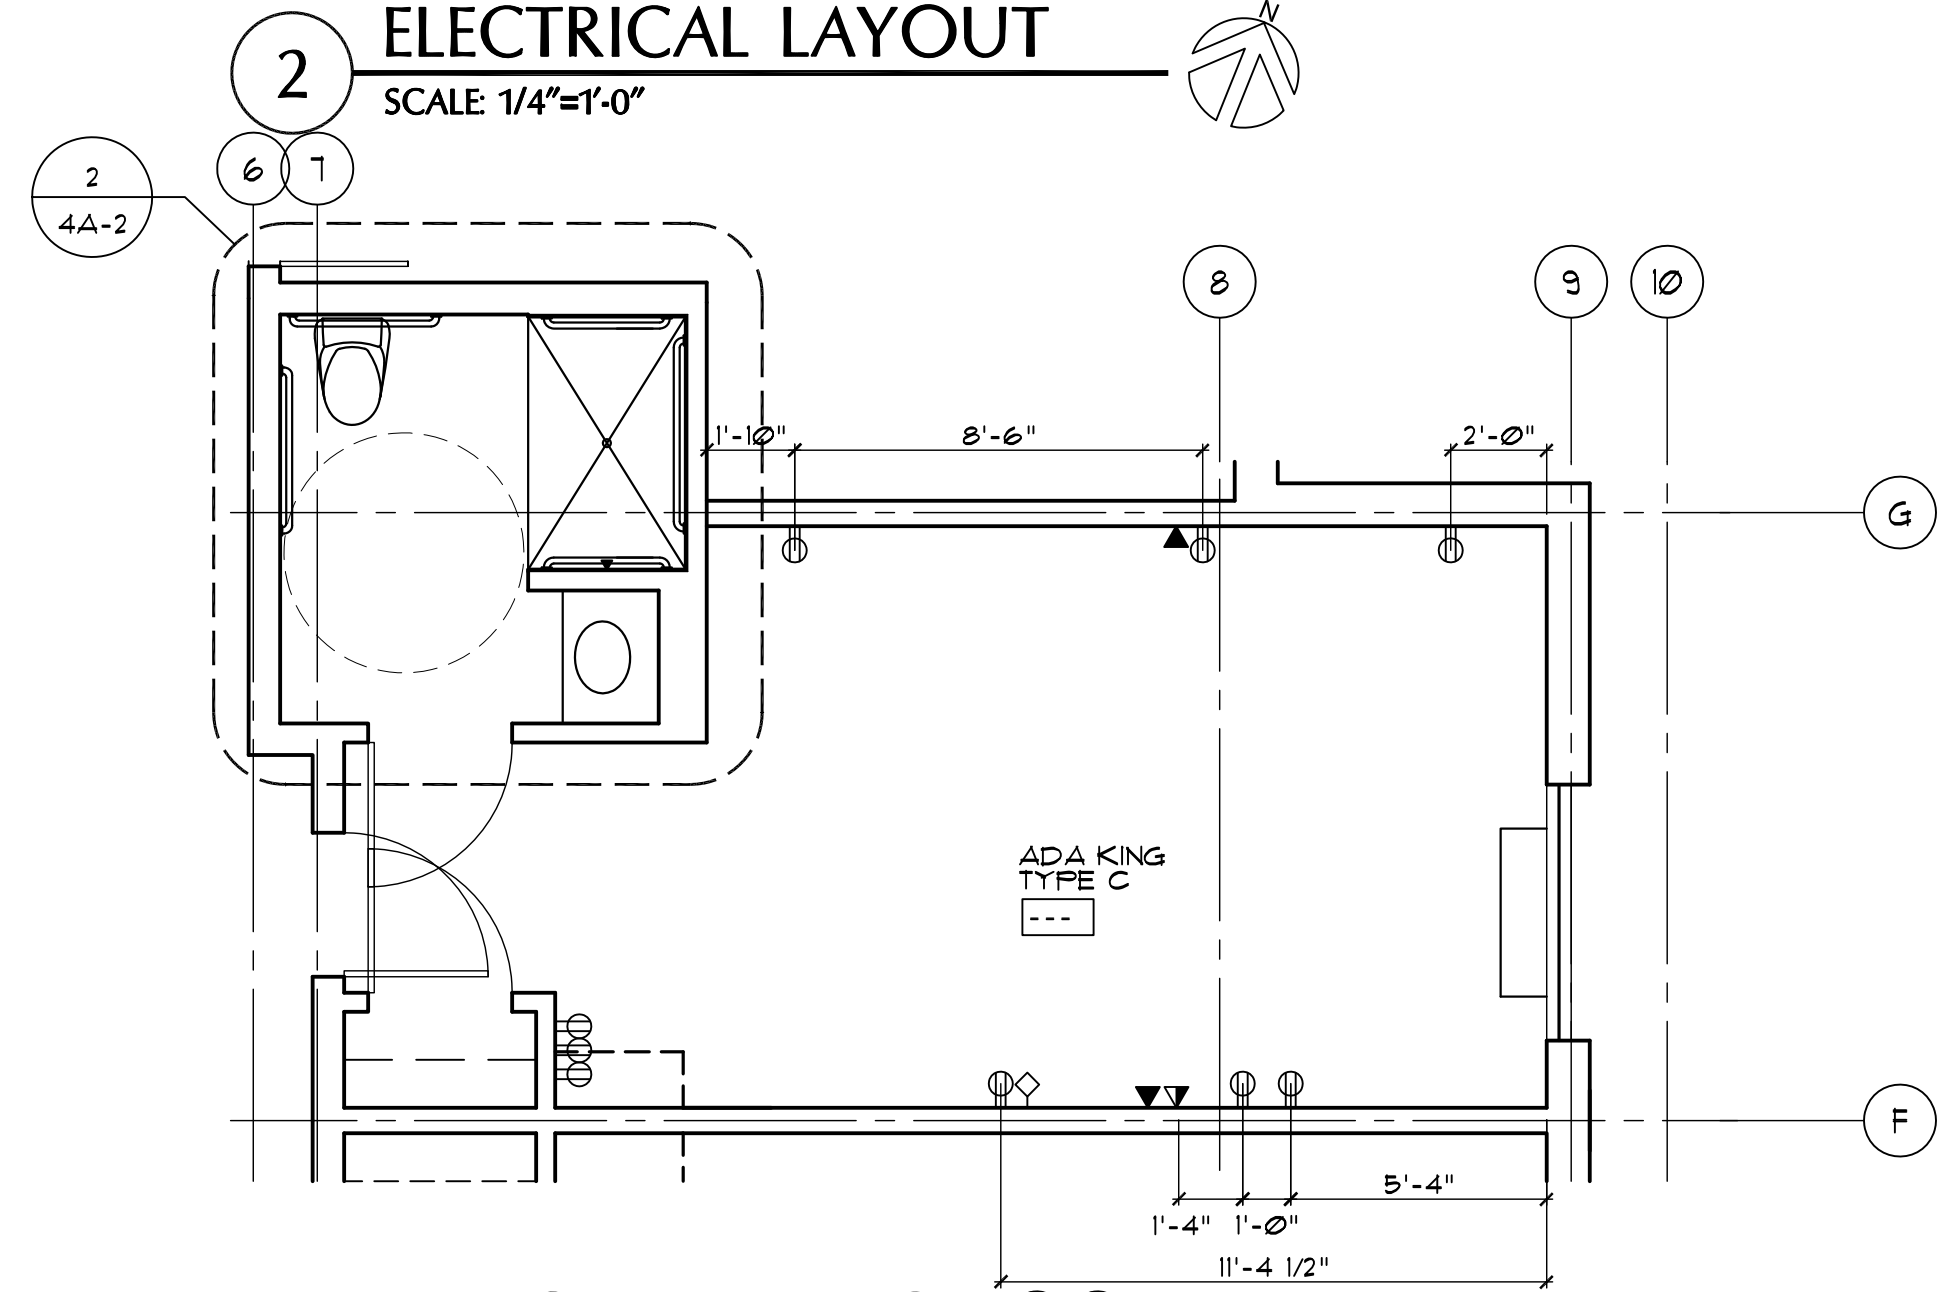

3 TYPE C ADA KING ROOM ELECTRICAL LAYOUT
SCALE 1/4"=1'-0"

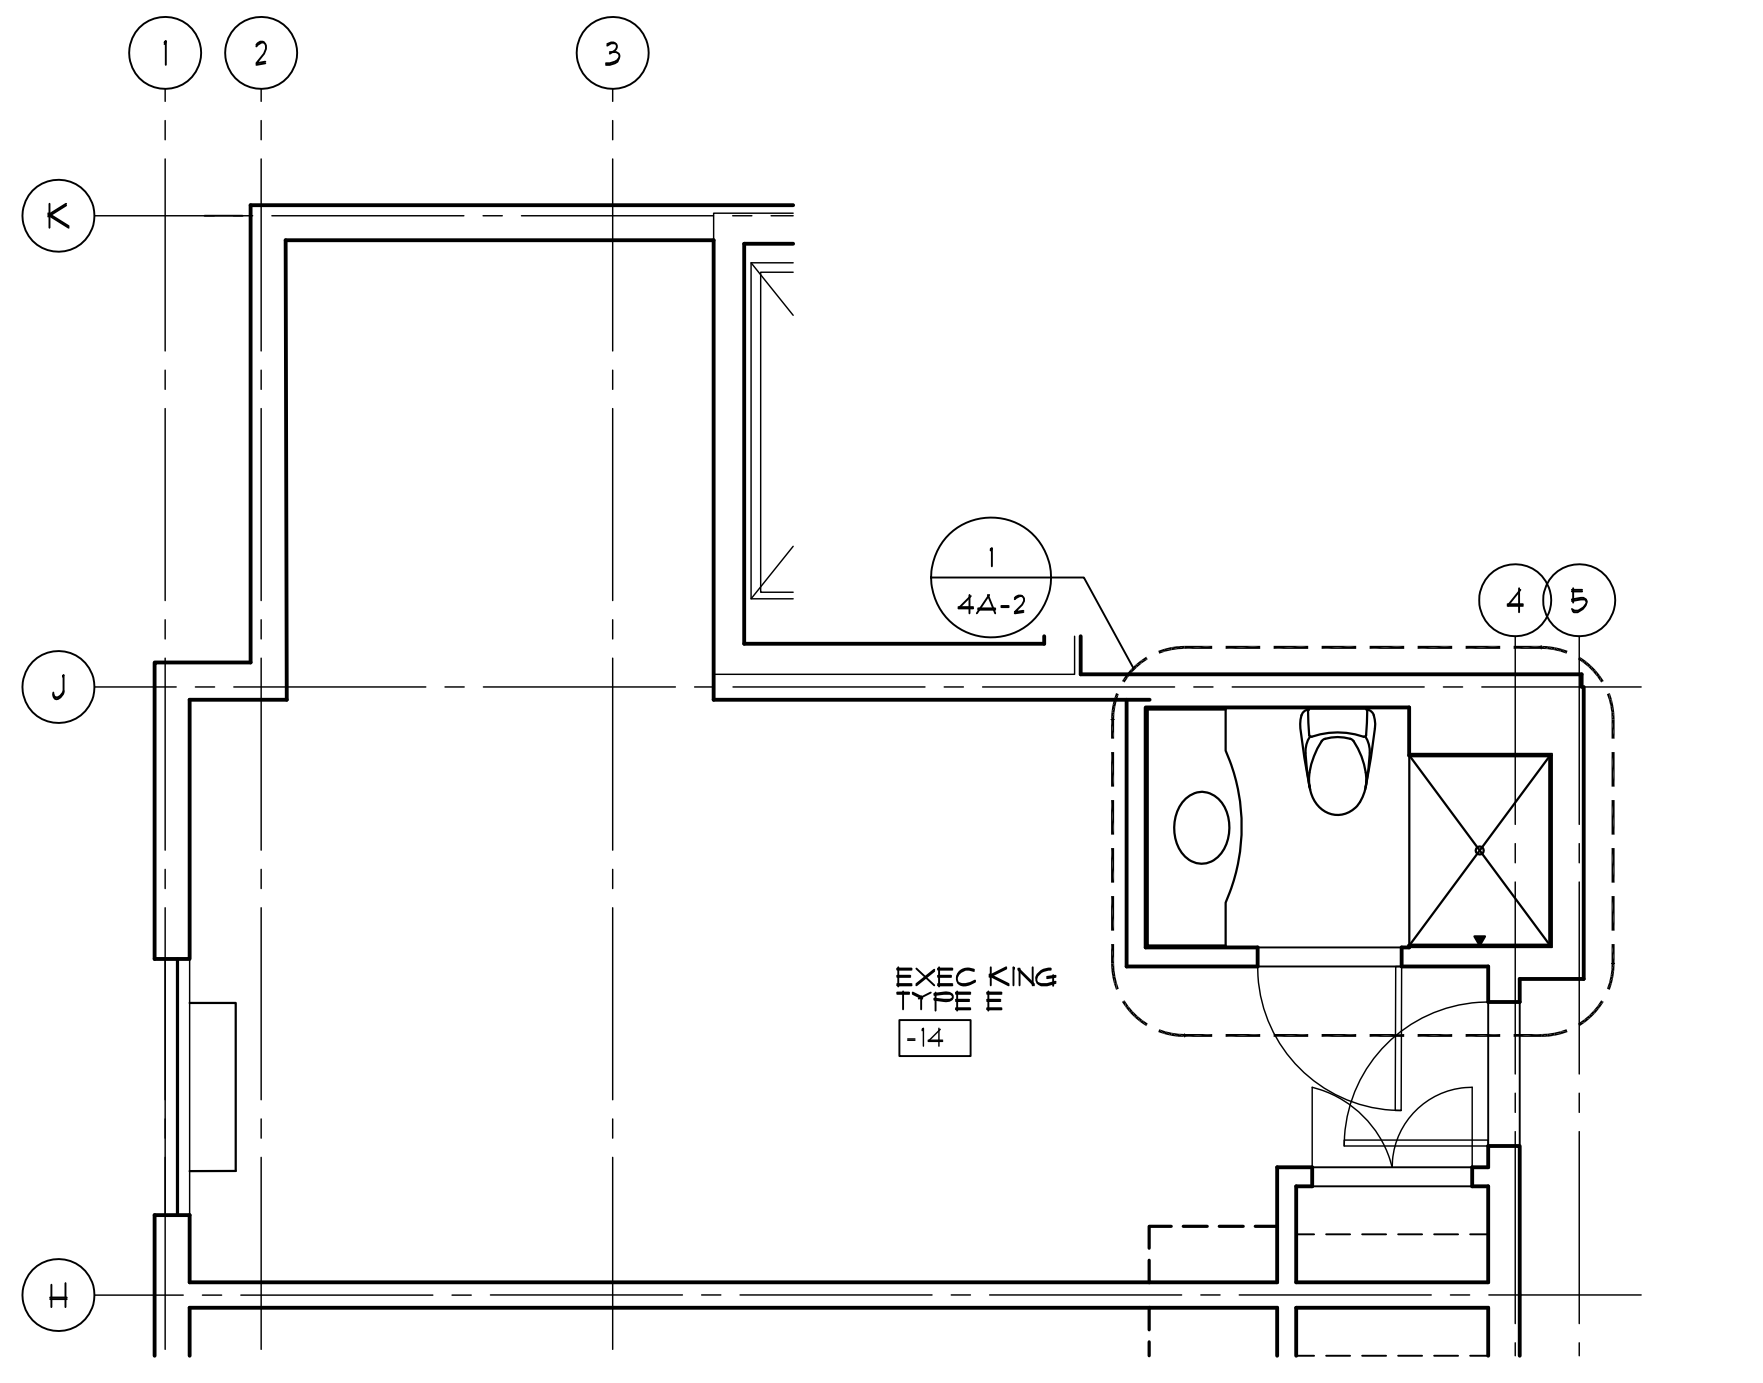

4 TYPE E EXEC KING ROOM ELECTRICAL LAYOUT
SCALE 1/4"=1'-0"

PROJECT
PORTLAND HILTON GARDEN INN ADDITION

LOCATION
PORTLAND
145 JETPORT BLVD
PORTLAND, MAINE 04102

ARCHITECT
hc
hogan campis architecture
1425 DUTCH VALLEY PL. STUDIO B ATLANTA GA 30324
404 685 8868 V. 404 685 8878 F. WWW.HCARCH.NET

LICENSED ARCHITECT
THOMAS J. HOGAN JR.
ARC 3864
STATE OF MAINE

STAMP

ISSUED FOR: _____ DATE: _____

REVIEW _____

PRICING JULY 20, 2012

PERMITTING JAN. 30, 2013

CONSTRUCTION _____

REVISIONS

THIS DRAWING IS THE PROPERTY OF HC ARCHITECTURE, INC. AND IS NOT TO BE REPRODUCED OR COPIED IN WHOLE OR IN PART. IT IS ONLY TO BE USED FOR THE PROJECT SPECIFICALLY IDENTIFIED HEREIN AND IS NOT TO BE USED ON ANY OTHER PROJECT. IT IS TO BE RETURNED UPON REQUEST. SCALES AS STATED HEREIN ARE VALID ON THE ORIGINAL DRAWING. THE DIMENSIONS OF WHICH ARE 30x42 INCHES.

JOB NO.
0479.000

DRAWING TITLE
GUESTROOM ELECTRICAL LAYOUTS AND DETAILS

SHEET NO.
4A-3

© 2011 hc|architecture, inc.