




1.3 HEAD DETAIL
 SCALE: N.T.S.

- MODEL WK472
 K=5.8
- MODEL WK472
 K=5.8
- RELIABLE+
 MODEL KFR-COS
 K=5.8
- 1/2" CHROME RESIDENTIAL PENDENT SEM-RECESSED ON DROPS SPACING 16 X 16 MAX
- 1/2" CONCEALED SPACE UPRIGHT ON SPRINGS SPACING 16 X 16 MAX DEFLECTORS 1 1/2"-4" BELOW DECK
- WIRING & RELIABLE+
 MODEL WK472 & KFR-COS (K=5.8 & 5.6)
- 1/2" CHROME RES. PENDENT SEM-RECESSED & BRASS UPRIGHT ABOVE AND BELOW COVERAGE
- QLOBE+
 MODEL QLSB01
 K=3.6
- QLOBE+
 MODEL QLSB01
 K=3.6
- 1/2" CHROME COMMERCIAL PENDENT SEM-RECESSED OR EXTENDED ESC. SPACING 30 SQ.FT. MAX.
- QLOBE+
 MODEL QLSB26
 K=3.6
- 2/7155
 K=3.6
- 1/2" CHROME COMMERCIAL HORIZONTAL SIDEWALL 4" TO 6" 18" ABOVE ELEVATOR PIT FLOOR


- FOR APPROVED EQUAL*
- SCALE: 1/8" = 1'-0"
- NO. DATE: DESCRIPTION:
- DATE: OCTOBER 23, 2013
- DESIGNER: ED DOLAN (GWS# 515)
- DRAWN BY: JEFF THOMAS (GWS# 12680)
- CHECKED BY: AL COSS (WELT # 12680)
- LOCATION: 145 JETPORT BLVD. PORTLAND, ME
- DRAWING TITLE: HILTON GARDEN INN ADDITION GROUND FLOOR FIRE PROTECTION PLAN (NFPA 13 2010ed.)
- DRAWING NO.: FP-01

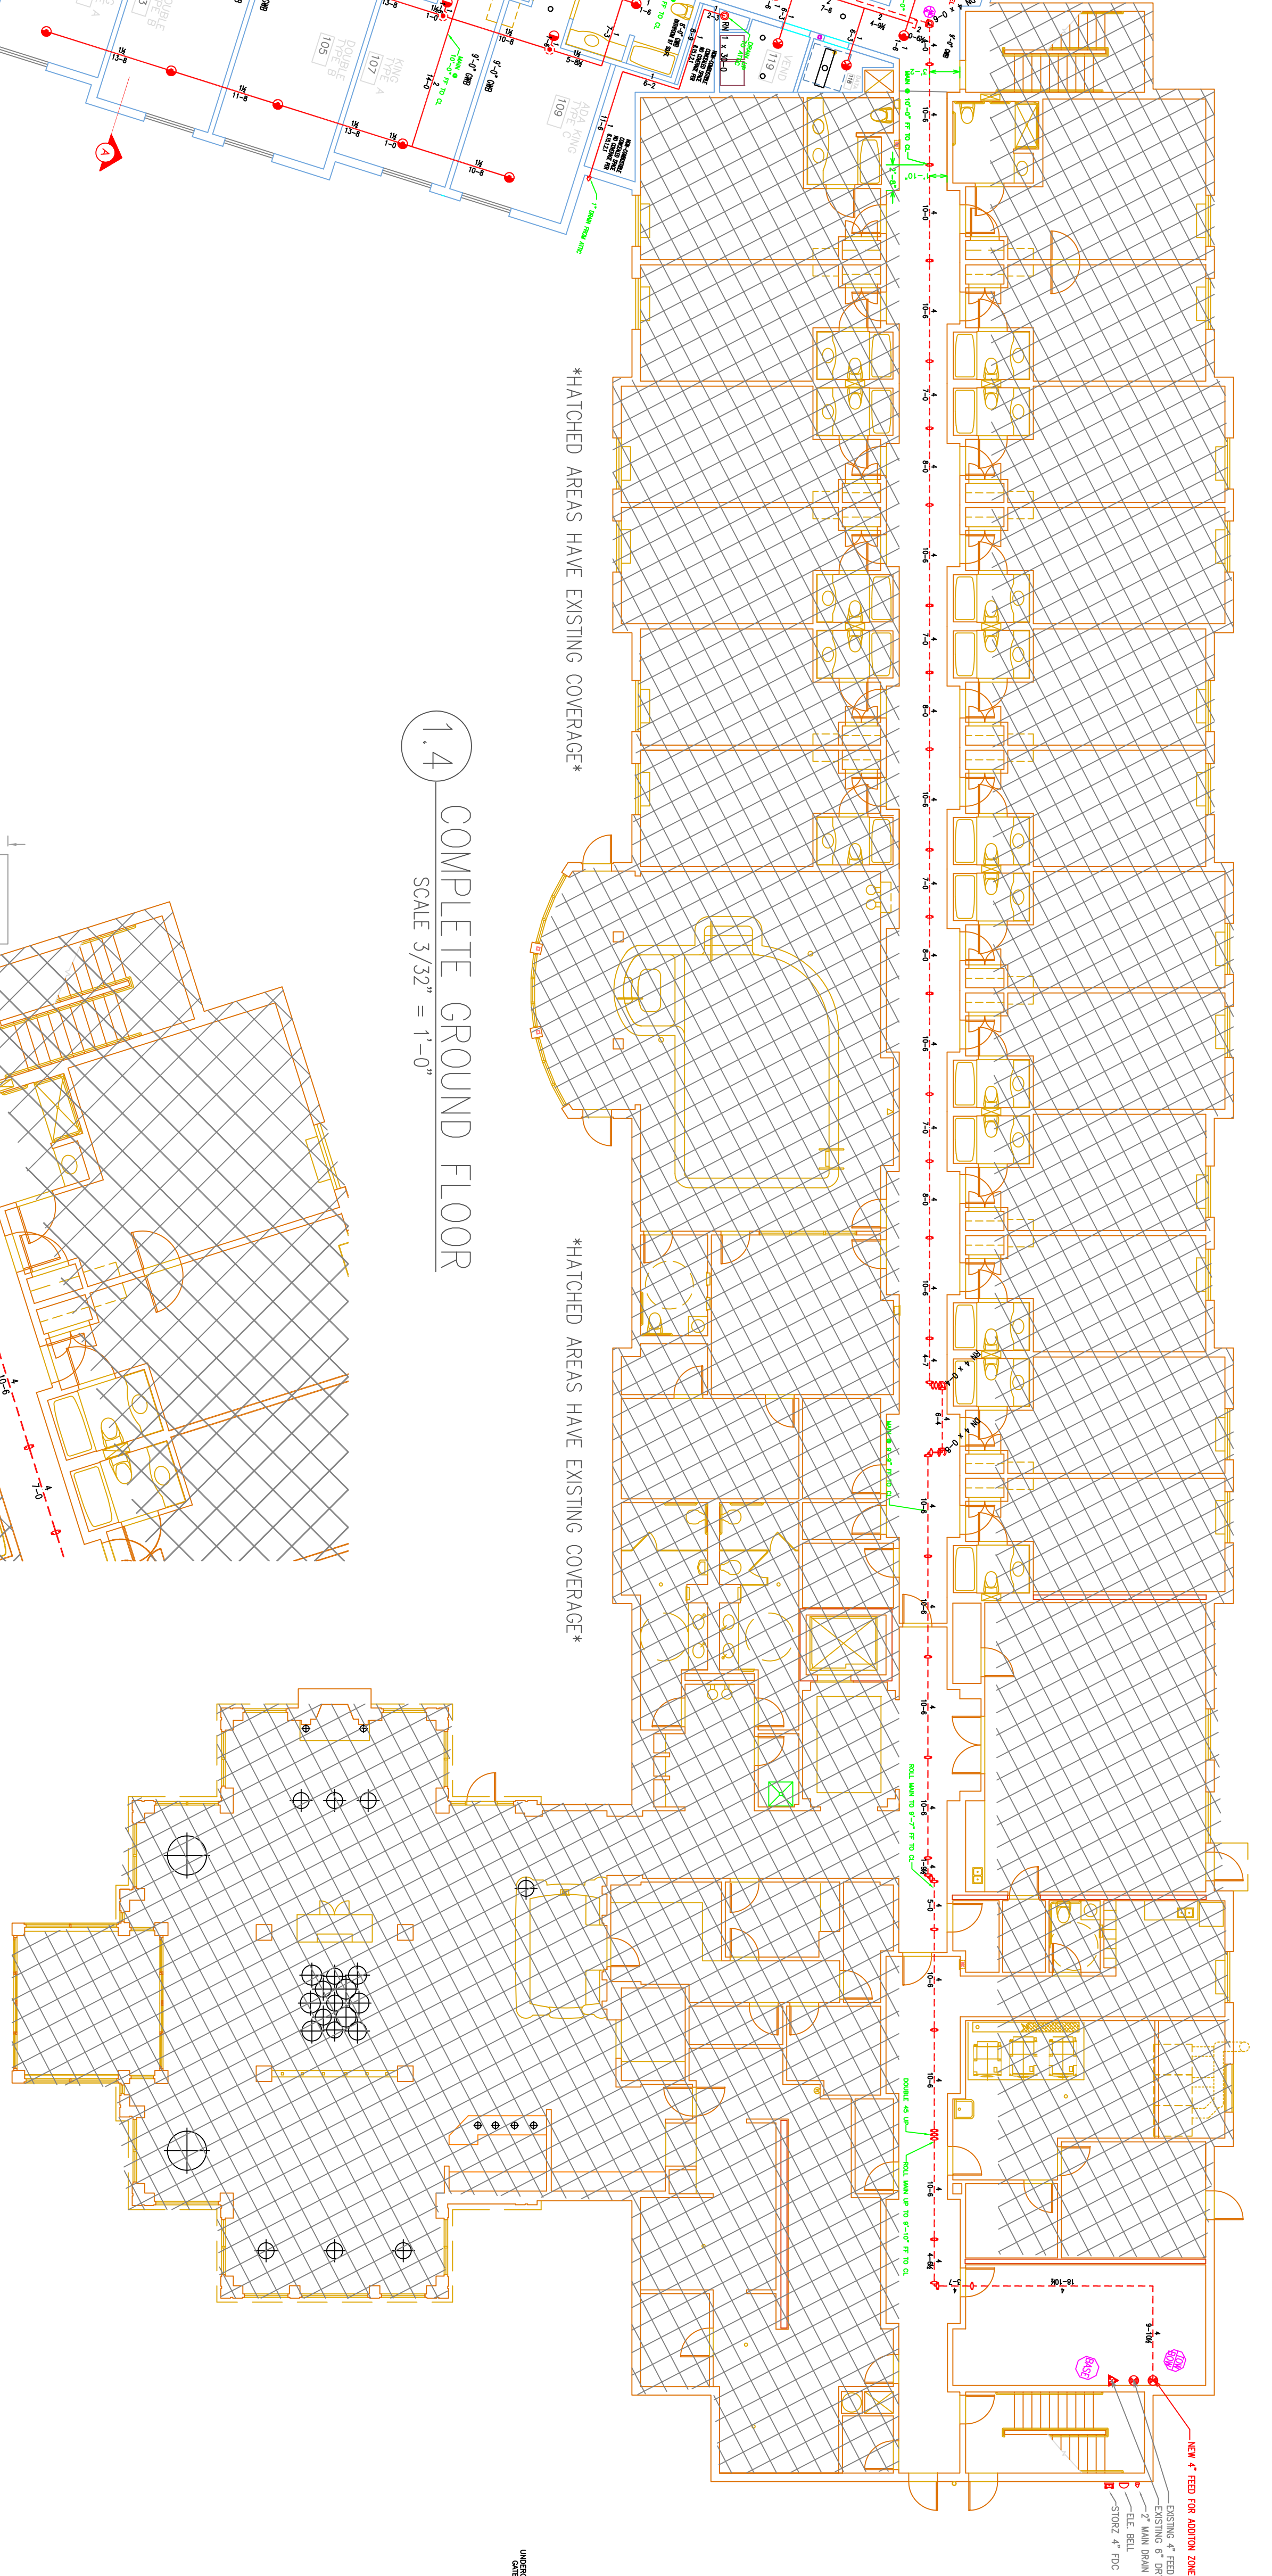


1.4 COMPLETE GROUND FLOOR
 SCALE 3/32" = 1'-0"

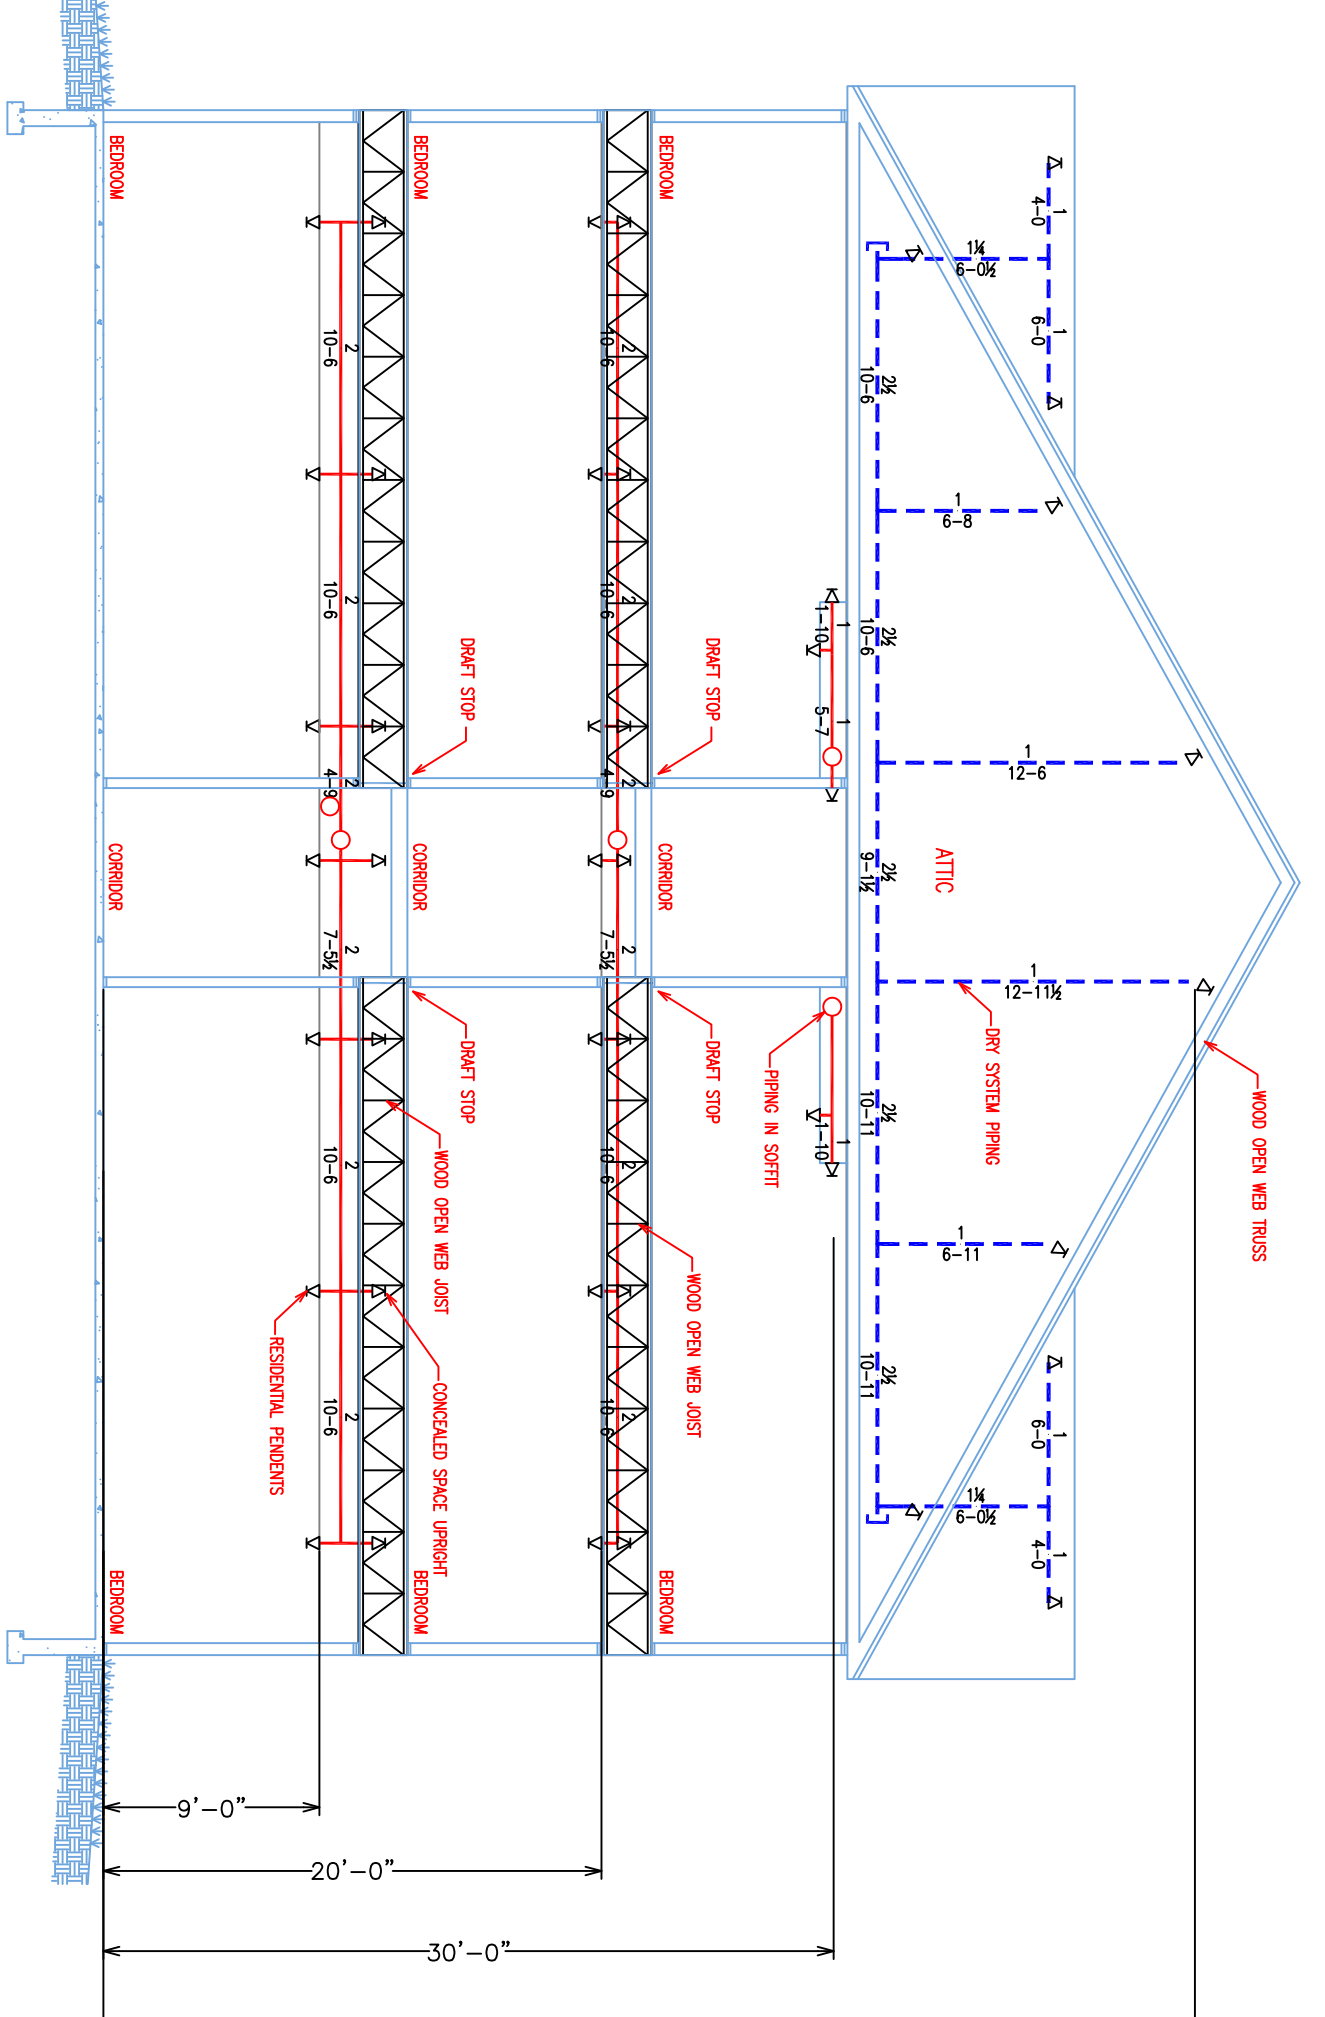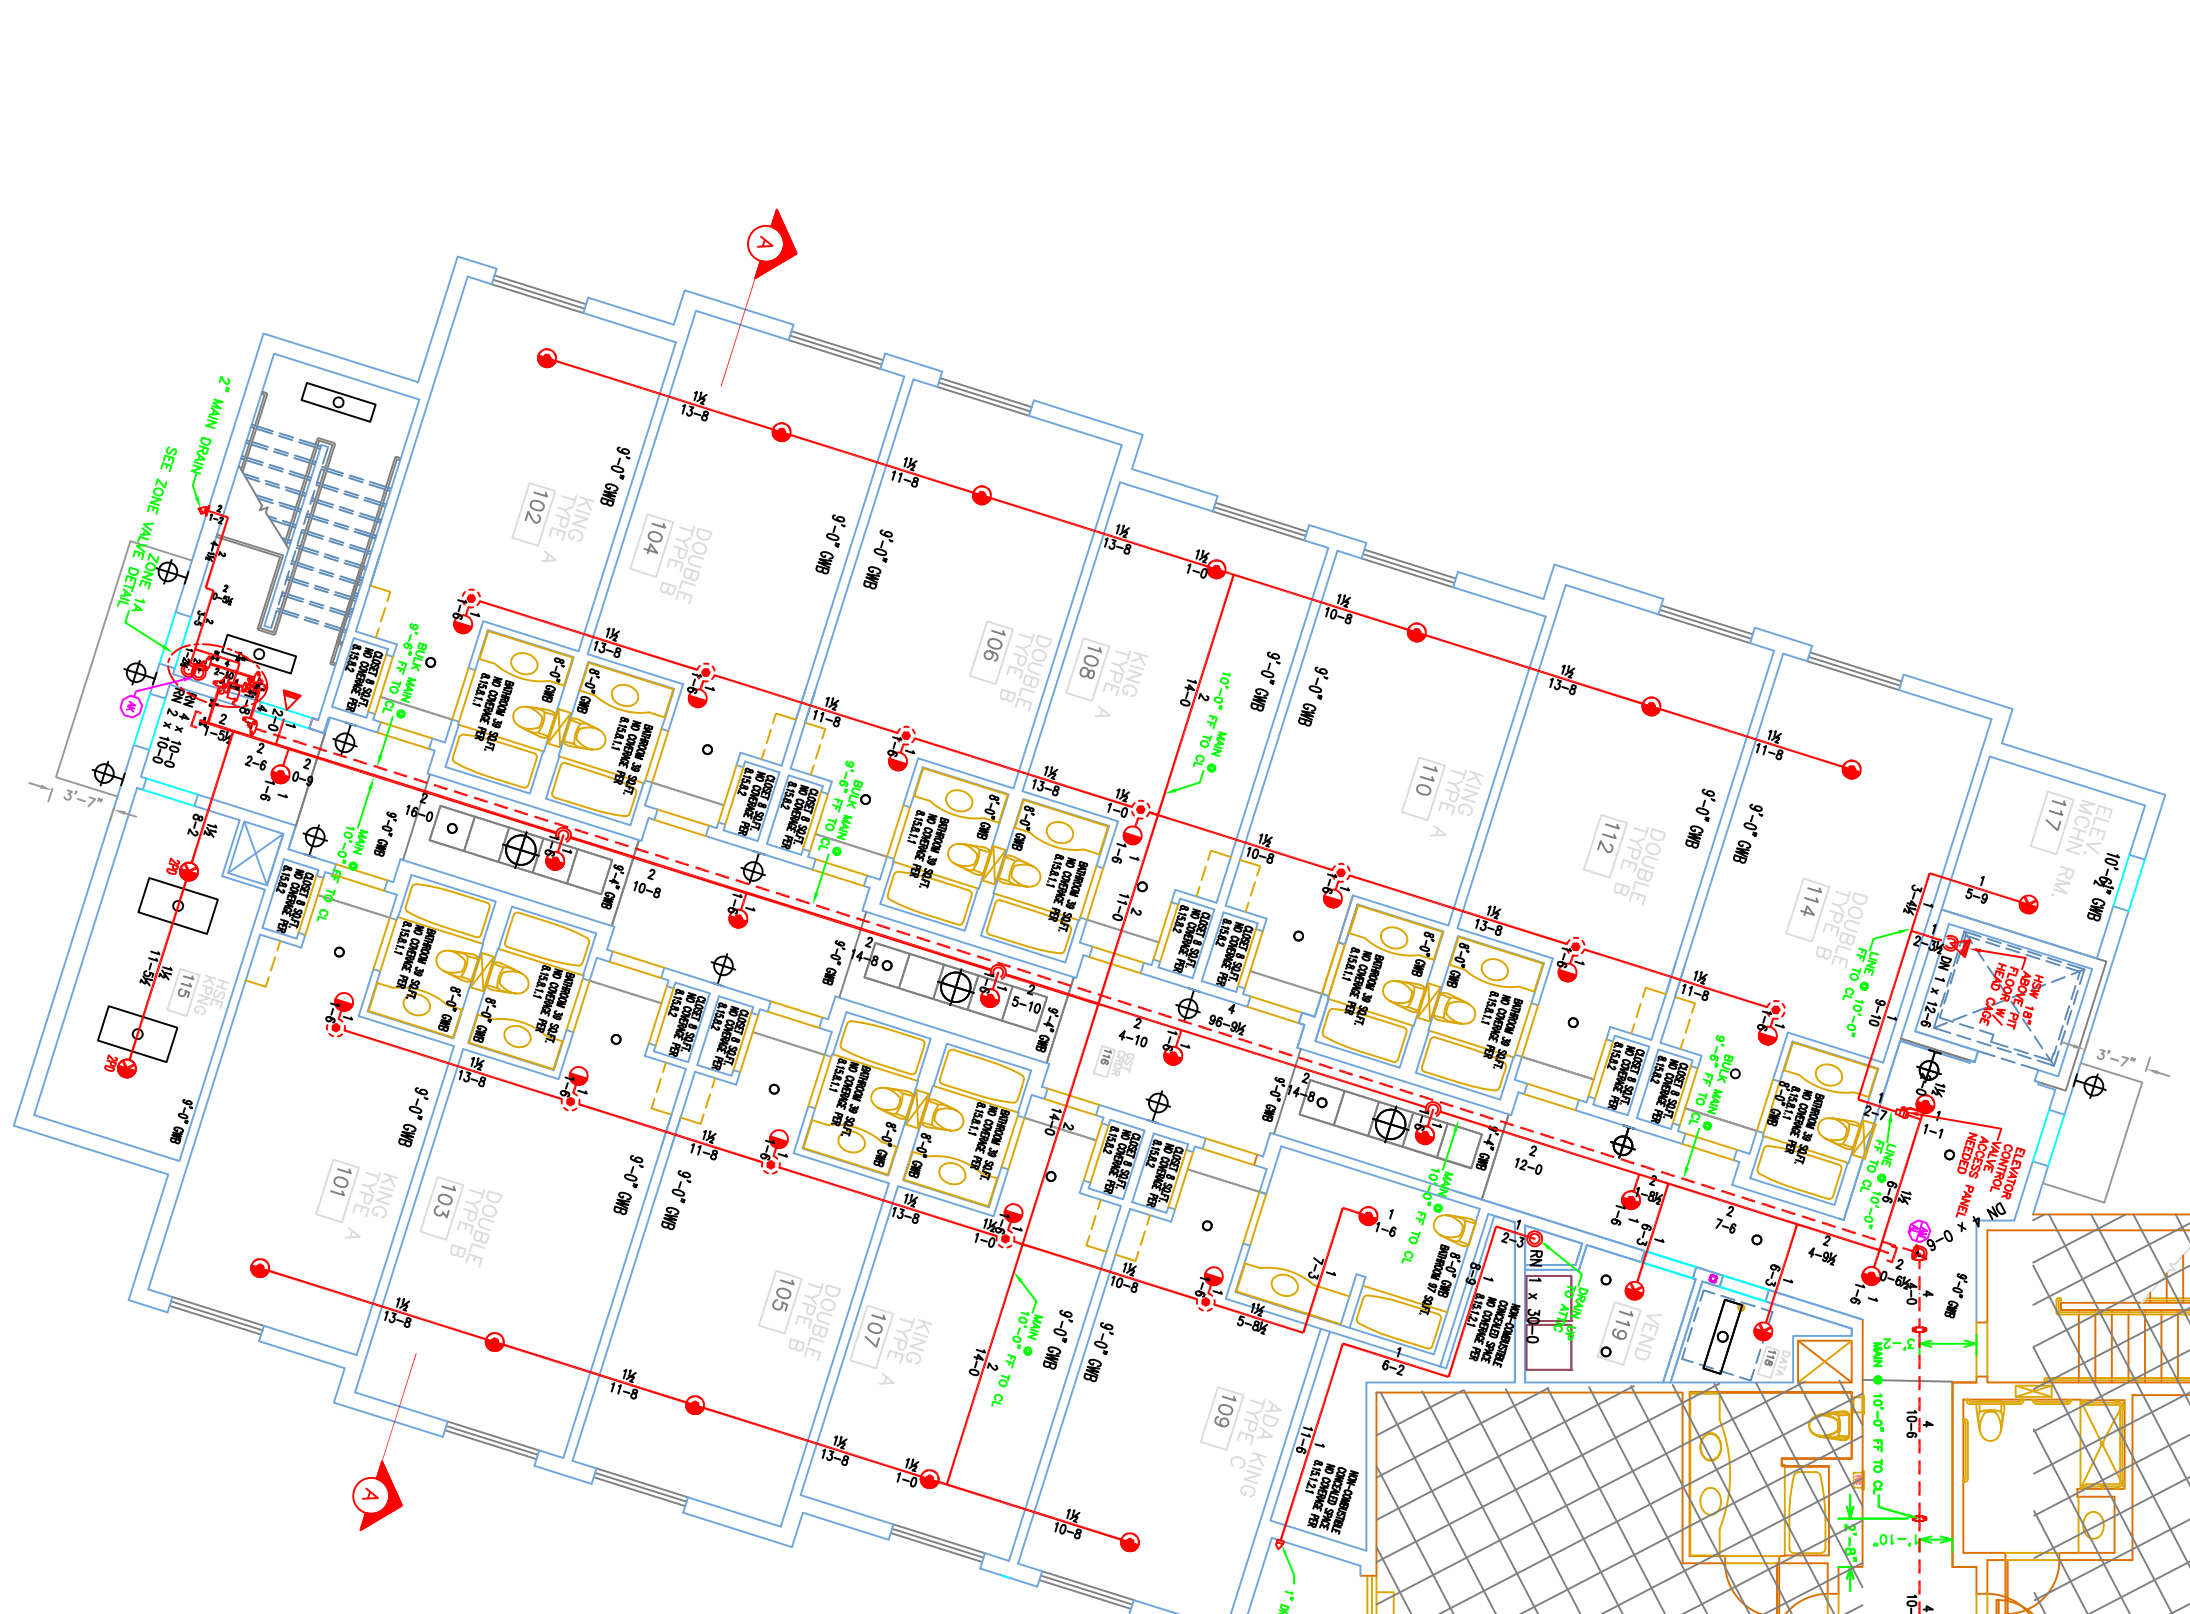


1.5 SECTION 1.1
 SCALE 1/8" = 1'-0"

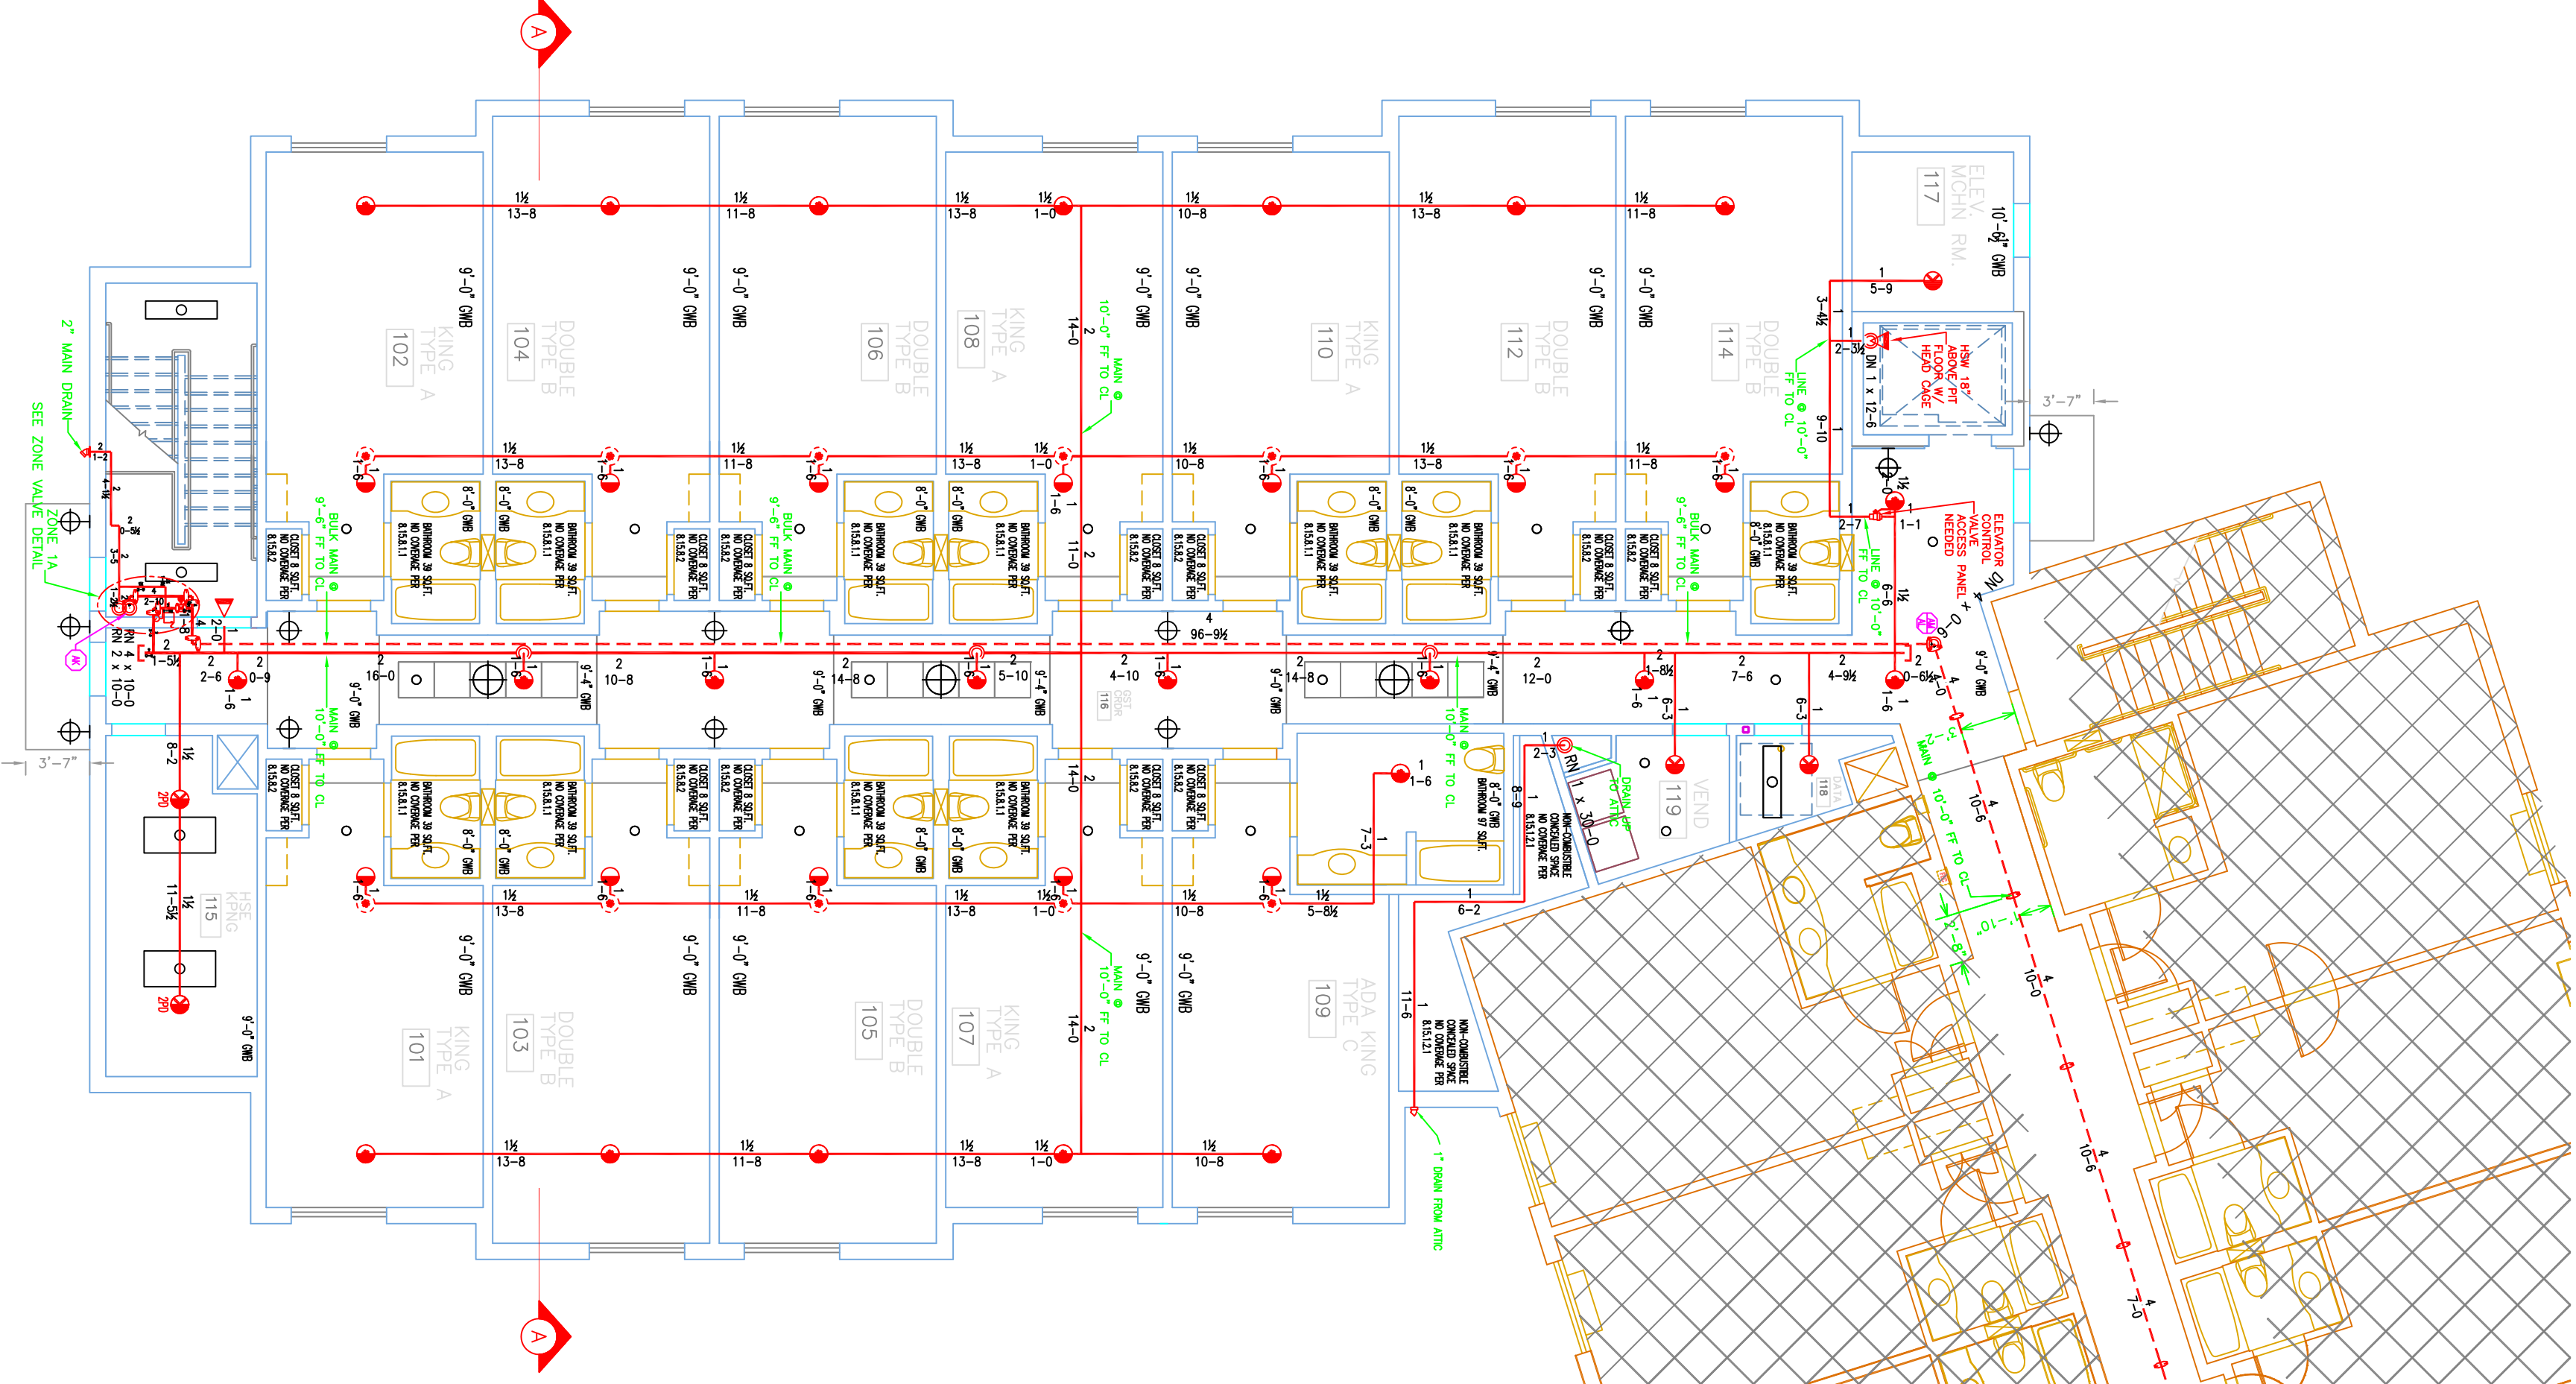

1 GROUND FLOOR (WET)
 SCALE 1/8" = 1'-0"
 TOTAL PROTECTED AREA 5,700 SQ.FT.

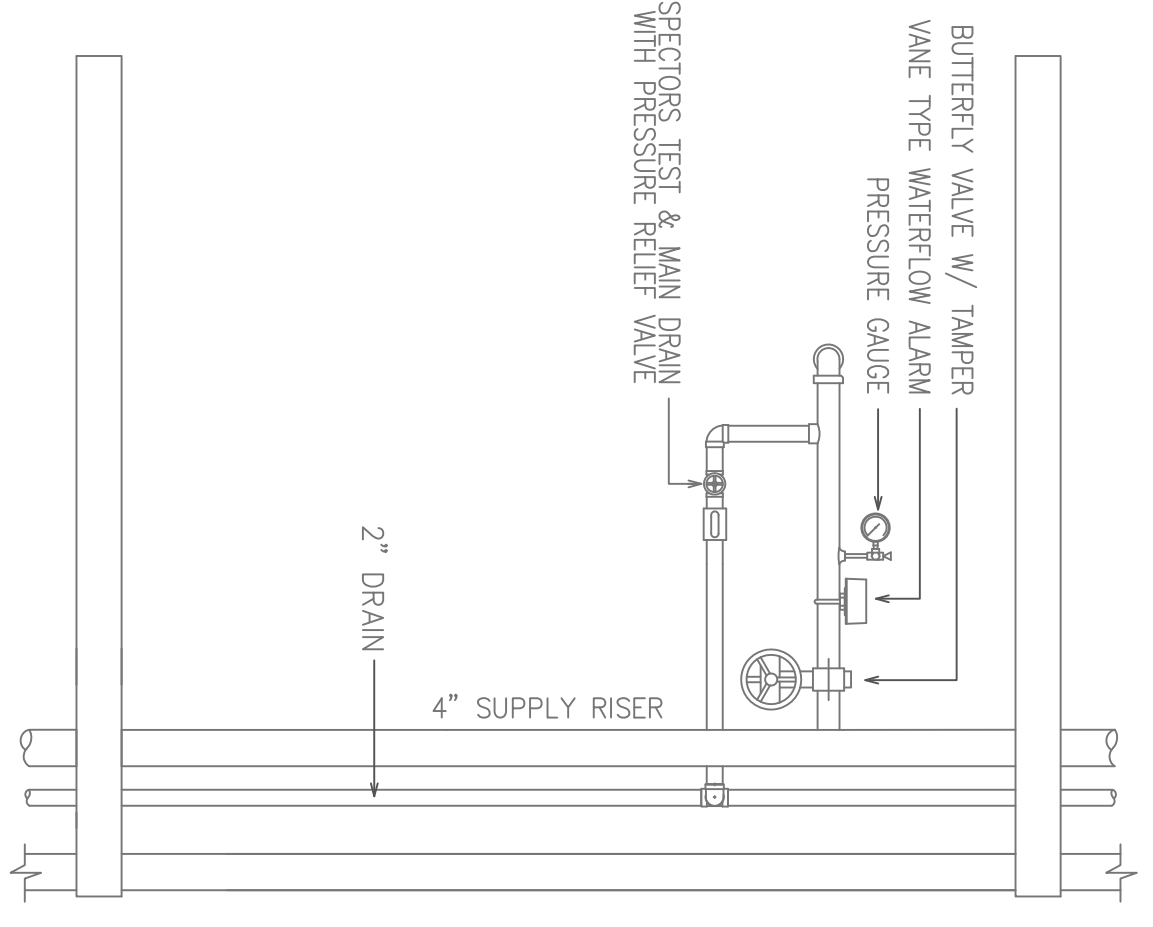

1.2 ZONE VALVE DETAIL
 SCALE: N.T.S.

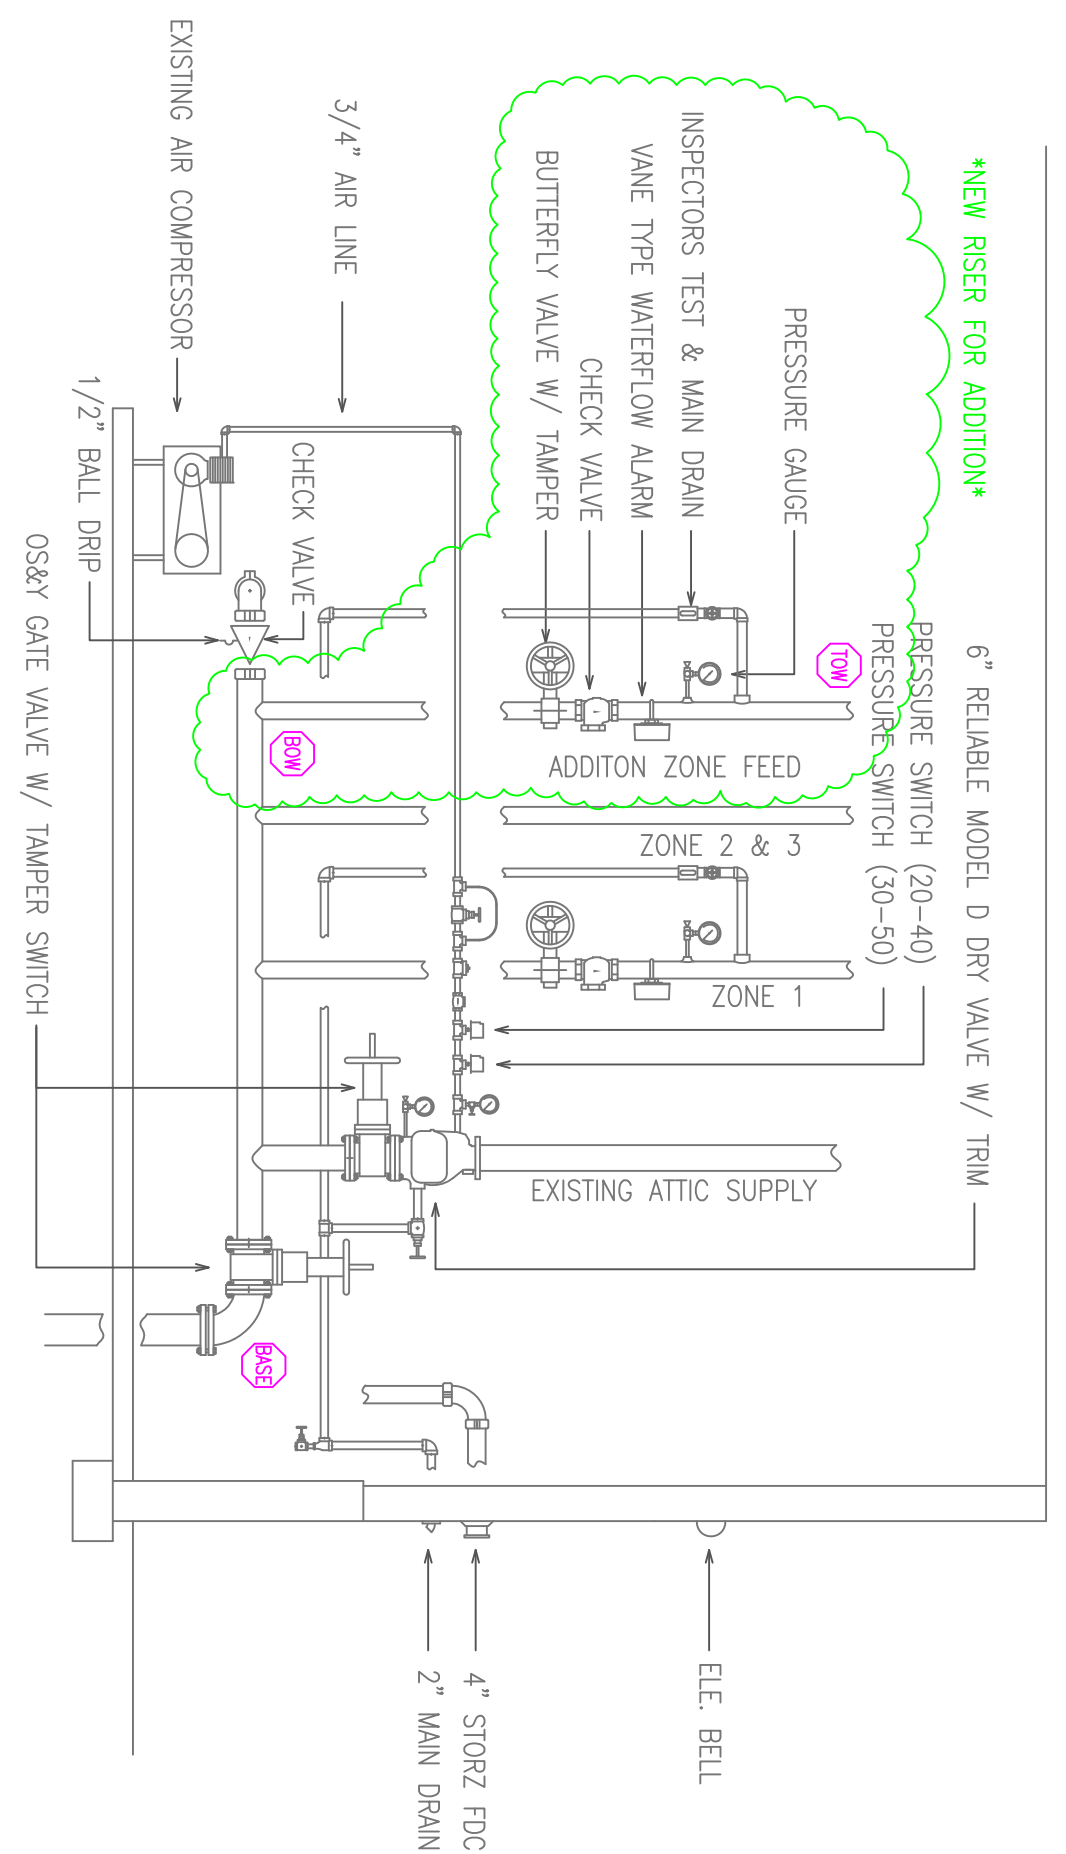

1.1 VALVE ROOM DETAIL
 SCALE: N.T.S.