





SITE PLAN
SCALE 1/4"=1'-0"

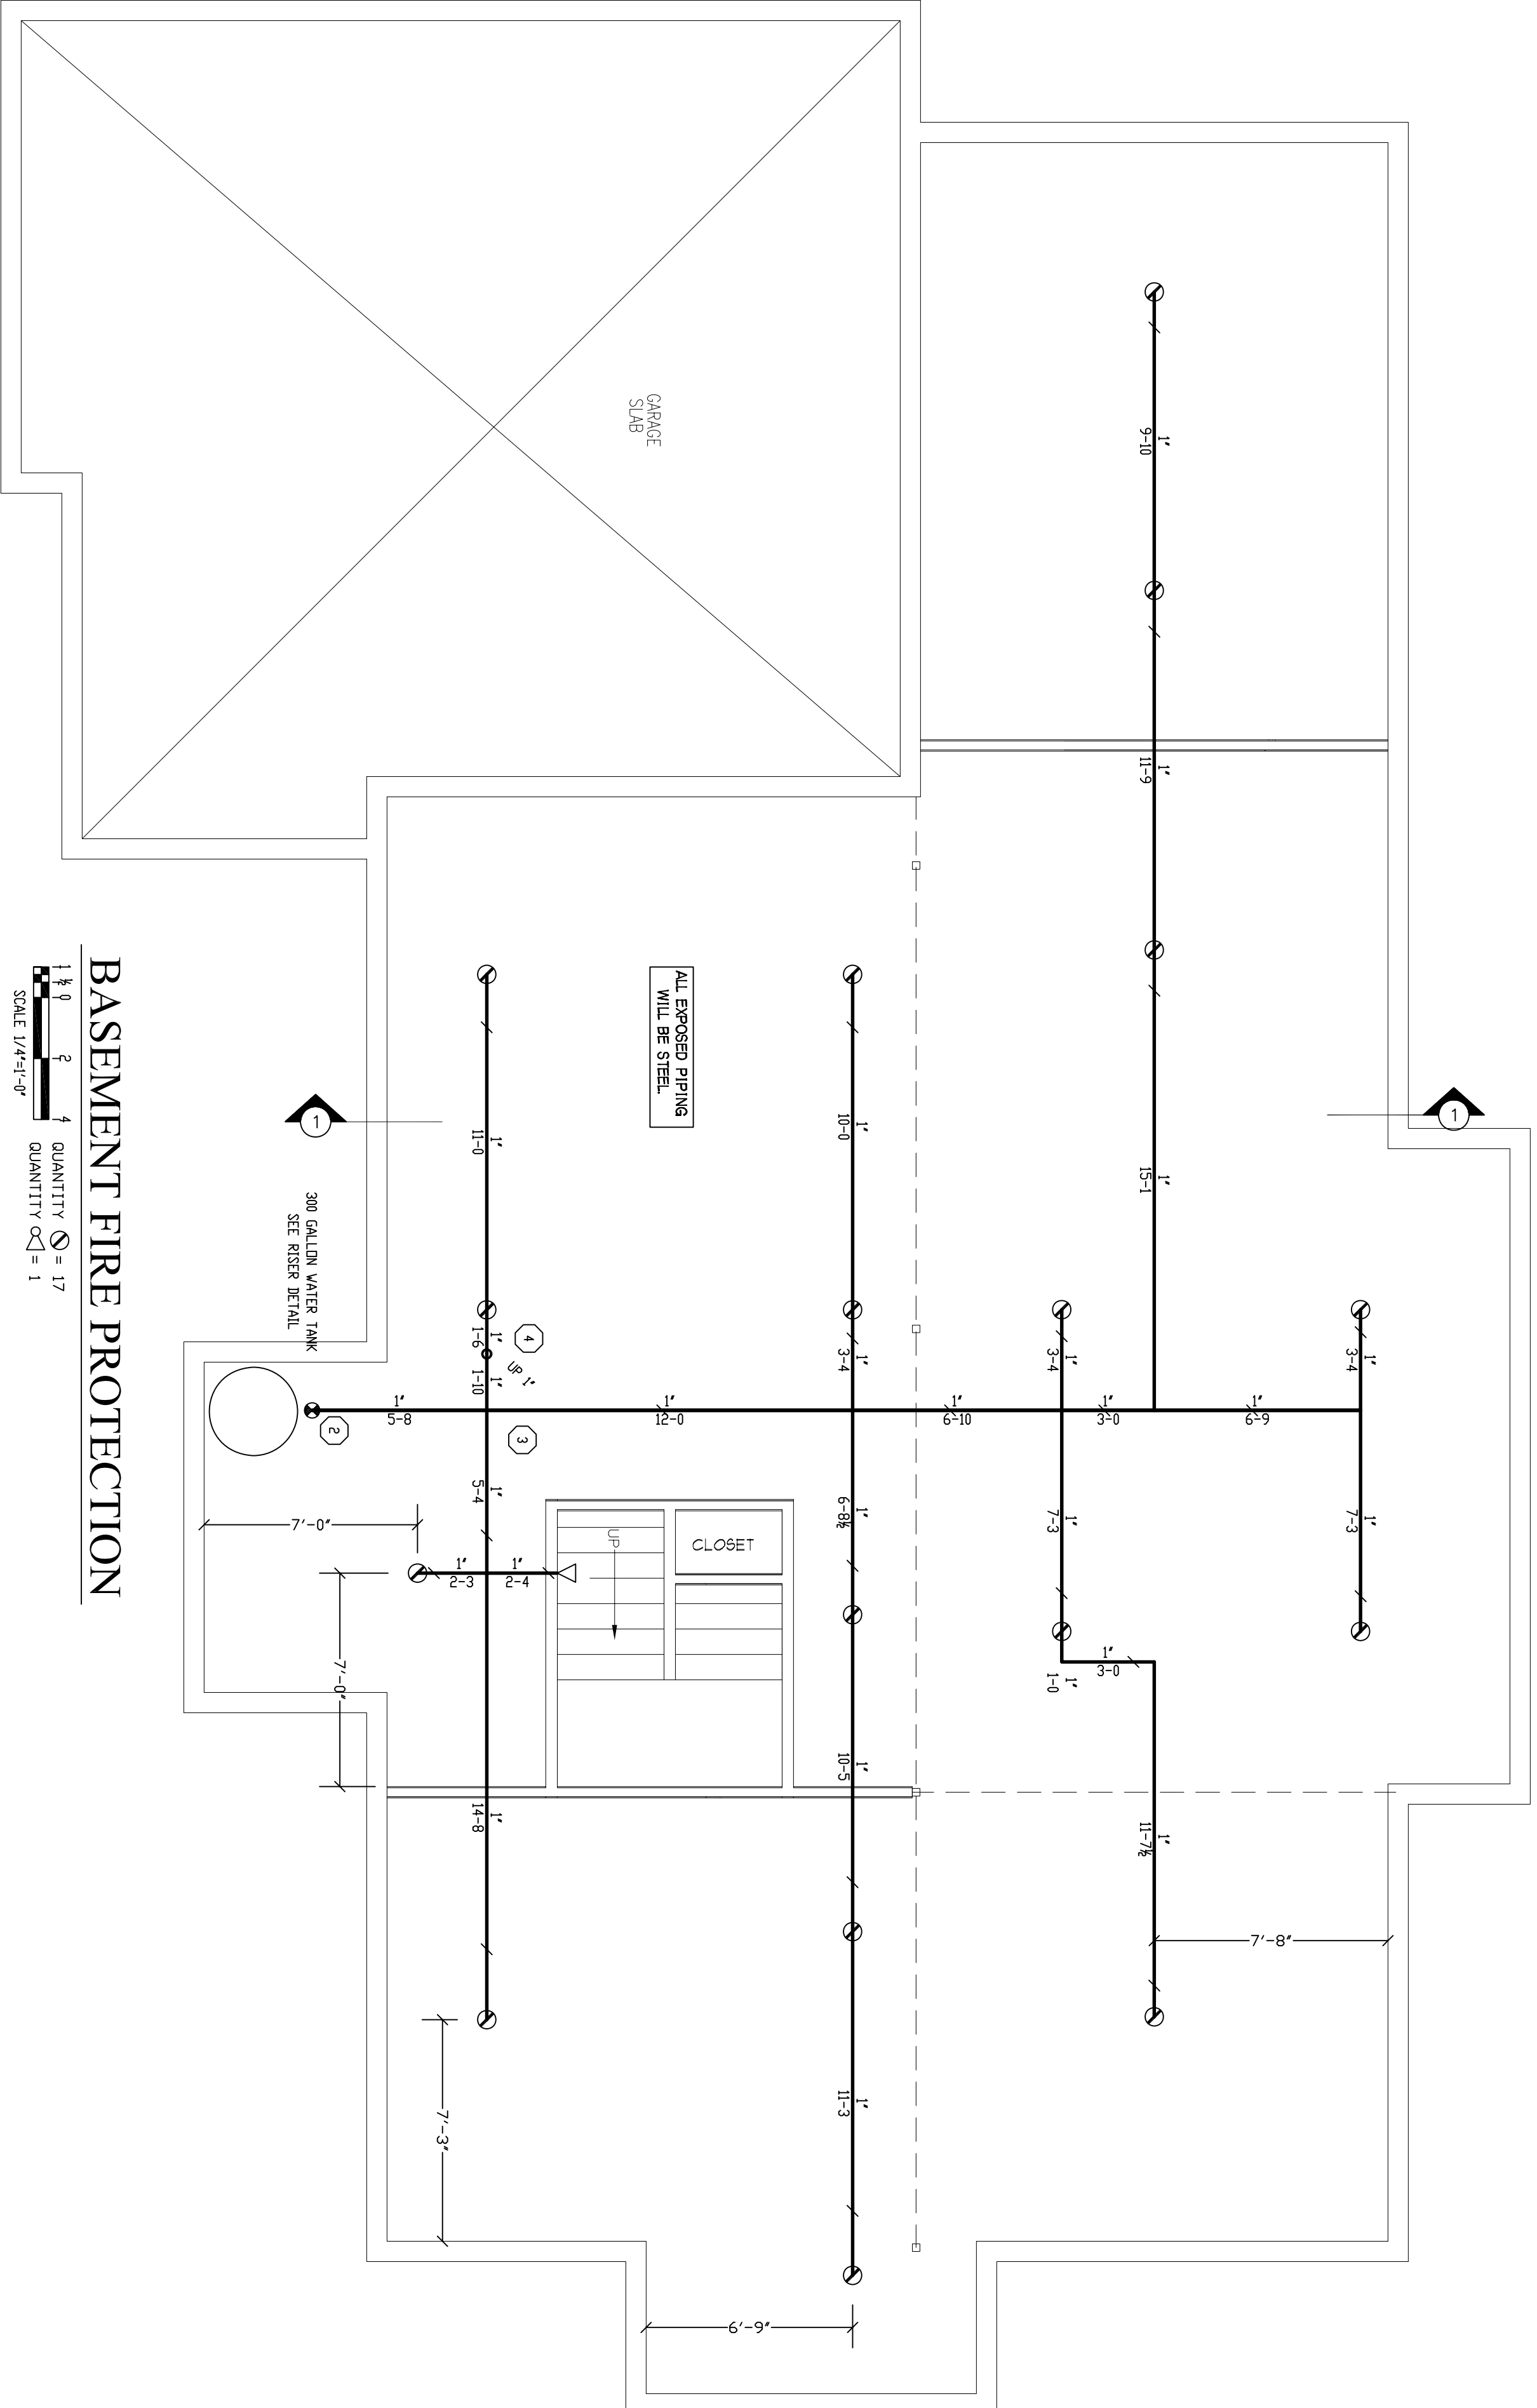


BASEMENT FIRE PROTECTION
SCALE 1/4"=1'-0"
QUANTITY Q = 17
QUANTITY Q = 1

GENERAL NOTES

- 1) SYSTEM TO BE DESIGNED AND INSTALLED IN ACCORDANCE WITH NFPA-13A, 2010 EDITION. ALL SPRINKLER PIPE AND FITTINGS TO BE COMBINATION OF BLACK STEEL, SCH 40 TYPE AND APPROVED BLACK MASTER PLASTIC (BMC) DESIGNED AND APPROVED TO BE USED WITH THIS STANDARD. ALL SPRINKLER HEADS TO BE SPECIFIED IN ACCORDANCE WITH THE MANUFACTURER'S RECOMMENDATIONS. ALL SPRINKLER HEADS TO BE SPECIFIED IN ACCORDANCE WITH THE MANUFACTURER'S RECOMMENDATIONS. ALL SPRINKLER HEADS TO BE SPECIFIED IN ACCORDANCE WITH THE MANUFACTURER'S RECOMMENDATIONS. ALL SPRINKLER HEADS TO BE SPECIFIED IN ACCORDANCE WITH THE MANUFACTURER'S RECOMMENDATIONS.
- 2) SPRINKLER HEADS TO BE SPECIFIED IN ACCORDANCE WITH THE MANUFACTURER'S RECOMMENDATIONS. ALL SPRINKLER HEADS TO BE SPECIFIED IN ACCORDANCE WITH THE MANUFACTURER'S RECOMMENDATIONS. ALL SPRINKLER HEADS TO BE SPECIFIED IN ACCORDANCE WITH THE MANUFACTURER'S RECOMMENDATIONS.
- 3) SPRINKLER HEADS TO BE SPECIFIED IN ACCORDANCE WITH THE MANUFACTURER'S RECOMMENDATIONS. ALL SPRINKLER HEADS TO BE SPECIFIED IN ACCORDANCE WITH THE MANUFACTURER'S RECOMMENDATIONS. ALL SPRINKLER HEADS TO BE SPECIFIED IN ACCORDANCE WITH THE MANUFACTURER'S RECOMMENDATIONS.
- 4) SPRINKLER HEADS TO BE SPECIFIED IN ACCORDANCE WITH THE MANUFACTURER'S RECOMMENDATIONS. ALL SPRINKLER HEADS TO BE SPECIFIED IN ACCORDANCE WITH THE MANUFACTURER'S RECOMMENDATIONS. ALL SPRINKLER HEADS TO BE SPECIFIED IN ACCORDANCE WITH THE MANUFACTURER'S RECOMMENDATIONS.

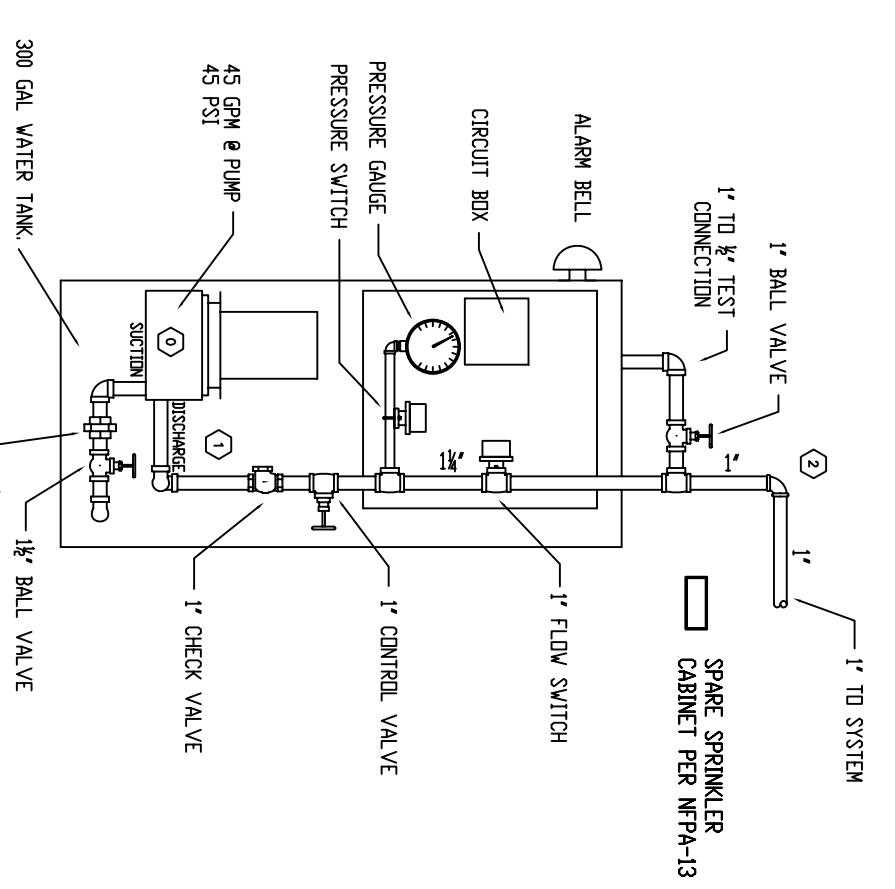

FIRE PROTECTION PUMP AND TANK DETAIL

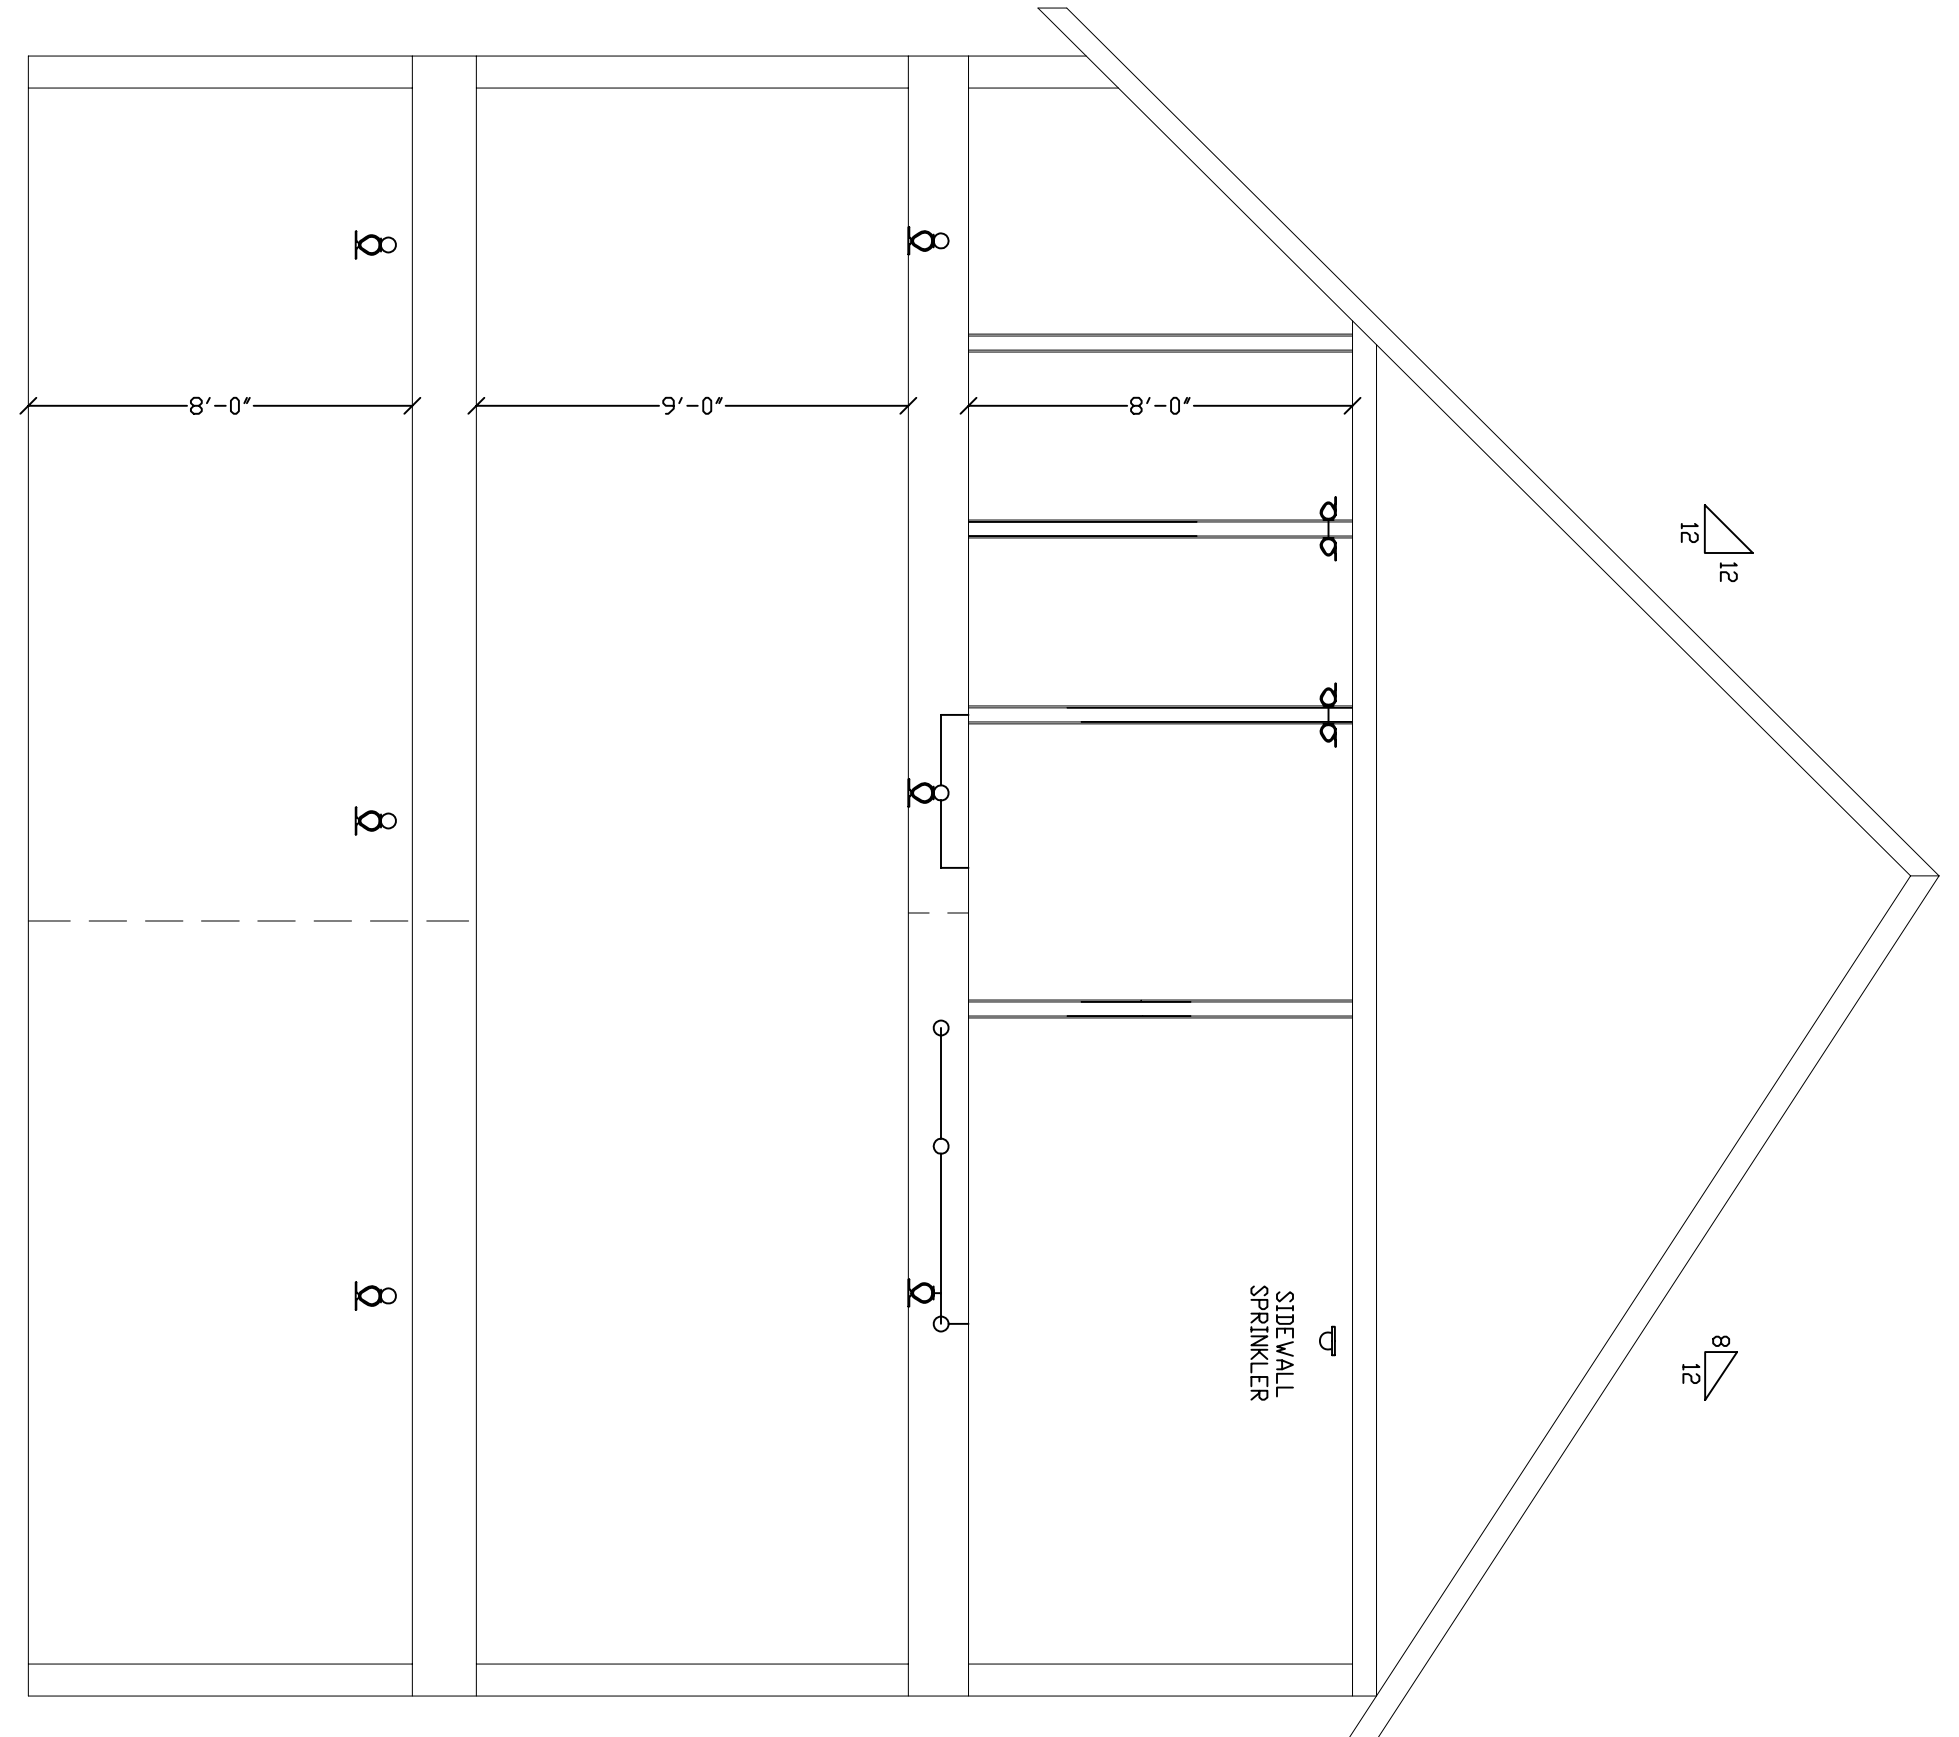

SECTION VIEW
SCALE 1/4"=1'-0"

REVISIONS	NOTES	SPRINKLER TYPE	IDENTIFICATION NO.	MFG.	ESC.	MODEL	FINISH	ORIFICE	TEMP.	SYMBOL	QUANT.
	K-4.9 RESIDENTIAL SPRINKLER COVERAGE 3/8\"/>										

STANDARD SYMBOLS	STANDARD SYMBOLS
<ul style="list-style-type: none"> ⊙ - POST INDICATOR VALVE ⊙ - KEY VALVE ⊙ - FIRE INDICANT ⊙ - FIRE DEPT CONNECTION ⊙ - O.S. & Y GATE VALVE ⊙ - SWING CHECK VALVE ⊙ - NON UNDERGROUND ⊙ - EDSH UNDERGROUND 	<ul style="list-style-type: none"> ⊙ - ALARM CHECK VALVE ⊙ - RISER W/ALARM VALVE ⊙ - RISER W/DRY VALVE ⊙ - RISER W/ELECT. FLOW SWITCH ⊙ - RISER W/RELIEF VALVE ⊙ - WATER MOTOR BELL ⊙ - ELECTRICAL BELL ⊙ - FLUSH FIRE DEPT CONNECTION

INSPECTIONS
1.
2.
3.
4.
5.
6.

ERIC DAWSON RESIDENCE 45 TIDE MILL ROAD PORTLAND, MAINE 04102		JOB No.	M0100
FREEDOM FIRE PROTECTION, INC. 209 QUAKER RIDGE ROAD CASCO, MAINE 04015		DATE	12/7/12
FIRE PROTECTION PLAN		DESIGN BY	MAN
SCALE		DATE NOTED	
SHEET No.			
FP-1012			