


project no. 18-0018
revisions:
Project JOHNSON ROAD PROPERTY PORTLAND, MAINE
drawing title SITE LIGHTING PLAN

date drawn: 06/22/18
date issued: 07/02/18
drawn by: LEB
scale: AS NOTED

Bartlett Design
LIGHTING & ELECTRICAL ENGINEERING
5 PALMER STREET, BATH, ME 04530
TEL (207) 443-5447

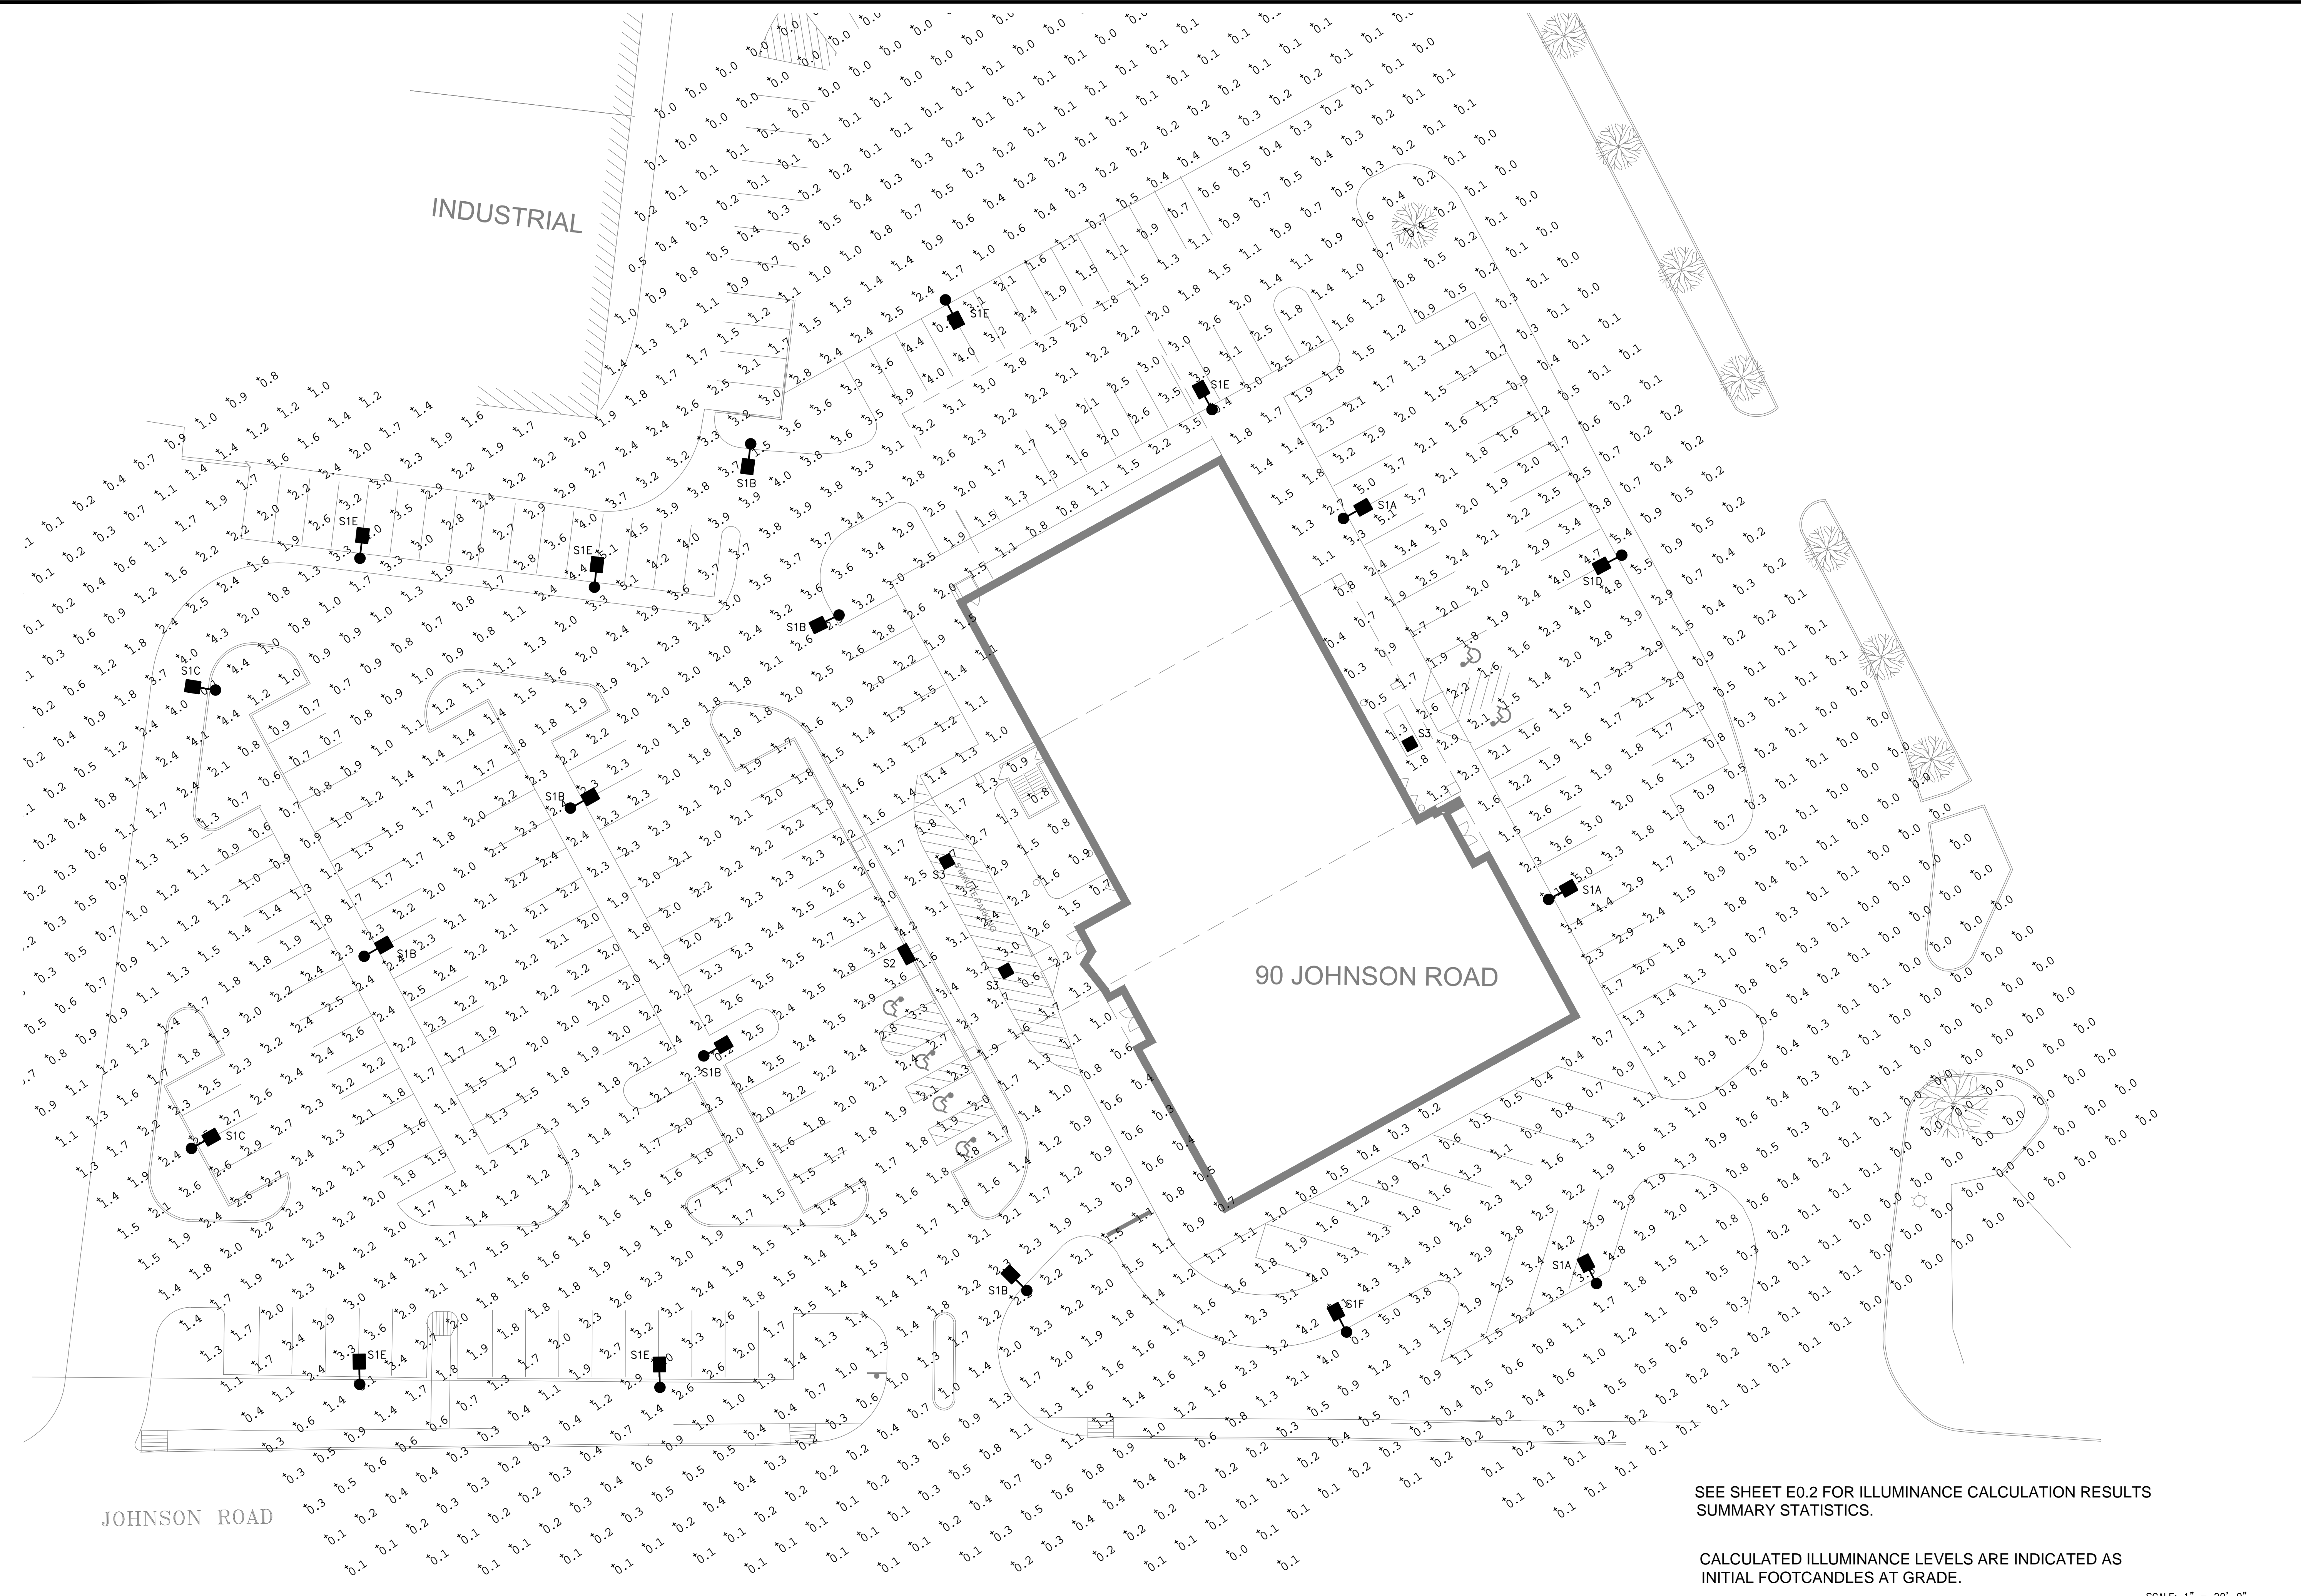

SEE SHEET E0.2 FOR ILLUMINANCE CALCULATION RESULTS SUMMARY STATISTICS.

CALCULATED ILLUMINANCE LEVELS ARE INDICATED AS INITIAL FOOTCANDLES AT GRADE.

SCALE: 1" = 20'-0"

SITE LIGHTING ILLUMINANCE CALCULATION PLAN

E-0.1

1
sheet number