



NOTE:
1. SEE SHEET M-001 FOR LEGEND AND ABBREVIATIONS.

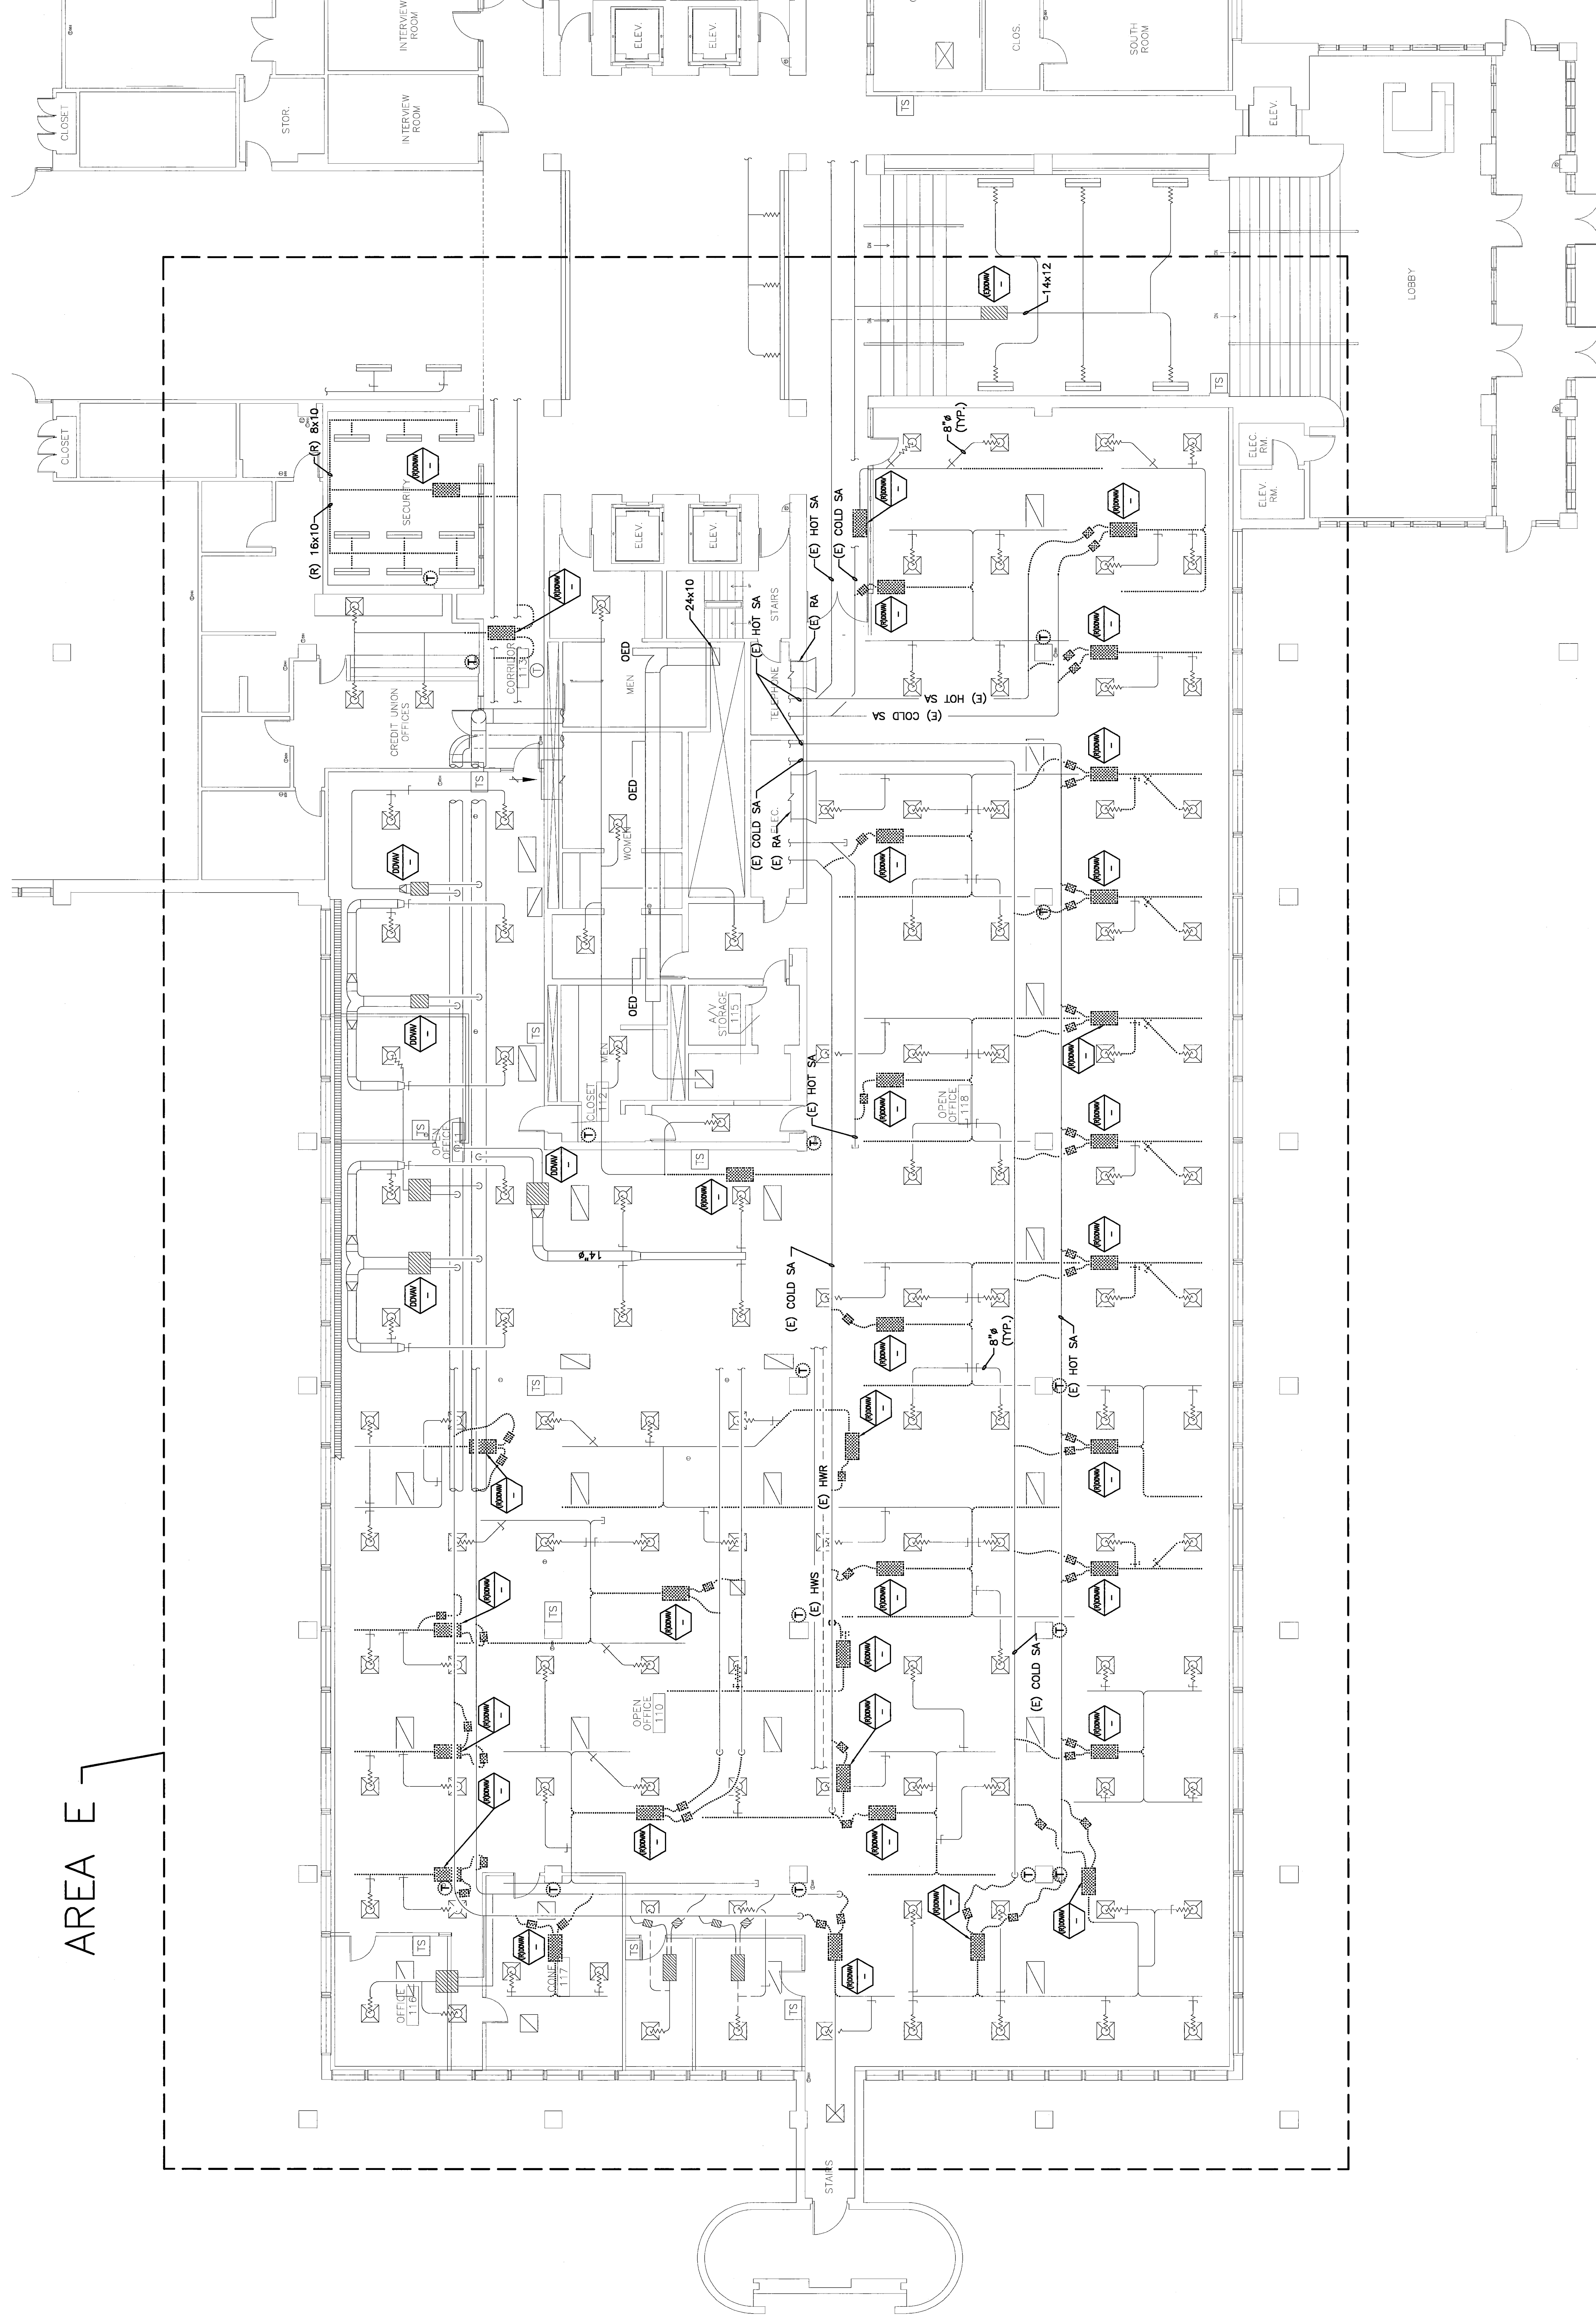

AREA E

REV.	DESCRIPTION	DATE
0	ISSUED FOR CONSTRUCTION	5-11-06

ISSUED FOR CONSTRUCTION
5-11-06

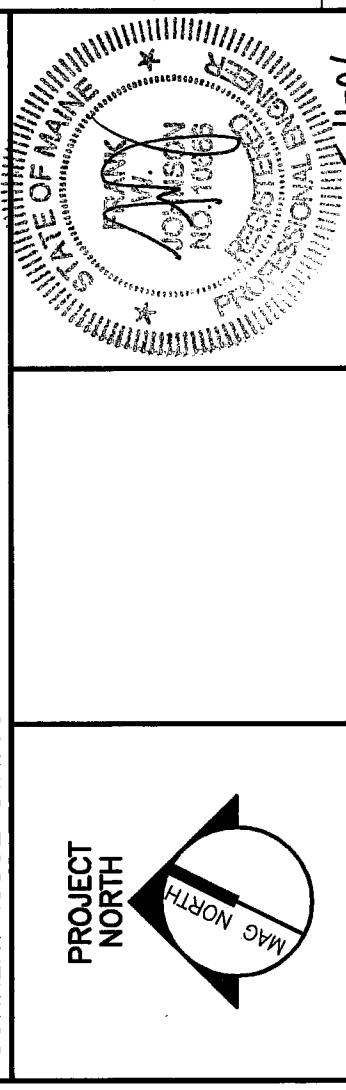

SM
RT
ARCHITECTURE ENGINEERING PLANNING
144 Fore Street P.O. Box 418
Portland, Maine 04104
Tel. (207) 772-3946
Fax. (207) 772-0100

PROJECT: **UnumProvident HO-1**
MITCO VALVE REPLACEMENT
PORTLAND, ME.

PROJECT TITLE: **HVAC DEMOLITION PLAN**
WEST SIDE

SHEET TITLE: **HVAC DEMOLITION PLAN**
SCALE: 1/8"=1'-0"
DATE: 5-11-06
GRAPHIC SCALE: 0'

PROJECT No. **MD101-06006**
SHEET No. **MD101**

A1 FLOOR PLAN
1/8"=1'-0"