


NOTES:

1. SEE SHEET M-001 FOR LEGEND AND ABBREVIATIONS.
2. RE-BALANCE SUPPLY DIFFUSERS SERVED BY NEW TERMINAL UNITS TO VOLUME INDICATED.

KEYED NOTES:

- ① PROVIDE 8-INCH TAKE-OFFS SERVING TERMINAL UNIT.
- ② PROVIDE 10-INCH TAKE-OFFS SERVING TERMINAL UNIT.
- ③ PROVIDE 12-INCH TAKE-OFFS SERVING TERMINAL UNIT.
- ④ PROVIDE 14-INCH TAKE-OFFS SERVING TERMINAL UNIT.

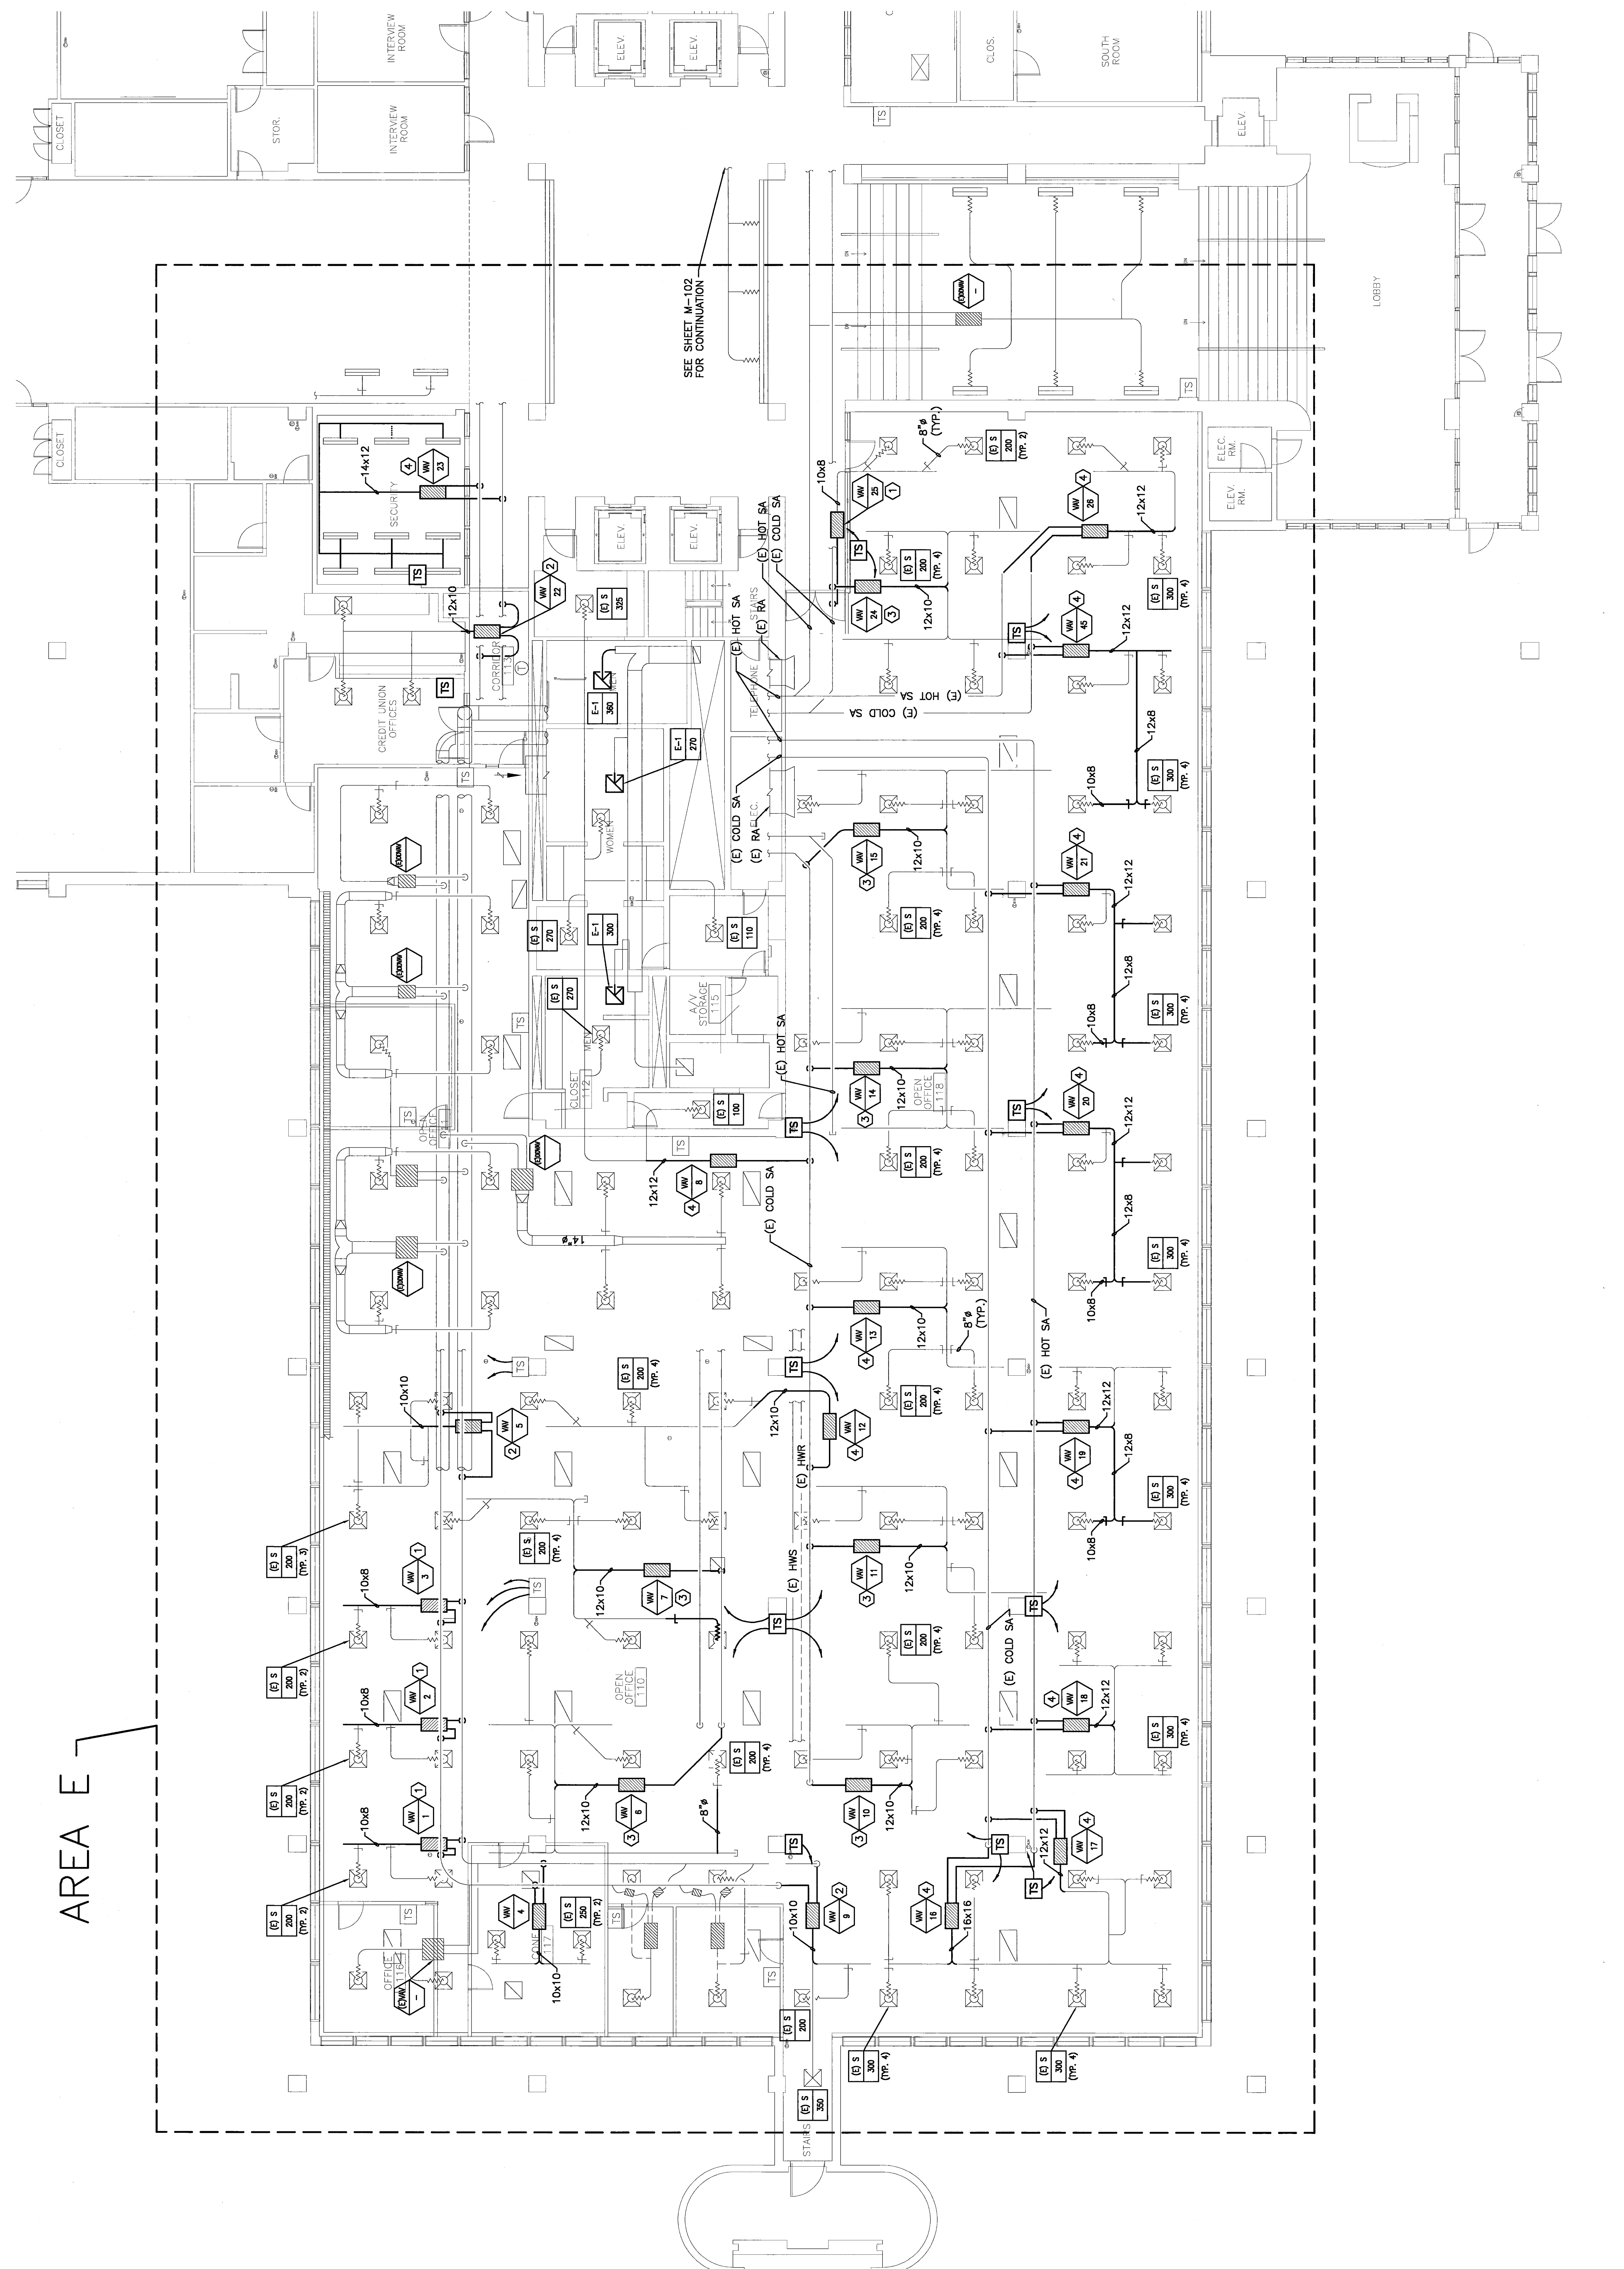

AREA E

REV.	ISSUED FOR CONSTRUCTION	DATE
0		5-11-06

ISSUED FOR CONSTRUCTION
5-11-06



SM RT
ARCHITECTURE ENGINEERING PLANNING
SMART
144 Park Street, 3rd Fl., #18
Portland, Maine 04103
Tel. (207) 725-3846
Fax. (207) 725-1070

PROJECT:
**UnumProvident HO-1
MITCO VALVE REPLACEMENT**
PORTLAND, ME.

HVAC PLAN
WEST SIDE

SHEET TITLE:	1/8"=1'-0"	DATE:	5-11-06
SCALE:		GRAPHIC SCALE:	0'
PROJECT MANAGER:	JUH		
JOB CHG/DRAWN:	CAH		
A/E OF RECORD:	FWJ		
SMART CAD FILE:	M-101-05006	SHEET NO.	M-101
PROJECT NO.	06006		

A1 FLOOR PLAN

1/8"=1'-0"