


**NOTE:**  
1. SEE SHEET E-001 FOR LEGEND AND GENERAL NOTES.


**KEYED NOTE:**  
① PROVIDE POWER FOR ELECTRIC WATER COOLER. COORDINATE WITH PLUMBING CONTRACTOR FOR EXACT LOCATION OF ELECTRICAL CONNECTION.

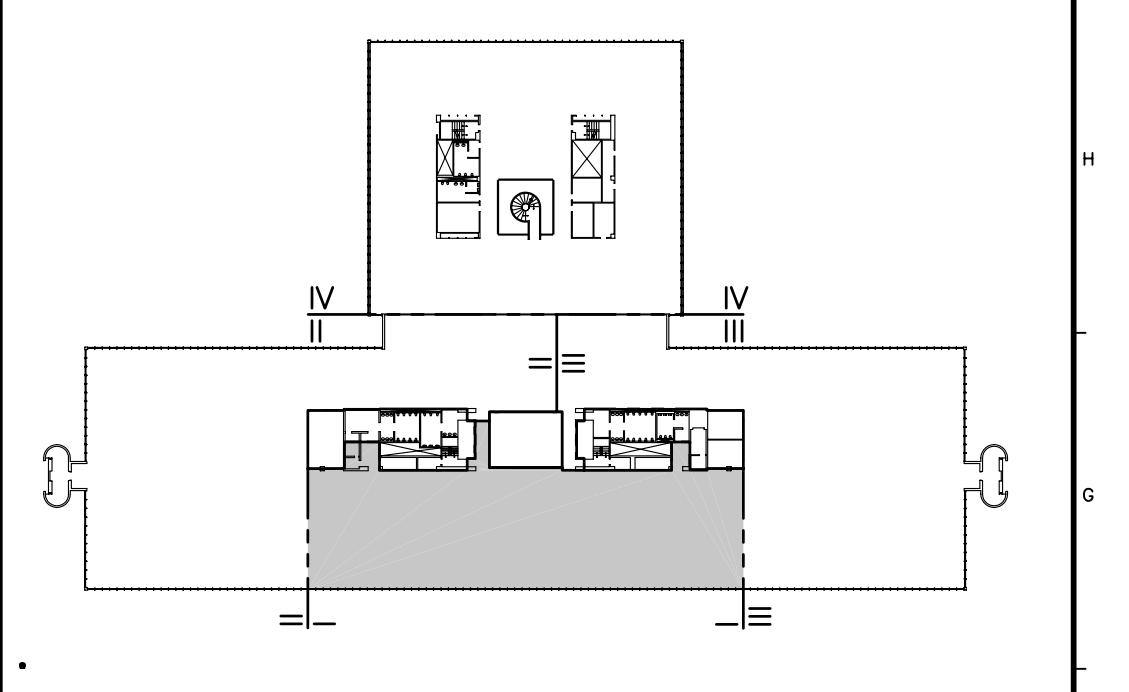

**F18 KEY PLAN**  
NOT TO SCALE

0	ISSUED FOR CONSTRUCTION	1-28-04
REV.	DESCRIPTION	DATE

**ISSUED FOR CONSTRUCTION 1-28-04**  
CURRENT ISSUE STATUS:

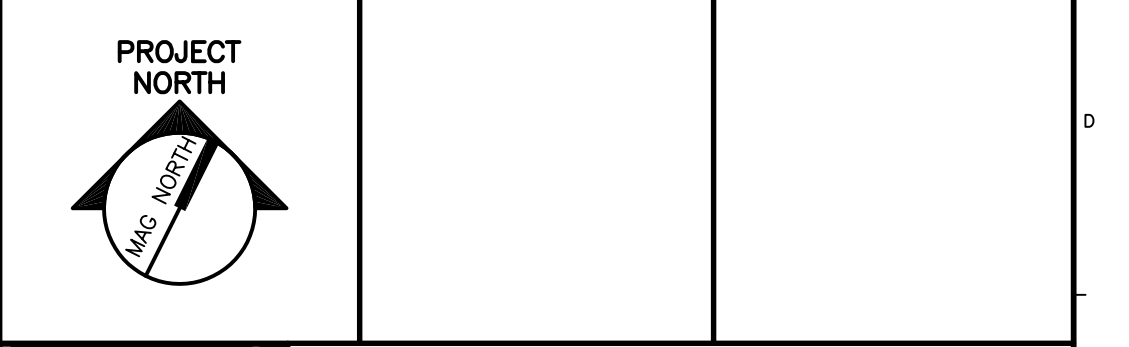

**SMRT** ARCHITECTURE ENGINEERING PLANNING  
SMRT  
144 Fore Street/P.O. Box 618  
Portland, Maine 04104  
tel. (207) 772-3846  
fax. (207) 772-1070

**UNIMPROVIDENT HO-1**  
**2nd FLOOR OFFICE RENOVATIONS**  
PORTLAND, ME.

**PHASE I POWER PLAN**

SHEET TITLE:	1/8"=1'-0"	DATE:	1-28-04
PROJECT MANAGER:	JLH	GRAPHIC SCALE:	0" 1"
JOB CAP/DRAWN:	CEB/BGG	A/E OF RECORD:	DJT
SMRT CAD FILE:	EP101-03100-01	SHEET No.	EP101
PROJECT No.	03100-01		

**A1 FLOOR PLAN**  
1/8"=1'-0"