
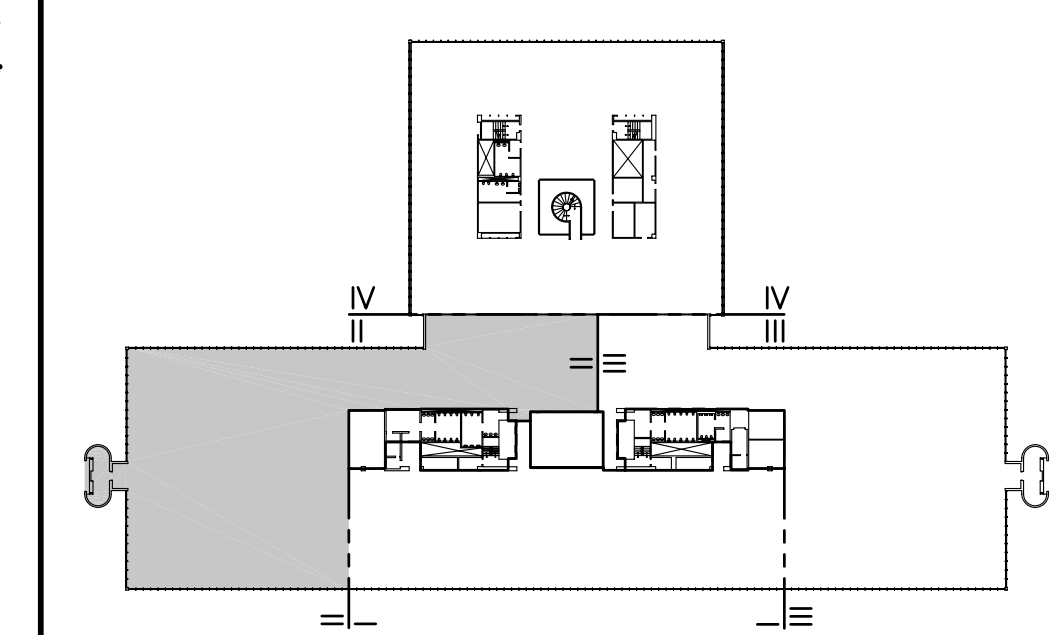


NOTE:

- SEE SHEET E-001 FOR LEGEND AND GENERAL NOTES.
- SEE SHEET ED101 FOR LOCATION OF PANELBOARDS LL2W1, LL2W3 & LL2W5.

KEYED NOTE:

- PROVIDE DOUBLE GANG BOX AND WHIP FOR MODULAR FURNITURE FEED. WIRING TO BE 2 #12 AWG #12 GND.

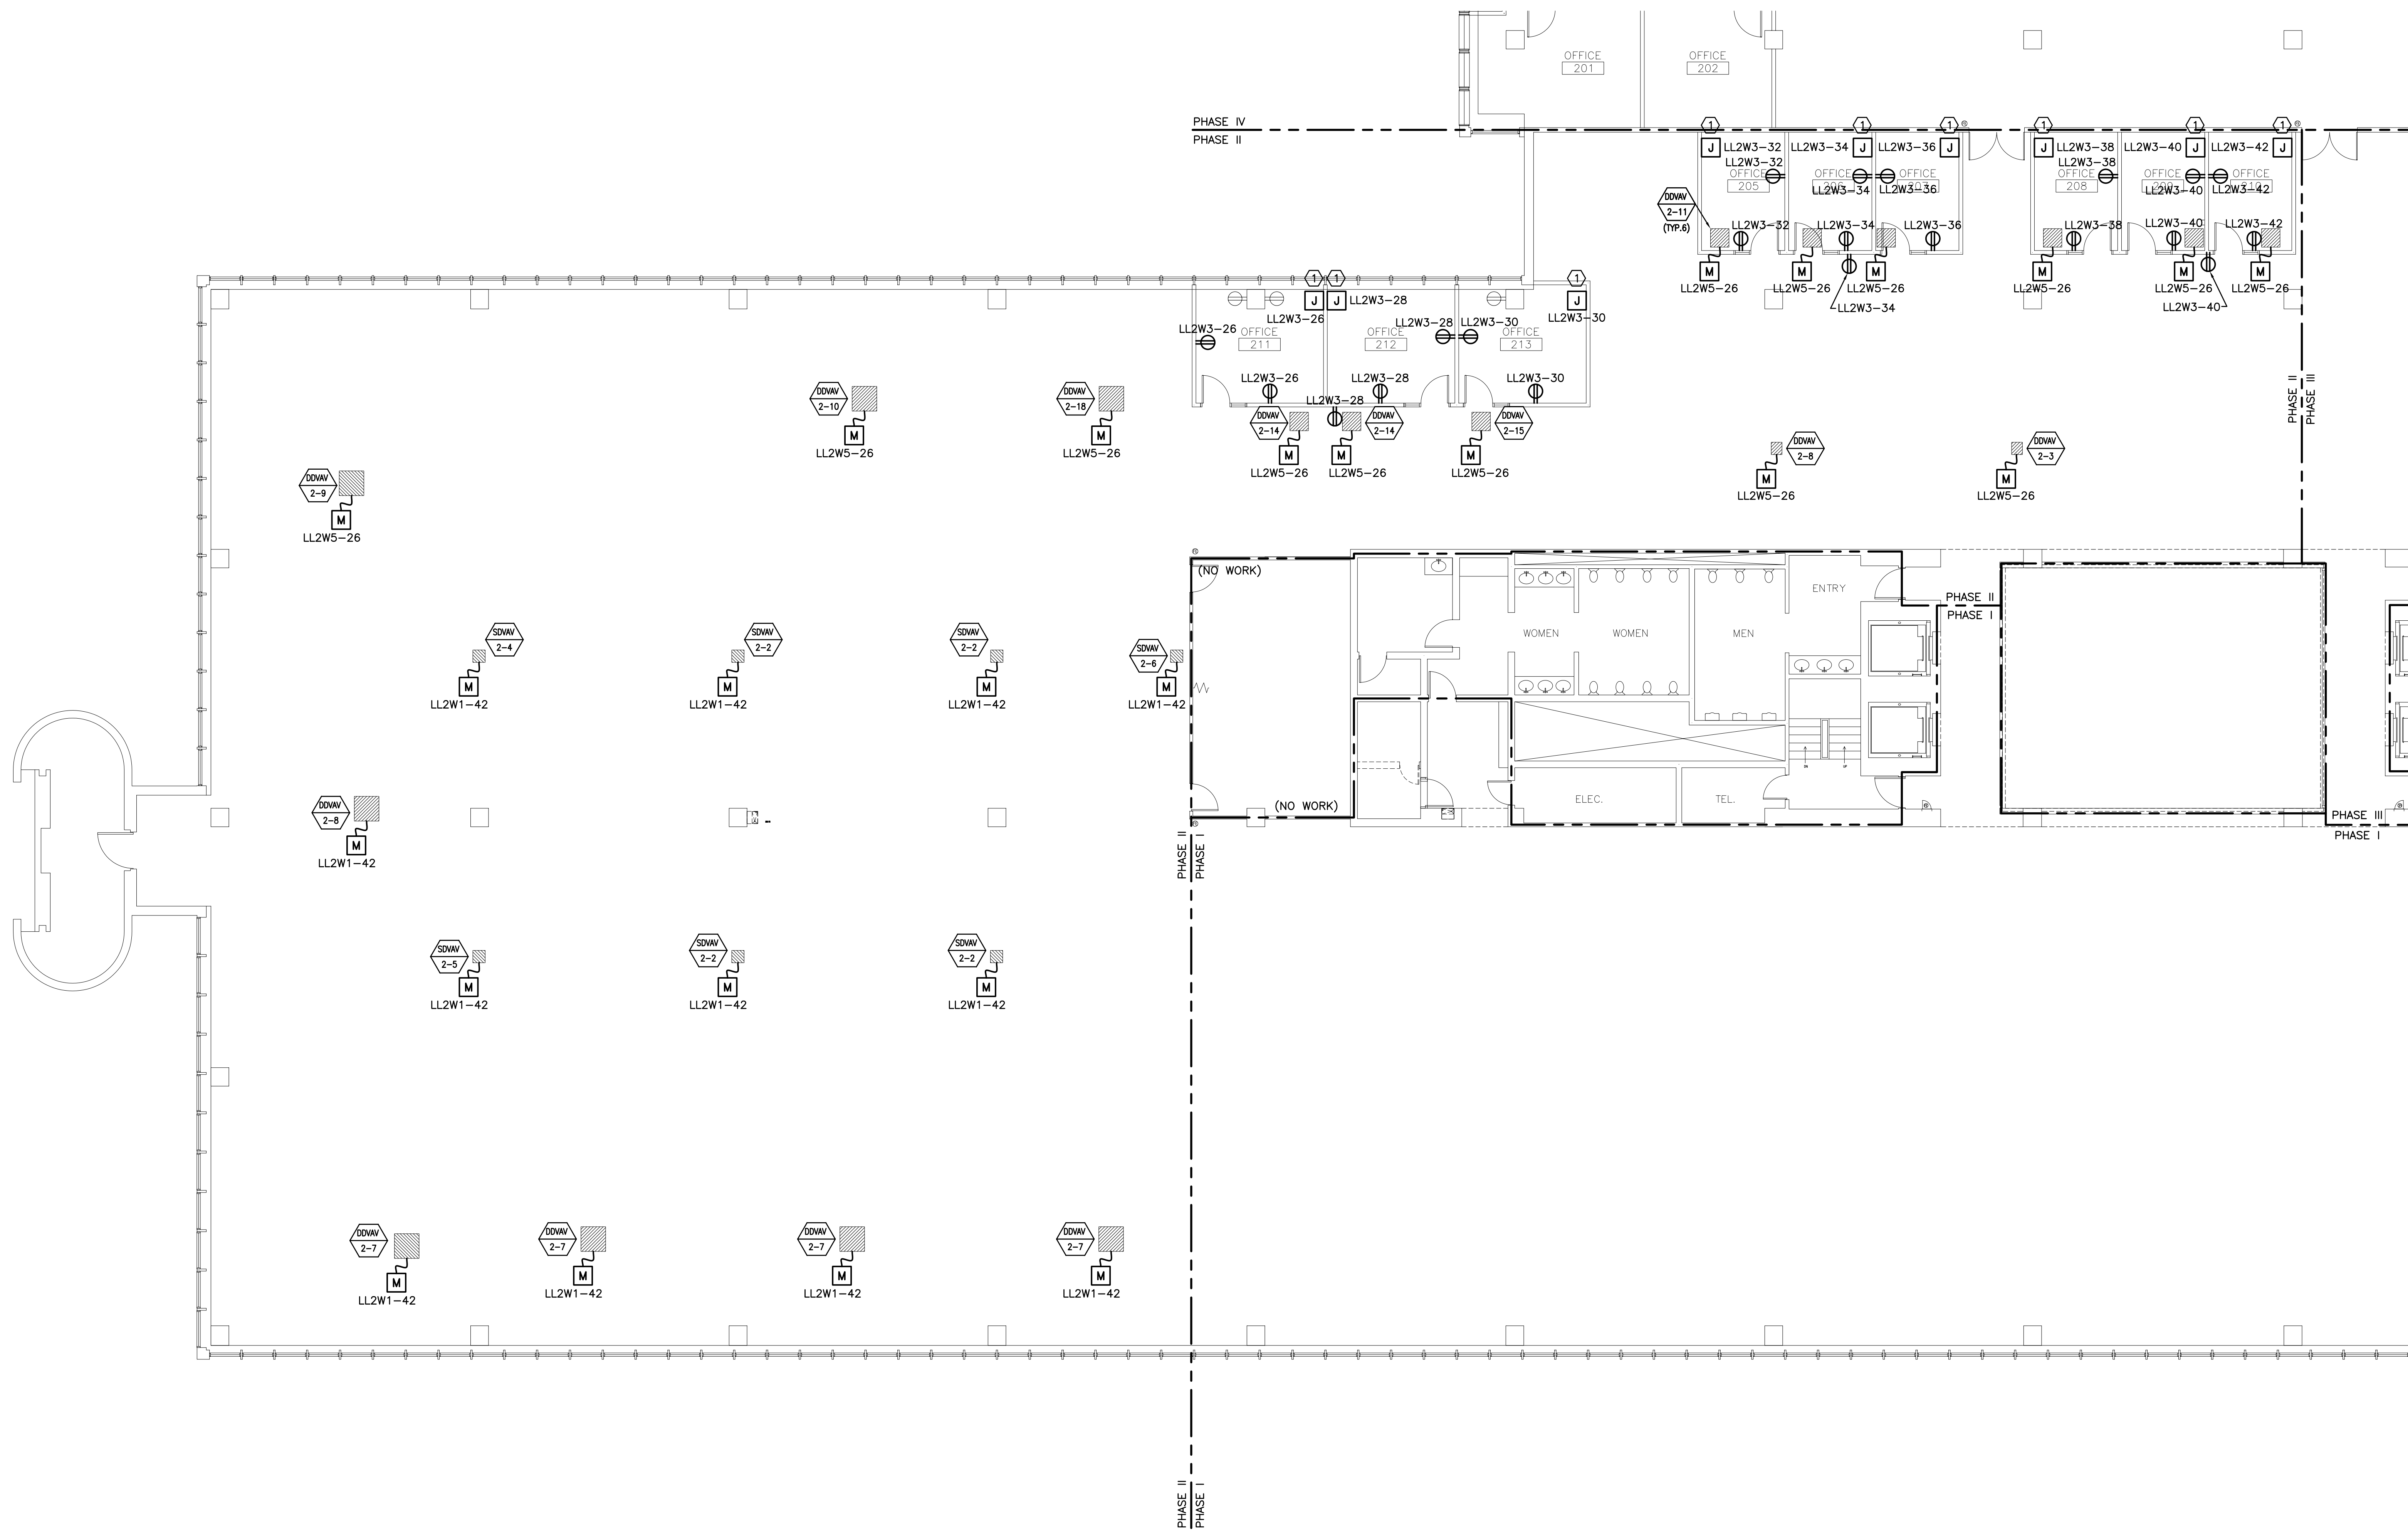

F18 KEY PLAN

NOT TO SCALE	
0	ISSUED FOR CONSTRUCTION
REV.	DESCRIPTION
	DATE

ISSUED FOR CONSTRUCTION 1-28-04

CURRENT ISSUE STATUS:

PROJECT NORTH

SM RT ARCHITECTURE ENGINEERING PLANNING

SMRT
144 Fore Street, P.O. Box 618
Portland, Maine 04104
tel. (207) 772-3846
fax. (207) 772-1070

**UNIMPROVIDENT HO-1
2nd FLOOR OFFICE RENOVATIONS
PORTLAND, ME.**

**PHASE II
POWER PLAN**

SHEET TITLE:	1-28-04
SCALE: 1/8"=1'-0"	DATE:
PROJECT MANAGER: JLH	GRAPHIC SCALE: 0" 1"
JOB CAP/DRAWN: CEB/BGG	
A/E OF RECORD: DJT	SHEET No.
SMRT CAD FILE: EP102-03100-01	EP102
PROJECT No. 03100-01	